


CONDUIT/CABLE SCHEDULE

- (A) (1) 2" CONDUIT WITH 4-*6, 1-*6 GND (2 LIGHTING CIRCUITS) AND 6-*8, 1-*8 GND (4 REC. CIRCUITS).
- (B) (1) 1 1/4" PVC CONDUIT WITH 2-*10, 1-*10 GND (1 LIGHTING CIRCUIT) AND 2*10, 1-*10 GND (1 REC. CIRCUITS).
- (C) (1) 2" CONDUIT WITH 4-*6, 1-*6 GND (2 LIGHTING CIRCUITS), 3-*8 (REC. CIRCUITS 2 & 4), 3-*10 (REC. CIRCUITS 1 & 3), AND 1-*8 GND (TOTAL 4 REC. CIRCUITS).

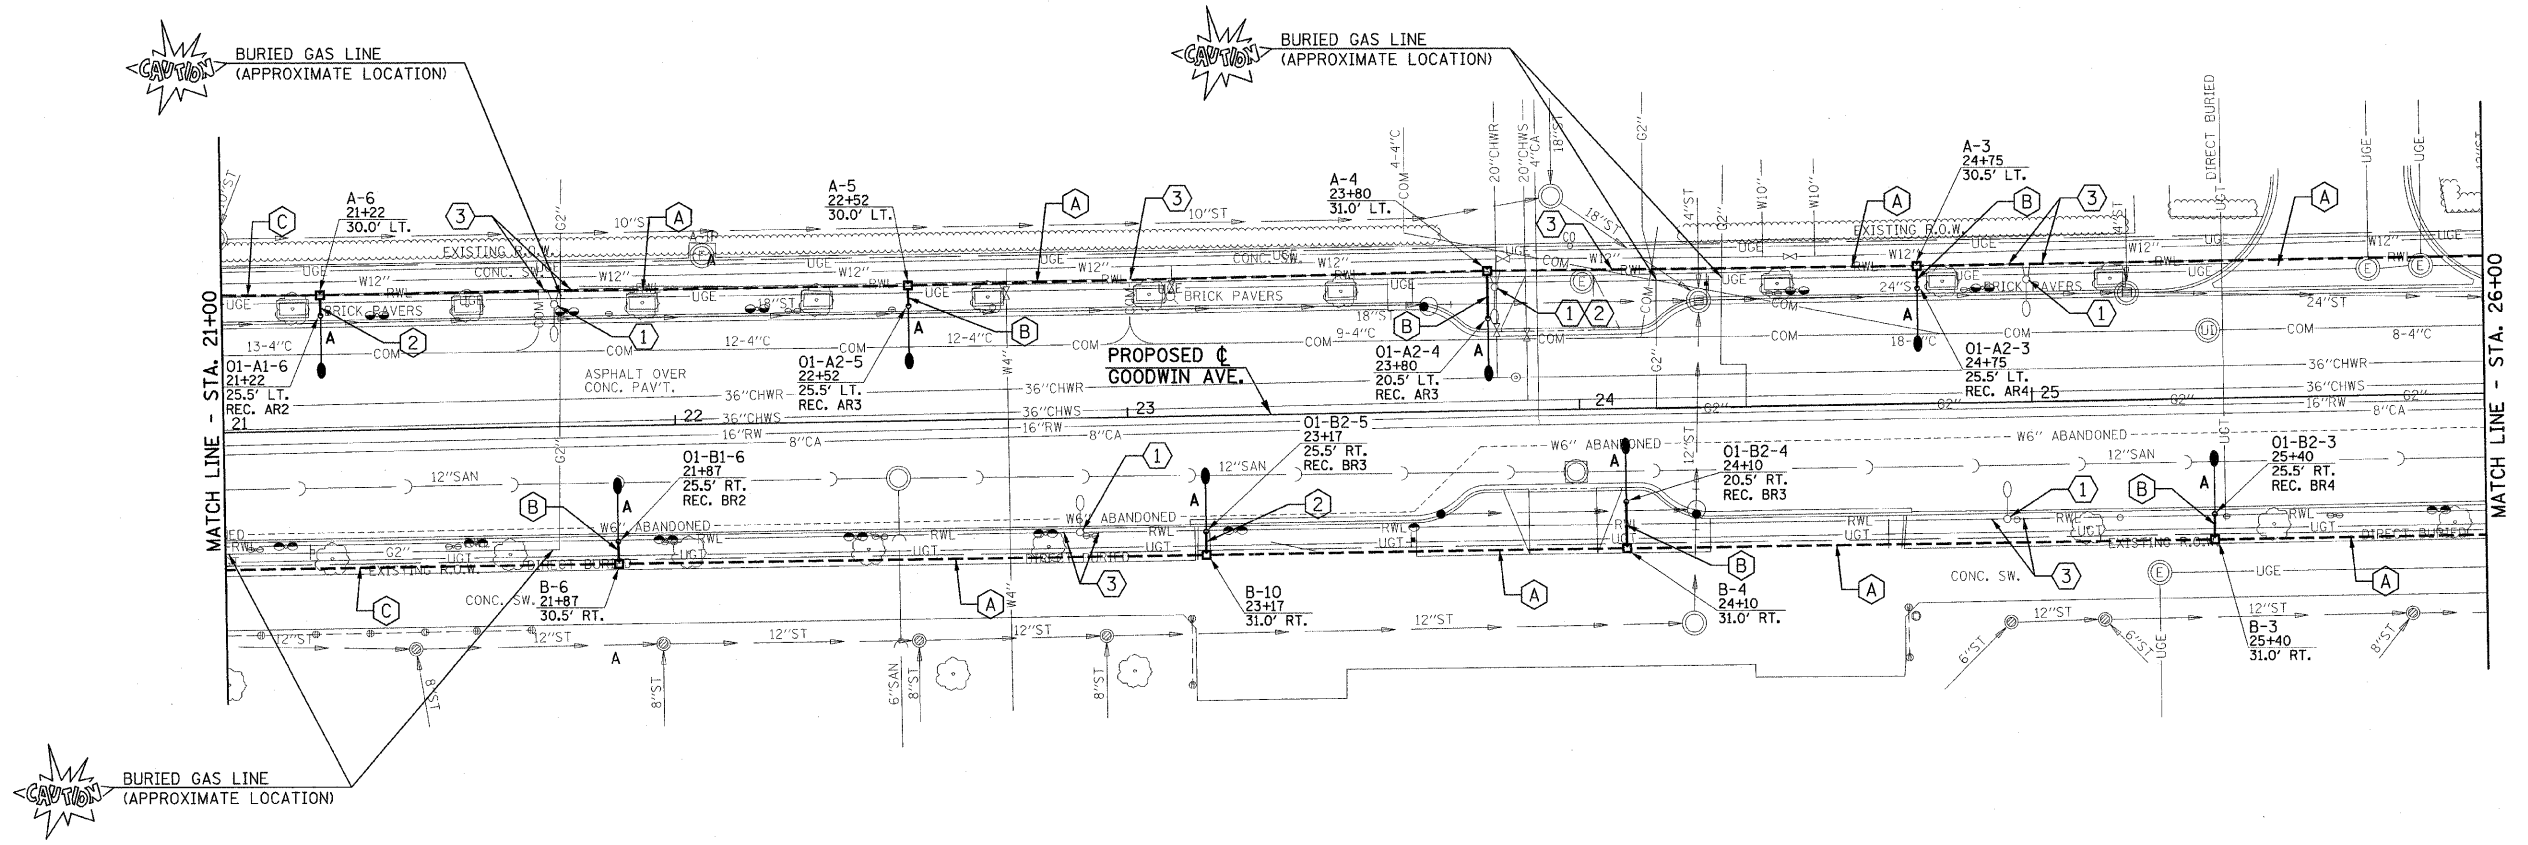

KEYED NOTES

- (1) REMOVE EXISTING LIGHT POLE (NO SALVAGE) AND FOUNDATION PER SPECIAL PROVISIONS.
- (2) DO NOT DISTURB GROUND WITHIN 3' OF LOCATION OF PROPOSED LIGHT TO ALLOW FOR THE INSTALLATION OF POLE BASE IN UNDISTURBED SOIL.
- (3) ABANDON EXISTING CABLE IN CONDUIT. ANY ABANDONED CABLE AND CONDUIT THAT INTERFERES WITH THE PROPOSED IMPROVEMENTS SHALL BE REMOVED AT THE POINT OF CONFLICT, AND NO ADDITIONAL COMPENSATION WILL BE ALLOWED.

FILE NAME = P:\U0070052\Plans\sheet64-Lighting.dgn	DESIGNED - MTP	REVISED -	STATE OF ILLINOIS DEPARTMENT OF TRANSPORTATION	ROADWAY LIGHTING PLAN			F.A.U. RTE.	SECTION	COUNTY	TOTAL SHEETS	SHEET NO.
	DATE - 01-2009	DRAWN - RJS		REVISED -	SCALE: 1"=20'	SHEET NO. 66 OF 75 SHEETS	STA. 21+00 TO STA. 26+00	7175	07-00456-00-RS	CHAMPAIGN	75
PLOT DATE = 1/18/2009 10:45:11 AM	CHECKED - JJF	REVISED -					GOODWIN AVENUE		CONTRACT NO. 91392		
							FED. ROAD DIST. NO. ILLINOIS FED. AID PROJECT				