



Hanson Professional Services Inc.
500 N. 20th Street
Oak Brook, Illinois 60423
© Copyright Hanson Professional Services Inc. 2009

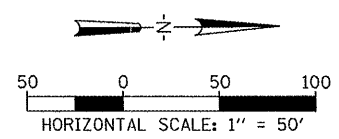

- LEGEND**
- RIPRAP
 - PROPOSED PIPE
 - PROPOSED FES
 - EXISTING FES

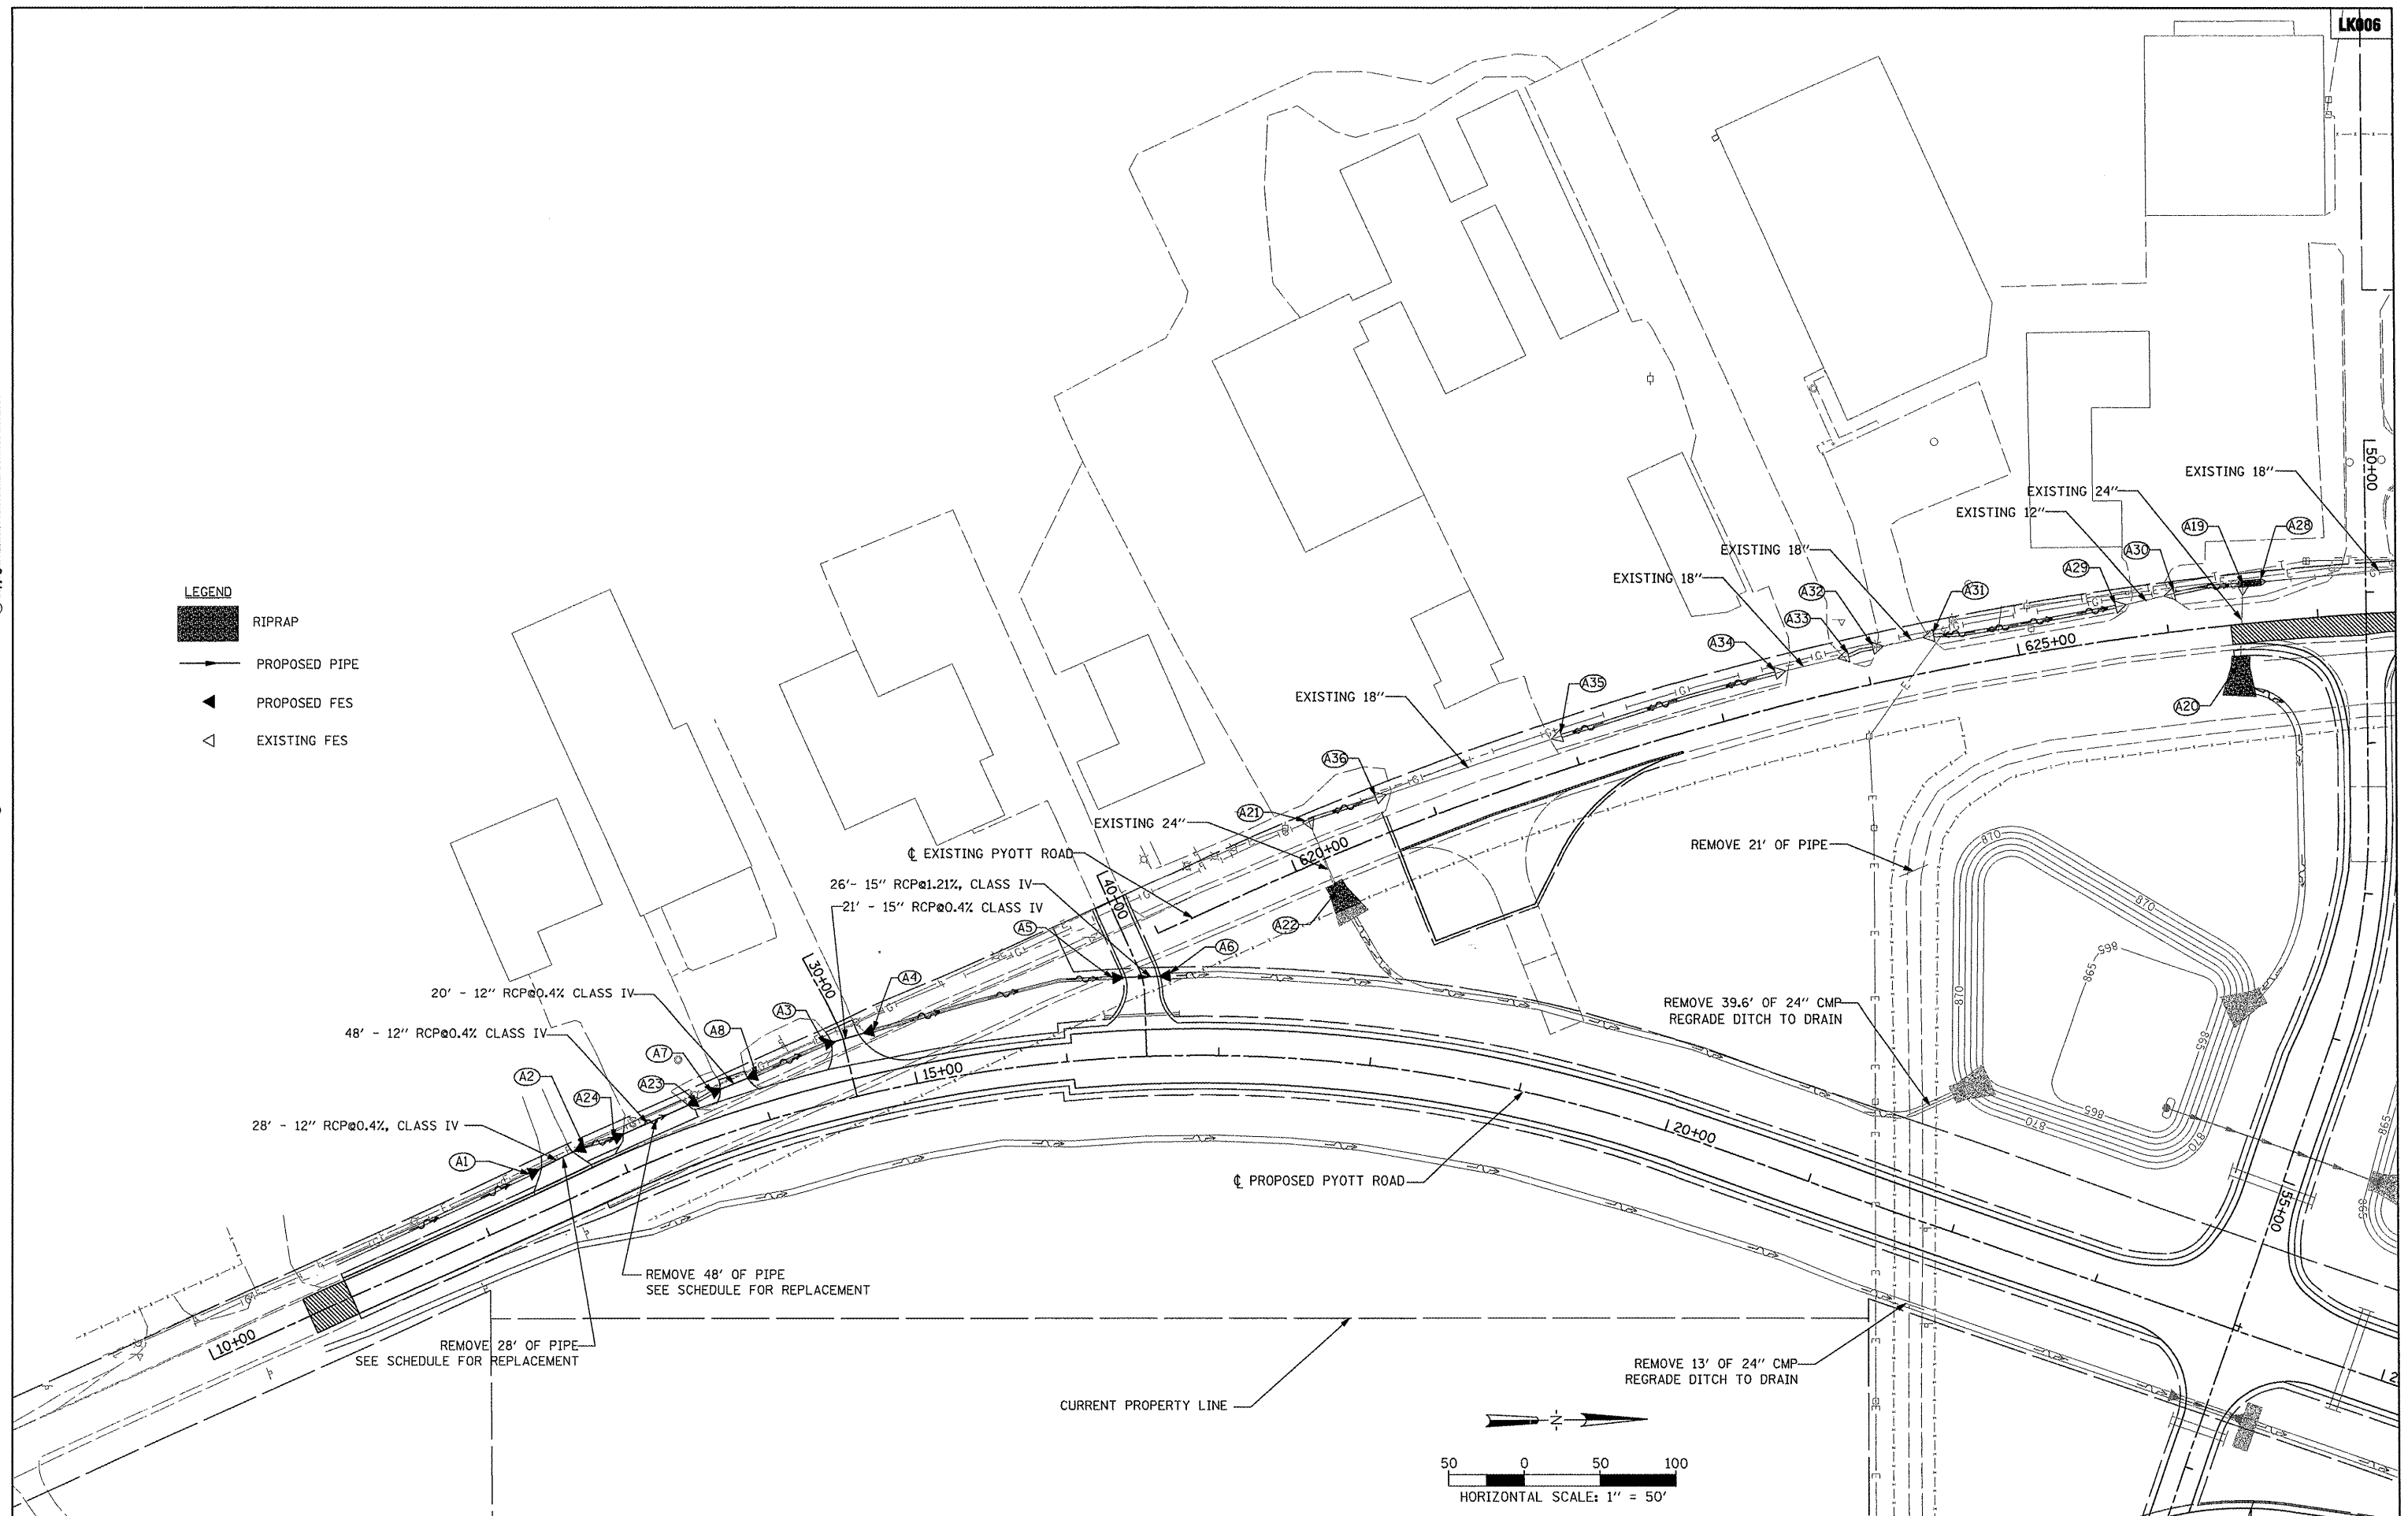

FILE NAME =	USER NAME = B10101219	DESIGNED - SJM	REVISED -
\\05jobs\00841\056021\civil part b\sheet\CC-DRNL.sht		DRAWN - SJM	REVISED -
	PLOT SCALE = 99.9998 ' / IN.	CHECKED - BLB	REVISED -
	PLOT DATE = 02/25/2009, 11:42 AM	DATE - 05/21/08	REVISED -

**VILLAGE OF
LAKE IN THE HILLS, ILLINOIS**

PYOTT ROAD DRAINAGE PLAN

COUNTY	TOTAL SHEETS	SHEET NO.
MCHENRY	143	43

AIP NO. 3-17-012-B10 ILLINOIS IDA NO. 3CK-3807