



F.A. RTE.	SECTION	COUNTY	TOTAL SHEETS	SHEET NO.
374	32687-R-1	COOK	279	215
STA.		TO STA.		
FED. ROAD DIST. NO.		ILLINOIS FED. AID PROJECT		

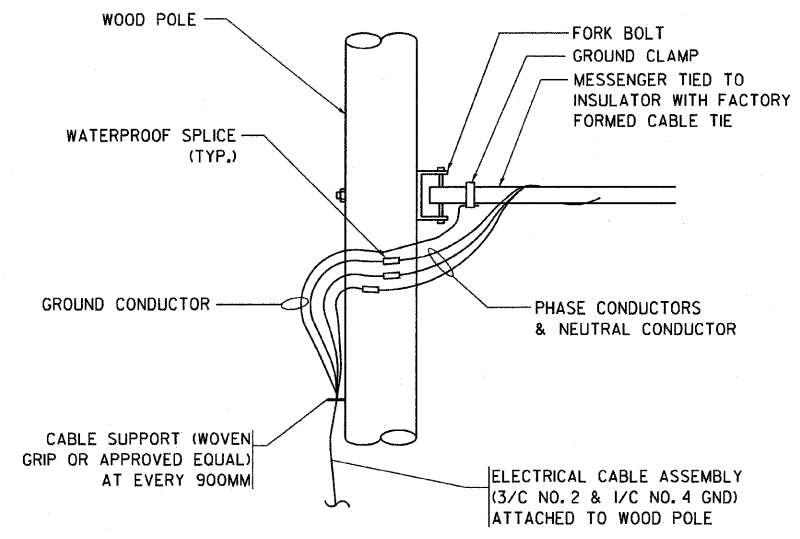


**AERIAL CABLE CONNECTION DETAIL**  
N.T.S.

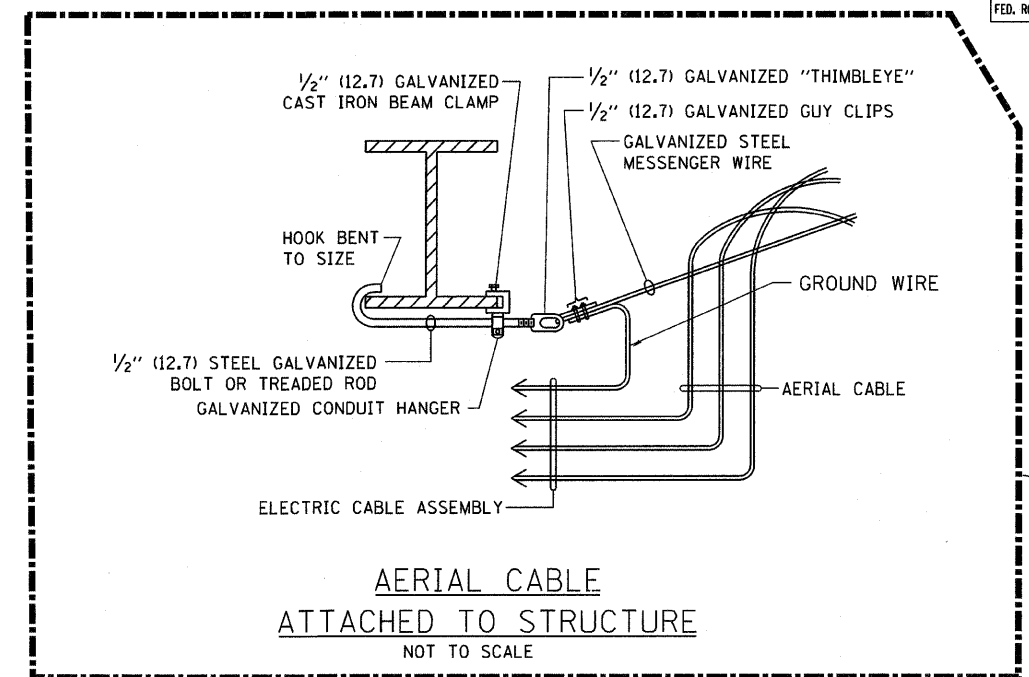

**AERIAL CABLE ATTACHED TO STRUCTURE**  
NOT TO SCALE

NOT USED FOR THIS PROJECT

- NOTES:**
1. ALL DIMENSIONS IN INCHES (MILLIMETERS) UNLESS OTHERWISE INDICATED.
  2. SEE PROPOSED LIGHTING PLAN FOR CONDUIT, CABLE AND ROUTING.
  3. THE CONTRACTOR SHALL PROVIDE INTERMEDIATE SUPPORTS TO MAINTAIN MINIMUM CLEARANCES. REFER TO AERIAL AERIAL CABLE ATTACHED TO STRUCTURE DETAIL.
  4. COST OF SPLICES AND MOUNTING HARDWARE SHALL BE INCLUDED IN THE UNIT PRICE FOR AERIAL CABLE.

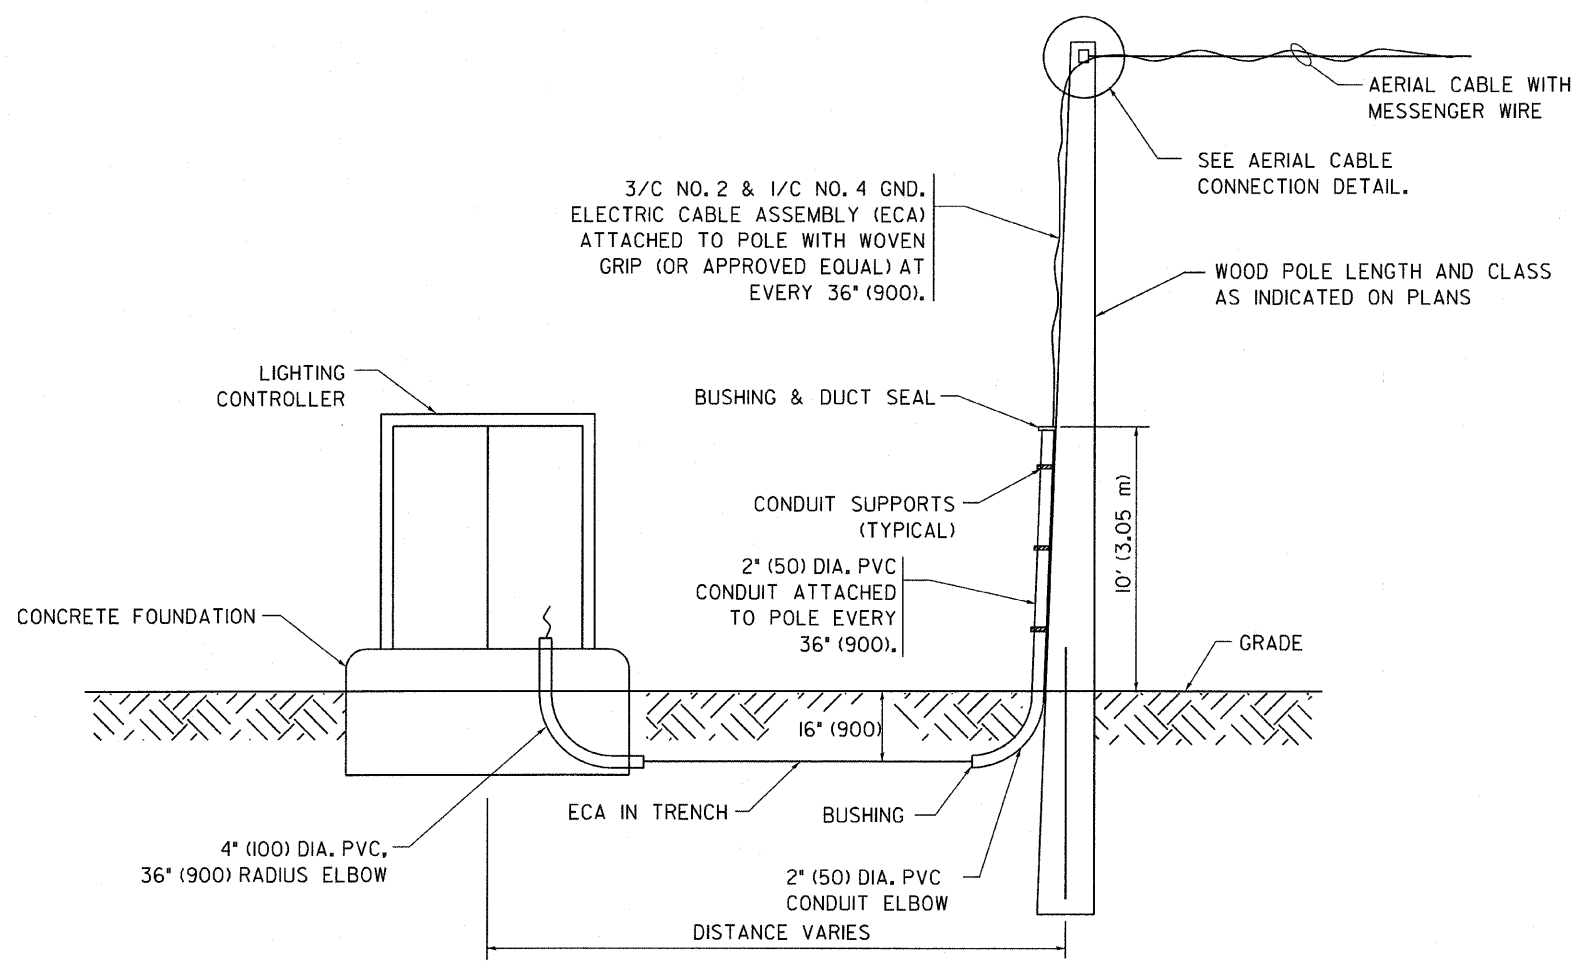

**WOOD POLE TO LIGHTING CONTROLLER WIRING CONNECTION DETAIL**  
N.T.S.

REVISIONS		ILLINOIS DEPARTMENT OF TRANSPORTATION
NAME	DATE	
		TEMPORARY AERIAL CABLE INSTALLATION

SCALE: VERT. DATE: 1/17/2007  
DRAWN BY: BE-801  
CHECKED BY: BE-801  
REVISION DATE: 01/01/07

PLOT DATE = 1/17/2007  
FILE NAME = c:\p01\p01\p01\p01\p01.dgn  
PLOT SCALE = 50.000' / IN.  
USER NAME = jtrahk