


F.A.U. NO.	SECTION	COUNTY	TOTAL SHEETS	SHEET NO.
2744	06-00183-00-CH	COOK	73	24
STA.	TO STA.			
FED. ROAD DIST. NO.	ILLINOIS	FED. AID PROJECT		
CONTRACT NO. 83999				

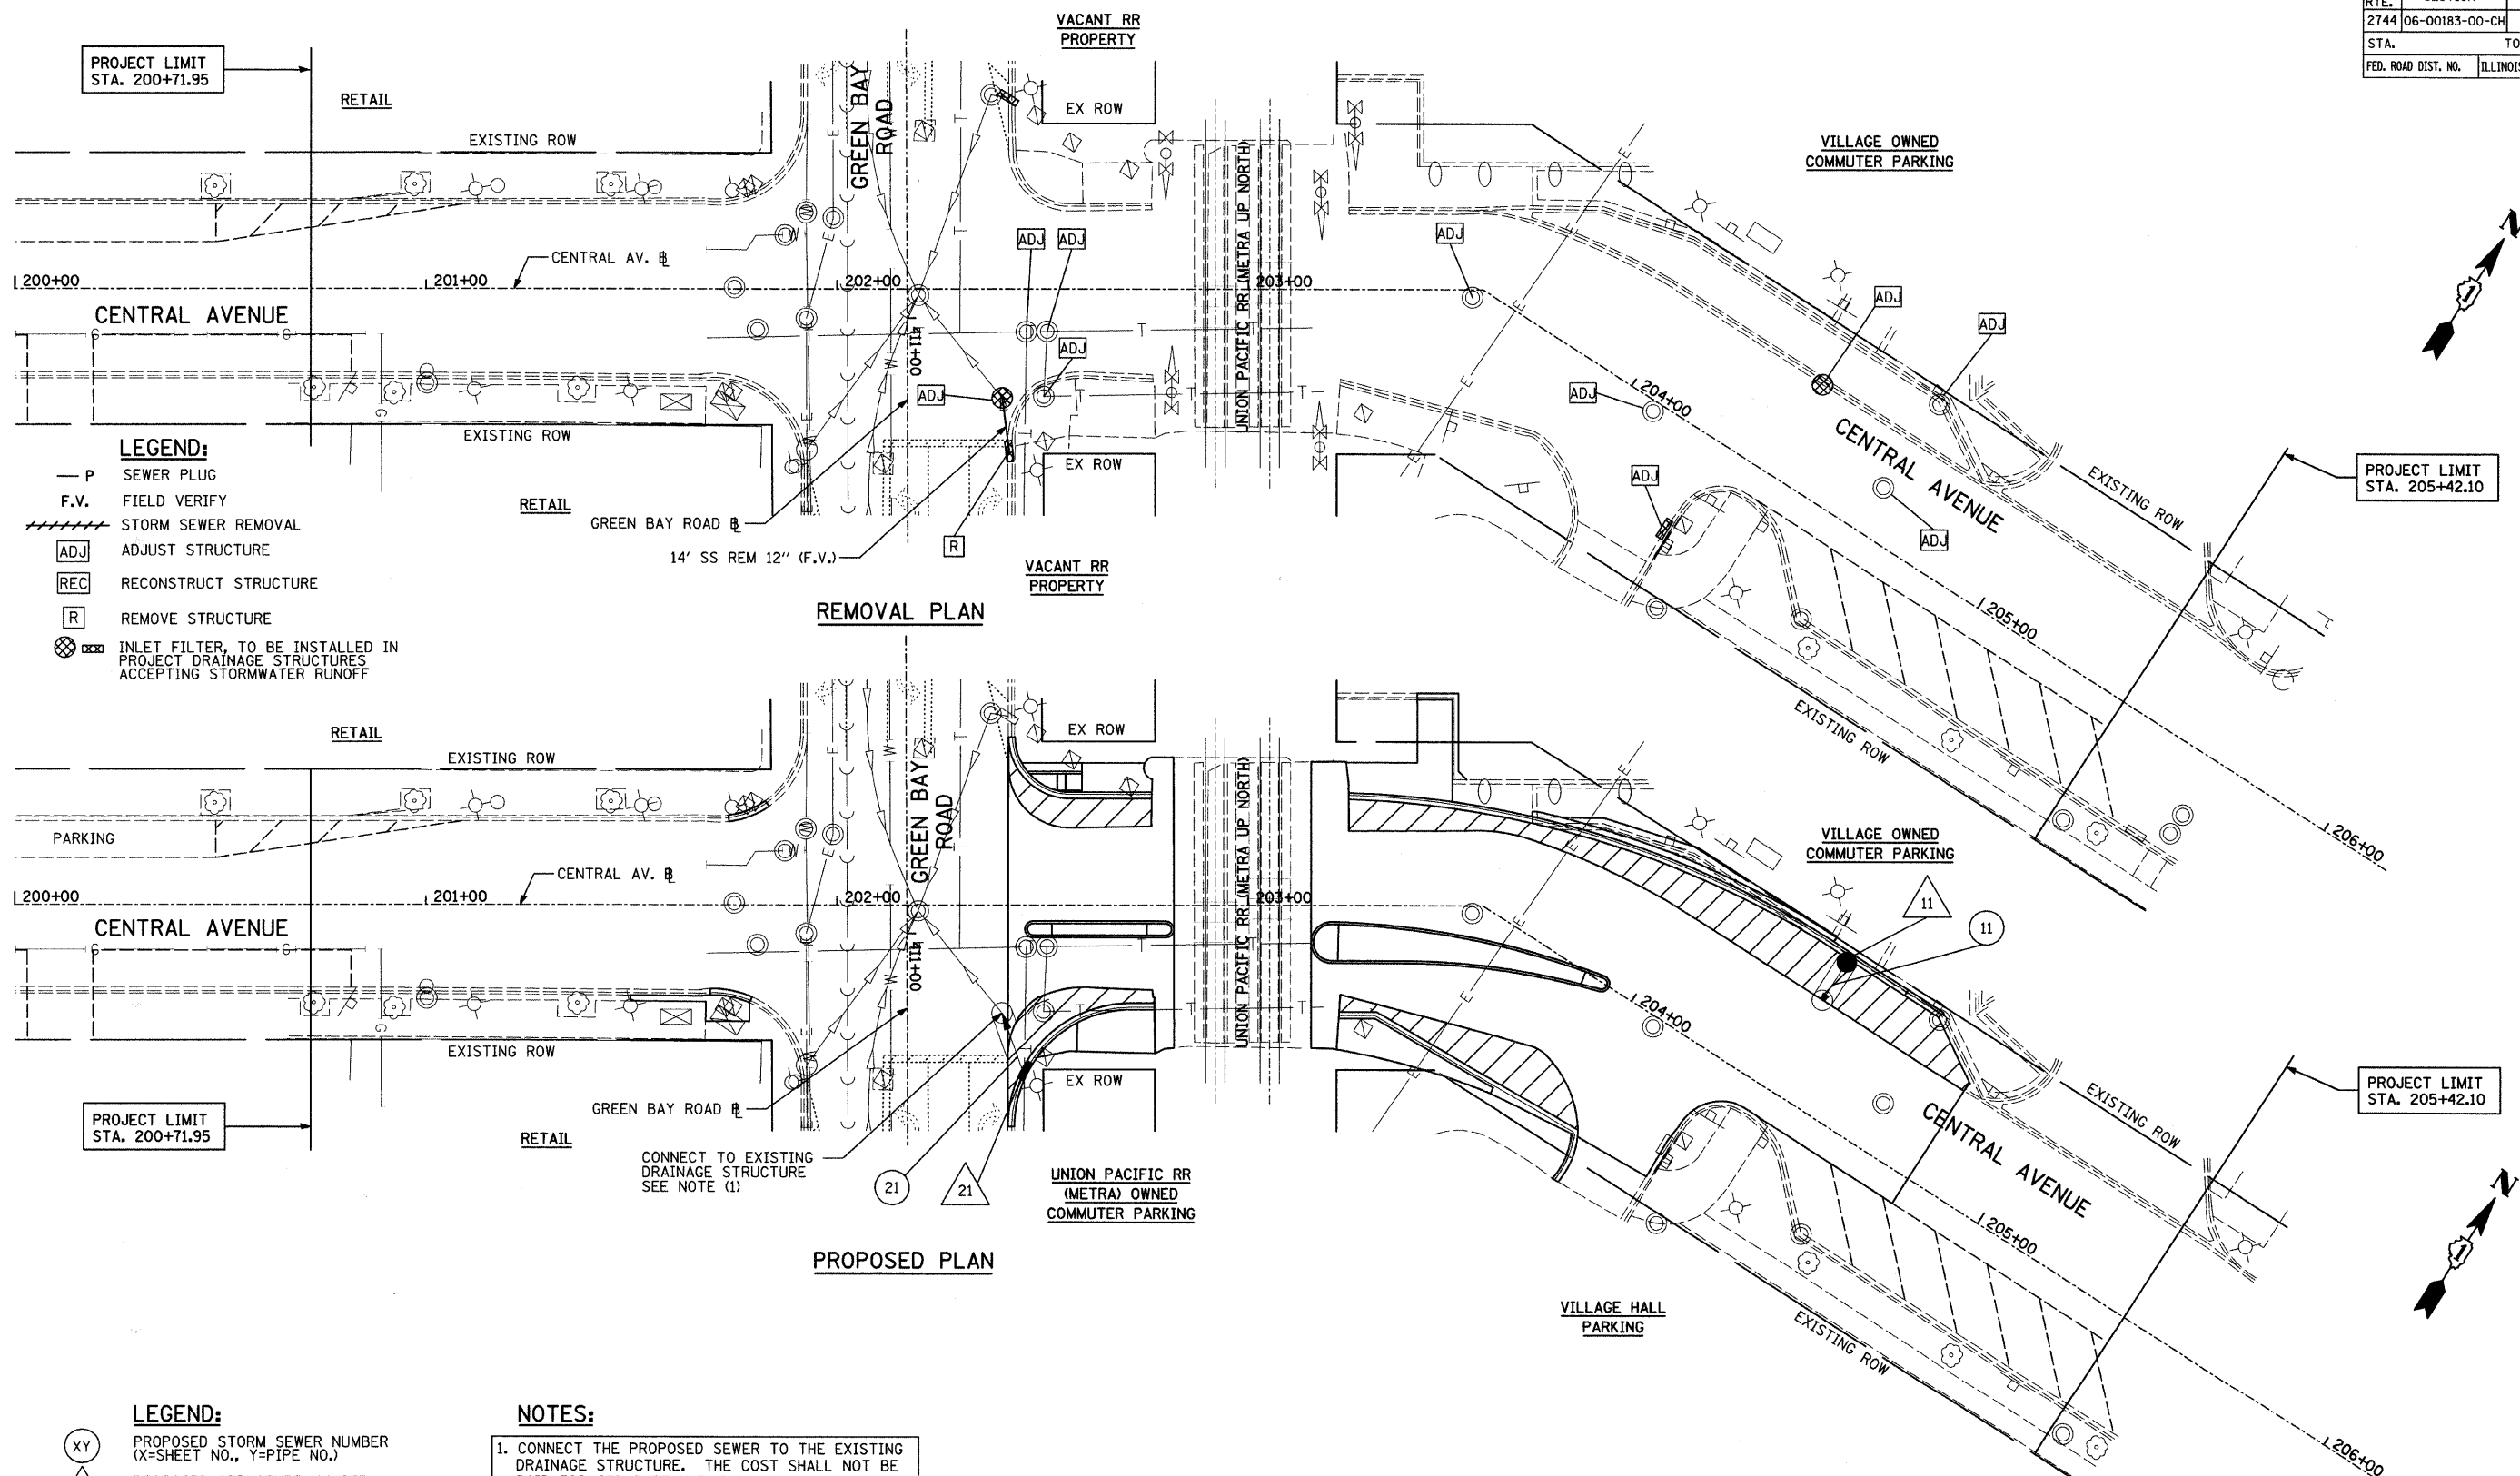

**LEGEND:**

- P SEWER PLUG
- F.V. FIELD VERIFY
- STORM SEWER REMOVAL
- ADJUST STRUCTURE
- RECONSTRUCT STRUCTURE
- REMOVE STRUCTURE
- INLET FILTER, TO BE INSTALLED IN PROJECT DRAINAGE STRUCTURES ACCEPTING STORMWATER RUNOFF

**REMOVAL PLAN**

 
**PROPOSED PLAN**

**LEGEND:**

- PROPOSED STORM SEWER NUMBER (X=SHEET NO., Y=PIPE NO.)
- PROPOSED STRUCTURE NUMBER (X=SHEET NO., Y=STRUCTURE NO.)

**NOTES:**

1. CONNECT THE PROPOSED SEWER TO THE EXISTING DRAINAGE STRUCTURE. THE COST SHALL NOT BE PAID FOR SEPARATELY BUT INCLUDED IN COST OF SEWER INSTALLATION OF THE SIZE AND TYPE SHOWN ON PLANS.



REVISIONS	
NAME	DATE

**DRAINAGE AND UTILITY PLAN**

CENTRAL AVENUE AT GREEN BAY ROAD

CONSULTANT  
**TYLIN INTERNATIONAL**

VILLAGE OF WILMETTE  
GREEN BAY ROAD  
INTERSECTION IMPROVEMENTS

DRAWN: \_\_\_\_\_ SHEET NO. \_\_\_\_\_  
 CHECKED: \_\_\_\_\_  
 APPROVED: \_\_\_\_\_  
 DATE: 02-14-2008  
 SCALE: 1"=20'-0"  
 JOB NO.: \_\_\_\_\_ PROJECT NO.: \_\_\_\_\_

DATE	
BY	
REVISIONS	
NOTED	
ALIGNED	
CHECKED	
CADD FILE NAME	
PLAN	
NOTE BOOK	
NO.	

DATE	
BY	
REVISIONS	
NOTED	
ALIGNED	
CHECKED	
CADD FILE NAME	
PROFILE	
NOTE BOOK	
NO.	