
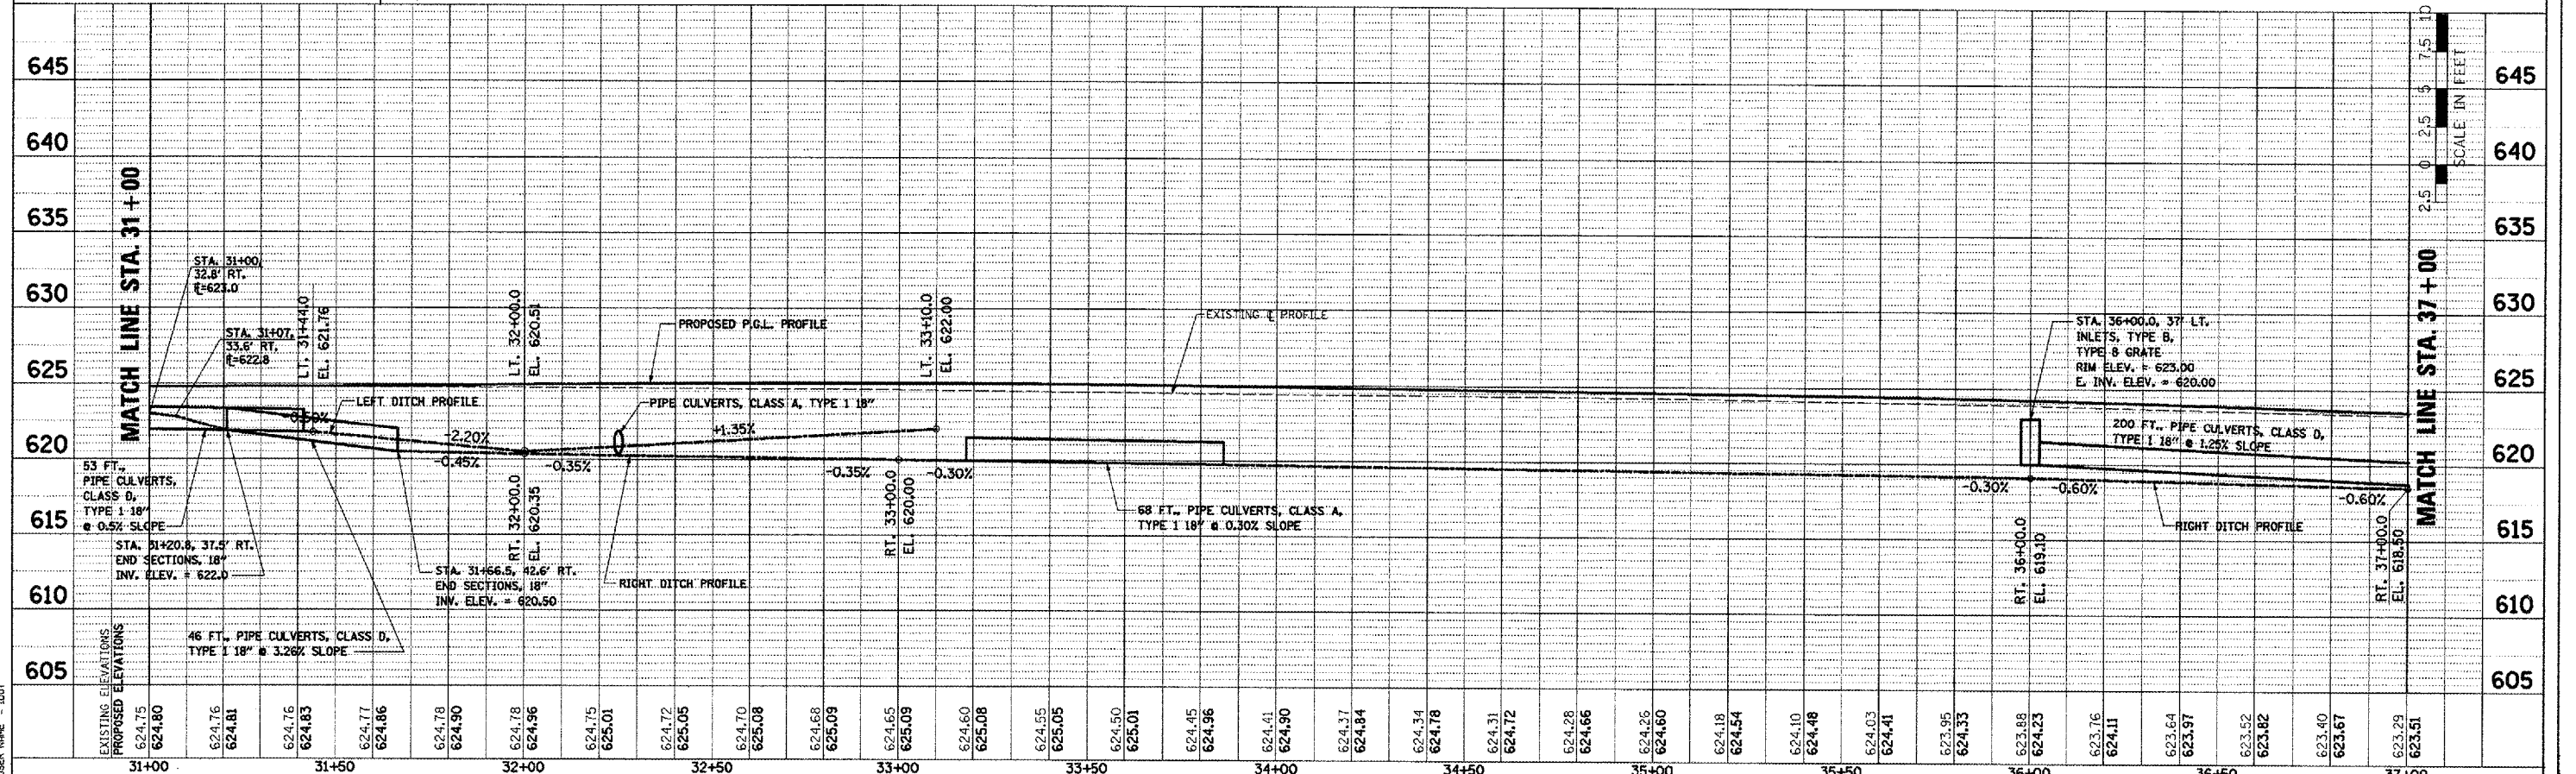


F.A.U. RTE.	SECTION	COUNTY	TOTAL SHEETS	SHEET NO.
6761	04-00057-06-WR	TAZEWELL	154	76
STA. 31+00		TO STA. 37+00		
FED. ROAD DIST. NO. 4 ILLINOIS FED. AID PROJECT				

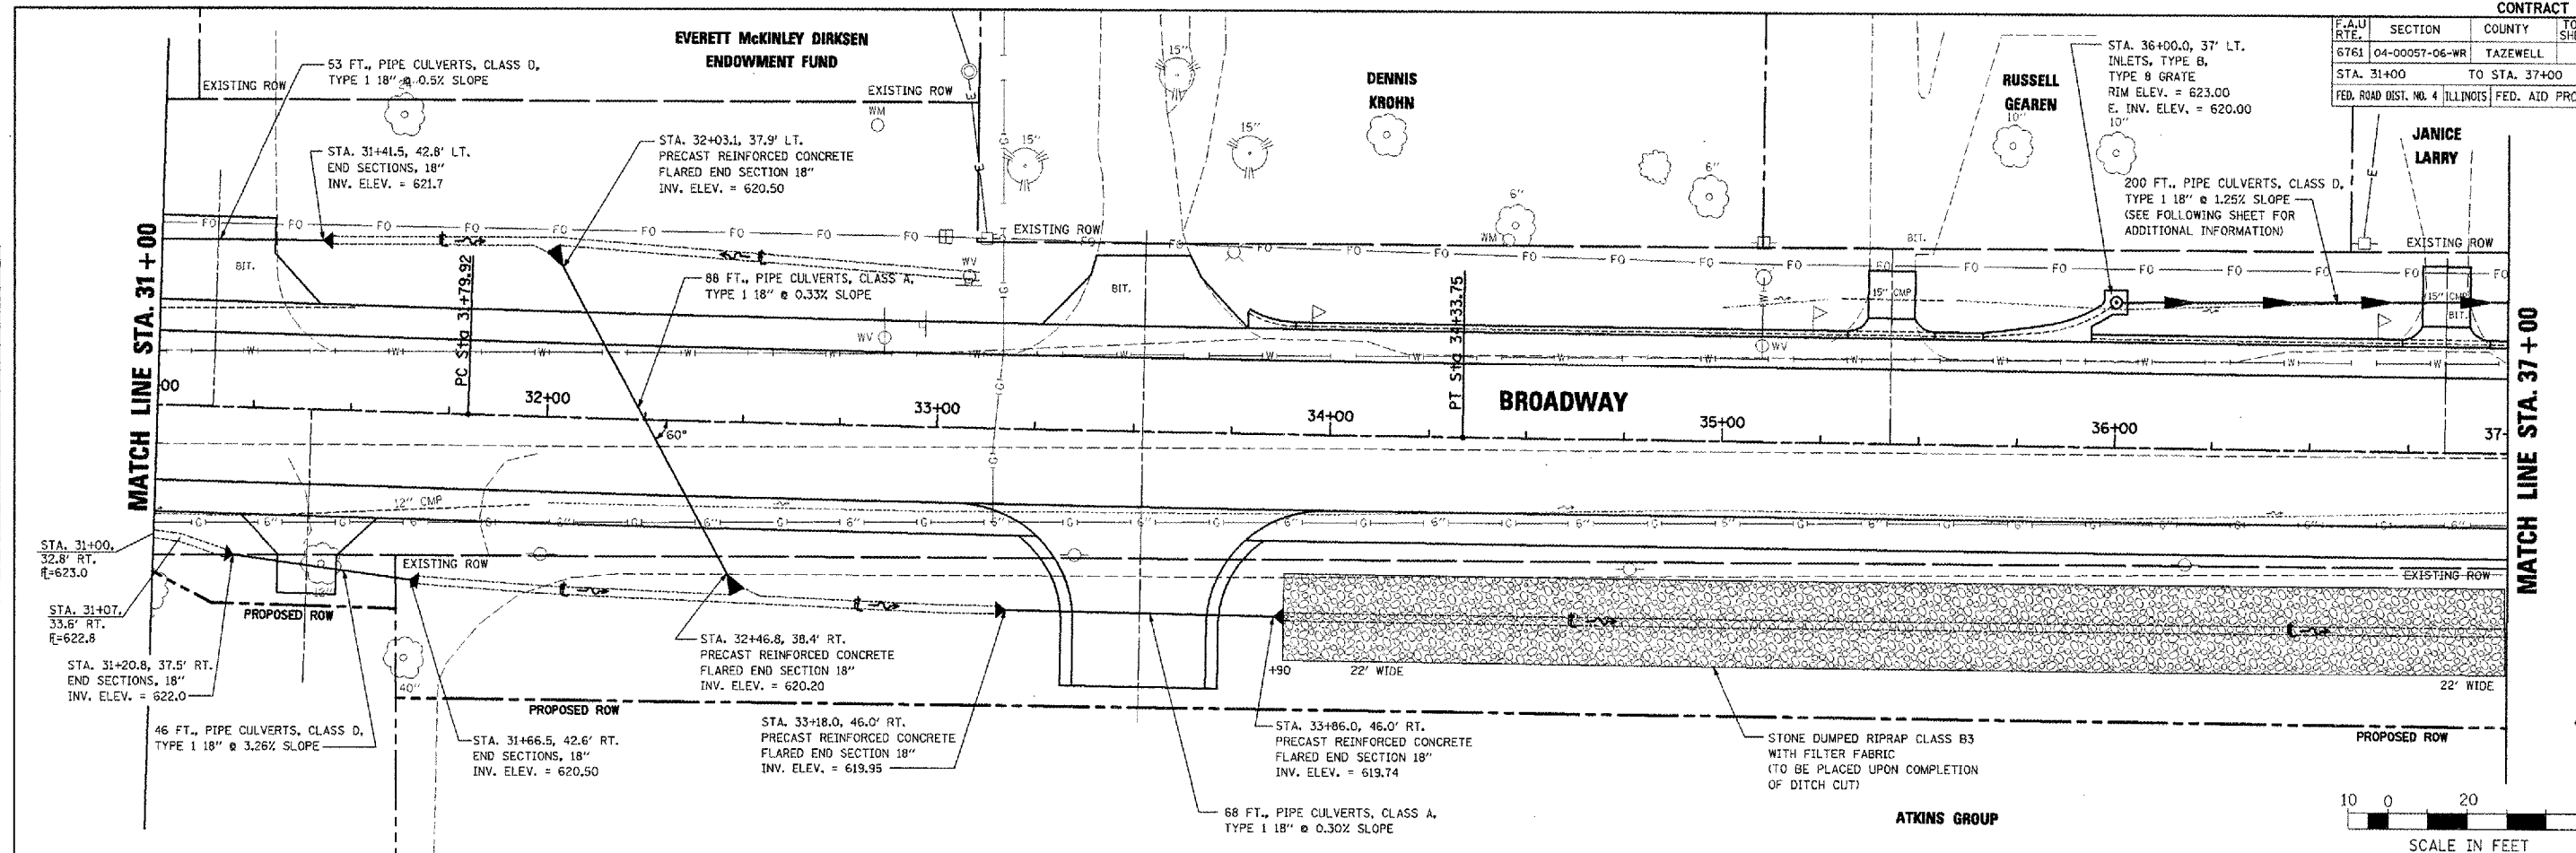

BROADWAY - DRAINAGE PLAN AND PROFILE - STA. 31+00 TO STA. 37+00

DATE: _____

BY: _____

PROJECT: _____

NOTE BOOK: _____

NO. _____

FILE NAME: _____

DATE: _____

BY: _____

PROJECT: _____

NOTE BOOK: _____

NO. _____

FILE NAME: _____

PLOT DATE = 2/26/2008

DESIGNER = [unreadable]

PILOT SCALE = 30' = 1" / 1" = 30'

USER NAME = IDOT