



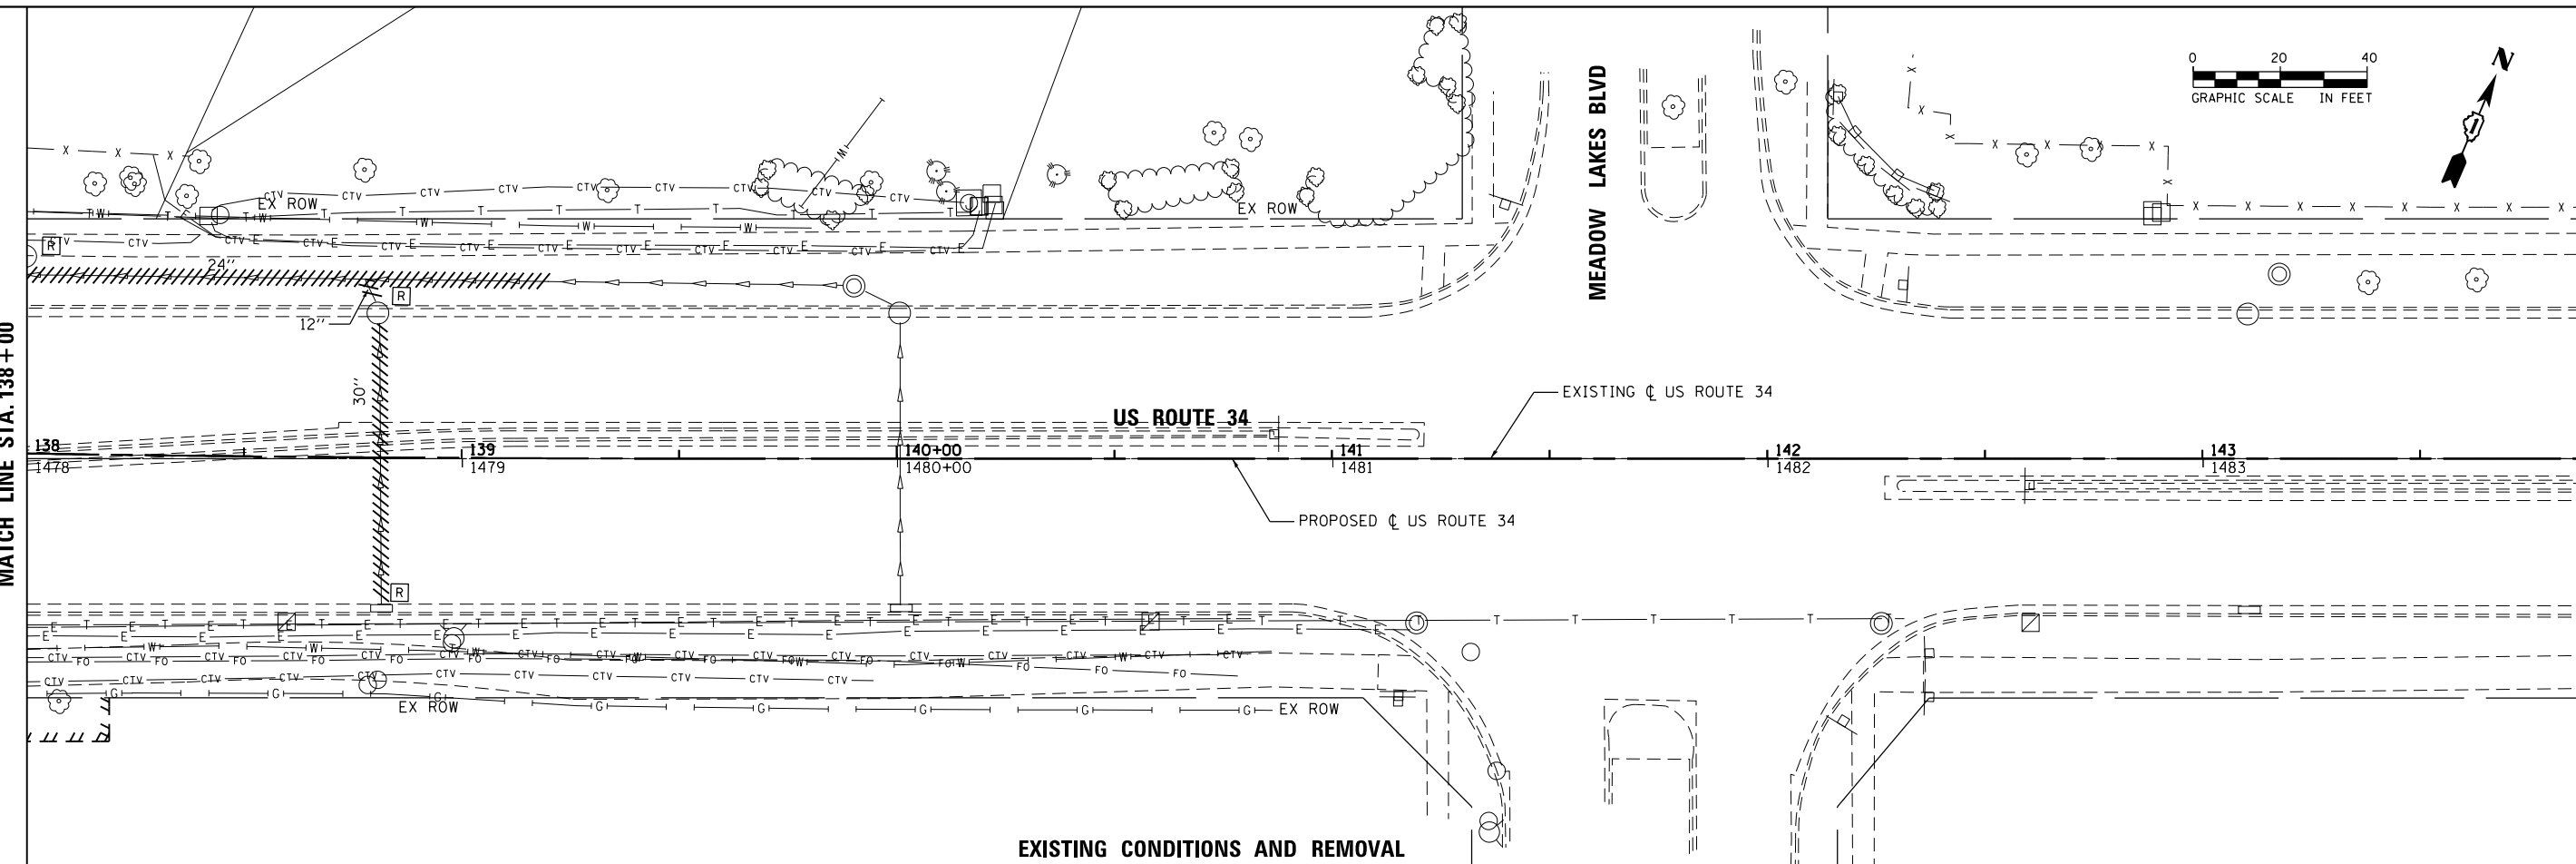

MATCH LINE STA. 138+00

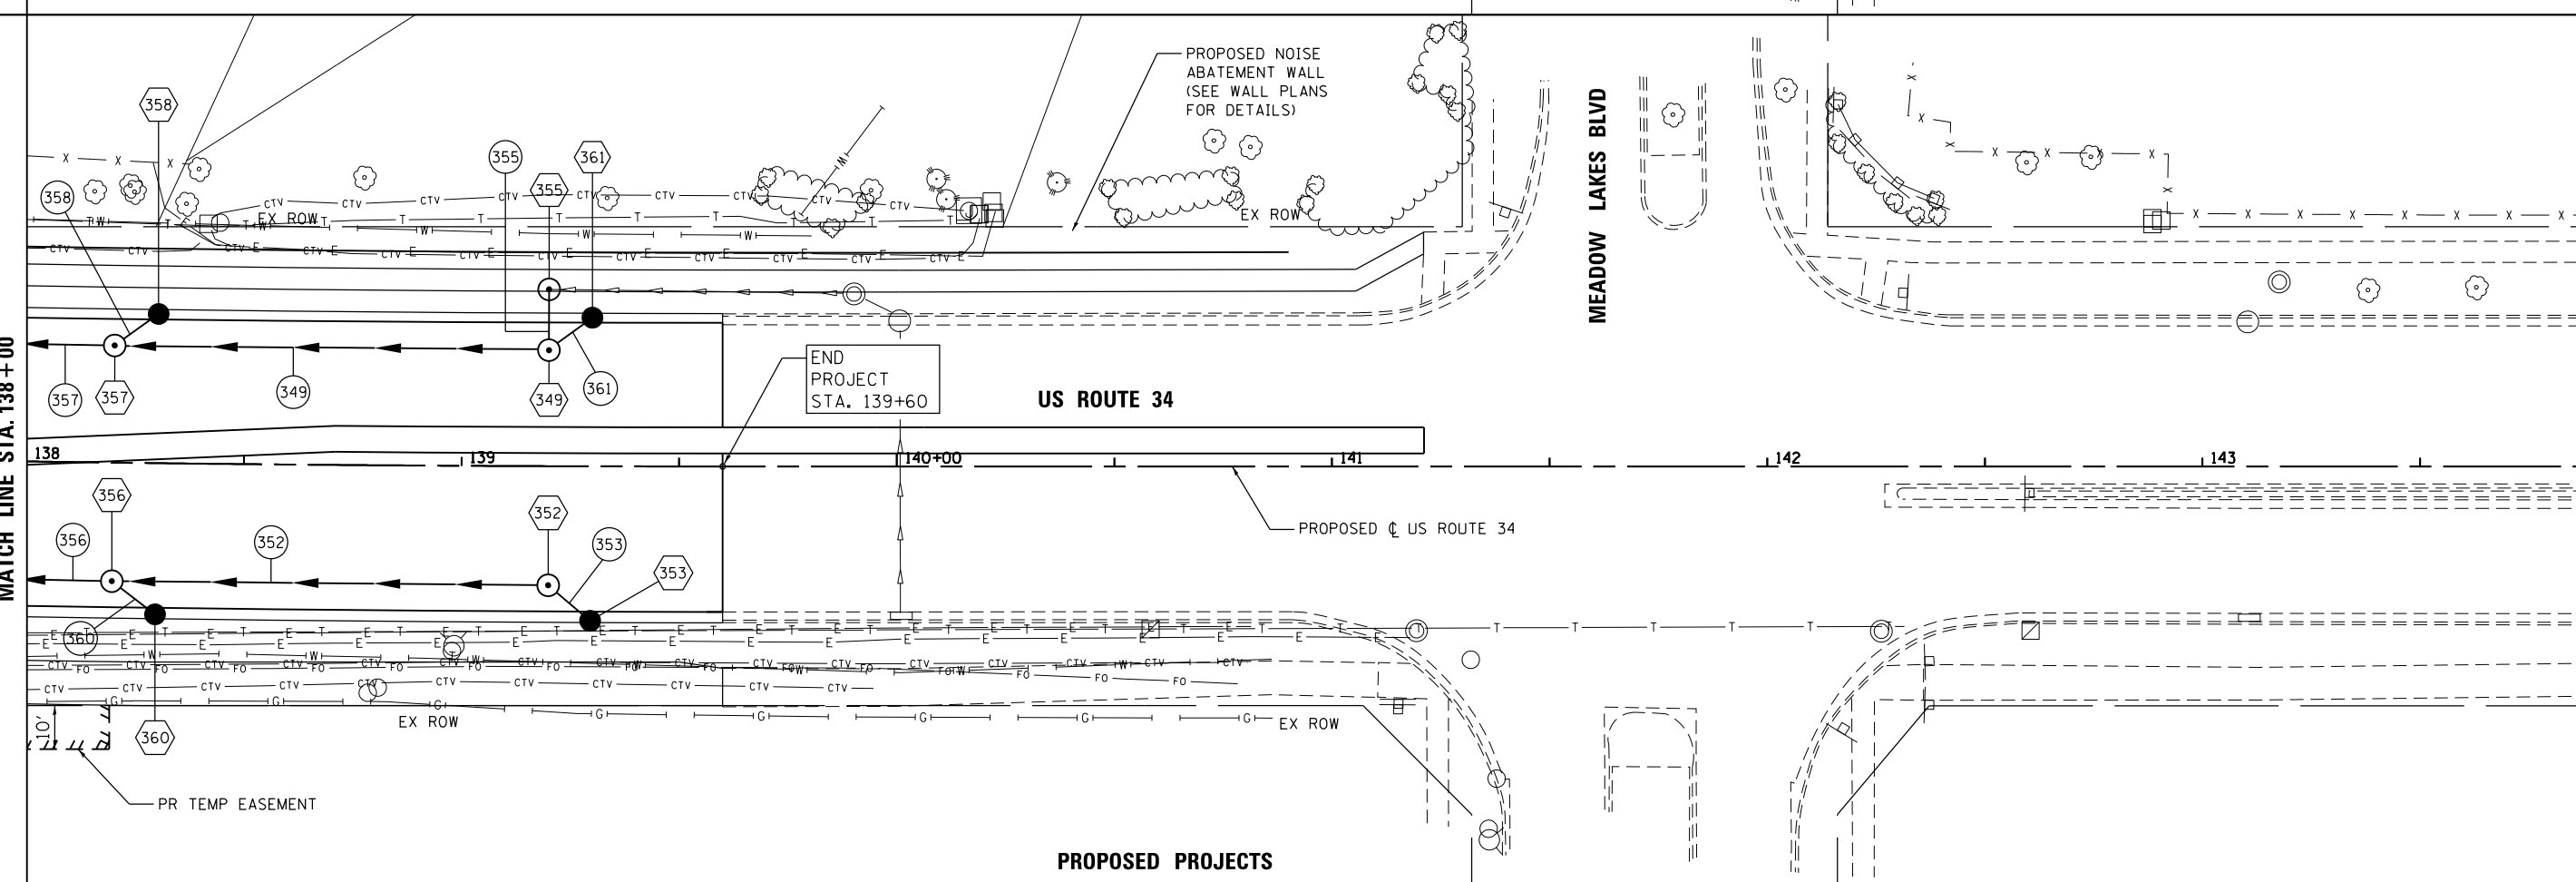

MATCH LINE STA. 138+00



FILE NAME = Q:\1\DOT\_25368367\_US\_34.ctb; CN: P:\2\Drawings\Roadway\Drainage\Utility\1616106-sht-D-um\_008.dgn



USER NAME = URS	DESIGNED - MB	REVISED -
PLOT SCALE = 48.0000' / in.	DRAWN - KJB	REVISED -
PLOT DATE = 02/28/2014	CHECKED - SPF	REVISED -
	DATE - 02/28/2014	REVISED -

STATE OF ILLINOIS  
DEPARTMENT OF TRANSPORTATION

DRAINAGE AND UTILITY PLAN  
US ROUTE 34

SCALE: 20 SHEET NO. 8 OF 8 SHEETS STA. 138+00 TO STA. 143+90

F.A.P. RTE.	SECTION	COUNTY	TOTAL SHEETS	SHEET NO.
311	652-A	DUPAGE	383	99
CONTRACT NO. 60R06				
FED. ROAD DIST. NO. 1 ILLINOIS FED. AID PROJECT				