

 


**NOTES**

1. PRIOR TO INSTALLING POST MOUNTED SIGNS, THE CONTRACTOR SHALL CONTACT J.U.L.I.E.
2. PORTABLE CHANGEABLE MESSAGE TO BE USED AT LOCATIONS AS DETERMINED BY THE ENGINEER.
3. ALL PAVEMENT MARKING USED FOR SUGGESTED STAGES OF CONSTRUCTION ARE TEMPORARY AND PER STANDARD SPECIFICATIONS FOR ROAD AND BRIDGE CONSTRUCTION, SECTION 703.
4. CONTRACTOR CANNOT EXCEED DROP OFFS OF 24 INCHES IN SELECT WORK ZONES FOR MORE THAN 48 HOURS.
5. SEE ROADWAY LIGHTING PLAN SHEETS FOR LIGHTING REMOVAL, TEMPORARY LIGHTING, AND INSTALLATIONS OF LIGHTING.

**LEGEND**

- WORK ZONE
- DIRECTION OF TRAFFIC
- TEMPORARY PLASTIC DRUMS WITH STEADY BURN MONO-DIRECTIONAL LIGHTS
- IMPACT ATTENUATOR, NON REDIRECTION TL3
- TRAFFIC SIGN
- TEMP. CONC. BARRIER W/ WALL MARKERS TYPE C @ 25 FT CTRS.
- TYPE III BARRICADE WITH FLASHING MONODIRECTIONAL LIGHTS

- 1 PAVEMENT MARKING TAPE, TYPE III - LINE 4" (SOLID WHITE)
- 2 PAVEMENT MARKING TAPE, TYPE III - LINE 5" (SKIP-DASH WHITE, 30' SKIP - 10' DASH)
- 3 PAVEMENT MARKING TAPE, TYPE III - LINE 4" (SOLID YELLOW)
- 4 PAVEMENT MARKING TAPE, TYPE III - LINE 24" (SOLID WHITE)
- 5 PAVEMENT MARKING TAPE, TYPE III - LETTERS AND SYMBOLS (SOLID WHITE)
- 6 PAVEMENT MARKING TAPE, TYPE III - LINE 12" (SOLID WHITE)
- 7 PAVEMENT MARKING TAPE, TYPE III - LINE 6" (SOLID WHITE)
- 8 PAVEMENT MARKING TAPE, TYPE III - LINE 8" (SOLID WHITE)

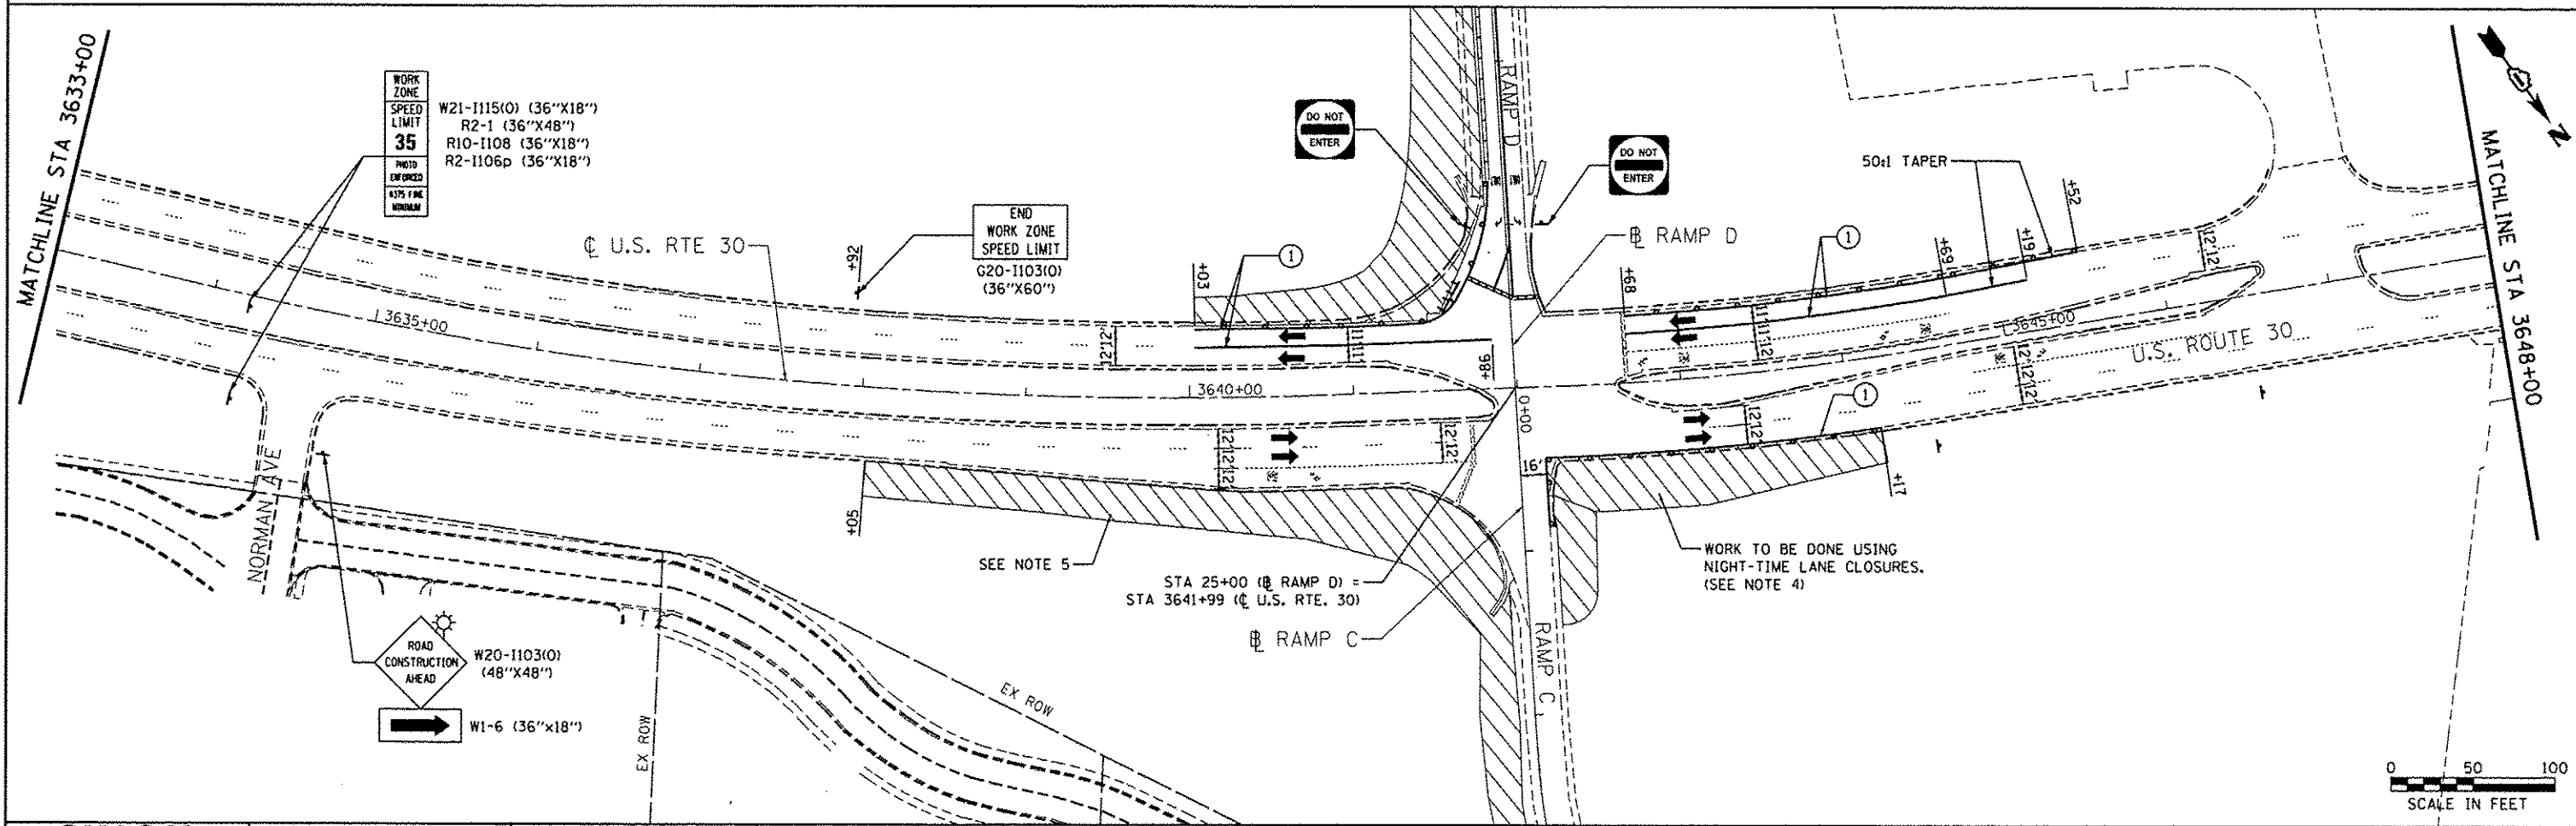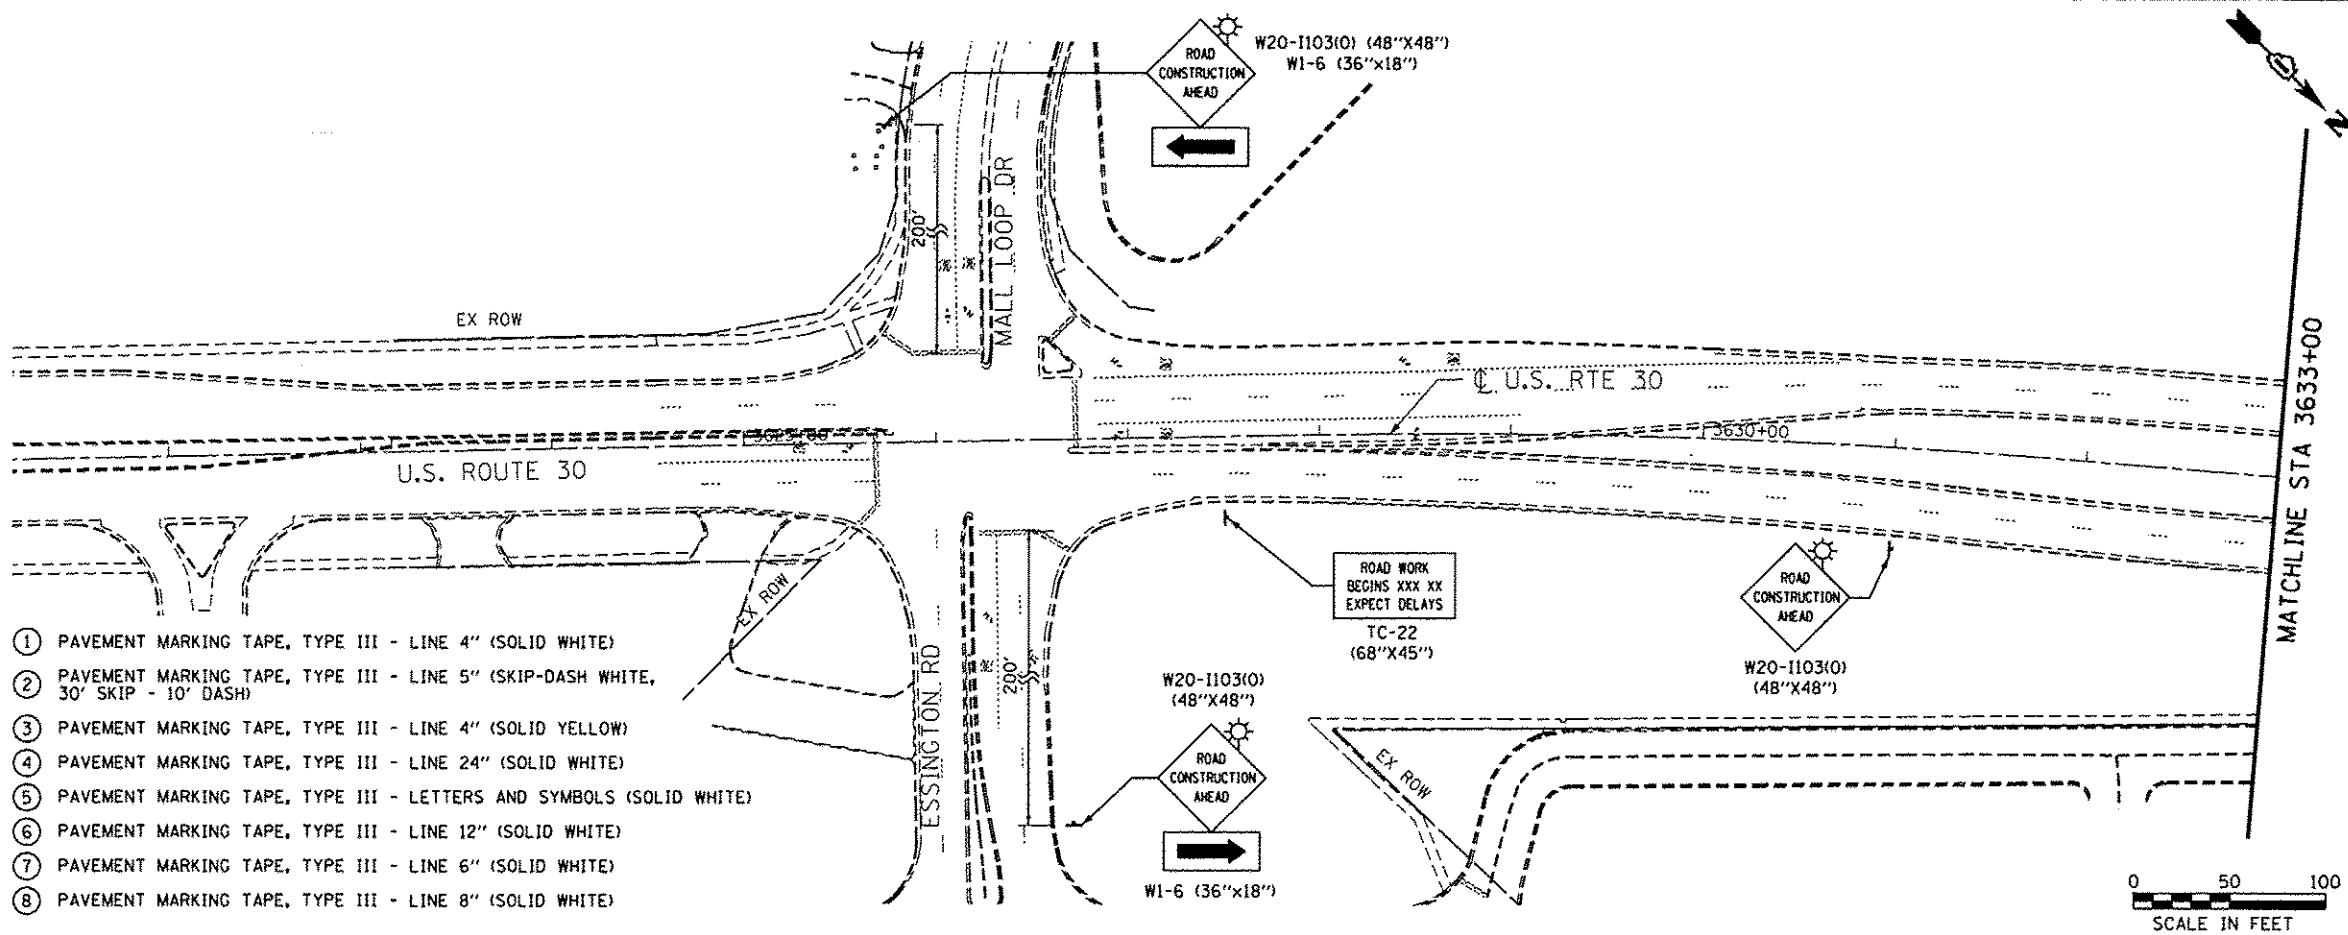

USER NAME = .USER.	DESIGNED - AS/OB	REVISED -
FILE NAME = D:\60W13\stg-staging8.dgn	DRAWN - AS/OB	REVISED -
PLOT SCALE = 5/8"=1'-0"	CHECKED - JY	REVISED -
PLOT DATE = 12/17/2013	DATE - 12/17/2013	REVISED -

STATE OF ILLINOIS  
DEPARTMENT OF TRANSPORTATION

SUGGESTED STAGES OF CONSTRUCTION AND TRAFFIC CONTROL  
US 30 - STAGE 1 AND 2  
SCALE: 1" = 50' SHEET 3 OF 5 SHEETS STA. 3618+00 TO STA. 3648+00

F.A.P. RTE.	SECTION	COUNTY	TOTAL SHEETS	SHEET NO.
575	14-N	WILL	163	40
CONTRACT NO. 60W13				
[ILLINOIS] FED. AID PROJECT				