


DAN RYAN

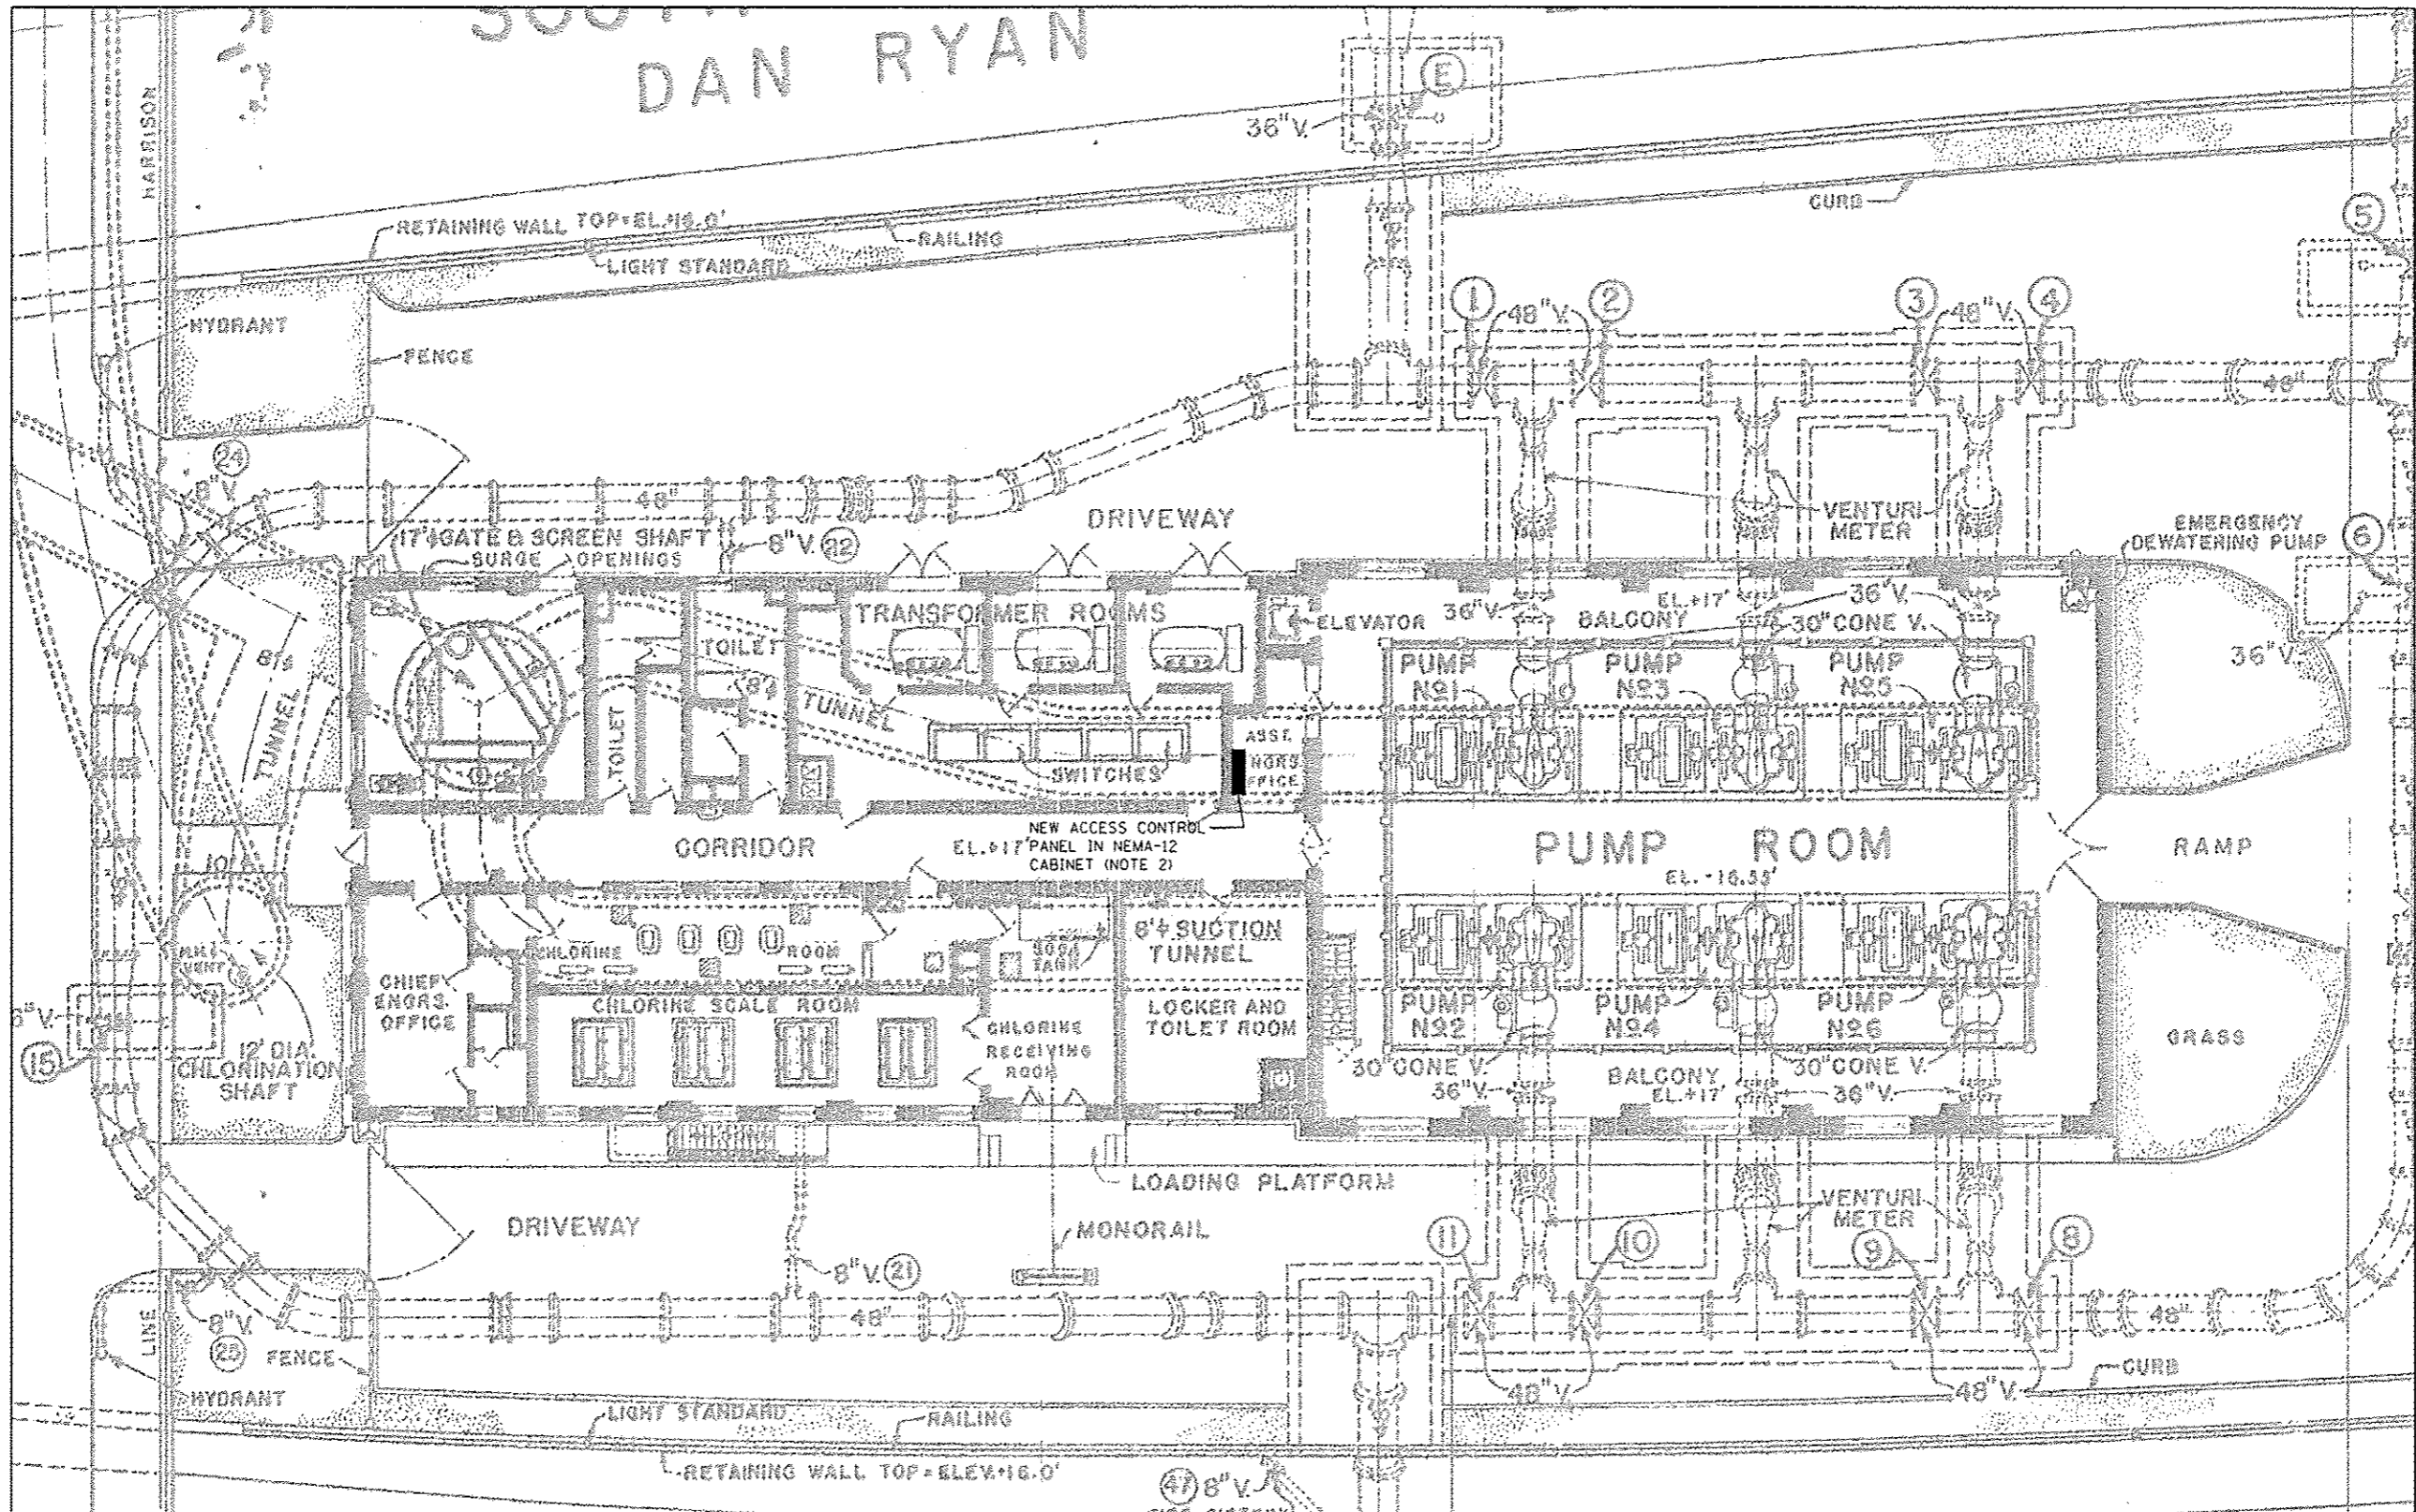

- NOTES:
1. THE BACKGROUND OF THIS DRAWING CONTAINS NOTES AND OTHER ITEMS NOT INCLUDED IN THIS SCOPE OF WORK. ONLY BOLDED WORK IS TO BE INCLUDED.
 2. INSTALL CABINET ON WALL USING GALVANIZED C-CHANNEL SUPPORTS TO BE ANCHORED TO WALL.

A

FILE PATH: s:\proj\388839\print\locconline\local\p\ae\c0688\Documents\01_American\TransformerStation\6269539_Circle\Phase_1\1088_CAD\06_Roadway\Sheet\SBW71-Sht-Fence-ELEC-02.dgn



D:\68W71-Sht-Fence-ELEC-02.dgn
 USER NAME: x.Chua
 PLOT SCALE: 2,0000 / in.
 PLOT DATE: 4/4/2014

DESIGNED - BMW	REVISED - 04/03/2014
DRAWN - BMW	REVISED -
CHECKED - WDS	REVISED -
DATE - 02/19/14	REVISED -

STATE OF ILLINOIS
 DEPARTMENT OF TRANSPORTATION

GATE OPERATOR
 ELECTRICAL PLAN

SCALE: N.T.S. SHEET 2 OF 4 SHEETS STA. TO STA.

F.A.I. RTE.	SECTION	COUNTY	TOTAL SHEETS	SHEET NO.
90/94/290	2013-036R	COOK	256	91B
CONTRACT NO. 60W71				
ILLINOIS FED. AID PROJECT				