


c:\pwworking\aecom\00\myer\sc\d0257059\DIGOW71-sht-Light-07.dgn 12/18/2013 7:42:37 AM

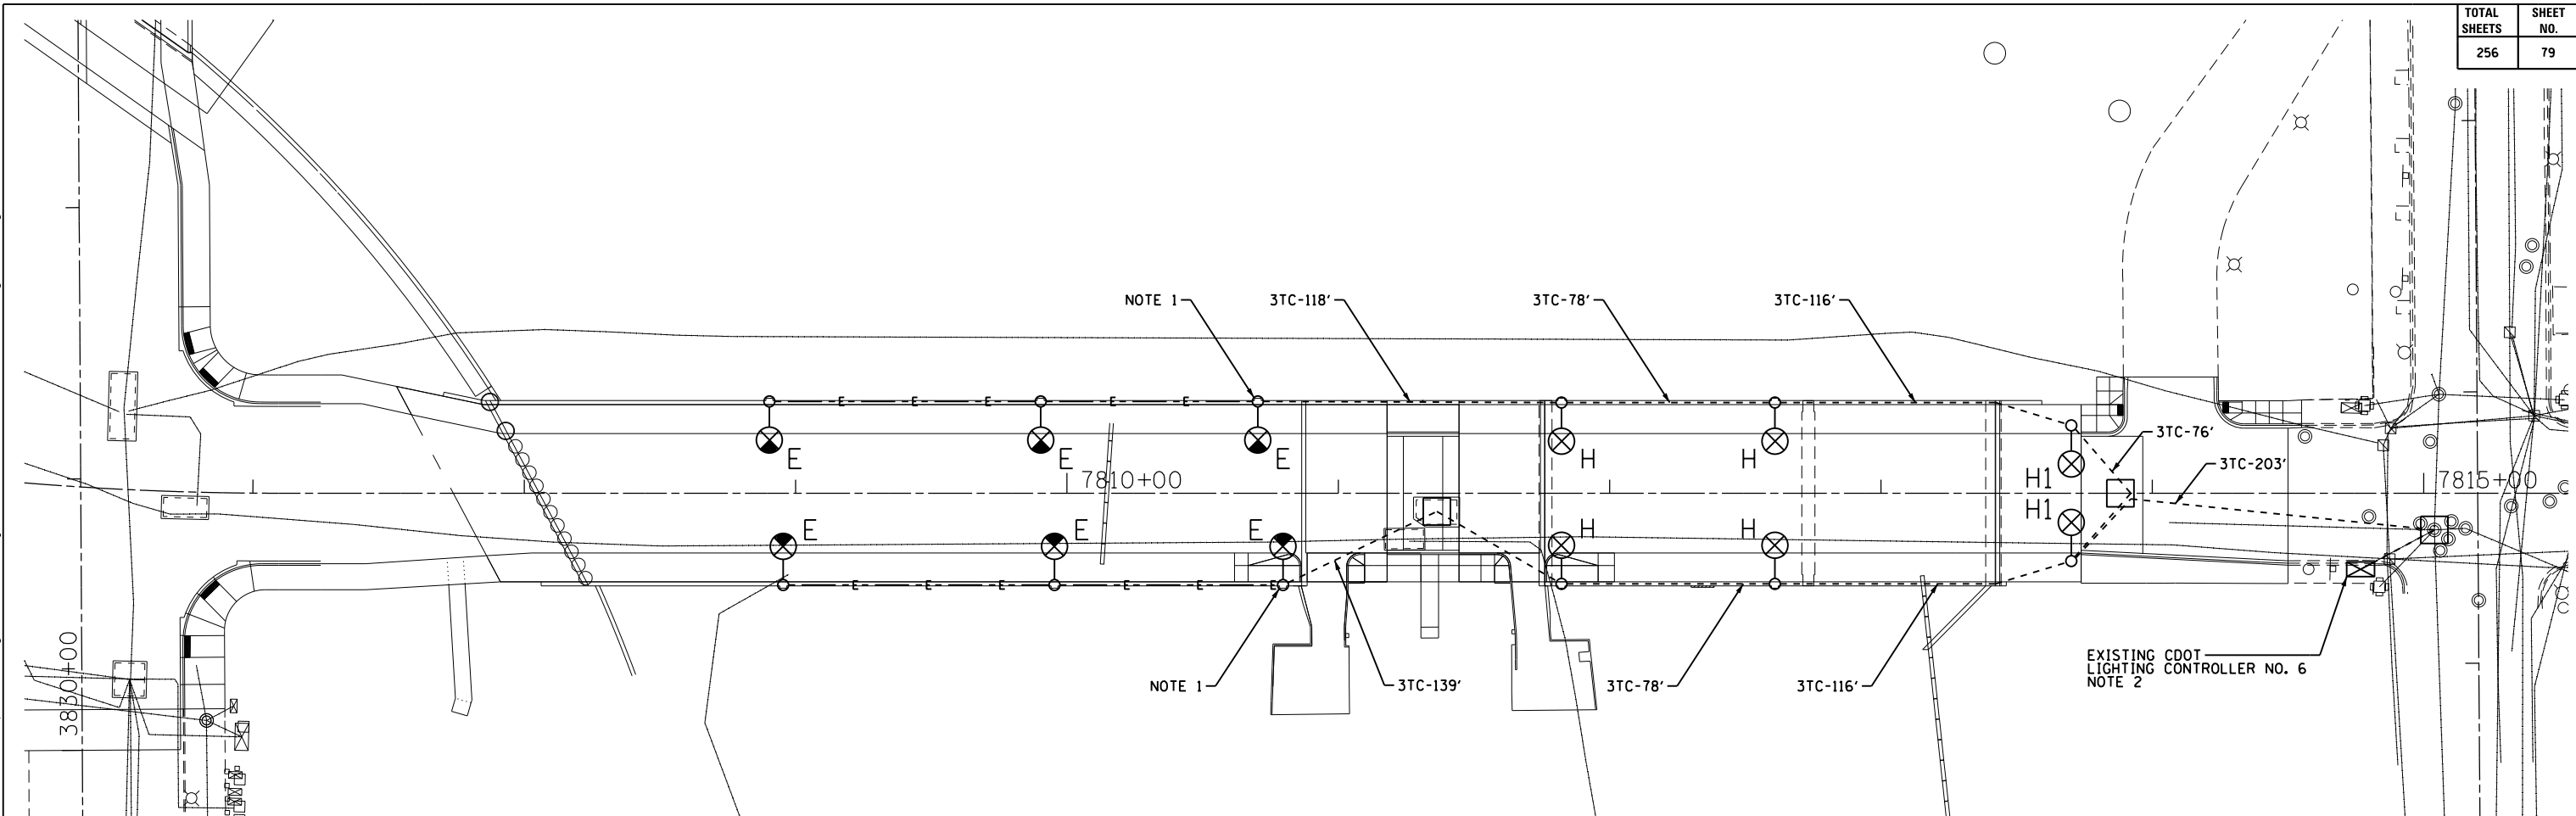


NEW 9,018 WATTS  
 OLD 9,018 WATTS  
 ATLAS NO. 0-24  
 GROUP NO. 6  
 (6) 480 WATT @ 240V  
 (18) 341 WATT @ 240V

**NOTES:**

1. SPLICE NEW CABLES TO EXISTING LIGHTING CIRCUITS LOCATED IN EXISTING POLE.
2. ALL LIGHTING UNITS SHOWN ON THIS DRAWING SHALL BE FED FROM EXISTING CDOT LIGHTING CONTROLLER GROUP NO. 6 LOCATED ON THE SW CORNER OF HALSTED AND DES PLAINES.

"E" EXISTING TO REMAIN  
 "H" INSTALL CDOT FURNISHED STEEL POLE, LUMINAIRE AND MAST ARM PER DRAWING NOS. 620, 762 AND 837.  
 "H1" INSTALL CDOT FURNISHED STEEL POLE, LUMINAIRE, MAST ARM AND BALLAST HOUSING PER DRAWING NOS. 620, 808 AND 875.

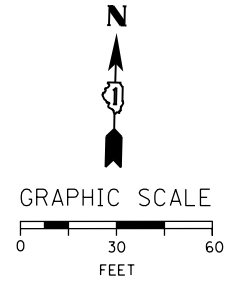

FOR CONDUIT AND FOUNDATION PLANS SEE DRAWING NO. E-06.  
 FOR LIGHTING REMOVAL PLANS SEE DRAWING NO. E-08.

DATE	REVISION	
<b>CITY OF CHICAGO</b>		
DEPARTMENT OF TRANSPORTATION DIVISION OF ENGINEERING		
<b>AECOM</b>		
WORK ORDER NO. _____	DATE _____	
COST ALLOCATION ACCOUNT _____		
APPROPRIATION ACCOUNT _____	MATERIAL _____ LABOR _____	
<b>EAST HARRISON STREET LIGHTING CABLE AND EQUIPMENT INSTALLATION PLAN</b>		
<b>CITY OF CHICAGO</b> DEPT. OF TRANSPORTATION DIVISION OF ELECTRICAL OPERATIONS		
DRAFTSMAN: CAM	CHIEF DRAFTSMAN: WDS	ENGINEER: WDS
SUPERVISING ENGINEER/ELEC. DESIGN ENGR. WDS		<b>E-07</b>
ENGINEER OF ELECTRICITY:		
GEN'L SUPT. OF ELECTRICITY:		
DEPUTY COMMISSIONER:		
SIZE: 22"   34"	SCALE: 1" = 30'	DATE: 12/06/13
DATE: 12/20/13	DWG. NO.: 7 OF 19	
C.D.O.T. PROJECT NO.:		