
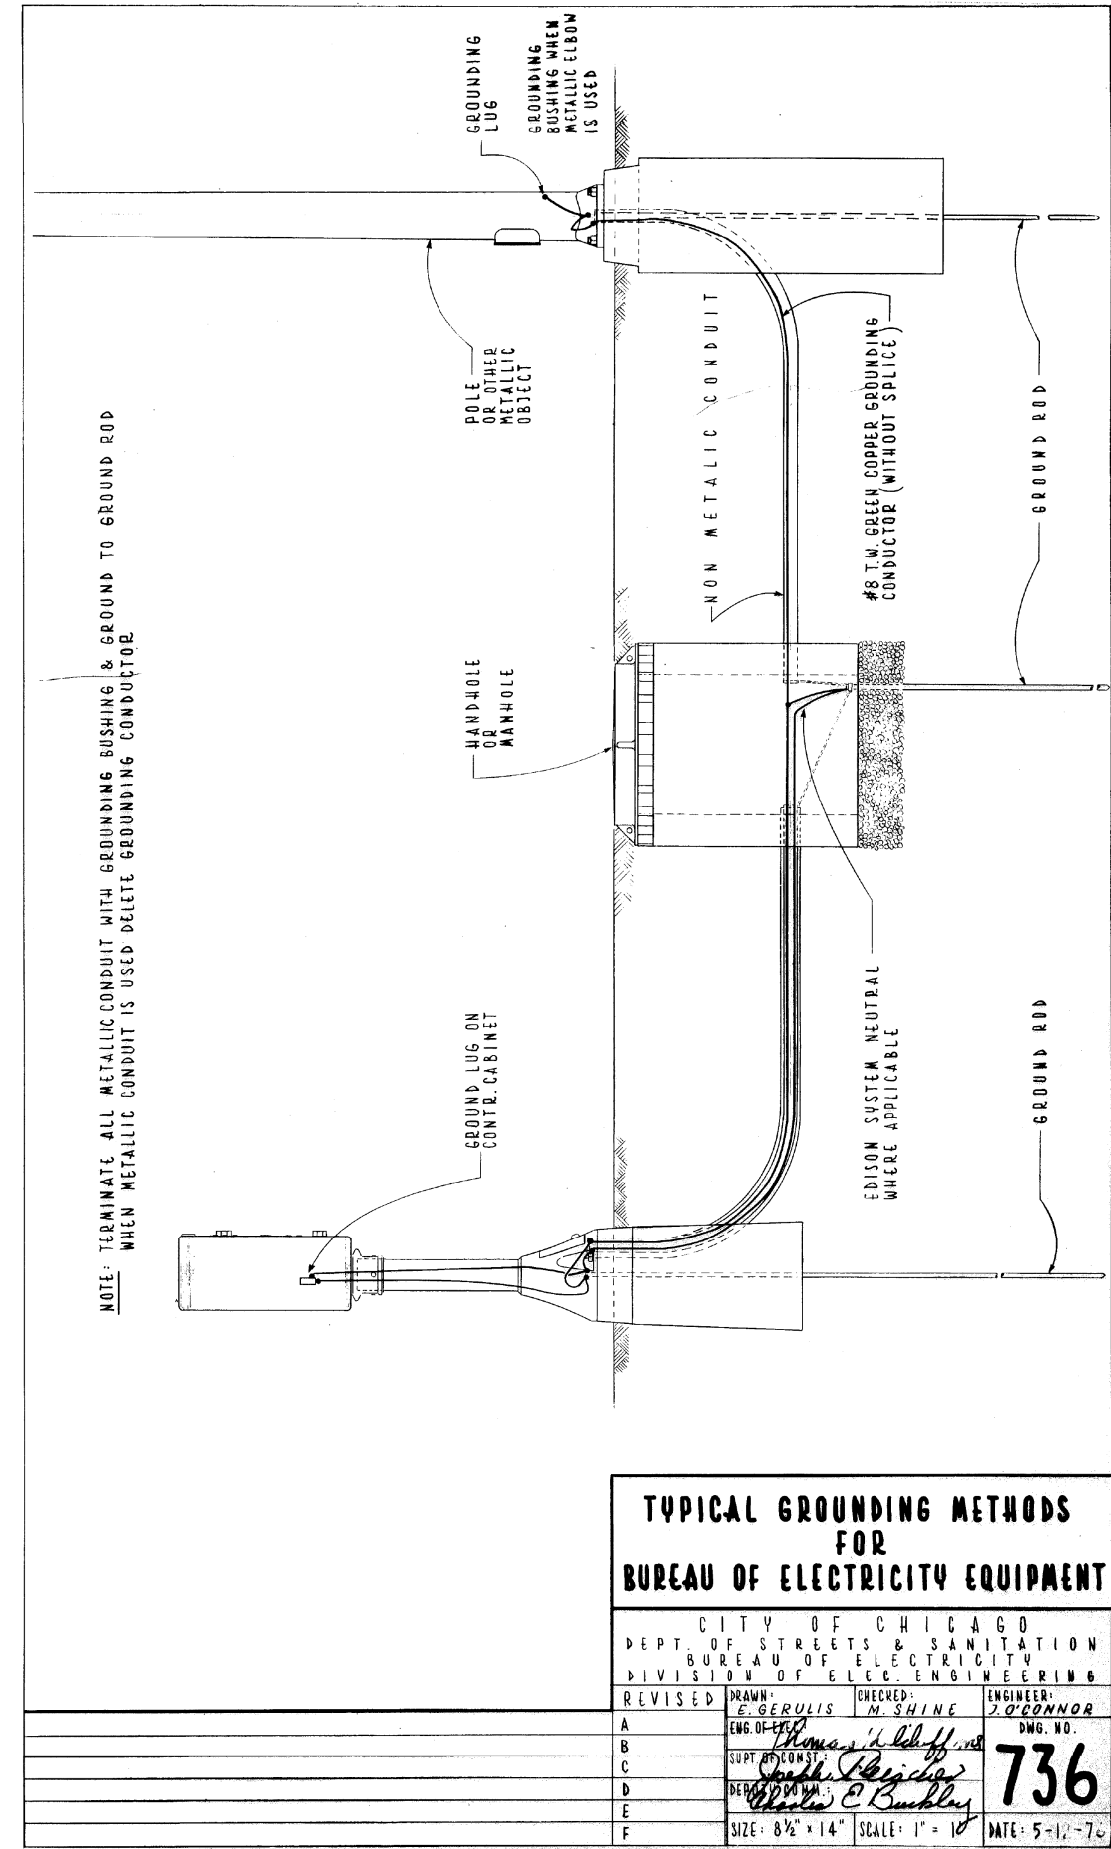


FILE PATH = p:\388035\pmt\econ\line\local\p\AECOM\0\Documents\01\_Americas\Transportation\66269938\_Circle\Phase\_1\000\_CAD\016\_Electrical\Sheets\60W71-Contract\0160W71-sht-Light-13

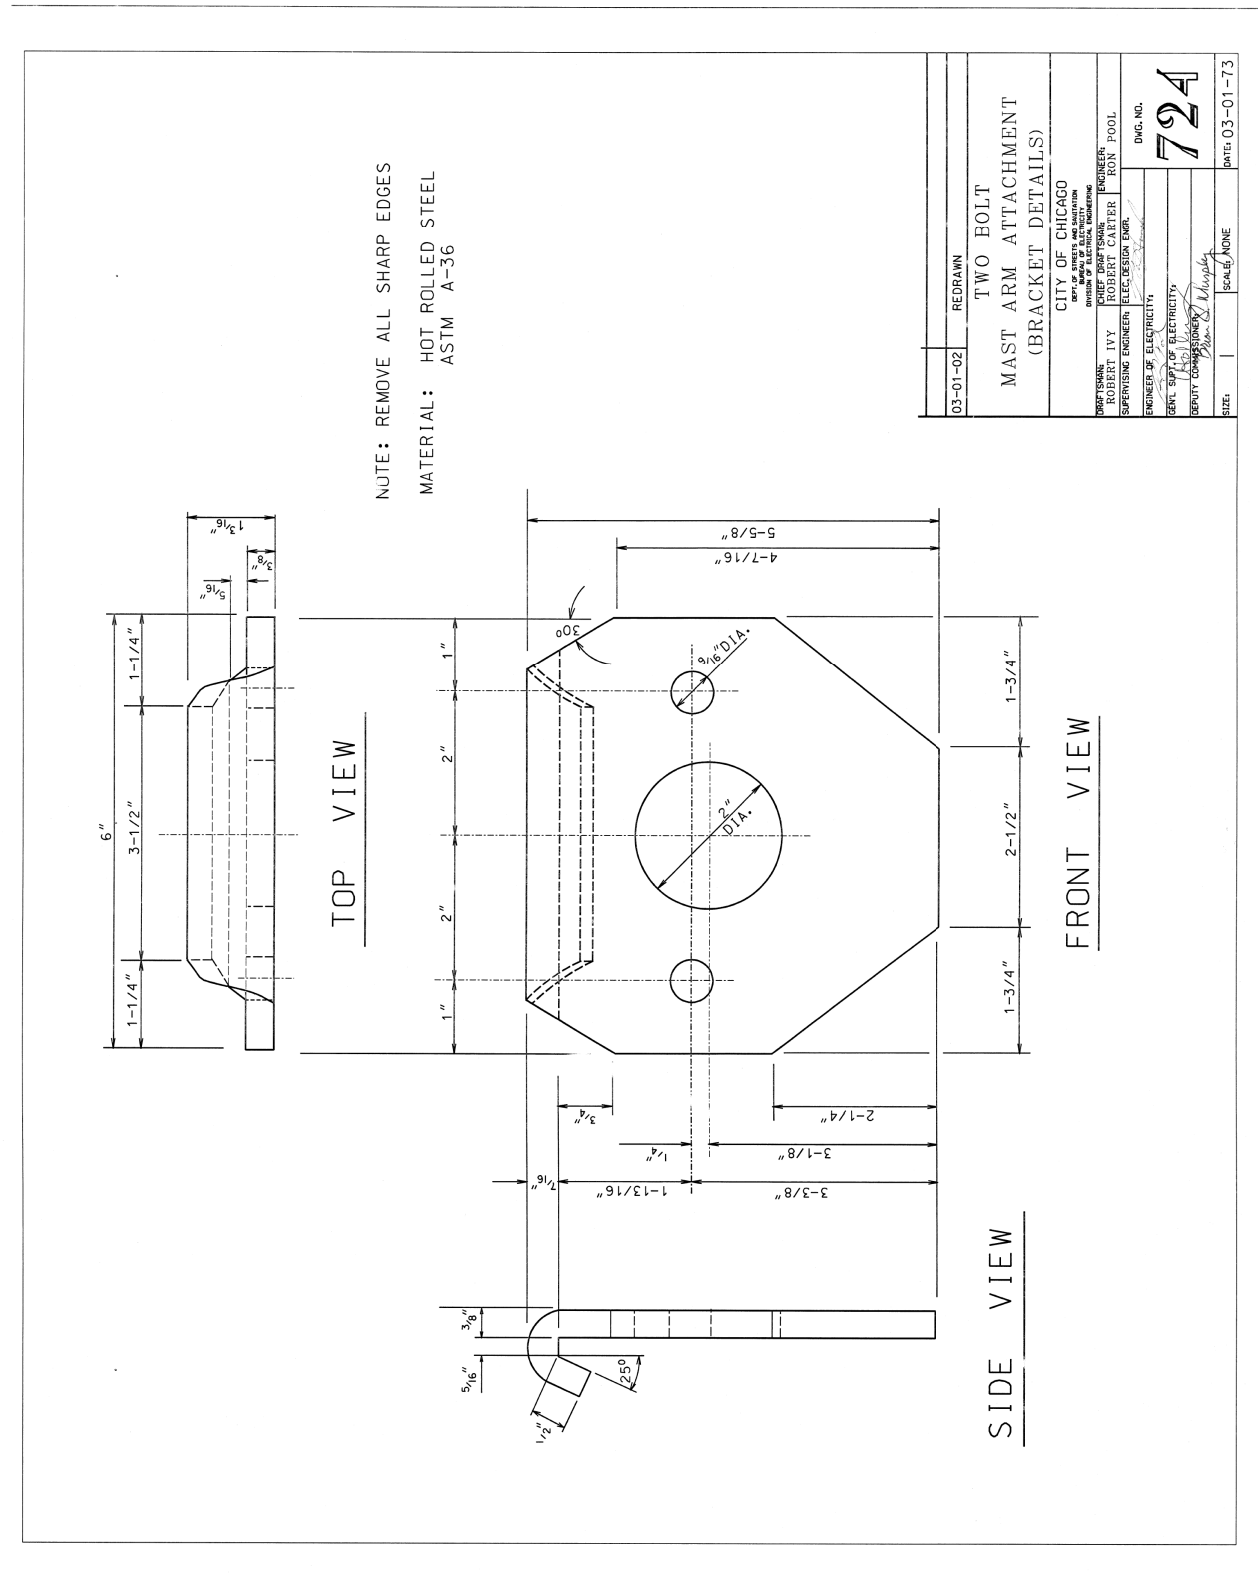

D160W71-sht-Light-13  
USER NAME = myersc  
PLOT SCALE = 1.0000' / 1" = 10'  
PLOT DATE = 12/18/2013

DESIGNED - WDS  
DRAWN - CAM  
CHECKED - WDS  
DATE - 12/20/13

REVISED -  
REVISED -  
REVISED -  
REVISED -

STATE OF ILLINOIS  
DEPARTMENT OF TRANSPORTATION

MISCELLANEOUS ELECTRICAL DETAILS  
SCALE: N.T.S. SHEET 13 OF 19 SHEETS STA. TO STA.

F.A.I. RT.E.	SECTION	COUNTY	TOTAL SHEETS	SHEET NO.
90/94/290	2013-036R	COOK	256	85
CONTRACT NO. 60W71				
ILLINOIS FED. AID PROJECT				