
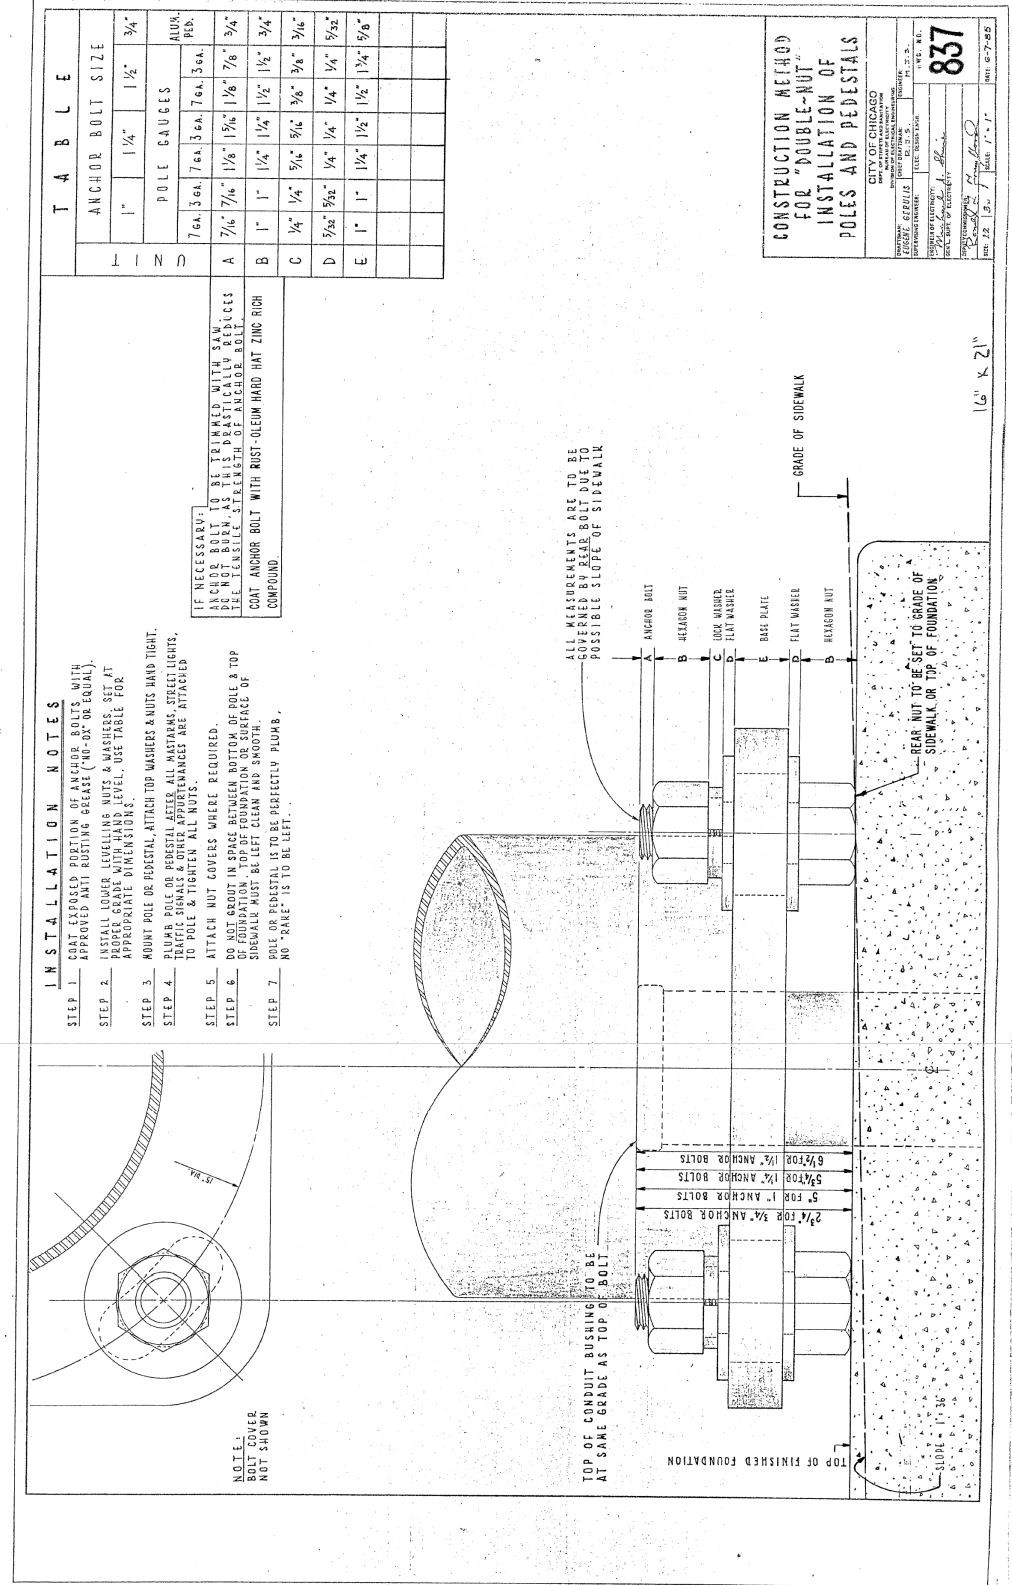


FILE PATH = p:\388035-pmt\lsc\comline\local\pawec\000\Documents\01\_Americas\Transportation\62629938\_Circle\Phase\_1\000\_CAD\01E\_Electrical\Sheets\60W71\_Contract\160W71-sht-Light-17

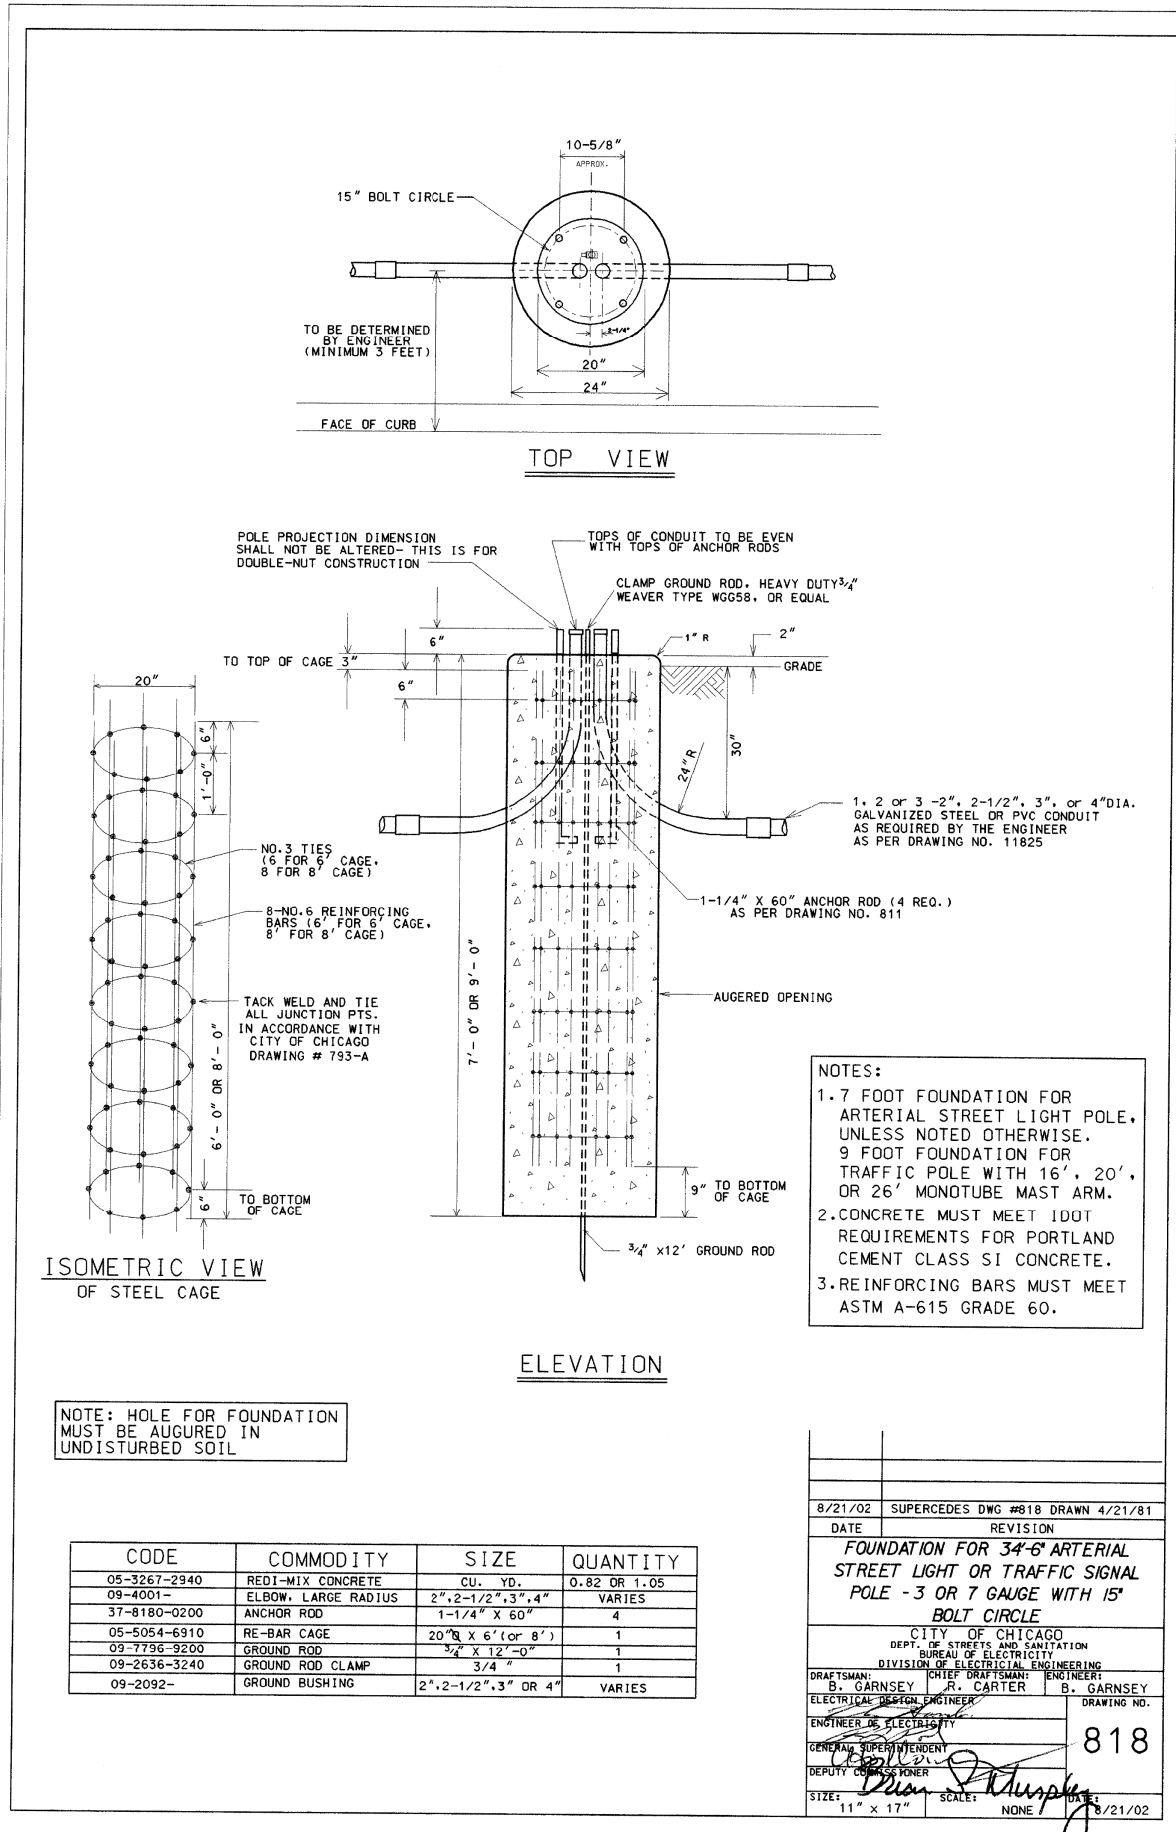

**CONSTRUCTION METHOD FOR "DOUBLE-NUT" INSTALLATION OF POLES AND PEDESTALS**

CITY OF CHICAGO  
DEPT. OF STREETS AND SANITATION  
BUREAU OF ELECTRICITY  
DIVISION OF ELECTRICAL ENGINEERING

DRAWING NO. **818**

DATE: 8/21/02



D160W71-sht-Light-17  
USER NAME = myersc  
PLOT SCALE = 1:8000 / 1/4"  
PLOT DATE = 12/18/2013

DESIGNED - WDS  
DRAWN - CAM  
CHECKED - WDS  
DATE - 12/20/13

STATE OF ILLINOIS  
DEPARTMENT OF TRANSPORTATION

MISCELLANEOUS ELECTRICAL DETAILS

SCALE: N.T.S. SHEET 17 OF 19 SHEETS STA. TO STA.

F.A.I. R.T.E.	SECTION	COUNTY	TOTAL SHEETS	SHEET NO.
90/94/290	2013-036R	COOK	256	89
CONTRACT NO. 60W71				
ILLINOIS FED. AID PROJECT				