


**DECK CROSS SECTION**  
(Facing East)

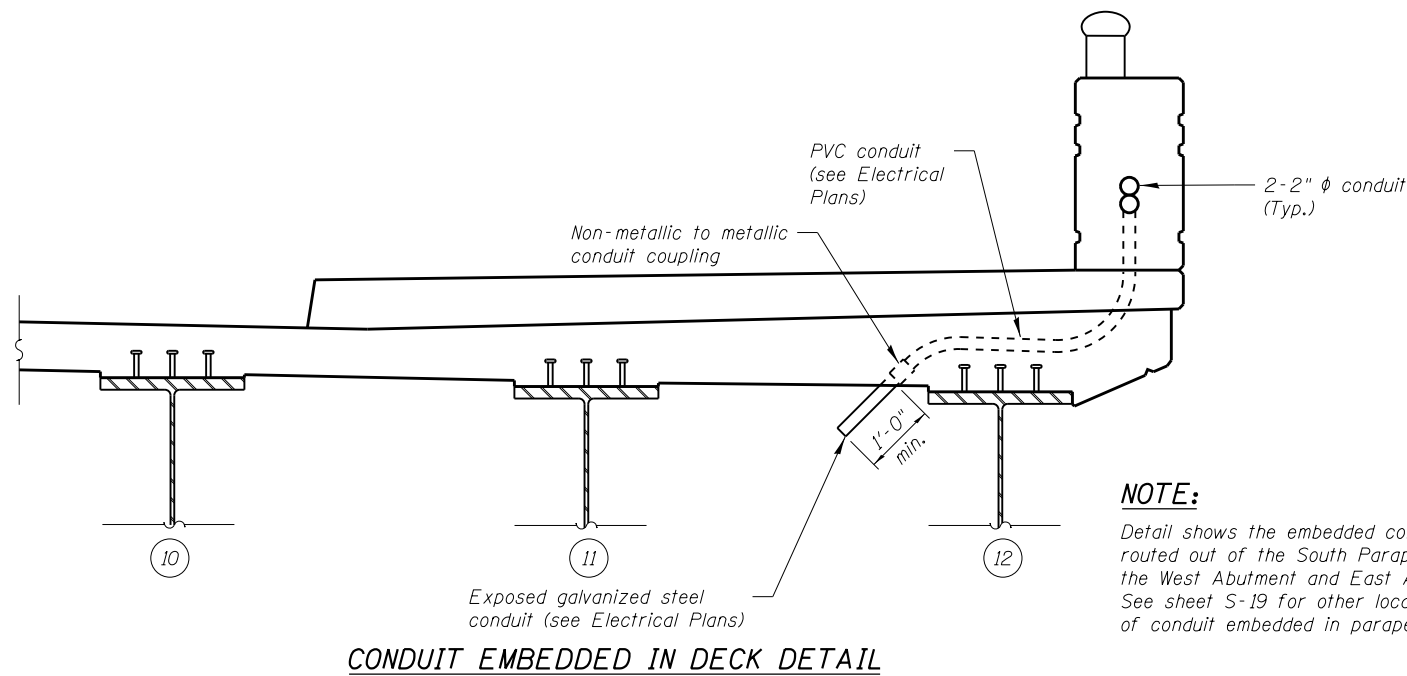

**NOTES:**

1. Work this sheet with sheet S-16.
2. Proposed conduit support system is shown for information only on sheets 135A thru 135C. The concrete inserts will be provided to the Contractor by ComEd. The Contractor is responsible for placing inserts per layout details and ComEd direction. ComEd may elect to provide support to Contractor for final insert placement in advance of pouring concrete. There is no separate payment for the placement of inserts. The work involved in placing inserts is included within Concrete Superstructure.
3. Space inserts at 10'-0" cts max longitudinally, full length of bridge (see framing plans). Cost of inserts included in Concrete Superstructure. See electrical plans for conduit support and insert details.

**NOTE:**

Detail shows the embedded conduits routed out of the South Parapet into the West Abutment and East Abutment. See sheet S-19 for other locations of conduit embedded in parapet.

0161711-60W71-S18-Deck



USER NAME = dunkerleyb	DESIGNED - DEV	REVISED
	CHECKED - DD	REVISED
PLOT SCALE = N.T.S.	DRAWN - DEV	REVISED
PLOT DATE = 12/17/2013	CHECKED - DD	REVISED

**STATE OF ILLINOIS**  
**DEPARTMENT OF TRANSPORTATION**

**DECK CROSS SECTION**  
**STRUCTURE NO. 016-1711**

SHEET NO. S-18 OF S-47 SHEETS

F.A.I. RTE.	SECTION	COUNTY	TOTAL SHEETS	SHEET NO.
90/94/290	2013-036R	COOK	256	110
CONTRACT NO.			60W71	
ILLINOIS FED. AID PROJECT -NUMBER-				