
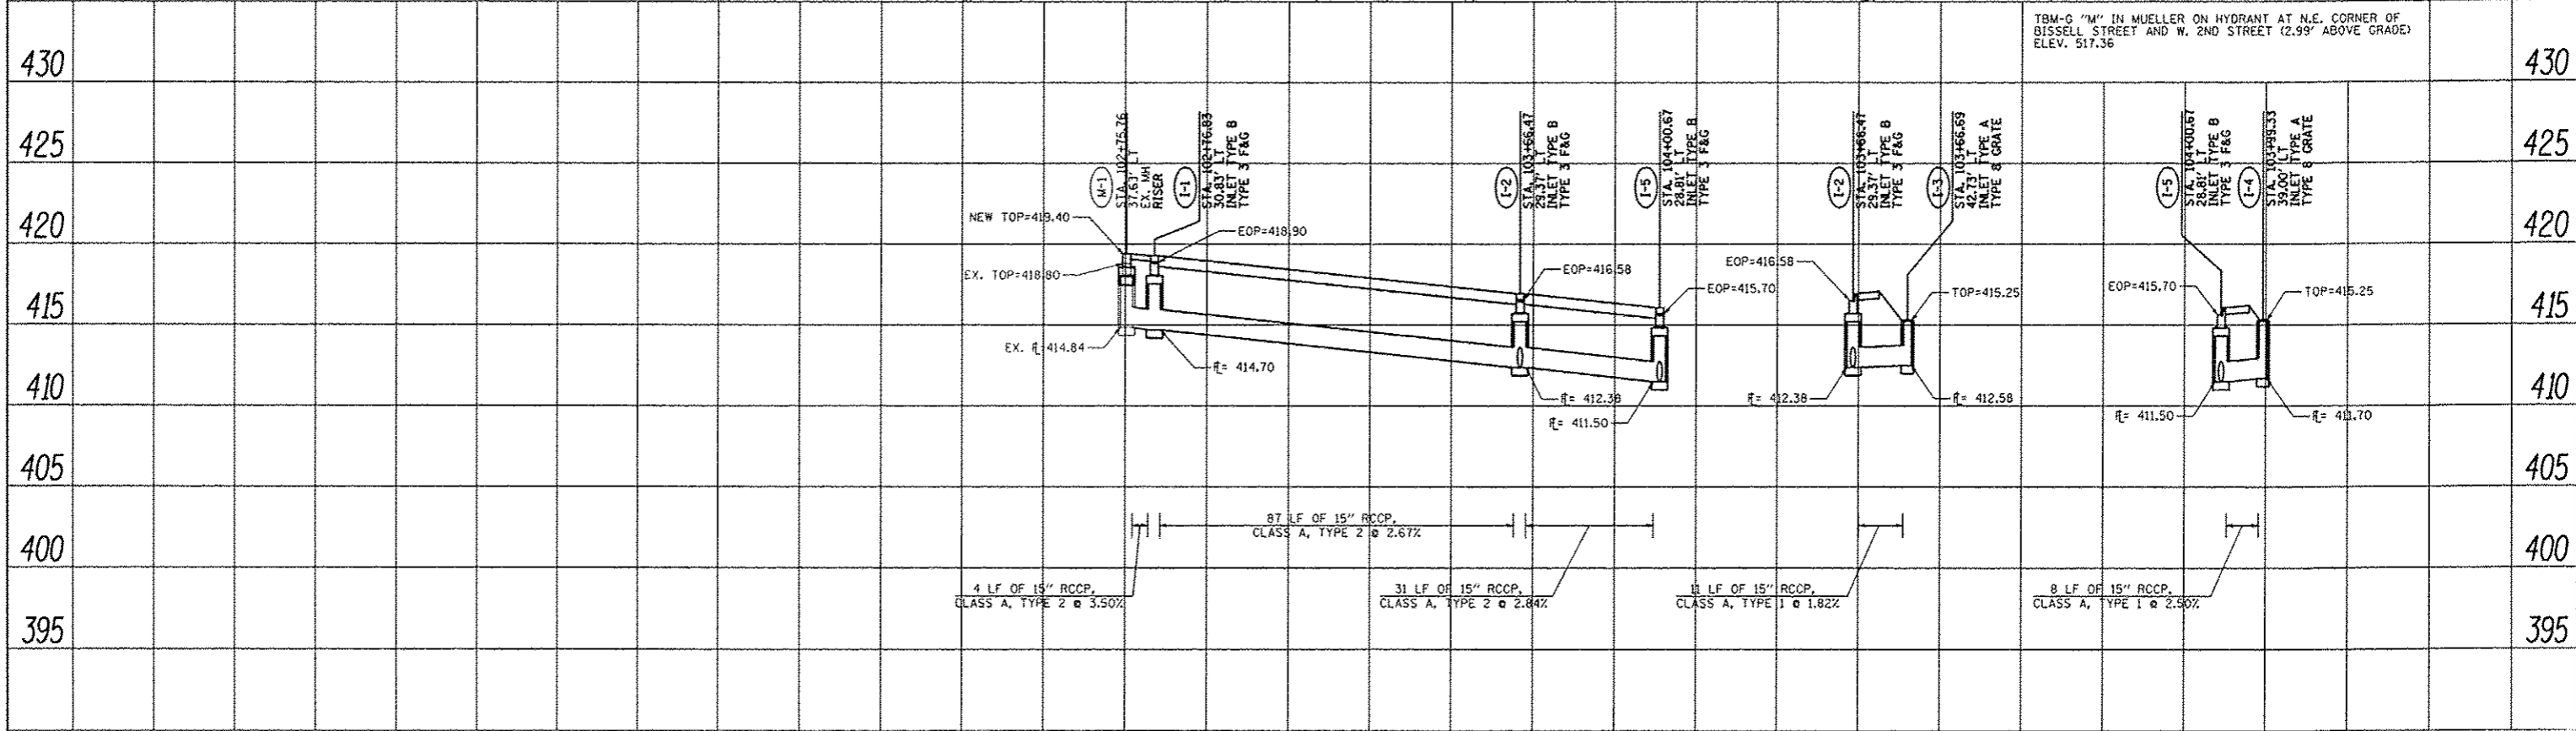


PLAN	SURVEYED	DATE
	PLOTTED	
	CHECKED	
	BY	
	NO.	
	FILE NAME	

PROFILE	SURVEYED	DATE
	PLOTTED	
	CHECKED	
	BY	
	NO.	
	FILE NAME	

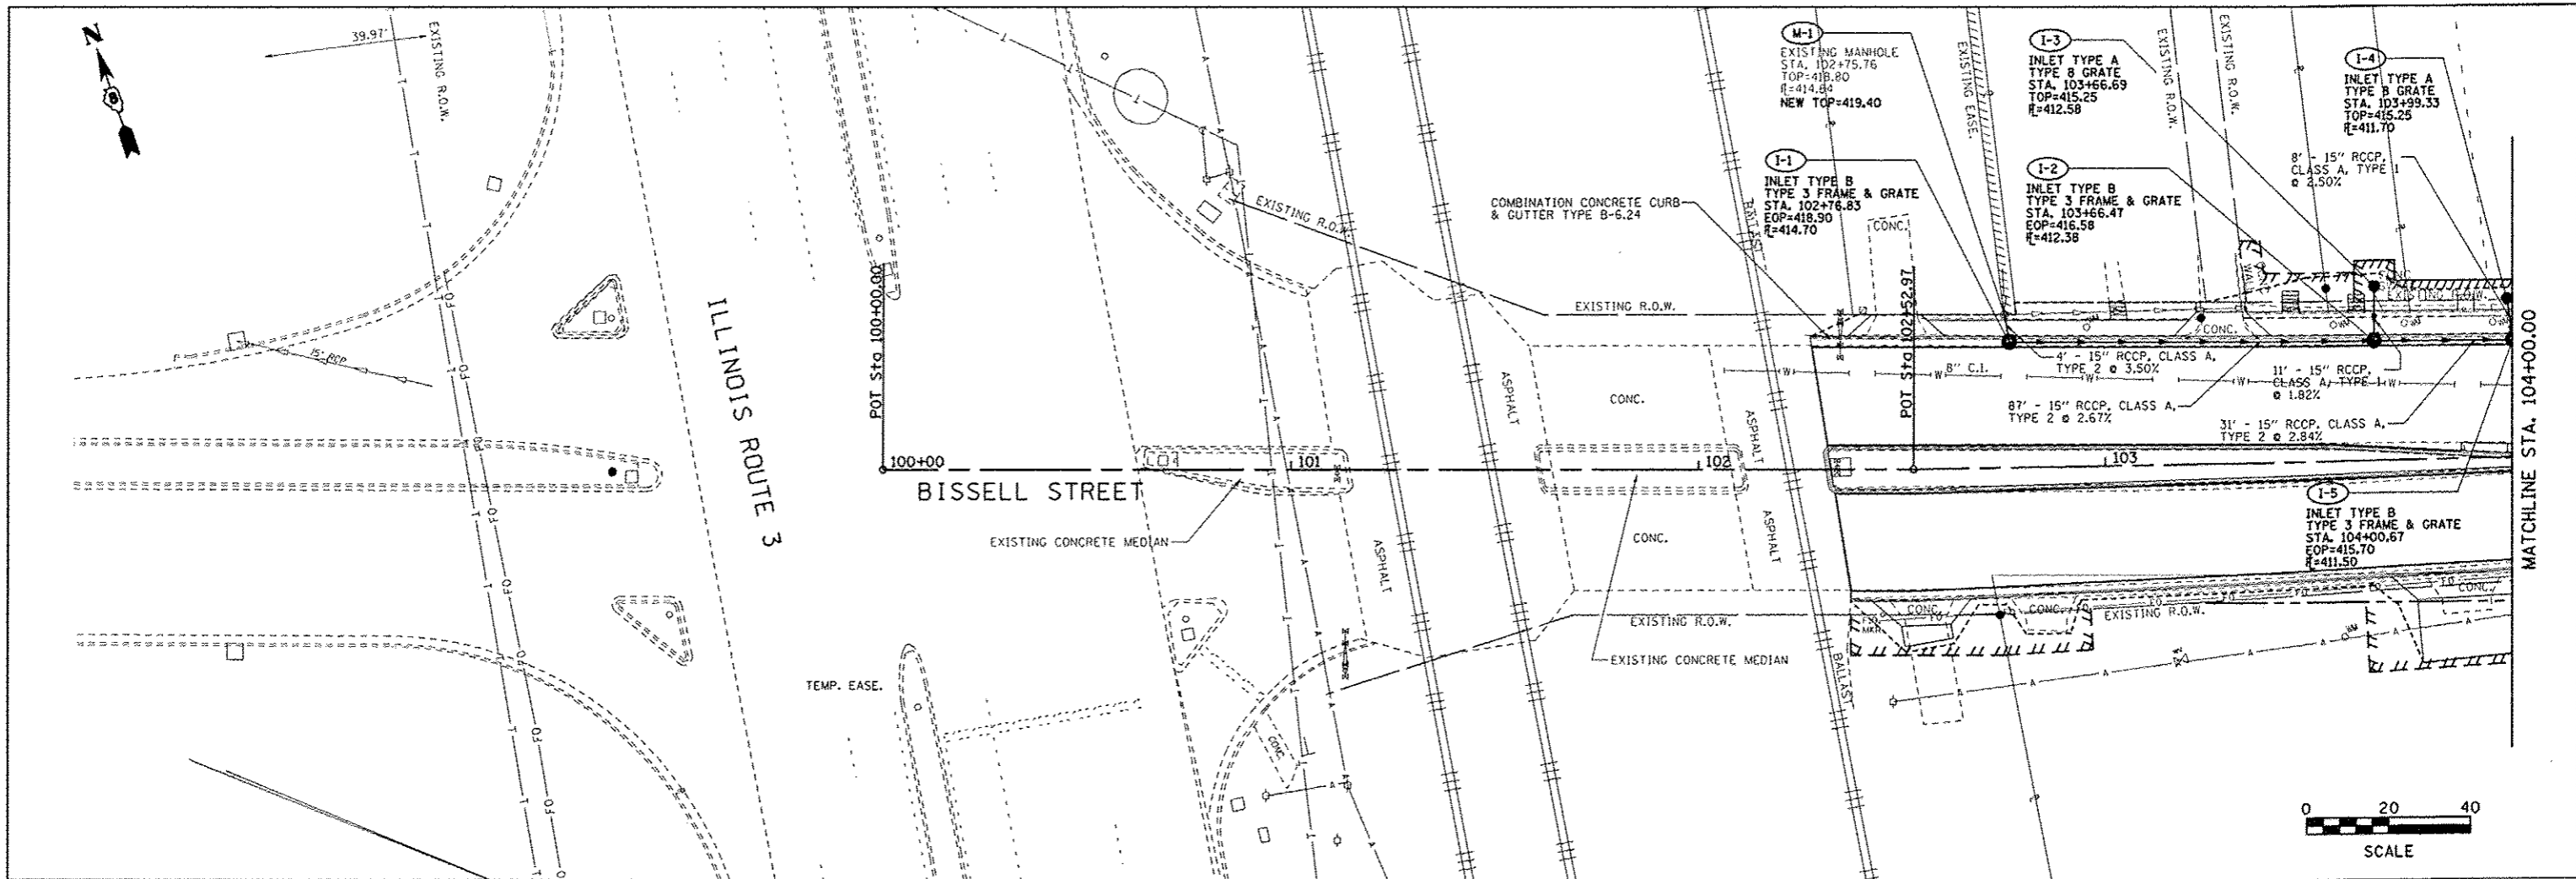

FILE NAME	USER NAME = ramash	DESIGNED - SAS	REVISED -	CITY OF MADISON BISSELL STREET	DRAINAGE PLAN & PROFILE	F.A.U. RTE. 9104	SECTION 10-00058-00-PV	COUNTY MADISON	TOTAL SHEETS 53	SHEET NO. 31	
#FILE#	PLOT SCALE = 4SCALE#	DRAWN - SAS	REVISED -			SCALE: 1"=20'	SHEET NO. 1 OF 3 SHEETS	STA. 102+32.57 TO STA. 104+00.00	CONTRACT NO. 97530		ILLINOIS FED. AID PROJECT
	PLOT DATE = 12/20/13	CHECKED - BFK	REVISED -								
		DATE = 12/20/13	REVISED -								