

FOR INDEX OF SHEETS, SEE SHEET NO. 3

THIS PROJECT IS LOCATED IN THE CITIES OF CHICAGO
AND CALUMET AND THE VILLAGES OF BURNHAM,
RIVERDALE, SOUTH HOLLAND AND DOLTON

TRAFFIC DATA

I-94

ADT(2023) = 166,900

POSTED SPEED LIMIT = 55 MPH

US 6 RAMP TO NB I-94

ADT(2022) = 6,300

POSTED SPEED LIMIT = 35 MPH

154TH STREET

ADT(2022) = 6,550

POSTED SPEED LIMIT = 35 MPH

US 6 (159TH ST)

ADT(2023) = 24,900

POSTED SPEED LIMIT = 35 MPH

FOR SEALS AND SIGNATURES, SEE SHEET NO. 2

STATE OF ILLINOIS

04-25-2025 LETTING ITEM 205


DEPARTMENT OF TRANSPORTATION

PROPOSED HIGHWAY PLANS

FAI ROUTE 94: I-94 (BISHOP FORD EXPRESSWAY)
WEST OF MLK DRIVE TO US 6 (159TH ST)
SECTION (42-B-11-1) BR, BJR 24
PROJECT NHPP-2B1H(072)
STANDARD OVERLAY, BRIDGE DECK OVERLAY, BRIDGE
REPAIR, BRIDGE SUPERSTRUCTURE REPLACEMENT, SIGN
STRUCTURES, LIGHTING, PATCHING, AND ITS

COOK COUNTY

C-91-249-24

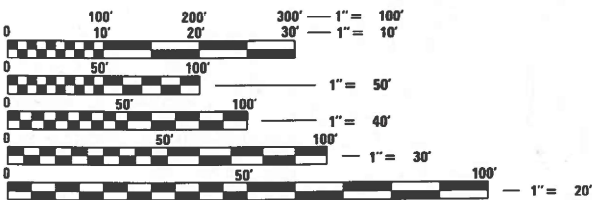


FULL SIZE PLANS HAVE BEEN PREPARED USING STANDARD
ENGINEERING SCALES. REDUCED SIZED PLANS WILL NOT
CONFORM TO STANDARD SCALES. IN MAKING MEASUREMENTS
ON REDUCED PLANS, THE ABOVE SCALES MAY BE USED.

J.U.L.I.E.
JOINT UTILITY LOCATION INFORMATION FOR EXCAVATORS
1(800) 892-0123
(312) 744-7000 OR 811 CHICAGO

PROJECT ENGINEER LUKASZ POCIECHA, P.E. (847) 705-4255
PROJECT MANAGER VESELIN VELICHKOV, P.E. (847) 705-4432

CONTRACT NO. 62W87

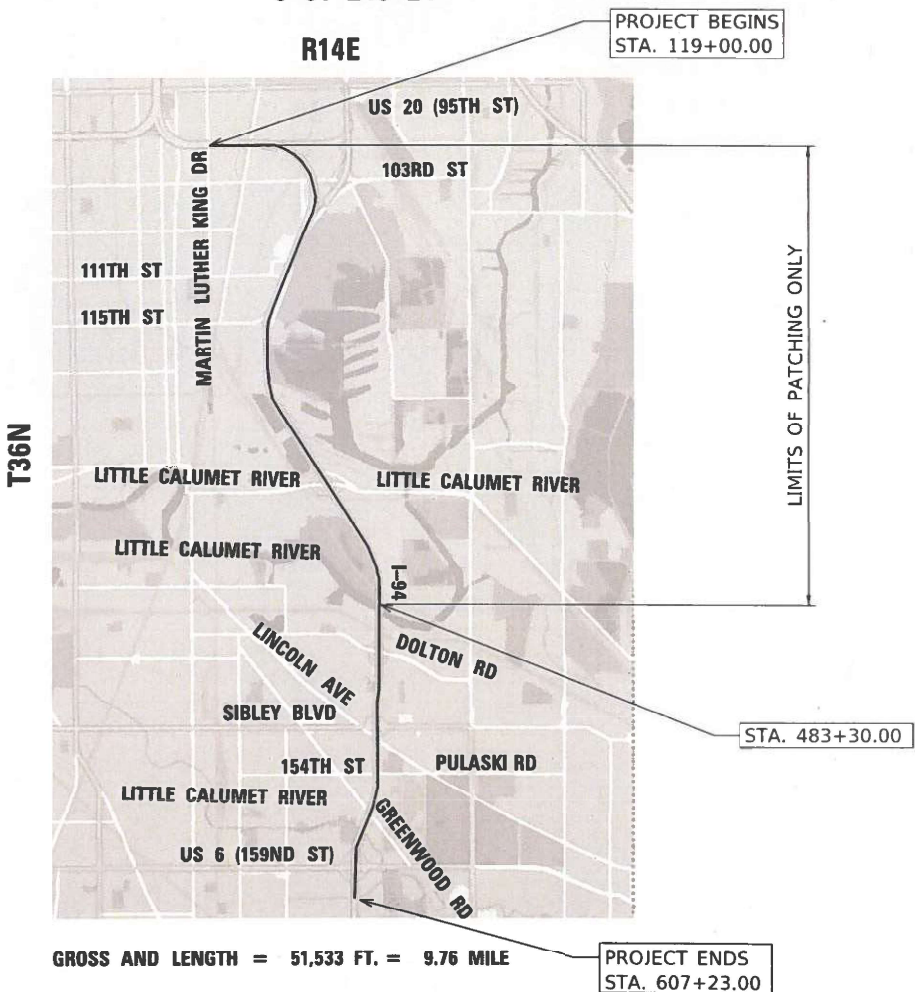

F.A.I. RTE.	SECTION	COUNTY	TOTAL SHEETS	SHEET NO.
94	(42-B-11-1) BR, BJR 24	COOK	761	1
ILLINOIS				CONTRACT NO. 62W87
* 761 + 31 = 792 TOTAL SHEETS				
** 792 + 1 = 793 TOTAL SHEETS				

D-91-201-24



LOCATION OF SECTION INDICATED THUS: -

STATE OF ILLINOIS
DEPARTMENT OF TRANSPORTATION

SUBMITTED Dec 12 20 24
Jose Rios REGIONAL ENGINEER

January 31 20 25
Scott A. Etkin ENGINEER OF DESIGN AND ENVIRONMENT

January 31 20 25
John J. 5 DIRECTOR OF HIGHWAYS PROJECT IMPLEMENTATION

PRINTED BY THE AUTHORITY
OF THE STATE OF ILLINOIS

1 REVISED SHEET 4/14/2025

REV-SEP

MODEL: Default
FILE NAME: hbmepw11cs01ICS.pdf, work_dir\3026\450_80D162K53-ent-index.dgn

INDEX OF SHEETS

1	COVER SHEET
2	SEALS AND SIGNATURES
3	INDEX OF SHEETS AND HIGHWAY STANDARDS
4	GENERAL NOTES
5-23A	SUMMARY OF QUANTITIES
24-25	BRIDGE STRUCTURES SCHEDULE OF QUANTITIES
26	OHSS SCHEDULE OF QUANTITIES
27-29	PROJECT CORRIDOR MAP
30-44	SCHEDULE OF QUANTITIES
45-66	TYPICAL SECTIONS
67	TYPICAL SECTIONS - US 6 (159TH STREET)
68	MISCELLANEOUS DETAILS
69-98	ALIGNMENT, TIES AND BENCHMARKS
99	ALIGNMENT, TIES AND BENCHMARKS - US 6 (159TH STREET)
99A	EROSION CONTROL NOTES
100-106	REMOVAL PLAN AND EROSION CONTROL PLAN
107	REMOVAL PLAN AND EROSION CONTROL PLAN - 154TH STREET
108	REMOVAL PLAN AND EROSION CONTROL PLAN - 159TH STREET
109-164	ROADWAY PLANS
165	ROADWAY & PAVEMENT MARKING PLAN - 154TH STREET
166-167	PROPOSED PLAN & PROFILE - US 6 (159TH STREET)
168	PROPOSED PLAN & PROFILE - US 6 RAMP
169	SUPERELEVATION TRANSITION DIAGRAM US 6 RAMP
170-172	PROPOSED US 6 RAMP & I-94 AUX LANE ELEVATION DETAILS
173-216*****	MAINTENANCE OF TRAFFIC
217-220	MAINTENANCE OF TRAFFIC - 154TH STREET
221-223	MAINTENANCE OF TRAFFIC - US 6 (159TH STREET)
224-246	DETOUR PLANS
247-248	DETOUR PLANS - US 6 (159TH STREET)
249-256	DRAINAGE PLANS
257	DRAINAGE PLANS - US 6 (159TH STREET)
258-313	PAVEMENT MARKING PLANS
314	PAVEMENT MARKING PLANS - US 6 (159TH STREET)
315-335	LANDSCAPE PLANS
336	ITS GENERAL NOTES AND LEGEND
337-352	ITS REMOVAL & TEMPORARY PLAN
353-384	ITS PLAN
385-397****	ITS DETAILS
398	LIGHTING PLANS - GENERAL NOTES AND BILL OF MATERIAL
399-400	LIGHTING PLANS - REMOVAL SCHEDULE
401-402	LIGHTING PLANS - SCHEDULE OF QUANTITIES
403-421	LIGHTING PLANS
422-424A	LIGHTING PLANS - PROPOSED ONE LINE DIAGRAM CONTROLLER
425-428***	LIGHTING PLANS - UNDERPASS
428A-428D	EXISTING LINE DIAGRAMS
428E-428L	LIGHTING PLANS - NAVIGATION LIGHTING
429-430	OVERHEAD SIGN STRUCTURES - SIGN PANEL ELEVATIONS
431-432	OVERHEAD SIGN STRUCTURES - SIGN PANEL DETAILS
433-441	STRUCTURE PLANS - OHSS #1
442-454	STRUCTURE PLANS - OHSS #2
455-458	BRIDGE MOUNTED SIGN PLANS
459-496	STRUCTURE PLANS - SN 016-0159
497-532	STRUCTURE PLANS - SN 016-0158
533-558	STRUCTURE PLANS - SN 016-0160 WB
559-584	STRUCTURE PLANS - SN 016-0160 EB
585-611	STRUCTURE PLANS - SN 016-0161 NB
612-639	STRUCTURE PLANS - SN 016-0161 SB
640-664	STRUCTURE PLANS - SN 016-0914
665-683	STRUCTURE PLANS - SN 016-0162
684-698*	STRUCTURE PLANS - SN 016-0163
699-735**	STRUCTURE PLANS - SN 016-0388
735A	PAVEMENT PATCHING FOR HMA SURFACED PAVEMENT (BD-22)
736	FRAMES AND LIDS ADJUSTMENT WITH MILLING (BD-08)
737	BUTT JOINT AND HMA TAPER DETAILS (BD-32)
738	LIGHT POLE FOUNDATION (BE-300)
739	MISCELLANEOUS ELECTRICAL DETAILS (BE-702)
740	MISCELLANEOUS ELECTRICAL DETAILS (BE-703)
741	SUSPENDED MOUNT LED UNDERPASS LUMINAIRE INSTALLATION DETAILS (BE-901)
742	PIER/ABUTMENT MOUNTED LED UNDERPASS LUMINARE INSTALLATION DETAILS (BE-903)
743	ENTRANCE AND EXIT RAMP CLOSURE DETAILS (TC-08)
744	TRAFFIC CONTROL DETAILS FOR FREEWAY SINGLE & MULTI-LANE WEAVE (TC-09)
745	TYPICAL APPLICATIONS RAISED REFLECTIVE PAVEMENT MARKERS (SNOW PLOW RESISTANT) (TC-11)
746-747	MULTI-LANE FREEWAY PAVEMENT MARKING DETAILS (TC-12)
748	TYPICAL PAVEMENT MARKINGS (TC-13)
749	TRAFFIC CONTROL DETAILS FOR FREEWAY SHOULDER CLOSURES AND PARTIAL RAMP CLOSURES (TC-17)
750	FREEWAY / EXPRESSWAY SIGNING FOR FLAGGING OPERATIONS AT WORK ZONE OPENINGS ON FREEWAYS / EXPRESSWAYS (TC-18)

751	DETOUR SIGNING FOR CLOSING STATE HIGHWAYS (TC-21)
752	ARTERIAL ROAD INFO SIGN (TC-22)
752A	TRAFFIC CONTROL DETAILS FOR FREEWAY CENTER LANE CLOSURE, SHOULDER LANE (TC-25)
753	SMART TRAFFIC MONITORING SYSTEM TYPICAL LAYOUT (TC-33)
754-761	CROSS SECTIONS

***** INCLUDES SHEETS 177A AND 177B

**** INCLUDES SHEETS 389A - 389F

*** INCLUDES SHEETS 426A AND 427A

* INCLUDES SHEETS 693A AND 693B

** INCLUDES SHEETS 728A AND 728B

LIST OF HIGHWAY STANDARDS

STANDARD NO.

DESCRIPTION

000001-08	STANDARD SYMBOLS, ABBREVIATIONS AND PATTERNS
001006	DECIMAL OF AN INCH AND OF A FOOT
280001-07	TEMPORARY EROSION CONTROL SYSTEMS
420001-10	PAVEMENT JOINTS
420701-03	PAVEMENT WELDED WIRE REINFORCEMENT
442001-04	CLASS A PATCHES
442101-09	CLASS B PATCHES
442201-03	CLASS C AND D PATCHES
482001-02	HMA SHOULDER ADJACENT TO FLEXIBLE PAVEMENT
515001-04	NAME PLATE FOR BRIDGES
601001-05	PIPE UNDERDRAINS
601101-02	CONCRETE HEADWALL FOR PIPE UNDERDRAIN
602016-02	CATCH BASIN, TYPE D
602301-04	INLET - TYPE A
604091-05	FRAME AND GRATE TYPE 24
606001-08	CONCRETE CURB TYPE B AND COMBINATION CONCRETE CURB AND GUTTER
606301-04	PC CONCRETE ISLANDS AND MEDIANS
630001-13	STEEL PLATE BEAM GUARDRAIL
630301-09	SHOULDER WIDENING FOR TYPE 1 (SPECIAL) GUARDRAIL TERMINALS
631011-10	TRAFFIC BARRIER TERMINAL, TYPE 2
631026-06	TRAFFIC BARRIER TERMINAL, TYPE 5
631031-18	TRAFFIC BARRIER TERMINAL, TYPE 6
635001-02	DELINEATORS
637006-05	CONCRETE BARRIER DOUBLE FACE, 44 IN. (1120 MM) HEIGHT
642001-03	SHOULDER RUMBLE STRIPS, 16 IN.
664001-02	CHAIN LINK FENCE
701400-12	APPROACH TO LANE CLOSURE, FREEWAY/EXPRESSWAY
701401-13	LANE CLOSURE, FREEWAY/EXPRESSWAY
701402-12	LANE CLOSURE, FREEWAY/EXPRESSWAY, WITH BARRIER
701406-13	LANE CLOSURE, FREEWAY/EXPRESSWAY, DAY OPERATIONS ONLY
701411-09	LANE CLOSURE, MULTILANE, AT ENTRANCE OR EXIT RAMP, FOR SPEEDS > 45 MPH
701426-09	LANE CLOSURE, MULTILANE, INTERMITTENT OR MOVING OPERATION, FOR SPEEDS > 45 MPH
701427-05	LANE CLOSURE, MULTILANE INTERMITTENT OR MOVING OPER., FOR SPEED < 40 MPH
701428-01	TRAFFIC CONTROL, SETUP AND REMOVAL, FREEWAY/EXPRESSWAY
701446-11	TWO LANE CLOSURE, FREEWAY/EXPRESSWAY
701451-05	RAMP CLOSURE FREEWAY/EXPRESSWAY
701601-09	URBAN LANE CLOSURE, MULTILANE, 1W OR 2W WITH NONTRAVERSABLE MEDIAN
701606-10	URBAN LANE CLOSURE, MULTILANE 2W WITH MOUNTABLE MEDIAN
701611-01	URBAN HALF ROAD CLOSURE, MULTILANE, 2W WITH MOUNTABLE MEDIAN
701801-06	SIDEWALK, CORNER OR CROSSWALK CLOSURE
701901-10	TRAFFIC CONTROL DEVICES
704001-08	TEMPORARY CONCRETE BARRIER
725001-01	OBJECT AND TERMINAL MARKERS
780001-05	TYPICAL PAVEMENT MARKINGS
781001-04	TYPICAL APPLICATIONS RAISED REFLECTIVE PAVEMENT MARKERS
782006-01	GUARDRAIL AND BARRIER BARRIER WALL REFLECTOR MOUNTING DETAILS

COMMITMENTS

THE RESIDENT ENGINEER WILL CONTACT THE FOREST PRESERVE OF COOK COUNTY (FPCC) PRIOR TO THE START OF CONSTRUCTION TO INFORM THEM OF THE INITIATION OF CONSTRUCTION NEAR THEIR PROPERTIES OF BEAUBIEN WOODS.



USER NAME = hbmepw11cs01s	DESIGNED - KJD	REVISED - ADS 4/8/2025
	DRAWN - KJD	REVISED -
PLOT SCALE = 40.0000 ' / in.	CHECKED - RTB	REVISED -
PLOT DATE = 4/11/2025	DATE - 12/9/2024	REVISED -

STATE OF ILLINOIS
DEPARTMENT OF TRANSPORTATION

INDEX OF SHEETS AND HIGHWAY STANDARDS
I-94 (BISHOP FORD EXPY)

SCALE:	SHEET 1	OF 1	SHEETS	STA.	TO STA.
--------	---------	------	--------	------	---------

REVISED SHEET 4/14/2025

F.A.I. RTE.	SECTION	COUNTY	TOTAL SHEETS	SHEET NO.
94	(42-B-11-1) BR, BJR 24	COOK	761	3
		CONTRACT NO. 62W87		
ILLINOIS FED. AID PROJECT				

MODEL: Default
FILE NAME: hbmepw11cs01\CS.pdf, work_dir\2966\1451_13\0152\53-sh1-S00-012.dgn

				CONSTRUCTION CODE								
CODE NO.	ITEM	UNIT	TOTAL QUANTITY	90% FED 10% STATE	90% FED 10% STATE	90% FED 10% STATE	90% FED 10% STATE	90% FED 10% STATE	90% FED 10% STATE	90% FED 10% STATE	100% STATE	100% STATE
				ROADWAY URBAN	ROADWAY URBAN	BRIDGE URBAN	BRIDGE URBAN	OHSS URBAN	ITS URBAN	LIGHTING URBAN	PATCHING URBAN	DRAINAGE URBAN
				0005	0004	0059	0013	0044	0043	0021	0006	0043
78300202	PAVEMENT MARKING REMOVAL - WATER BLASTING	SQ FT	767628	767628								
* 81028200	UNDERGROUND CONDUIT, GALVANIZED STEEL, 2" DIA.	FOOT	2436						2436			
* 81028240	UNDERGROUND CONDUIT, GALVANIZED STEEL, 4" DIA.	FOOT	1347						1347			
* 81028350	UNDERGROUND CONDUIT, PVC, 2" DIA.	FOOT	24							24		
* 81028750	UNDERGROUND CONDUIT, COILABLE NONMETALLIC CONDUIT, 2" DIA.	FOOT	1370						1370			
* 81100320	CONDUIT ATTACHED TO STRUCTURE, 1" DIA., PVC COATED GALVANIZED STEEL	FOOT	2381							2381		
* 81101005	CONDUIT ATTACHED TO STRUCTURE, 4" DIA., PVC COATED GALVANIZED STEEL	FOOT	762						762			
* 81300220	JUNCTION BOX, STAINLESS STEEL, ATTACHED TO STRUCTURE, 6" X 6" X 4"	EACH	22							22		
* 81300310	JUNCTION BOX, STAINLESS STEEL, ATTACHED TO STRUCTURE, 8" X 6" X 4"	EACH	11							11		
* 81300420	JUNCTION BOX, STAINLESS STEEL, ATTACHED TO STRUCTURE, 10" X 8" X 6"	EACH	9							9		
* 81300830	JUNCTION BOX, STAINLESS STEEL, ATTACHED TO STRUCTURE, 18" X 18" X 8"	EACH	4							4		
* 81300945	JUNCTION BOX, STAINLESS STEEL, ATTACHED TO STRUCTURE, 24" X 24" X 8"	EACH	8						8			
* 81400200	HEAVY-DUTY HANDHOLE	EACH	11						11			
* 81603081	UNIT DUCT, 600V, 3-1C NO.2, 1/C NO.4 GROUND, (XLP-TYPE USE), 1 1/2" DIA. POLYETHYLENE	FOOT	310							310		
* 81702110	ELECTRIC CABLE IN CONDUIT, 600V (XLP-TYPE USE) 1/C NO. 10	FOOT	6541							6541		
* 81702120	ELECTRIC CABLE IN CONDUIT, 600V (XLP-TYPE USE) 1/C NO. 8	FOOT	3792						3792			
* 81702130	ELECTRIC CABLE IN CONDUIT, 600V (XLP-TYPE USE) 1/C NO. 6	FOOT	6258						6258			
* 81702140	ELECTRIC CABLE IN CONDUIT, 600V (XLP-TYPE USE) 1/C NO. 4	FOOT	276						276			
* 81702150	ELECTRIC CABLE IN CONDUIT, 600V (XLP-TYPE USE) 1/C NO. 2	FOOT	92						92			

* SPECIALTY ITEM

 REVISED SHEET 4/14/2025



USER NAME = hbmepw11cs01\$	DESIGNED - AMI	REVISED -
	DRAWN - AMI	REVISED -
PLOT SCALE = 40.0000 ' / in.	CHECKED - RTB	REVISED -
PLOT DATE = 3/20/2025	DATE - 12/9/2024	REVISED -

STATE OF ILLINOIS
DEPARTMENT OF TRANSPORTATION

SUMMARY OF QUANTITIES
I-94 (BISHOP FORD EXPY)

SCALE: SHEET 12 OF 20 SHEETS STA. TO STA.

F.A.I. RTE.	SECTION	COUNTY	TOTAL SHEETS	SHEET NO.
94	(42-B-11-1) BR, BJR 24	COOK	761	16
CONTRACT NO. 62W87				
ILLINOIS FED. AID PROJECT				

MODEL: Default
FILE NAME: hbmepw11cs01\CS.pdf, work_dir\2958\1451_14\DI\EX\53-sh1-S00-013.dgn

CODE NO.	ITEM	UNIT	TOTAL QUANTITY	CONSTRUCTION CODE								
				90% FED 10% STATE	90% FED 10% STATE	90% FED 10% STATE	90% FED 10% STATE	90% FED 10% STATE	90% FED 10% STATE	90% FED 10% STATE	100% STATE	100% STATE
				ROADWAY URBAN	ROADWAY URBAN	BRIDGE URBAN	BRIDGE URBAN	OHSS URBAN	ITS URBAN	LIGHTING URBAN	PATCHING URBAN	DRAINAGE URBAN
				0005	0004	0059	0013	0044	0043	0021	0006	0043
*	81702450	ELECTRIC CABLE IN CONDUIT, 600V (XLP-TYPE USE) 3-1/C NO. 10	FOOT	885						885	1	
*	81800330	AERIAL CABLE, 3-1/C NO. 6 WITH MESSENGER WIRE	FOOT	100						100		
*	82110022	LUMINAIRE, LED, UNDERPASS, WALLMOUNT, OUTPUT DESIGNATION E	EACH	8						8		
*	82110026	LUMINAIRE, LED, UNDERPASS, SUSPENDED, OUTPUT DESIGNATION D	EACH	16						16		
*	82200606	WATERWAY OBSTRUCTION WARNING LUMINAIRE, LED, 180 DEGREE RED, PARAPET MOUNTED	EACH	6						6		
*	82200609	WATERWAY OBSTRUCTION WARNING LUMINAIRE, LED, 360 DEGREE GREEN	EACH	2						2		
*	82600106	OBSTRUCTION WARNINGLIGHTINGCONTROLLER	EACH	1						1		
*	83600200	LIGHT POLE FOUNDATION, 24" DIAMETER	FOOT	12						12		
*	83600352	LIGHT POLE FOUNDATION, METAL, 11 1/2" BOLT CIRCLE, 8 5/8" X 6'	EACH	24					24			
*	83800105	BREAKAWAY DEVICE, TRANSFORMER BASE, 11.5 INCH BOLT CIRCLE	EACH	2						2		
*	84200804	REMOVAL OF POLE FOUNDATION	EACH	2						2		
*	84400105	RELOCATE EXISTING LIGHTING UNIT	EACH	2						2		
*	86300300	CONTROLLER CABINET TYPE III	EACH	7					7			
*	87300901	ELECTRIC CABLE IN CONDUIT, TRACER, NO. 12 1C	FOOT	3797					3797			
*	87800200	CONCRETE FOUNDATION, TYPE D	FOOT	2					2			
*	87900100	DRILL EXISTING FOUNDATION	EACH	4					4			
*	87900205	DRILL EXISTING HEAVY DUTY HANDHOLE	EACH	11					11			
*	89500510	CABINET HOUSING EQUIPMENT REMOVAL	EACH	1					1			
*	89502300	REMOVE ELECTRIC CABLE FROM CONDUIT	FOOT	37028					32773	4255		

* SPECIALTY ITEM

1

REVISED SHEET 4/14/2025



USER NAME = hbmepw11cs01\$	DESIGNED - AMI	REVISED -
DRAWN - AMI	REVIS	ED -
PLOT SCALE = 40.0000 ' / in.	CHECKED - RTB	REVISED -
PLOT DATE = 3/19/2025	DATE - 12/9/2024	REVISED -

STATE OF ILLINOIS
DEPARTMENT OF TRANSPORTATION

SUMMARY OF QUANTITIES
I-94 (BISHOP FORD EXPY)

SCALE: SHEET 13 OF 20 SHEETS STA. TO STA.

F.A.I. RTE.	SECTION	COUNTY	TOTAL SHEETS	SHEET NO.
94	(42-B-11-1) BR, BJR 24	COOK	761	17
CONTRACT NO. 62W87				
ILLINOIS FED. AID PROJECT				

MODEL: Default
FILE NAME: hbmesw11cs01\CS.pdf, work_dir\2969\1451_26\01\EXK53-shl-S00-017.dgn

CODE NO.	ITEM	UNIT	TOTAL QUANTITY	CONSTRUCTION CODE								
				90% FED 10% STATE	90% FED 10% STATE	90% FED 10% STATE	90% FED 10% STATE	90% FED 10% STATE	90% FED 10% STATE	90% FED 10% STATE	100% STATE	100% STATE
				ROADWAY URBAN	ROADWAY URBAN	BRIDGE URBAN	BRIDGE URBAN	OHSS URBAN	ITS URBAN	LIGHTING URBAN	PATCHING URBAN	DRAINAGE URBAN
				0005	0004	0059	0013	0044	0043	0021	0006	0043
X6420100	SHOULDER RUMBLE STRIP REMOVAL	SQ YD	21120	21120								
X6640304	CHAIN LINK FENCE TO BE REMOVED AND RE-ERECTED	FOOT	400	400								
X7010118	TEMPORARY RUMBLE STRIPS (SPECIAL)	EACH	120	120								
X7010216	TRAFFIC CONTROL AND PROTECTION, (SPECIAL)	L SUM	1	1								
X7011015	TRAFFIC CONTROL AND PROTECTION (EXPRESSWAYS)	L SUM	1	1								
X7013820	TRAFFIC CONTROL SURVEILLANCE, EXPRESSWAYS	CAL DA	992	992								
X7040650	REMOVE TEMPORARY CONCRETE BARRIER	FOOT	438	438								
X7200061	TEMPORARY INFORMATION SIGNING	SQ FT	582	582								
X7200203	DETOUR SIGNING	L SUM	1	1								
X7830050	RAISED REFLECTIVE PAVEMENT MARKER, REFLECTOR REMOVAL	EACH	17760	17760								
* X7830052	RAISED REFLECTIVE PAVEMENT MARKER, REFLECTOR REPLACEMENT	EACH	17760	17760								
* X8000003	MAINTENANCE OF LIGHTING SYSTEM	CAL MO	12							12		
* X8050204	REMOVE ELECTRIC SERVICE	EACH	3						3			
* X8100863	INTERCEPT EXISTING CONDUIT	EACH	9						9			
* X8101095	UNDERGROUND CONDUIT, MULTI-DUCT, 4-18MM MICRODUCTS	FOOT	27606						27606			
* X8130112	JUNCTION BOX TYPE J	EACH	1						1			
* X8130125	REMOVE EXISTING JUNCTION BOX	EACH	46							46		
* X8210003	LUMINAIRE, LED, ROADWAY, REPLACEMENT, OUTPUT DESIGNATION G	EACH	129							129		
X8210007	LUMINAIRE, LED, ROADWAY, REPLACEMENT, OUTPUT DESIGNATION H	EACH	112							112		
* X8211002	PROTECT AND MAINTAIN EXISTING UNDERPASS LUMINAIRE	L SUM	1							1		



* SPECIALTY ITEM

REVISED SHEET 4/14/2025



USER NAME = hbmeprw11cs01\$	DESIGNED - AMI	REVISED -
	DRAWN - AMI	REVISED -
PLOT SCALE = 40.0000 ' / in.	CHECKED - RTB	REVISED -
PLOT DATE = 3/20/2025	DATE - 12/9/2024	REVISED -

STATE OF ILLINOIS
DEPARTMENT OF TRANSPORTATION

SUMMARY OF QUANTITIES
I-94 (BISHOP FORD EXPY)

SCALE: SHEET 17 OF 20 SHEETS STA. TO STA.

F.A.I. RTE.	SECTION	COUNTY	TOTAL SHEETS	SHEET NO.
94	(42-B-11-1) BR, BJR 24	COOK	761	21
CONTRACT NO. 62W87				
ILLINOIS FED. AID PROJECT				

MODEL: Default
FILE NAME: hbmepw11cs01\CS.pdf work dir\28271450_19\0162K53-sh-BridgeSchedule1.dgn

CODE NO.	ITEM	UNIT	TOTAL QUANTITY	STRUCTURE NUMBER									
				016-0159 (WB)	016-0158 (EB)	016-0160 (WB)	016-0160 (EB)	016-0161 (WB)	016-0161 (EB)	016-0914	016-0162	016-0163	016-0388
20700220	POROUS GRANULAR EMBANKMENT	CU YD	226			1	1	10	1	2	211		
50101500	REMOVAL OF EXISTING SUPERSTRUCTURES	EACH	1										1
50102400	CONCRETE REMOVAL	CU YD	307.9	52	52	33.2	32.6	18.2	18.2	17	32	32	20.7
50104650	SLOPE WALL REMOVAL	SQ YD	193					29	2	3	159		
50157300	PROTECTIVE SHIELD	SQ YD	14867	2859	2594	1921	1921	529	529	758	1114	1354	1288
50300225	CONCRETE STRUCTURES	CU YD	146.6							1	9	9	127.6
50300255	CONCRETE SUPERSTRUCTURE	CU YD	1234.4	50	58	37.3	36.9	18.2	18.2	17.2	23	23	952.6
50300260	BRIDGE DECK GROOVING	SQ YD	2368										2368
50300300	PROTECTIVE COAT	SQ YD	26411	5532	5532	3099	3120	203	203	1443	10	4085	3184
50301350	CONCRETE SUPERSTRUCTURE (APPROACH SLAB)	CU YD	253.8										253.8
50500105	FURNISHING AND ERECTING STRUCTURAL STEEL	L SUM	1										1
50500405	FURNISHING AND ERECTING STRUCTURAL STEEL	POUND	25250	9300	10120					5830			
50500505	STUD SHEAR CONNECTORS	EACH	14574										14574
50606701	CLEANING AND PAINTING STRUCTURAL STEEL, LOCATION 1	L SUM	1		1								
50606702	CLEANING AND PAINTING STRUCTURAL STEEL, LOCATION 2	L SUM	1	1									
50800205	REINFORCEMENT BARS, EPOXY COATED	POUND	441010	9560	9560	5020	5050	3150	3150	2630	5950	5590	391350
50800515	BAR SPLICERS	EACH	1592	114	114	48	48	32	32	26	64	64	1050
50901730	BRIDGE FENCE RAILING	FOOT	524										524
51100100	SLOPE WALL 4 INCH	SQ YD	193					29	2	3	159		
51500100	NAME PLATES	EACH	2										2
52000030	PREFORMED JOINT SEAL 2 1/2"	FOOT	581				414	167					
52000110	PREFORMED JOINT STRIP SEAL	FOOT	2146	330	330	210	210	120	124	124	267	247	184
52000600	FABRIC REINFORCED ELASTOMERIC TROUGH	FOOT	112	56	56								
52100010	ELASTOMERIC BEARING ASSEMBLY, TYPE I	EACH	56										56
52100020	ELASTOMERIC BEARING ASSEMBLY, TYPE II	EACH	20							20			
52100520	ANCHOR BOLTS, 1"	EACH	193						1	80			112
52100530	ANCHOR BOLTS, 1 1/4"	EACH	28										28
58700300	CONCRETE SEALER	SQ FT	19939	4378	3636	4189	4241	942	928				1625
59000200	EPOXY CRACK INJECTION	FOOT	787			16	36	44	30	259	217	38	147
59200101	BRIDGE WASHING NO. 1	EACH	1		1								
59200102	BRIDGE WASHING NO. 2	EACH	1	1									
66400205	CHAIN LINK FENCE, 5'	FOOT	5			5							
X0322559	BOLT REPLACEMENT	EACH	2				2						
X0323491	SLOPE WALL CRACK SEALING	FOOT	427			84	50	139	154				
X5030250	BRIDGE DECK GROOVING (LONGITUDINAL)	SQ YD	13750	3172	3172	2217	2217					2972	

1



USER NAME = hbmepw11cs01\$	DESIGNED - KJD	REVISED -
	DRAWN - KJD	REVISED -
PLOT SCALE = 40.0000 ' / in.	CHECKED - LAB	REVISED -
PLOT DATE = 3/11/2025	DATE - 12/9/2024	REVISED -

STATE OF ILLINOIS
DEPARTMENT OF TRANSPORTATION

BRIDGE STRUCTURES SCHEDULE OF QUANTITIES
I-94 (BISHOP FORD EXPY)

SCALE: SHEET 1 OF 2 SHEETS STA. TO STA.

1 REVISED SHEET 4/14/2025

F.A.I. RTE.	SECTION	COUNTY	TOTAL SHEETS	SHEET NO.
94	(42-B-11-1) BR, BJR 24	COOK	761	24
CONTRACT NO. 62W87				
(ILLINOIS { FED. AID PROJECT				

MODEL: Default
FILE NAME: hbmepw11cs01\CS.pdf work_drf2828\1450_200162003-sh-BridgeSchedule2.dgn

				STRUCTURE NUMBER									
CODE NO.	ITEM	UNIT	TOTAL QUANTITY	016-0159 (WB)	016-0158 (EB)	016-0160 (WB)	016-0160 (EB)	016-0161 (WB)	016-0161 (EB)	016-0914	016-0162	016-0163	016-0388
X5060601	CONTAINMENT AND DISPOSAL OF NON-LEAD PAINT CLEANING RESIDUES NO. 1	L SUM	1		1								
X5060602	CONTAINMENT AND DISPOSAL OF NON-LEAD PAINT CLEANING RESIDUES NO. 2	L SUM	1	1									
X5080530	BAR TERMINATORS	EACH	156										156
X5230140	BRIDGE DRAINAGE SYSTEM	EACH	1									1	
X5230162	DECK DRAIN EXTENSIONS	EACH	88	28	28	16	16						
X6050184	PLUG EXISTING FLOOR DRAINS	EACH	8									8	
Z0001700	APPROACH SLAB REPAIR (FULL DEPTH)	SQ YD	8								7	1	
Z0001800	APPROACH SLAB REPAIR (PARTIAL DEPTH)	SQ YD	53									53	
Z0001899	JACK AND REMOVE EXISTING BEARINGS	EACH	20							20			
X5051204	STRUCTURAL STEEL REMOVAL	POUND	5710	280						5430			
X5051206	STRUCTURAL STEEL REPAIR	POUND	13560	410					190	10650	2010	300	
Z0003600	BEAM STRAIGHTENING	L SUM	1					0.33	0.33	0.34			
Z0004552	APPROACH SLAB REMOVAL	SQ YD	409										409
Z0006016	BRIDGE DECK LATEX CONCRETE OVERLAY, 2 3/4 INCHES	SQ YD	3333									3333	
Z0006018	BRIDGE DECK LATEX CONCRETE OVERLAY, 3 INCHES	SQ YD	14177	4471	4472	2617	2617						
Z0010400	CLEANING BRIDGE SEATS	SQ FT	2912								1566	1346	
X5230152	CLEANING DRAINAGE SYSTEM	L SUM	1	0.33	0.33					0.34			
Z0010615	CLEANING EXISTING INLETS	EACH	40									40	
Z0012102	CONCRETE BRIDGE DECK SCARIFICATION 3/8 INCH	SQ YD	7374					1042	1042	1430	3860		
Z0012130	BRIDGE DECK SCARIFICATION 3/4"	SQ YD	14177	4471	4472	2617	2617						
Z0012144	BRIDGE DECK SCARIFICATION 2 1/2"	SQ YD	3333									3333	
Z0012193	BRIDGE DECK THIN POLYMER OVERLAY 3/8"	SQ YD	7374					1042	1042	1430	3860		
Z0012754	STRUCTURAL REPAIR OF CONCRETE (DEPTH EQUAL TO OR LESS THAN 5 INCHES)	SQ FT	3410	140	847	160	268	79	93	679	872	65	207
Z0012755	STRUCTURAL REPAIR OF CONCRETE (DEPTH GREATER THAN 5 INCHES)	SQ FT	77			19	3	9		46			
Z0016001	DECK SLAB REPAIR (FULL DEPTH, TYPE I)	SQ YD	67.1	0.5	0.5		0.1			1	6	59	
Z0016002	DECK SLAB REPAIR (FULL DEPTH, TYPE II)	SQ YD	265	12							158	95	
Z0016200	DECK SLAB REPAIR (PARTIAL)	SQ YD	305						46	4	255		
X5230176	DRAINAGE SCUPPERS, DS-12	EACH	8										8
X5230172	DRAINAGE SCUPPERS TO BE ADJUSTED	EACH	60	28	28	2	2						
Z0021400	EXPANSION JOINT (SPECIAL)	FOOT	584								313	271	
Z0029090	DIAMOND GRINDING (BRIDGE SECTION)	SQ YD	16850	4262	4263	2511	2511					3303	
Z0073200	TEMPORARY SHORING AND CRIBBING	EACH	33	2	4	2	2			23			



USER NAME = hbmepw11cs01\$	DESIGNED - KJD	REVISED -
	DRAWN - KJD	REVISED -
PLOT SCALE = 40.0000 ' / in.	CHECKED - LAB	REVISED -
PLOT DATE = 3/11/2025	DATE - 12/9/2024	REVISED -

STATE OF ILLINOIS
DEPARTMENT OF TRANSPORTATION

BRIDGE STRUCTURES SCHEDULE OF QUANTITIES
I-94 (BISHOP FORD EXPY)

SCALE: SHEET 2 OF 2 SHEETS STA. TO STA.

REVISED SHEET 4/14/2025

F.A.I. RTE.	SECTION	COUNTY	TOTAL SHEETS	SHEET NO.
94	(42-B-11-1) BR, BJR 24	COOK	761	25
			CONTRACT NO. 62W87	
ILLINOIS FED. AID PROJECT				

Lighting and Electrical Legend

SYMBOL	DESCRIPTION
	PROPOSED RED NAVIGATIONAL LIGHT, LED, 180°
	PROPOSED GREEN NAVIGATIONAL LIGHT, LED, 360°
	EXISTING NAVIGATIONAL LIGHTING TO BE REMOVED
	RELOCATE LIGHT POLE UNIT ON PROPOSED CONCRETE FOUNDATION. LUMINAIRE, LED, ROADWAY, REPLACEMENT, OUTPUT DESIGNATION G.
	EXISTING ROADWAY LIGHTING UNIT WITH LED LUMINAIRE TO REMAIN
	EXISTING ROADWAY LIGHTING POLE TO REMAIN, REPLACE HPS LUMINAIRE WITH LUMINAIRE, LED, ROADWAY, REPLACEMENT, OUTPUT DESIGNATION G.
	EXISTING ROADWAY LIGHTING POLE TO REMAIN, REPLACE HPS LUMINAIRE WITH LUMINAIRE, LED, ROADWAY, REPLACEMENT, OUTPUT DESIGNATION H
	EXISTING ROADWAY TWIN LIGHTING POLE TO REMAIN, REPLACE HPS LUMINAIRES WITH LUMINAIRE, LED, ROADWAY, REPLACEMENT, OUTPUT DESIGNATION H
	PROPOSED LED SUSPENDED UNDERPASS LUMINAIRE, LED, SUSPENDED, OUTPUT DESIGNATION D, 240 V
	PROPOSED LED UNDERPASS LUMINAIRE, LED, PIER MOUNTED, OUTPUT DESIGNATION E, 240 V
	EXISTING UNDERPASS LUMINAIRE TO BE REMOVED
	EXISTING UNDERPASS LUMINAIRE TO REMAIN
	PROPOSED CABLE AND CONDUIT, TYPE AND SIZE AS SPECIFIED
	EXISTING UNIT DUCT TO REMAIN
	EXISTING AERIAL CABLE TO REMAIN
	EXISTING CABLE AND CONDUIT TO BE REMOVED
	PROPOSED OBSTRUCTION WARNING CONTROLLER
	EXISTING CONTROLLER CABINET TO BE REMOVED
	EXISTING LIGHTING CONTROLLER TO REMAIN
	EXISTING ELECTRIC SERVICE LOCATION
	PROPOSED JUNCTION BOX, STAINLESS STEEL, ATTACHED TO STRUCTURE, SIZE AS SPECIFIED
	EXISTING JUNCTION BOX TO BE REMOVED
	EXISTING JUNCTION BOX TO REMAIN

IDOT DISTRICT 1 STANDARD DETAIL

BE-300	LIGHTPOLE FOUNDATION 30' TO 35' M.H. 11 1/2" BOLT CIRCLE
BE-702	MISC. ELECTRICAL DETAILS, SHEET A
BE-703	MISC. ELECTRICAL DETAILS, SHEET B
BE-901	SUSPENDED MOUNT LED UNDERPASS LUMINAIRE INSTALLATION DETAILS
BE-903	PIER / ABUTMENT MOUNTED LED UNDERPASS, LUMINAIRE INSTALLATION DETAILS

ABBREVIATIONS

ABBREVIATION	DESCRIPTION
AC	ALTERNATING CURRENT
A/C	AERIAL CABLE
B.O.C.	BACK OF CURB
CB	CIRCUIT BREAKER
CKT	CIRCUIT
CM	CENTIMETER
COMED	COMMONWEALTH EDISON COMPANY
CP	CONTROL PANEL
CT	CURRENT TRANSFORMER
DA	DAVIT ARM
DC	DIRECT CURRENT
DIA	DIAMETER
DP	DISTRIBUTION PANEL
E	EXISTING UNIT TO REMAIN
EX.	EXISTING
ECA	ELECTRIC CABLE ASSEMBLY
E.O.P.	EDGE OF PAVEMENT
F.O.C.	FACE OF CURB
FT	FEET OR FOOT
FU	FUSE
GND	GROUND
HID	HIGH INTENSITY DISCHARGE
HPS	HIGH PRESSURE SODIUM
JB	JUNCTION BOX
KVA	KILOVOLT-AMPERE
KW	KILOWATTS
LED	LIGHT EMITTING DIODE
LP	LIGHT POLE
LTFM	LIQUID TIGHT FLEXIBLE METALLIC
LPS	LOW PRESSURE SODIUM
M	METER
MA	MAST ARM
MC	MULTI-CONDUCTOR
MM	MILLIMETER
M.H.	MOUNTING HEIGHT
MW	MESSANGER WIRE
NO. #	NUMBER
N.T.S.	NOT TO SCALE
P	PROPOSED
PB	PUSH BUTTON
PNL	PANEL
PVC	POLYVINYL CHLORIDE
PVCC RGC	PVC COATED RIGID GALVANIZED CONDUIT
PT	POTENTIAL TRANSFORMER
R	EXISTING UNIT TO BE REMOVED (OWNER SALVAGED U.N.O.)
RR	EXISTING UNIT TO BE REMOVED AND REINSTALLED
RECP	RECEPTACLE
RGC	RIGID GALVANIZED CONDUIT
SEL SW	SELECTOR SWITCH
SPARE	SPARE
SPACE	SPACE
SS	STAINLESS STEEL
STA	STATION
XFMR	TRANSFORMER
UD	UNIT DUCT
U.N.O.	UNLESS NOTED OTHERWISE
UGC, GS	UNDERGROUND CONDUCT, GALVANIZED STEEL
V	VOLTS
W	WATTS
WP	WOOD POLE


BILL OF MATERIALS

SP	ITEM DESCRIPTION	UNIT	QUANTITY
	UNDERGROUND CONDUIT, PVC, 2" DIA.	FOOT	24
	CONDUIT ATTACHED TO STRUCTURE, 1" DIA., PVC COATED GALVANIZED STEEL	FOOT	2381
	JUNCTION BOX, STAINLESS STEEL, ATTACHED TO STRUCTURE, 6" X 6" X 4"	EACH	22
	JUNCTION BOX, STAINLESS STEEL, ATTACHED TO STRUCTURE, 8" X 6" X 4"	EACH	11
	JUNCTION BOX, STAINLESS STEEL, ATTACHED TO STRUCTURE, 10" X 8" X 6"	EACH	9
	JUNCTION BOX, STAINLESS STEEL, ATTACHED TO STRUCTURE, 18" X 18" X 8"	EACH	4
	UNIT DUCT, 600V, 3-1C NO.2, 1/C NO.4 GROUND, (XLP-TYPE USE), 1 1/2" DIA. POLYETHYLENE	FOOT	310
	ELECTRIC CABLE IN CONDUIT, 600V (XLP-TYPE USE) 1/C NO. 10	FOOT	6541
	ELECTRIC CABLE IN CONDUIT, 600V (XLP-TYPE USE) 3-1/C NO. 10	FOOT	885
	AERIAL CABLE, 3-1/C NO. 6 WITH MESSENGER WIRE	FOOT	100
	LUMINAIRE, LED, UNDERPASS, WALLMOUNT, OUTPUT DESIGNATION E	EACH	8
	LUMINAIRE, LED, UNDERPASS, SUSPENDED, OUTPUT DESIGNATION D	EACH	16
*	WATERWAY OBSTRUCTION WARNING LUMINAIRE, LED, 180 DEGREE RED, PARAPET MOUNTED	EACH	6
*	WATERWAY OBSTRUCTION WARNING LUMINAIRE, LED, 360 DEGREE GREEN, PARAPET MOUNTED	EACH	2
	OBSTRUCTION WARNING LIGHTING CONTROLLER	EACH	1
	LIGHT POLE FOUNDATION, 24" DIAMETER	FOOT	12
	BREAKAWAY DEVICE, TRANSFORMER BASE, 11.5 INCH BOLT CIRCLE	EACH	2
	REMOVAL OF POLE FOUNDATION	EACH	2
	RELOCATE EXISTING LIGHTING UNIT	EACH	2
	REMOVE ELECTRIC CABLE FROM CONDUIT	FOOT	4255
*	REMOVAL OF LIGHTING LUMINAIRE, SALVAGE	EACH	241
*	REMOVE EXISTING JUNCTION BOX	EACH	46
*	REMOVAL OF EXISTING NAVIGATIONAL LIGHTING	FOOT	8
*	REMOVAL OF LUMINAIRE, NO SALVAGE, UNDERPASS	EACH	24
*	REMOVE EXISTING CONDUIT ATTACHED TO STRUCTURE	FOOT	2385
*	REMOVE EXISTING CONTROLLER	EACH	1
*	REMOVE EXISTING UNDERGROUND CONDUIT	FOOT	24
*	LUMINAIRE, LED, ROADWAY, REPLACEMENT, OUTPUT DESIGNATION G	EACH	129
*	LUMINAIRE, LED, ROADWAY, REPLACEMENT, OUTPUT DESIGNATION H	EACH	112
*	MAINTENANCE OF LIGHTING SYSTEM	CAL MO	12

Lighting General Notes

- ELECTRIC CABLE IN EXISTING UNIT DUCT OR CONDUIT AND JUNCTION BOXES AT EACH UNDERPASS LOCATION SHALL BE REMOVED AND PAID FOR AS "REMOVE ELECTRIC CABLE FROM CONDUIT." ALL EXISTING LUMINAIRES, JUNCTION BOXES, CONDUITS AND CABLES FOR UNDERPASS LIGHTING SHALL BE REMOVED.
- THERE ARE LOCATIONS WHERE EXISTING ROADWAY LUMINAIRES AND UNDERPASS LUMINAIRES ALONG THE ROADWAY AND RAMP ARE ON THE SAME CIRCUIT. THE EXITING LUMINAIRES SHALL BE PLACE WITH NO INTERRUPTION TO THE LIGHTING FROM DUSK TO DAWN.
- LIGHTING SYSTEM INSTALLATION SHALL CONFORM TO THE LATEST IDOT STANDARDS AND NEC.
- ALL ELECTRICAL EQUIPMENT AND PRODUCT SHALL BE LISTED AND LABELED.
- THE EXISTING HPS ROADWAY LUMINAIRES TO BE REMOVED SHALL BE SALVAGED TO THE STATE, AND 55W LPS UNDERPASS LUMINAIRES TO BE REMOVED SHALL NOT BE SALVAGED.
- THE REMOVAL AND REPLACEMENT OF LUMINAIRES SHALL BE SUCH THAT LIGHTING IS PROVIDED EACH NIGHT FROM DUSK TO DAWN.
- THE NEW LED LUMINAIRES SHALL HAVE THE SAME ORIENTATION AS THE HPS LUMINAIRES THEY ARE REPLACING.
- SPlicing AND RECONNECTION OF THE NEW LED LUMINAIRES ARE INCLUDED IN THE COST OF THE LUMINAIRES PAY ITEMS.

CALL-OUT SAMPLE

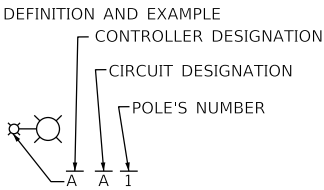

PROPOSED/EXISTING LIGHTING UNIT

REVISD SHEET 4/14/2025

MODEL Default
FILE Name: W:\mesaw\11cs01\CS_def.dwg
Title: 745 McCintock Drive
Suite 210
Burr Ridge, IL 60527
Ph. 773-451-4788
www.abnaincorp.com



USER NAME = hbmeprw11cs01s	DESIGNED - FPE	REVISED - 4/8/2025 LNK
	DRAWN - LNK	REVISED -
PLOT SCALE = 100.0000 ' / in.	CHECKED - JMO	REVISED -
PLOT DATE = 4/10/2025	DATE - 01/22/2025	REVISED -

STATE OF ILLINOIS
DEPARTMENT OF TRANSPORTATION

LIGHTING PLAN GENERAL NOTES AND BILL OF MATERIALS
I-94 (BISHOP FORD EXPY)

SCALE: SHEET 1 OF 1 SHEETS STA. TO STA.

F.A.I. RTE.	SECTION	COUNTY	TOTAL SHEETS	SHEET NO.
94	(42-B-11-1) BR, BJR 24	COOK	761	398
CONTRACT NO. 62W87				
ILLINOIS FED. AID PROJECT				

MODEL Default
FILE Name: \\homesw1\lcs01\lcs_pof_work_dir\30204\1468_210DD\62K53-cht-light-S00-01.dgn

LIGHTING SCHEDULE (1 OF 4)									
ROADWAY	REFERENCE ALIGNMENT	STATION	OFFSET	LIGHT POLE NUMBER	X8210003	X8210007	83600200	84400105	83800105
					LUM LED RDWY ROD G	LUM LED RDWY ROD H	LIGHT POLE FDN 24D	RELOC EX LT UNIT	BKWY DEV TR B 11.5BC
					EACH	EACH	FOOT	EACH	EACH
Mainline I-94	Ex CL I-94	448+94.2900 R1	-60.29	XB14		1			
Mainline I-94	Ex CL I-94	448+94.5200 R1	58.5	XA10		1			
Mainline I-94	Ex CL I-94	450+93.3975 R1	-59.6494	XA14	1				
Mainline I-94	Ex CL I-94	450+93.6286 R1	59.1214	XB10	1				
Mainline I-94	Ex CL I-94	452+58.0148 R1	59.5273	XA11	1				
Mainline I-94	Ex CL I-94	452+58.0148 R1	-59.3111	XB15	1				
Mainline I-94	Ex CL I-94	453+98.5153 R1	-59.3111	XA15	1				
Mainline I-94	Ex CL I-94	453+98.9458 R1	59.5273	XB11	1				
Mainline I-94	Ex CL I-94	455+39.8734 R1	59.5273	XA12	1				
Mainline I-94	Ex CL I-94	455+39.8734 R1	-59.3111	XB16	1				
Mainline I-94	Ex CL I-94	457+01.4870 R1	59.5273	XB12		1			
Mainline I-94	Ex CL I-94	457+05.0979 R1	-59.3111	XA16		1			
Mainline I-94	Ex CL I-94	460+04.4912 R1	0.388	HA10 & HB10		2			
Mainline I-94	Ex CL I-94	462+11.8942 R1	0.6207	HA9 & HB9		2			
Mainline I-94	Ex CL I-94	464+23.0248 R1	0.9115	HA8 & HB8		2			
Mainline I-94	Ex CL I-94	466+32.9976 R1	0.8135	HA7 & HB7		2			
Mainline I-94	Ex CL I-94	468+27.9106 R1	0.8955	HA6 & HB6		2			
Mainline I-94	Ex CL I-94	470+40.4869 R1	1.3143	HA5 & HB5		2			
Mainline I-94	Ex CL I-94	472+54.6510 R1	1.3925	HA4 & HB4		2			
Mainline I-94	Ex CL I-94	474+64.2189 R1	1.558	HA3 & HB3		2			
Mainline I-94	Ex CL I-94	476+64.9444 R1	1.8001	HA2 & HB2		2			
Mainline I-94	Ex CL I-94	478+76.8554 R1	1.6095	HA1 & HB1		2			
Mainline I-94	Ex CL I-94	480+78.0269 R1	1.4955	HC1 & HD1		2			
Mainline I-94	Ex CL I-94	482+77.7944 R1	1.185	HC2 & HD2		2			
Mainline I-94	Ex CL I-94	484+82.3205 R1	0.759	HC3 & HD3		2			
Mainline I-94	Ex CL I-94	485+67.6912 R1	-64.7823	HG19		1			
Mainline I-94	Ex CL I-94	485+71.2346 R1	67.75	HH15		1			
Mainline I-94	Ex CL I-94	487+65.8977 R1	64.2687	HG15		1			
Mainline I-94	Ex CL I-94	487+66.8281 R1	-61.5379	HH19		1			
Mainline I-94	Ex CL I-94	489+63.0839 R1	63.5562	HH16		1			
Mainline I-94	Ex CL I-94	489+64.5533 R1	-60.7613	HG18		1			
Mainline I-94	Ex CL I-94	491+44.2755 R1	65.3487	HG16		1			
Mainline I-94	Ex CL I-94	491+45.7500 R1	-62.1518	HH18		1			
Mainline I-94	Ex CL I-94	493+38.9399 R1	-63.4733	HG17		1			
Mainline I-94	Ex CL I-94	493+39.5548 R1	66.4145	HH17		1			
Mainline I-94	Ex CL I-94	494+16.4657 R1	0.0135	HG9 & HH9		2			
Mainline I-94	Ex CL I-94	496+93.5008 R1	0.915	HG10 & HH10		2			
Mainline I-94	Ex CL I-94	499+67.9035 R1	0.7844	HG11 & HH11		2			
Mainline I-94	Ex CL I-94	502+50.7669 R1	0.5317	HG12 & HH12		2			
Mainline I-94	Ex CL I-94	505+16.4267 R1	-0.0553	HG13 & HH13		2			
Mainline I-94	Ex CL I-94	508+01.9091 R1	-0.5582	HG14 & HH14		2			
Mainline I-94	Ex CL I-94	532+10.5547 R1	0.0585	GA1 & GB1		2			
Mainline I-94	Ex CL I-94	534+87.8071 R1	0.2438	GA2 & GB2		2			
Mainline I-94	Ex CL I-94	537+67.6014 R1	-0.1454	GA3 & GB3		2			
Mainline I-94	Ex CL I-94	540+46.4899 R1	0.179	GA4 & GB4		2			
Mainline I-94	Ex CL I-94	543+26.6573 R1	0.3243	GA5 & GB5		2			
Mainline I-94	Ex CL I-94	546+06.4109 R1	0.7186	GA6 & GB6		2			
Mainline I-94	Ex CL I-94	549+17.2545 R1	-0.2146	GA11 & GB11		2			
Mainline I-94	Ex CL I-94	552+20.4858 R1	-0.2747	GA12 & GB12		2			
Mainline I-94	Ex CL I-94	554+89.0452 R1	0.6484	GA13 & GB13		2			
SUBTOTAL 1					8	70	0	0	0



LIGHTING SCHEDULE (2 OF 4)									
ROADWAY	REFERENCE ALIGNMENT	STATION	OFFSET	LIGHT POLE NUMBER	X8210003	X8210007	83600200	84400105	83800105
					LUM LED RDWY ROD G	LUM LED RDWY ROD H	LIGHT POLE FDN 24D	RELOC EX LT UNIT	BKWY DEV TR B 11.5BC
					EACH	EACH	FOOT	EACH	EACH
Mainline I-94	Ex CL I-94	557+73.7878 R1	0.425	GA14 & GB14		2			
Mainline I-94	Ex CL I-94	560+59.9927 R1	-0.0064	GA15 & GB15		2			
Mainline I-94	Ex CL I-94	562+89.0177 R1	-0.406	GA16 & GB16		2			
Mainline I-94	Ex CL I-94	565+19.7464 R1	0.3006	GA17 & GB17		2			
Mainline I-94	Ex CL I-94	567+31.4991 R1	0.067	GA18 & GB18		2			
Mainline I-94	Ex CL I-94	569+62.6883 R1	-0.2755	FC14 & FD14		2			
Mainline I-94	Ex CL I-94	571+92.2151 R1	-0.0927	FC13 & FD13		2			
Mainline I-94	Ex CL I-94	574+20.1609 R1	0.0439	FC12 & FD12		2			
Mainline I-94	Ex CL I-94	576+44.1737 R1	0.0248	FC11 & FD11		2			
Mainline I-94	Ex CL I-94	578+77.5104 R1	0.3953	FC10 & FD10		2			
Mainline I-94	Ex CL I-94	581+02.3879 R1	0.8169	FC9 & FD9		2			
Mainline I-94	Ex CL I-94	583+28.1615 R1	0.9811	FC8 & FD8		2			
Mainline I-94	Ex CL I-94	585+56.1258 R1	0.1779	FC7 & FD7		2			
Mainline I-94	Ex CL I-94	587+91.4776 R1	-0.113	FC6 & FD6		2			
Mainline I-94	Ex CL I-94	590+16.1179 R1	-0.8268	FC5 & FD5		2			
Mainline I-94	Ex CL I-94	592+47.6464 R1	1.2496	FC4 & FD4		2			
Mainline I-94	Ex CL I-94	594+83.8032 R1	-0.3622	FC3 & FD3		2			
Mainline I-94	Ex CL I-94	597+81.8433 R1	-0.298	FC2 & FD2		2			
Mainline I-94	Ex CL I-94	600+81.8458 R1	0.0269	FC1 & FD1		2			
Mainline I-94	Ex CL I-94	603+76.1771 R1	66.883	FL7	1				
Mainline I-94	Ex CL I-94	603+77.5539 R1	-70.1935	FJ1	1				
Mainline I-94	Ex CL I-94	606+26.0935 R1	-0.1634	EA12 & EB12		2			
Mainline I-94	Ex CL I-94	608+55.7011 R1	-0.274	EA11 & EB11		2			
Ramp W3	ExBL1	100+17.7993 R1	21.6684	HJ5	1				
Ramp W3	ExBL1	102+18.7026 R1	19.8383	HI5	1				
Ramp W3	ExBL1	104+20.7833 R1	19.7033	HJ4	1				
Ramp W3	ExBL1	106+21.5798 R1	19.9482	HI4	1				
Ramp W3	ExBL1	108+22.3894 R1	19.6896	HJ3	1				
Ramp W3	ExBL1	108+86.5500 R1	-60.33	HE1	1				
Ramp W3	ExBL1	109+04.9200 R1	-138.5	HI1	1				
Ramp W3	ExBL1	110+52.4500 R1	-94.8	HJ1	1				
Ramp W3	ExBL1	112+27.5800 R1	-79.7	HI2	1				
Ramp W3	ExBL1	110+30.4994 R1	20.2215	HI3	1				
Ramp W3	ExBL1	112+25.4551 R1	21.295	HJ2	1				
Ramp W1	W1	10+12.5451 R1	23.5304	HF4	1				
Ramp W1	W1	10+91.6200 R1	-81.54	HG20	1				
Ramp W1	W1	11+40.4902 R1	19.0985	HE4	1				
DOLTON RD	-	-	-	HF3	1				
Ramp W1	W1	13+02.3400 R1	-56.3	HE3	1				
Ramp W1	W1	13+40.2331 R1	20.0438	HE5	1				
Ramp W1	W1	15+40.2507 R1	20.4404	HF5	1				
Ramp W1	W1	17+40.0112 R1	20.2662	HE6	1				
Ramp W1	W1	19+11.4524 R1	26.463	HF6	1				
Ramp W1	W1	21+21.4563 R1	16.251	HE7	1				
Ramp W4	W4	50+63.4900 R1	-74.2	HF2	1				
Ramp W2	W2	51+32.8352 R1	23.8928	HG5	1				
Ramp W2	W2	52+60.3800 R1	-65.3	HH20	1				
Ramp W2	W2	53+02.0110 R1	19.2191	HH6	1				
Ramp W2	W2	54+46.5452 R1	18.7596	HG6	1				
Ramp W2	W2	55+99.3955 R1	20.3481	HH7	1				
Ramp W2	W2	57+51.9833 R1	19.6742	HG7	1				
SUBTOTAL 2					30	42	0	0	0





745 McCintock Drive
Suite 210
Burr Ridge, IL 60527
Ph. 773-631-4788
www.abnacorp.com

USER NAME

= hbmeprw1lcs01s

DESIGNED

- FPE

REVISD

- 4/8/2025 LNK

PLOT SCALE

= 100.0000 ' / in.

CHECKED

- JMO

REVISD

-

PLOT DATE

= 4/10/2025

DATE

- 12/9/2024

REVISD

-

STATE OF ILLINOIS
DEPARTMENT OF TRANSPORTATION

LIGHTING PLAN SCHEDULE OF QUANTITIES
I-94 (BISHOP FORD EXPY)

SCALE: SHEET 1 OF 2 SHEETS STA. TO STA.

F.A.I. RTE.	SECTION	COUNTY	TOTAL SHEETS	SHEET NO.
94	(42-B-11-1) BR, BJR 24	COOK	761	401
CONTRACT NO. 62W87				
		ILLINOIS	FED. AID PROJECT	

LIGHTING SCHEDULE (3 OF 4)									
ROADWAY	REFERENCE ALIGNMENT	STATION	OFFSET	LIGHT POLE NUMBER	X8210003 LUM LED RDWY ROD G	X8210007 LUM LED RDWY ROD H	83600200 LIGHT POLE FDN 24D	84400105 RELOC EX LT UNIT	83800105 BKWY DEV TR B 11.5BC
			FT		EACH	EACH	FOOT	EACH	EACH
Ramp W2	W2	59+02.8293 R1	19.8894	HH8	1				
Ramp W2	W2	482+58.0998 R1	78.0439	HG8	1				
Ramp W4	W4	150+44.6058 R1	23.0317	HH4	1				
Ramp W4	W4	152+30.6333 R1	20.8217	HG4	1				
Ramp W4	W4	154+26.2983 R1	20.3023	HH3	1				
Ramp W4	W4	156+10.8917 R1	20.1142	HG3	1				
Ramp W4	W4	157+92.1426 R1	20.2158	HH2	1				
Ramp W4	W4	160+01.0910 R1	20.2509	HG2	1				
Ramp W4	W4	162+08.6800 R1	-38.6	HG1	1				
Ramp W4	W4	162+39.6700 R1	-110.8	HF1	1				
Ramp W4	W4	163+85.5200 R1	-77.9	HE2	1				
Ramp W4	W4	162+07.3998 R1	20.2246	HH1	1				
Ramp W4	W4	163+79.0346 R1	23.8134	HH5	1				
Ramp Y1	Y1	657+64.3882 R1	10.1942	FH10	1				
Ramp Y1	Y1	659+19.4667 R1	9.8603	FG10	1				
Ramp Y1	Y1	660+78.0402 R1	10.889	FH9	1				
Ramp Y1	Y1	662+30.8016 R1	10.6185	FG9	1				
Ramp Y1	Y1	663+88.1009 R1	10.1983	FH8	1				
Ramp Y1	PR CENTERLINE	103+77.3947 R1	11.5047	FG8	1		6	1	4
Ramp Y1	PR CENTERLINE	105+38.6252 R1	10.9222	FH7	1		6	1	4
Ramp Y2	Y2	700+20.3431 R1	15.1149	FG1	1				
Ramp Y2	Y2	701+41.1652 R1	17.0593	FH1	1				
Ramp Y2	Y2	702+85.5674 R1	10.1287	FG2	1				
Ramp Y2	Y2	704+35.4132 R1	-25.1826	FH2	1				
Ramp Y2	Y2	705+85.9965 R1	-24.8905	FG3	1				
Ramp Y2	Y2	707+36.9135 R1	-24.9631	FH3	1				
Ramp Y2	Y2	709+06.6113 R1	-25.7121	FG4	1				
Ramp Y2	Y2	710+36.3071 R1	9.9025	FH5	1				
Ramp Y2	Y2	711+91.7710 R1	12.9338	FG6	1				
Ramp Y3	Y3	751+00.2297 R1	11.1271	FI5	1				
Ramp Y3	Y3	752+64.5634 R1	9.4113	FJ5	1				
Ramp Y3	Y3	754+31.1988 R1	-26.7488	FI3	1				
Ramp Y3	Y3	755+71.8110 R1	-25.1896	FJ3	1				
Ramp Y3	Y3	757+28.2855 R1	-26.103	FI2	1				
Ramp Y3	Y3	758+84.3940 R1	9.8387	FJ2	1				
Ramp Y3	Y3	760+39.3600 R1	12.9583	FI1	1				
Ramp Y4	Y4	804+96.6596 R1	15.1193	FJ11	1				
Ramp Y4	Y4	806+51.5039 R1	21.0651	FI10	1				
Ramp Y4	Y4	808+24.4168 R1	16.011	FJ9	1				
Ramp Y4	Y4	809+89.6734 R1	8.7762	FI9	1				
Ramp Y4	Y4	811+55.2201 R1	-32.8977	FJ8	1				
Ramp Y4	Y4	813+19.8155 R1	9.4992	FI8	1				
Ramp Y5	Y5	851+76.7331 R1	11.8127	FB5	1				

LIGHTING SCHEDULE (4 OF 4)									
ROADWAY	REFERENCE ALIGNMENT	STATION	OFFSET	LIGHT POLE NUMBER	X8210003 LUM LED RDWY ROD G	X8210007 LUM LED RDWY ROD H	83600200 LIGHT POLE FDN 24D	84400105 RELOC EX LT UNIT	83800105 BKWY DEV TR B 11.5BC
			FT		EACH	EACH	FOOT	EACH	EACH
Ramp Y5	Y5	861+57.2930 R1	11.499	FB2	1				
Ramp Y5	Y5	863+31.6515 R1	11.3344	FA2	1				
Ramp Y5	Y5	865+08.1822 R1	17.0452	FB1	1				
Ramp Y5	Y5	866+82.2115 R1	4.1252	FA1	1				
Ramp Y6	Y6	900+96.2470 R1	6.5168	FB10	1				
Ramp Y6	Y6	902+41.7199 R1	9.8842	FA9	1				
Ramp Y6	Y6	903+86.6278 R1	-25.0143	FB9	1				
Ramp Y6	Y6	905+31.1447 R1	-24.9752	FA6	1				
Ramp Y6	Y6	906+76.3730 R1	-25.3408	FB6	1				
Ramp Y6	Y6	908+19.2696 R1	-25.1486	FA7	1				
Ramp Y6	Y6	909+65.5403 R1	10.546	FB7	1				
Ramp Y6	Y6	911+10.9626 R1	9.9576	FA8	1				
Ramp Y7	Y7	950+86.5173 R1	12.2599	FK6	1				
Ramp Y7	Y7	952+45.8900 R1	10.5423	FL6	1				
Ramp Y7	Y7	953+93.8506 R1	-26.068	FK5	1				
Ramp Y7	Y7	955+43.1388 R1	-25.245	FL5	1				
Ramp Y7	Y7	956+93.1737 R1	-26.6122	FK4	1				
Ramp Y7	Y7	958+44.1102 R1	-22.4122	FL4	1				
Ramp Y7	Y7	959+78.8785 R1	14.6466	FK2	1				
Ramp Y7	Y7	961+30.8618 R1	10.8465	FL2	1				
Ramp Y8	Y8	1001+02.1920 R1	11.4353	FK7	1				
Ramp Y8	Y8	1002+54.3737 R1	10.7376	FL9	1				
Ramp Y8	Y8	1004+19.8857 R1	10.8018	FK8	1				
Ramp Y8	Y8	1005+83.3160 R1	11.2618	FL10	1				
Ramp Y8	Y8	1007+38.8754 R1	9.4374	FK9	1				
Ramp Y8	Y8	1009+12.9827 R1	15.5408	FL11	1				
Ramp Y8	Y8	1010+95.3784 R1	16.6483	FK10	1				
Ramp Y8	Y8	1012+62.7297 R1	21.3835	FL12	1				
Ramp Y8	Y8	1013+81.3362 R1	19.1221	FK11	1				
US 6	Y4	815+46.8379	-41.4135	FI14	1				
US 6	Y1	656+07.1266	-133.848	FH4	1				
US 6	Y8	1002+12.6057	-77.7583	FL1	1				
US 6	Y5	864+04.6186	-56.4376	FB11	1				
US 6	Y7	960+83.9582	-80.3026	FK1	1				
US 6	EXISTING CENTERLINE	338+97.1349	-37.8684	FA11	1				
US 6	EXISTING CENTERLINE	340+34.4556	48.9695	FK3	1				
US 6	EXISTING CENTERLINE	341+74.2789	49.1869	FL3	1				
US 6	EXISTING CENTERLINE	342+05.2589	-48.0872	FA10	1				
US 6	EXISTING CENTERLINE	345+24.8554	49.5557	FI6	1				
US 6	EXISTING CENTERLINE	345+81.0765	-48.8481	FH6	1				
US 6	EXISTING CENTERLINE	346+49.9435	49.0366	FJ6	1				
US 6	EXISTING CENTERLINE	348+72.0430	-37.2376	FG5	1				
US 6	EXISTING CENTERLINE	349+84.0229	38.7504	FJ14	1				
SUBTOTAL 4					43	0	0	0	0
TOTAL					129	112	12	2	8

LIGHTING SCHEDULE																	
ROADWAY	FROM STA	TO STA	81100320 CON AT ST 1 PVC GS	81702110 EC C XLP USE 1C 10	81702450 EC C XLP USE 3-1C 10	81800330 A CBL 3- 1C6 MESS WIRE	81028350 UNDRGRD C PVC 2	82200609 WWOWL LED 360 D G	82200606 WWOWL LED 180 R PM	82600106 OBSTRUCT WARN LT CONT	81300220 JUN BX SS AS 6X6X4	81300310 JUN BX SS AS 8X6X4	81300420 JUN BX SS AS 10X8X6	81300830 JUN BX SS AP 18X18X8	82110026 LUM LED UP SUS D	82110022 LUM LED UP WM E	81603081 UD 3#2#4GXLP USE 1.5 P
			FOOT	FOOT	FOOT	FOOT	FOOT	EACH	EACH	EACH	EACH	EACH	EACH	EACH	EACH	EACH	FOOT
I-94 Over Dolton	478+47.356	479+21.9413	400	765	175						8		4	2	8	-	-
WB US 6 - WB I-94	663+88.10 R1	665+40.34 R1	-	-							-		-	-	-	-	152.4
WB US 6 - WB I-94	665+40.34 R1	666+97.48 R1	-	-							-		-	-	-	-	147
I-94 AND 154TH ST	547+32.13	547+94.02	300	780	70						8		2	1	8	-	-
I-94 AND 159TH ST	602+42.43	603+32.58	350	630	205						6		3	1	-	8	-
I-94 STELL BRIDGE	451+65.97	458+00	1331	4366	435	100	24	2	6	1		11					
TOTAL			12381	6541	8851	100	24	2	6	1	22	11	9	4	16	8	300

MODEL Default
FILE NAME: W:\mnpw\11cs01\CS_gdf_work_dlf\30241468_211D\62K53-ctrl-light-S00-02.dgn



745 McCintock Drive
Suite 210
Burr Ridge, IL 60527
Ph. 773-451-4788
www.abnacorp.com

USER NAME

= hbmeppw11cs01s

DESIGNED

- FPE

DRAWN

- LNK

PLOT SCALE

= 100.0000 ' / in.

CHECKED

- JMO

PLOT DATE

= 4/10/2025

DATE

- 01/22/2025

REVISD

- 4/8/2025 LNK

REVISD

-

REVISD

-

REVISD

-

STATE OF ILLINOIS
DEPARTMENT OF TRANSPORTATION

LIGHTING PLAN SCHEDULE OF QUANTITIES
I-94 (BISHOP FORD EXPY)

SCALE: SHEET 2 OF 2 SHEETS STA. TO STA.

F.A.I. RTE.	SECTION	COUNTY	TOTAL SHEETS	SHEET NO.
94	(42-B-11-1) BR, BJR 24	COOK	761	402
CONTRACT NO. 62W87				
ILLINOIS FED. AID PROJECT				

MODEL: Default
FILE: \\net1c\work\62W87\11cs01\CS_pdfs\work_dtl\3024\1468_80\DI\62W87-shl-light1026.dgn



745 McCintock Drive
Suite 210
Burr Ridge, IL 60527
Ph. 773-451-4788
www.abnacorp.com

USER NAME	= hbmepw11cs01s
PLOT SCALE	= 100.0000 ' / in.
PLOT DATE	= 4/10/2025

DESIGNED -	FPE	REVISED -	4/8/2025 LNK
DRAWN -	LNK	REVISED -	
CHECKED -	JMO	REVISED -	
DATE -	12/9/2024	REVISED -	


STATE OF ILLINOIS
DEPARTMENT OF TRANSPORTATION

LIGHTING PLAN
I-94 (BISHOP FORD EXPY)



SCALE: SHEET 1 OF 22 SHEETS STA. 447+50 TO STA. 461+00




F.A.I. RTE.	SECTION	COUNTY	TOTAL SHEETS	SHEET NO.
94	(42-B-11-1) BR, BJR 24	COOK	761	403
CONTRACT NO. 62W87				
		ILLINOIS	FED. AID PROJECT	

MATCHLINE STA 447+50

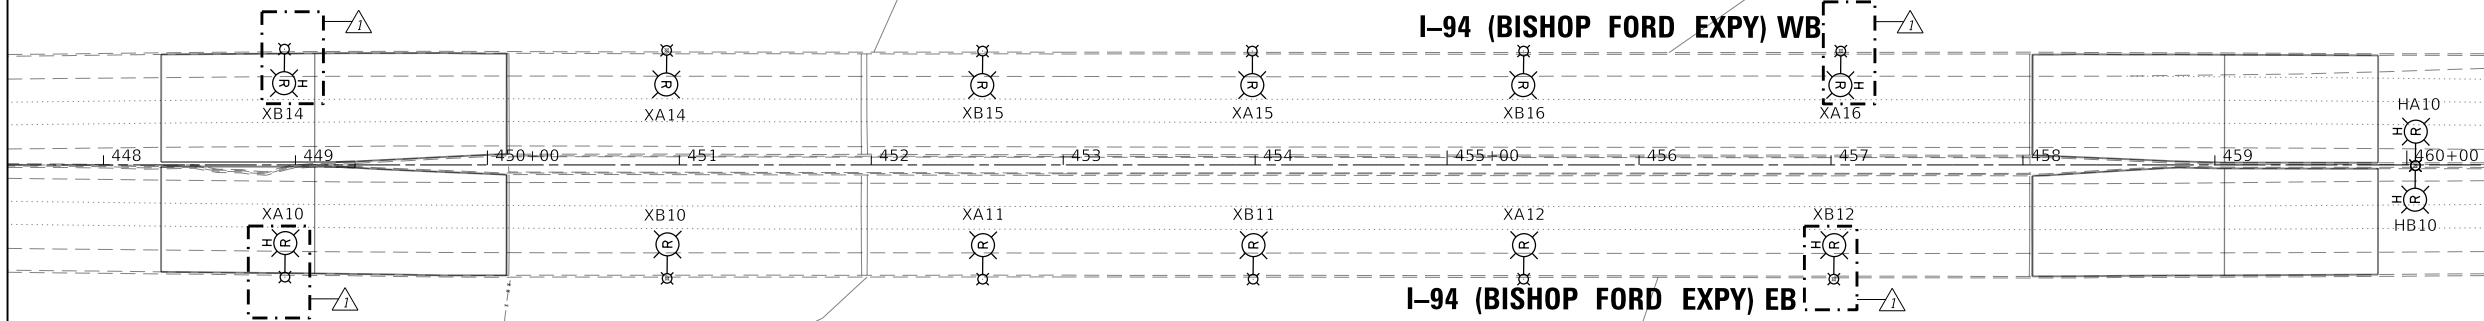

MATCHLINE STA 461+00

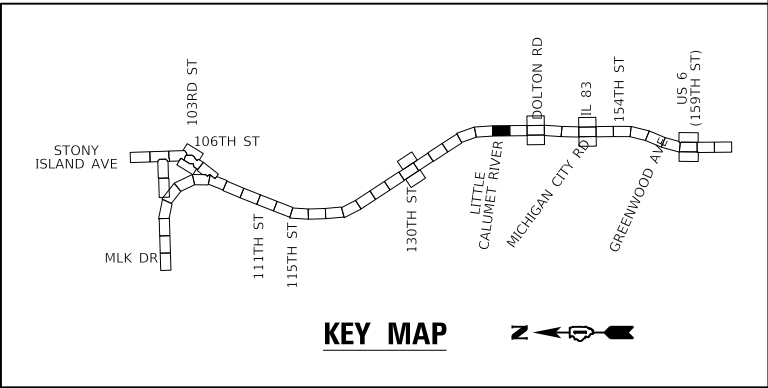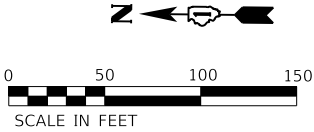

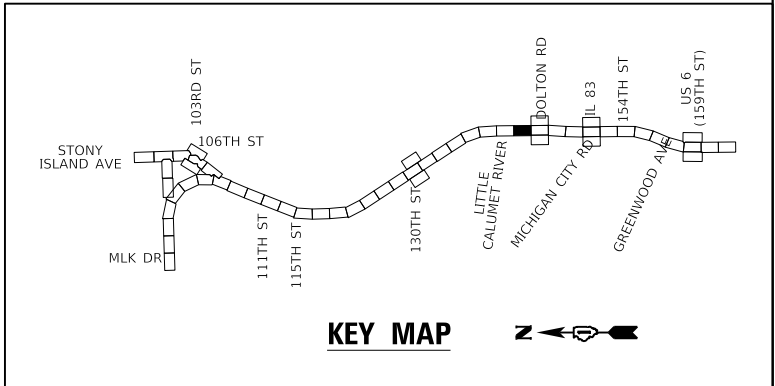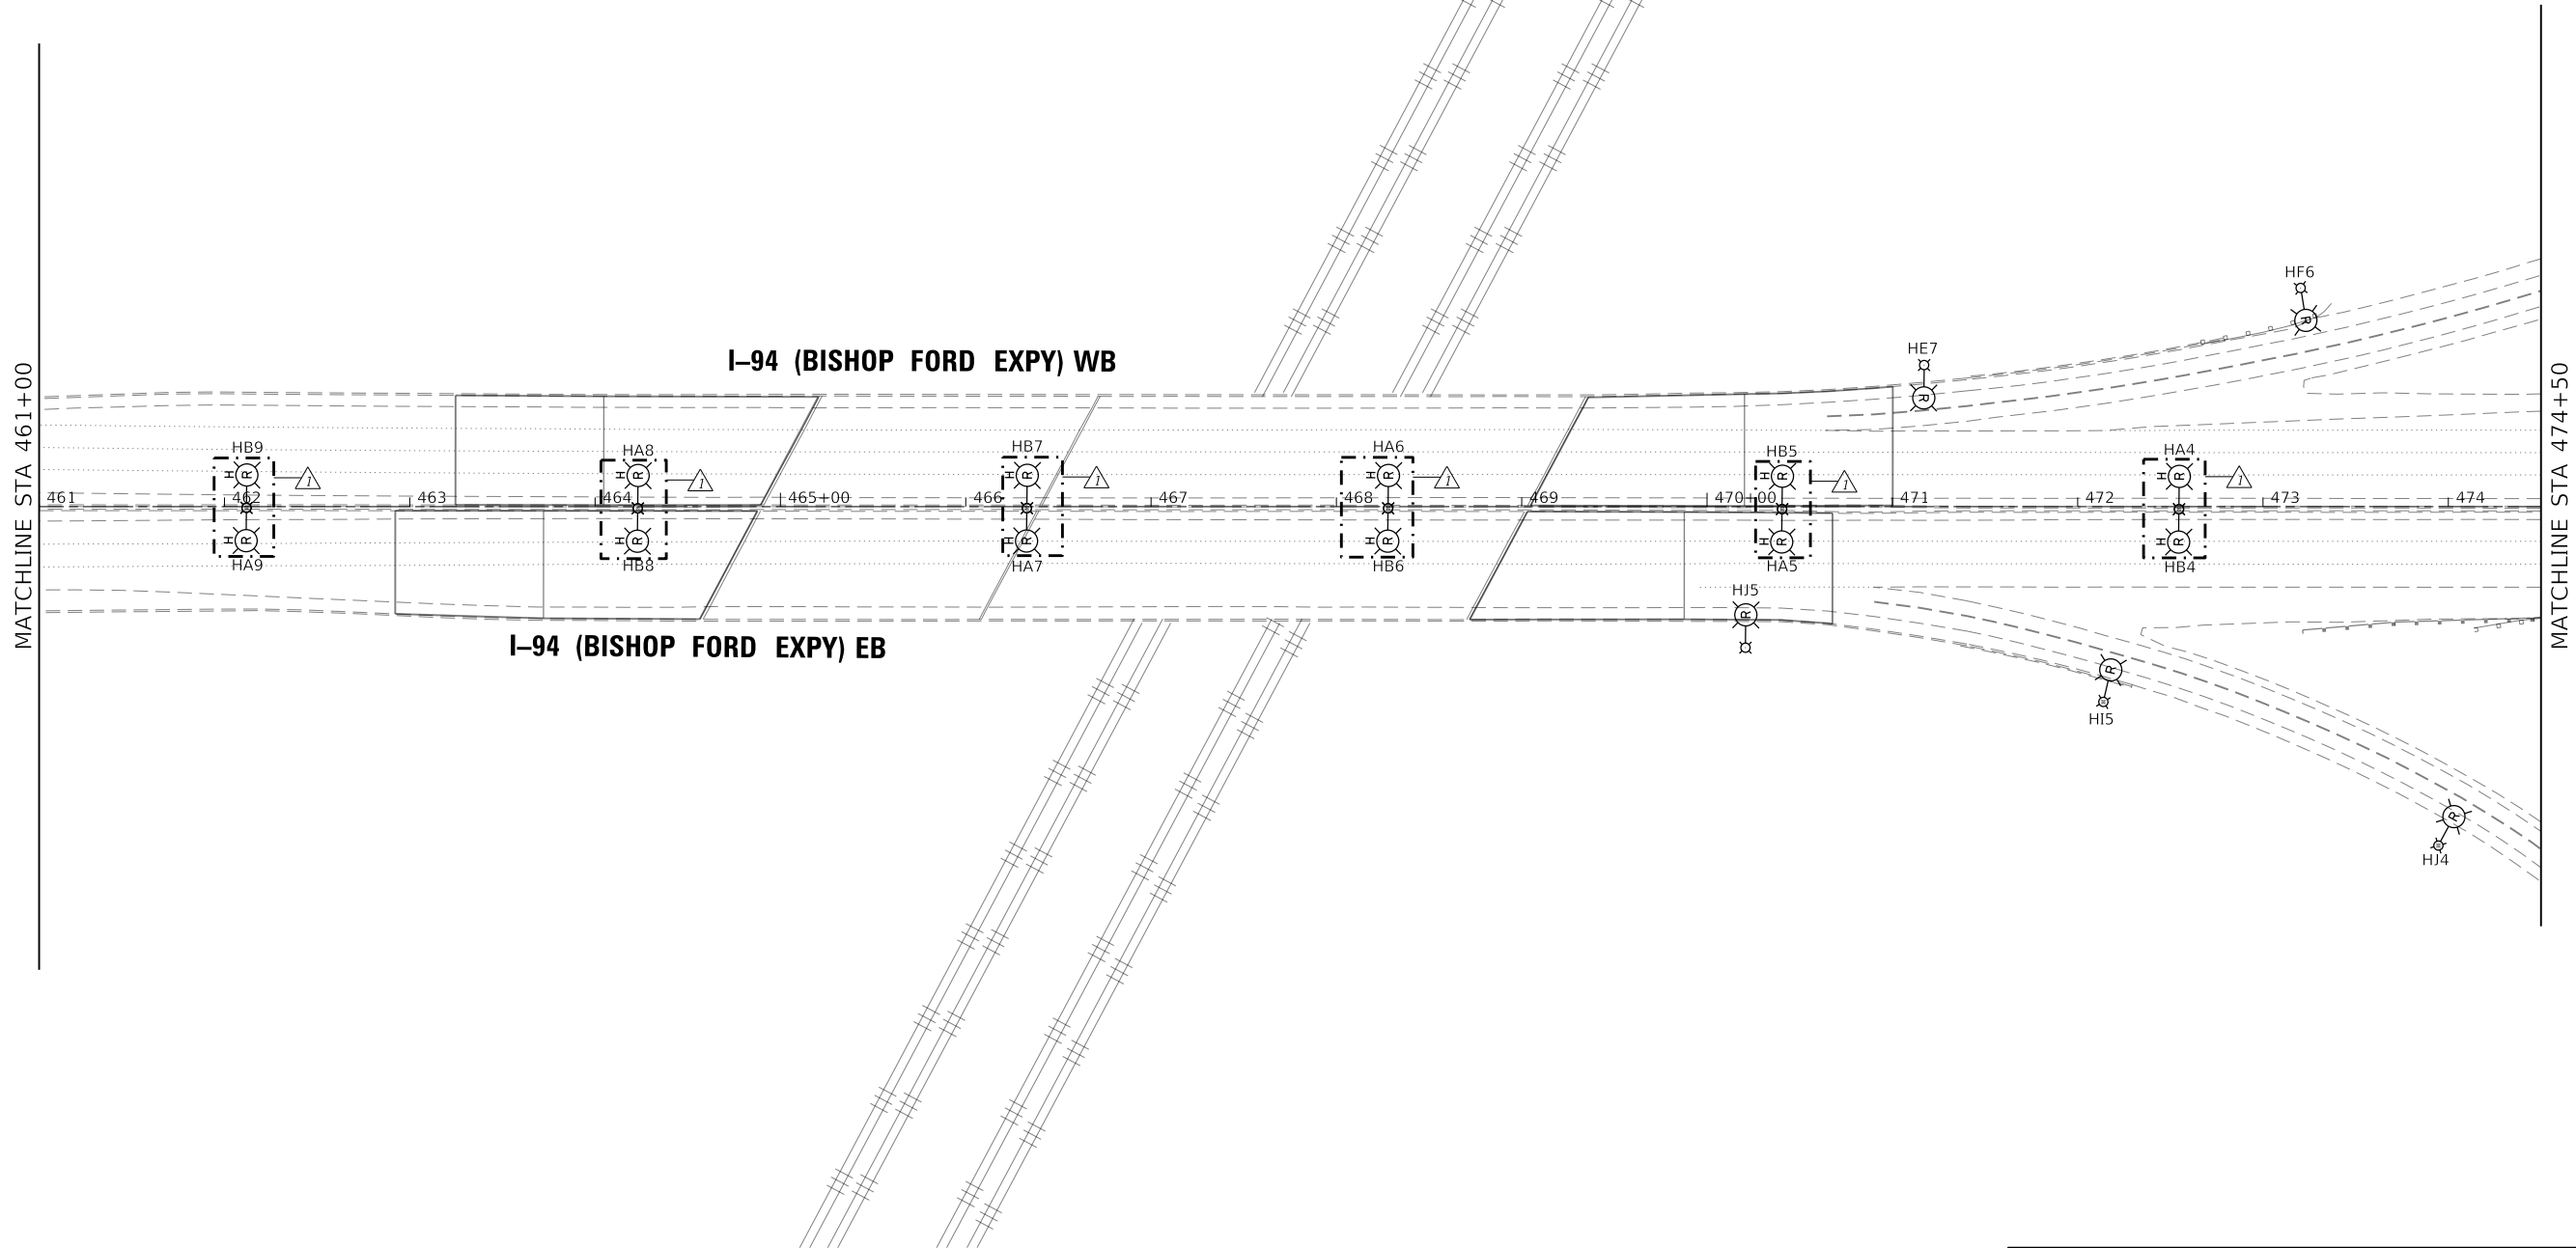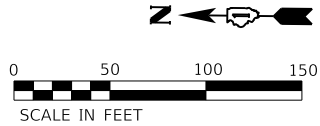

MODEL: Default
FILE: \\net1\work\62w87\11cs01\CS_gdf_work\dlr\3020\1468_8\1D162K53-sh-light027.dgn



745 McCintock Drive
Suite 210
Burr Ridge, IL 60527
Ph. 773-451-4788
www.abnacorp.com

USER NAME	= hbmeprw11cs01s	DESIGNED	- FPE	REVISED	- 4/8/2025 LNK
DRAWN	- LNK	REVIS	-		
PLOT SCALE	= 100,0000 ' / in.	CHECKED	- JMO	REVISED	-
PLOT DATE	= 4/10/2025	DATE	- 12/9/2024	REVISED	-

STATE OF ILLINOIS
DEPARTMENT OF TRANSPORTATION

LIGHTING PLAN
I-94 (BISHOP FORD EXPY)

SCALE: SHEET 2 OF 22 SHEETS STA. 461+00 TO STA. 474+50

F.A.I. RTE.	SECTION	COUNTY	TOTAL SHEETS	SHEET NO.
94	(42-B-11-1) BR, BJR 24	COOK	761	404
CONTRACT NO. 62W87				
		ILLINOIS	FED. AID PROJECT	

MODEL Default
FILE Name: W:\msepaw11cs01\CS_gdf_work_dtl\02\K53-sh-light02B.dgn






USER NAME = hbmeprw11cs01s	DESIGNED - FPE	REVISED - 4/8/2025 LNK
	DRAWN - LNK	REVISED -
PLOT SCALE = 100,0000 ' / in.	CHECKED - JMO	REVISED -
PLOT DATE = 4/10/2025	DATE - 12/9/2024	REVISED -




STATE OF ILLINOIS
DEPARTMENT OF TRANSPORTATION

LIGHTING PLAN
I-94 (BISHOP FORD EXPY)

SCALE: SHEET 3 OF 22 SHEETS STA. 474+50 TO STA. 488+00

F.A.I. RTE.	SECTION	COUNTY	TOTAL SHEETS	SHEET NO.
94	(42-B-11-1) BR, BJR 24	COOK	761	405
CONTRACT NO. 62W87				
ILLINOIS FED. AID PROJECT				

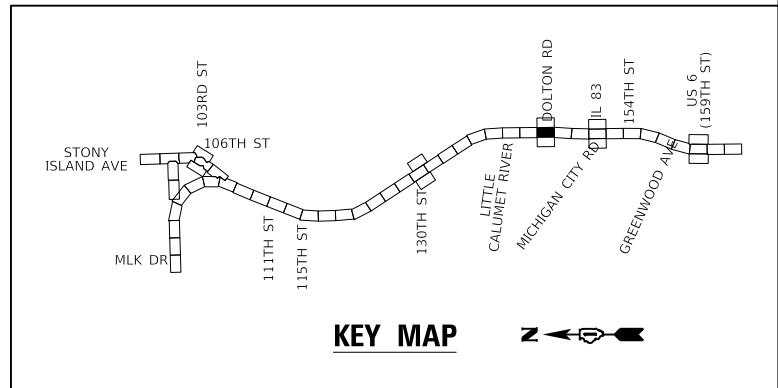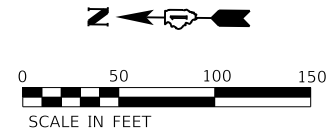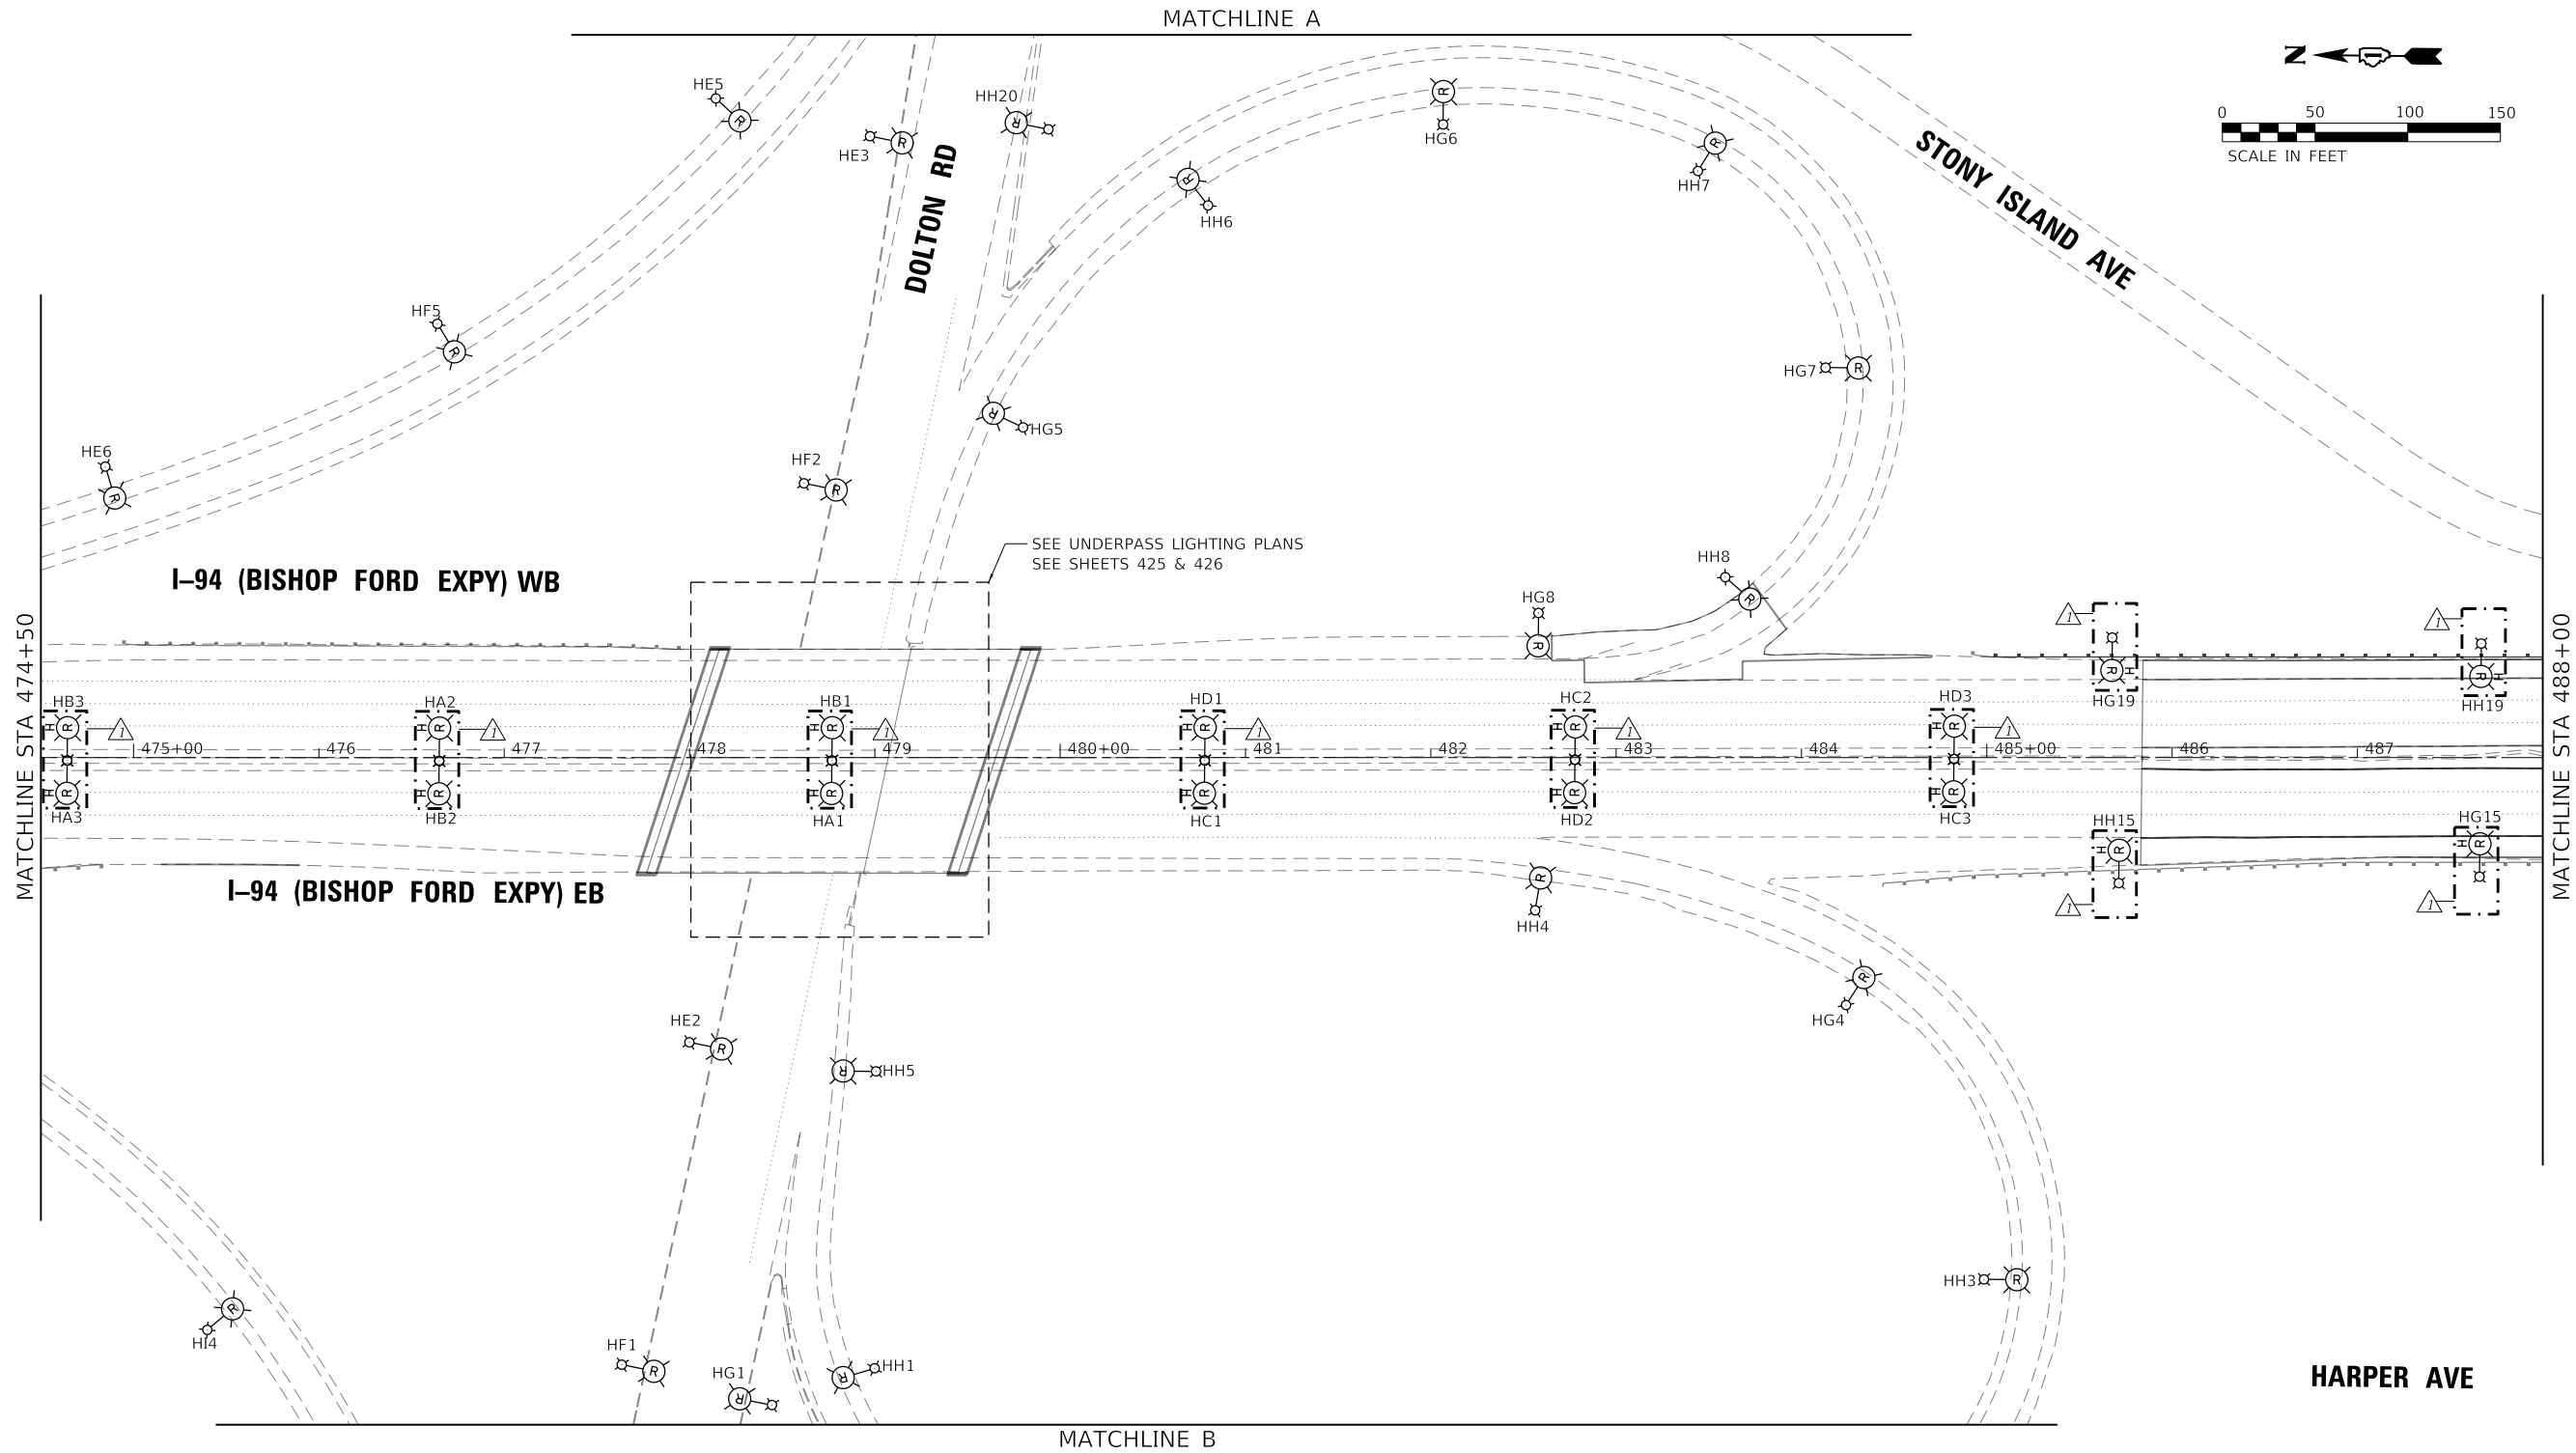

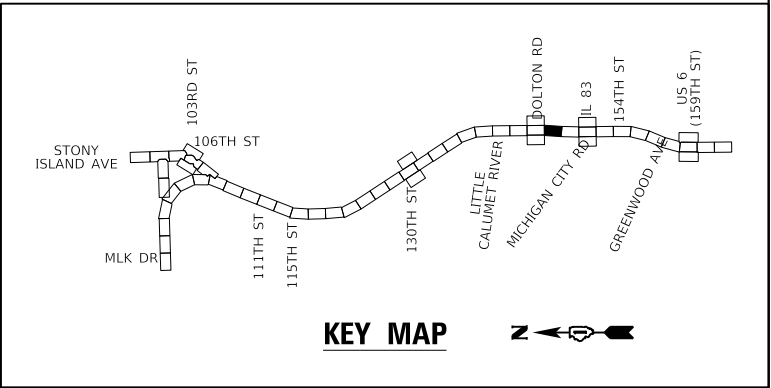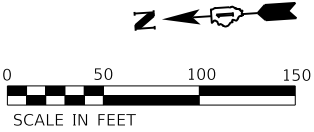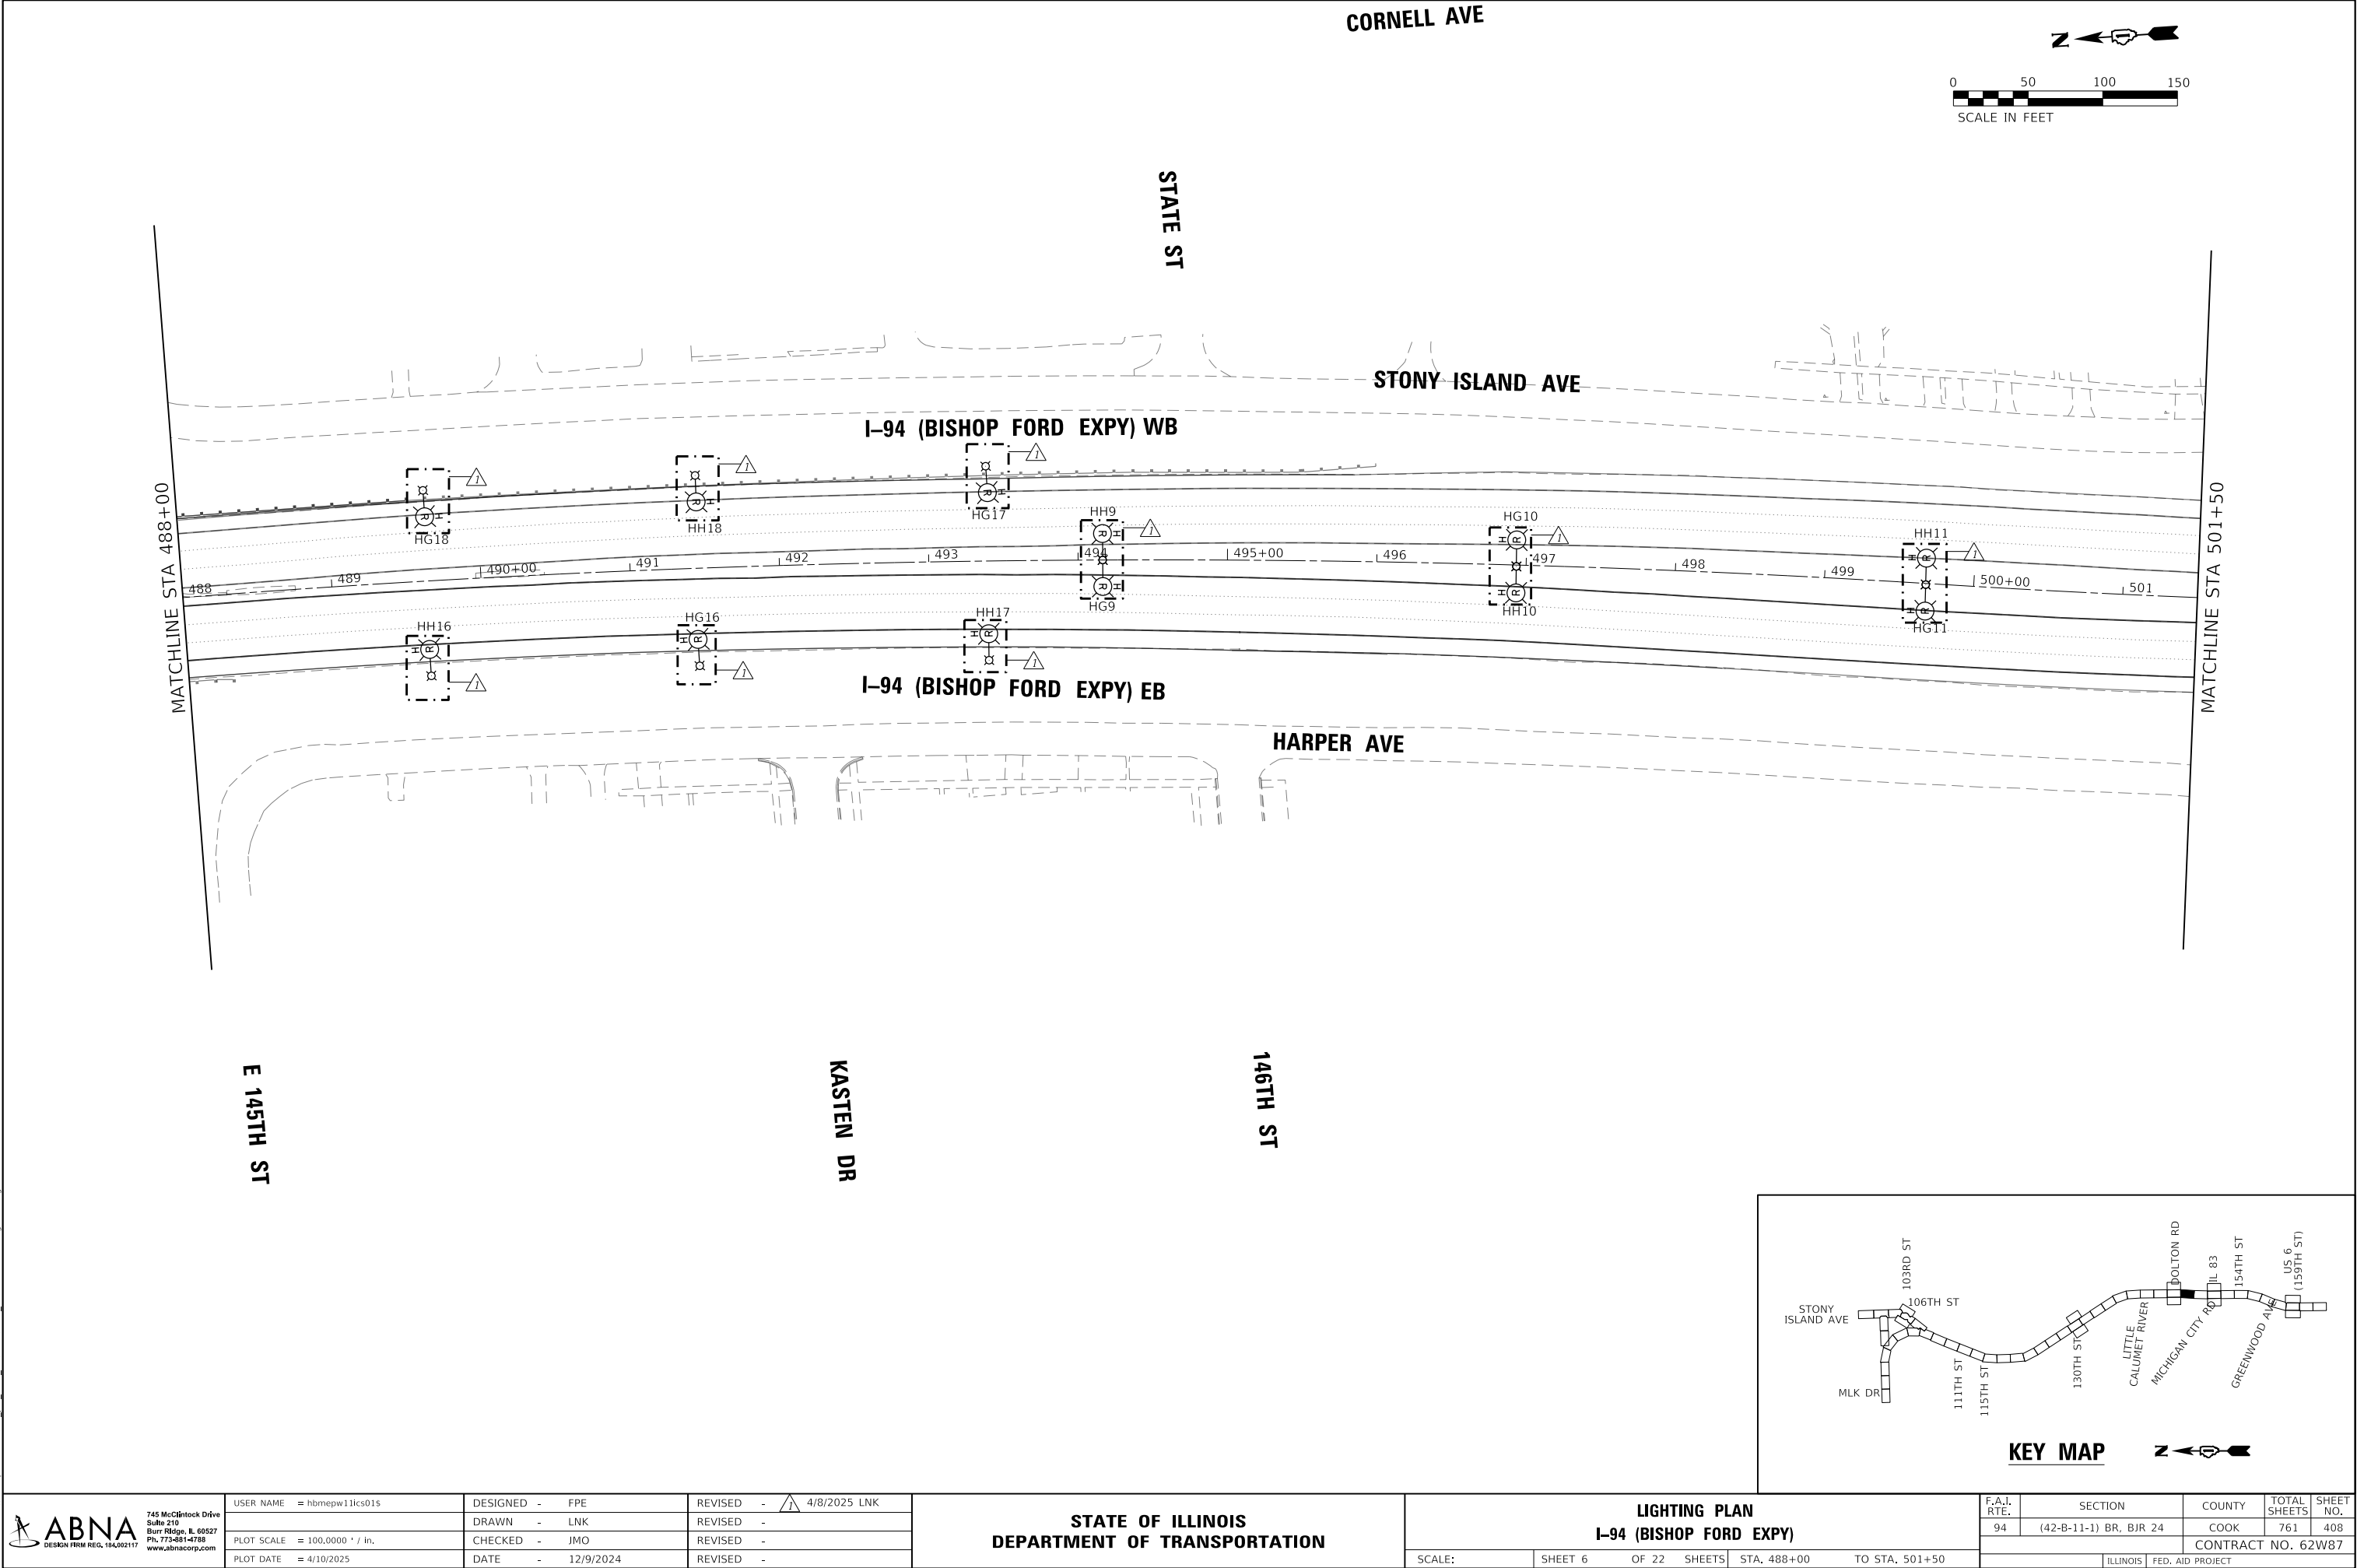

MODEL: Default
FILE: hbmepw11cs01\CS_gdf_work\dlp3020\1468_82\DI\62W87-shl-light029.dgn



745 McClellan Drive
Suite 210
Burr Ridge, IL 60527
Ph: 773-451-4788
www.abnacorp.com




USER NAME = hbmepw11cs01\$	DESIGNED - FPE	REVISED - 4/8/2025 LNK
	DRAWN - LNK	REVISED -
PLOT SCALE = 100,0000 ' / in.	CHECKED - JMO	REVISED -
PLOT DATE = 4/10/2025	DATE - 12/9/2024	REVISED -

STATE OF ILLINOIS
DEPARTMENT OF TRANSPORTATION

LIGHTING PLAN
I-94 (BISHOP FORD EXPY)

SCALE: SHEET 6 OF 22 SHEETS STA. 488+00 TO STA. 501+50

F.A.I. RTE.	SECTION	COUNTY	TOTAL SHEETS	SHEET NO.
94	(42-B-11-1) BR, BJR 24	COOK	761	408
CONTRACT NO. 62W87				
ILLINOIS FED. AID PROJECT				

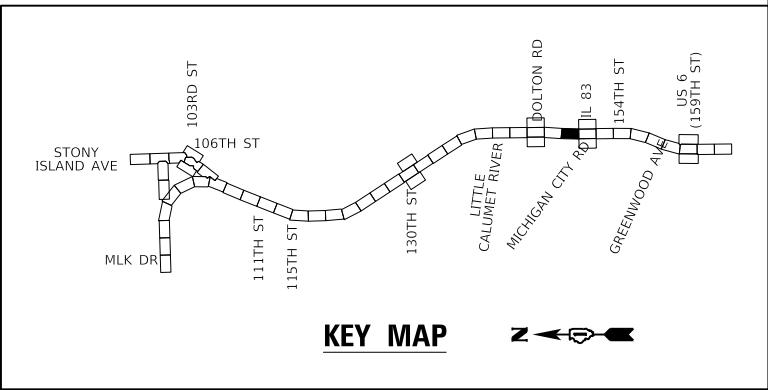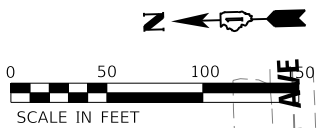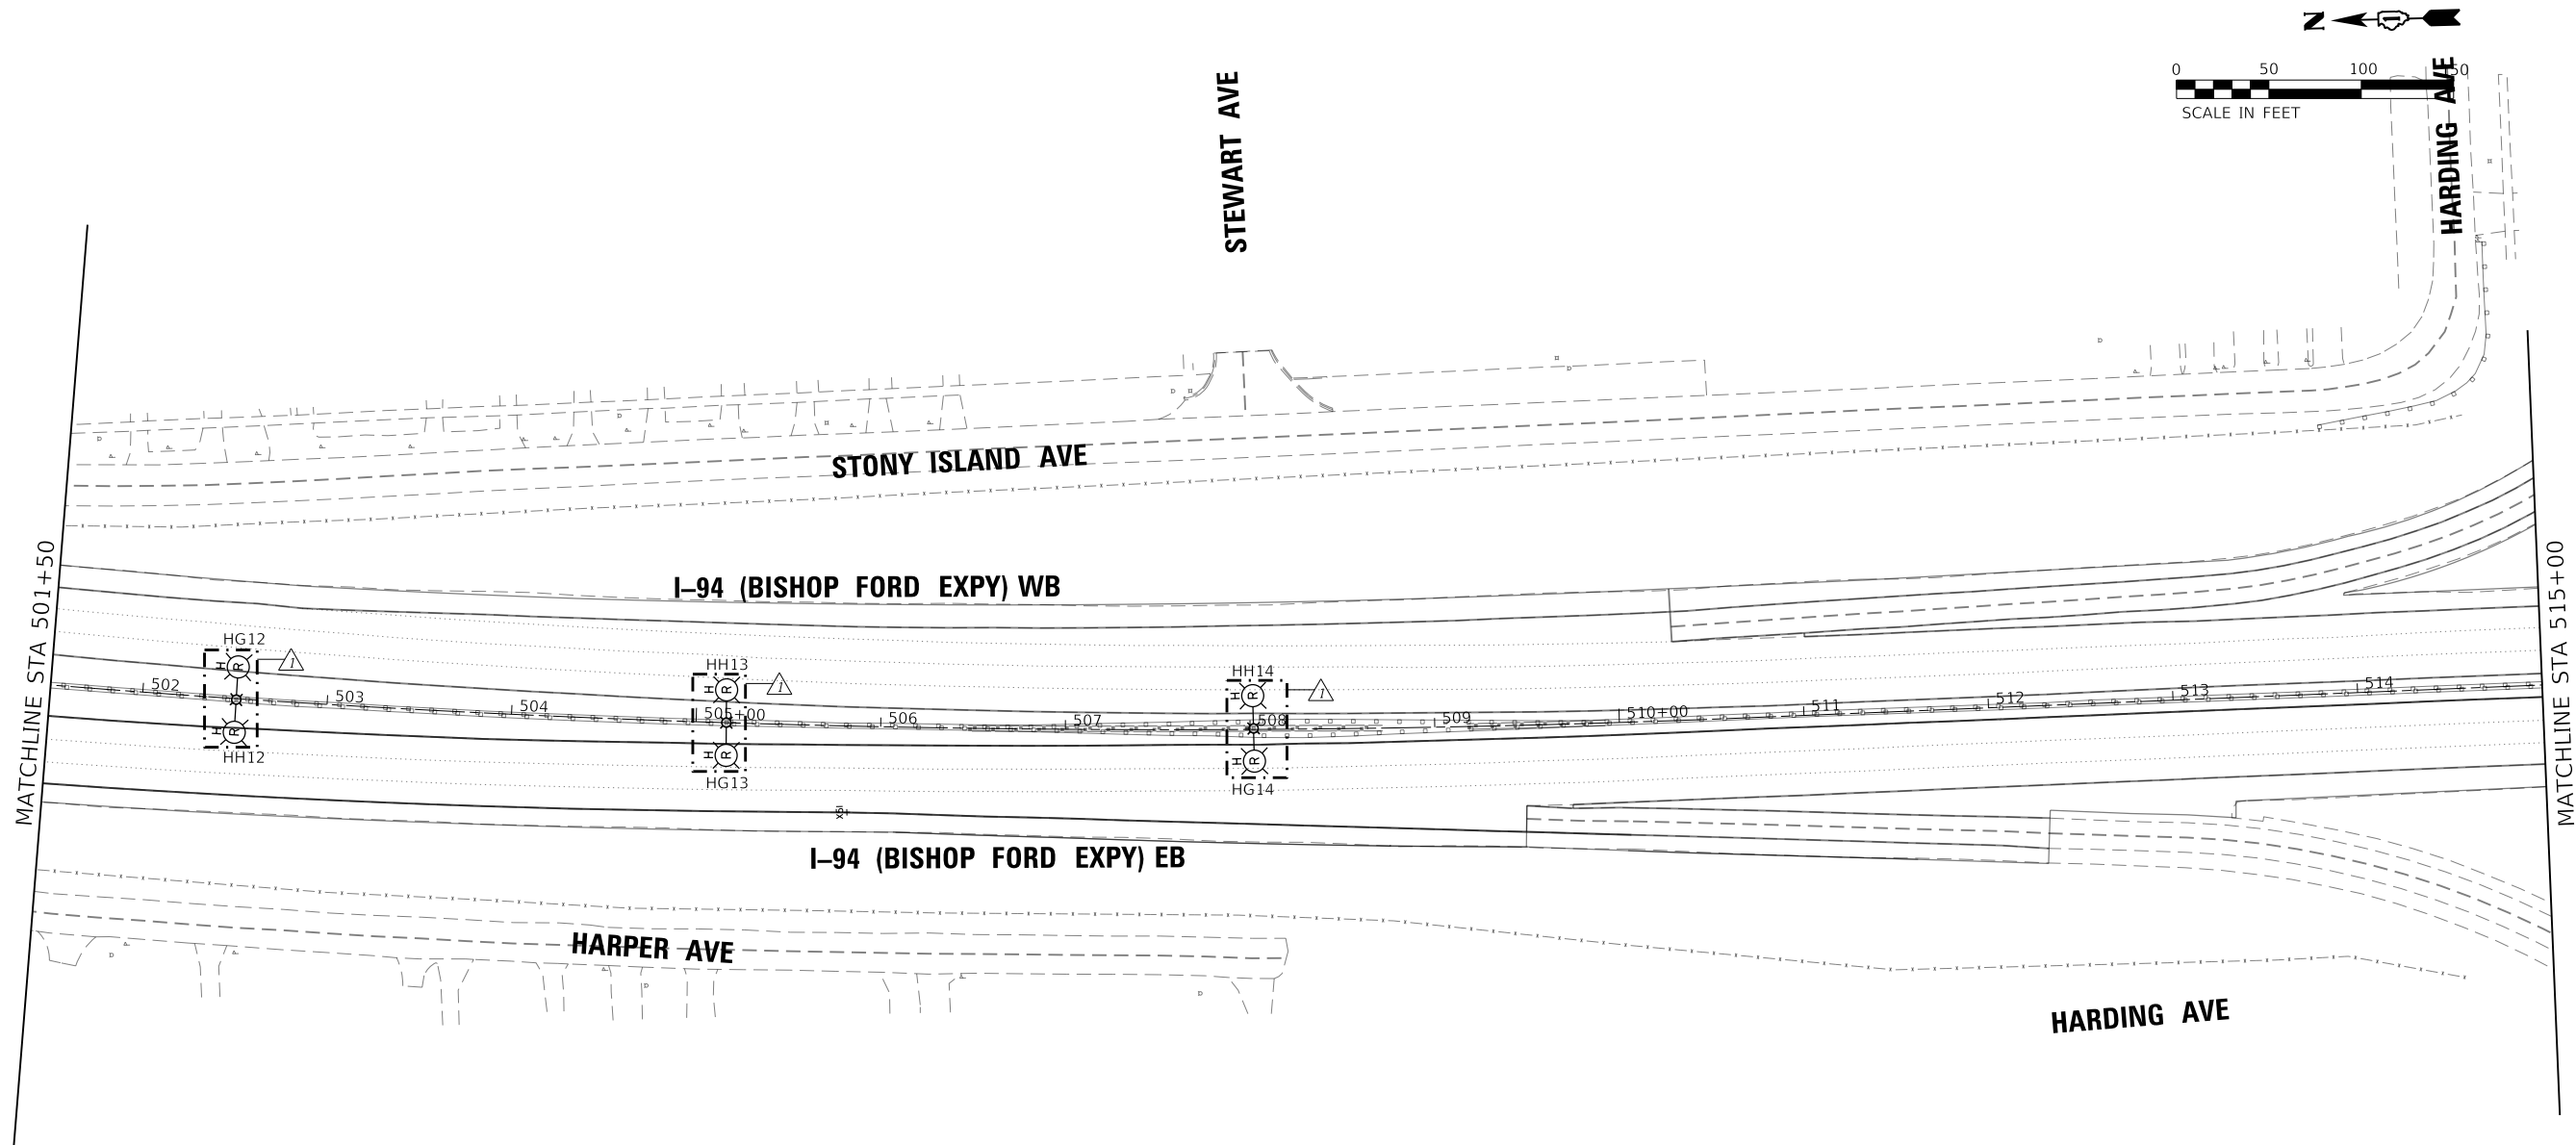

MODEL: Default
FILE: \\miller\work\mep\w11cs01\CS_gdf_work_dtl\302011468_83\DI\25X53-sh-light030.dgn



 745 McCintock Drive Suite 210 Burr Ridge, IL 60527 Ph. 773-451-4788 www.abnacorp.com	USER NAME = hbmeprw11cs01s	DESIGNED - FPE	REVISED -  4/8/2025 LNK
		DRAWN - LNK	REVISED -
	PLOT SCALE = 100,0000 ' / in.	CHECKED - JMO	REVISED -
	PLOT DATE = 4/10/2025	DATE - 12/9/2024	REVISED -

STATE OF ILLINOIS
DEPARTMENT OF TRANSPORTATION

LIGHTING PLAN
I-94 (BISHOP FORD EXPY)

SCALE: SHEET 7 OF 22 SHEETS STA. 501+50 TO STA. 515+00

F.A.I. RTE.	SECTION	COUNTY	TOTAL SHEETS	SHEET NO.
94	(42-B-11-1) BR, BJR 24	COOK	761	409
CONTRACT NO. 62W87				
		ILLINOIS	FED. AID PROJECT	

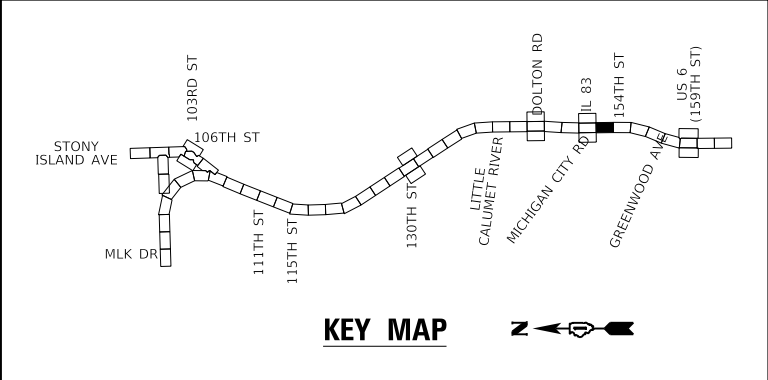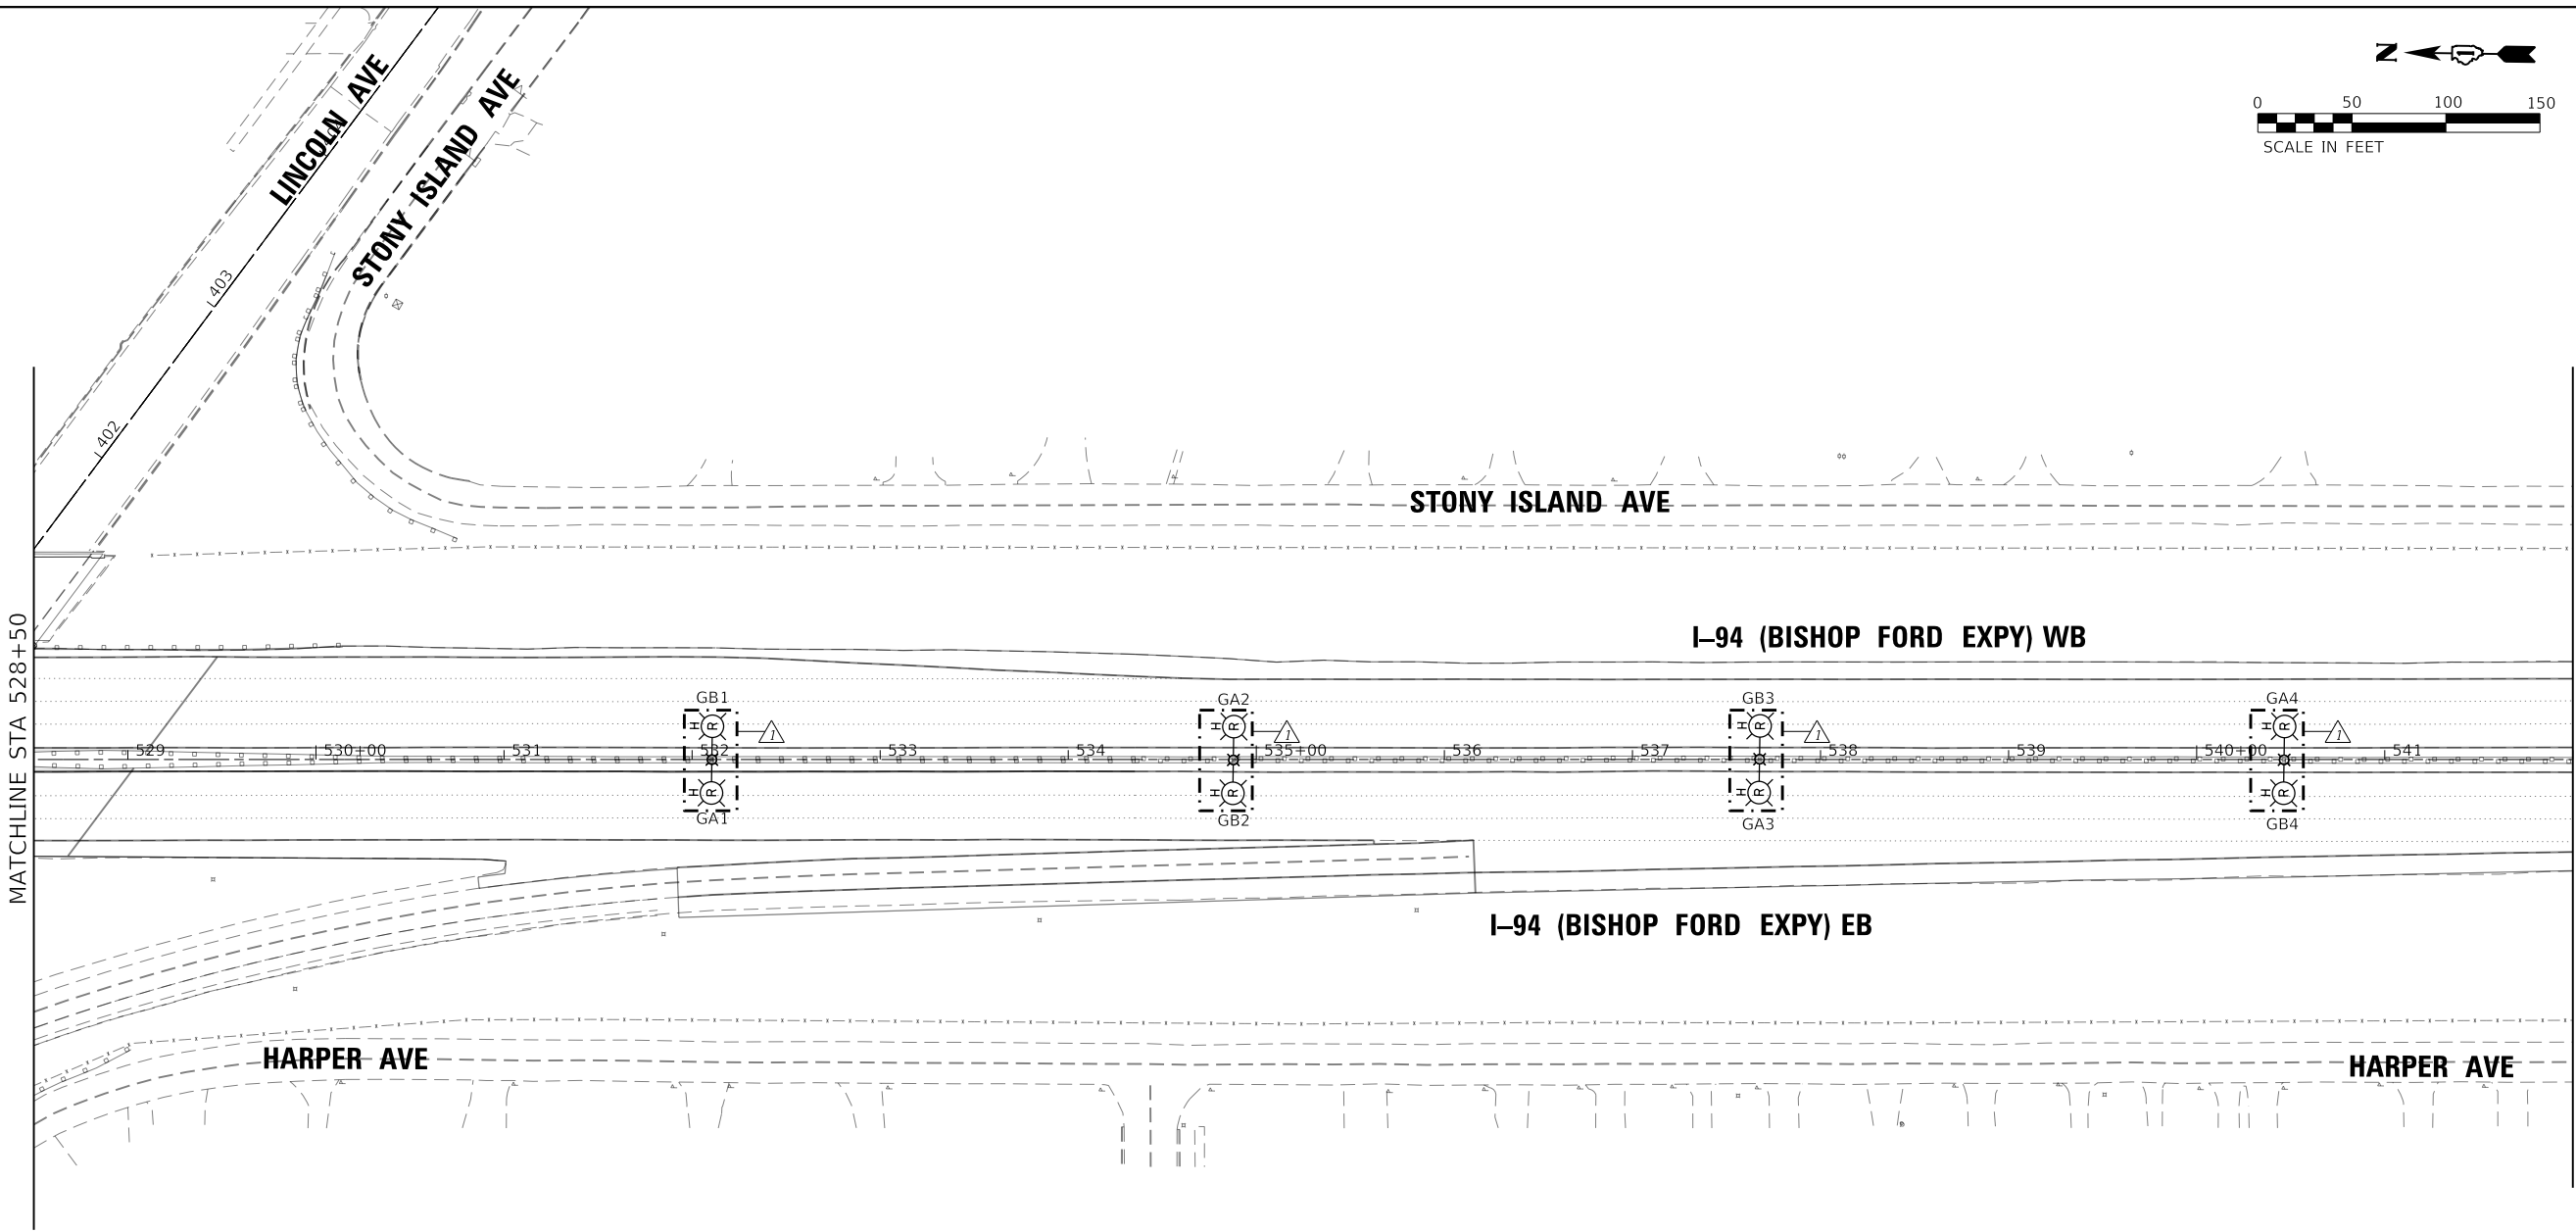

MODEL Default
FILE Name: \\homesw11\cs01\CS_golf_work\dlr\3020\1468_BA\DI\EX\53-sh-light\022.dgn

 745 McCintock Drive Suite 210 Burr Ridge, IL 60527 Ph. 773-451-4788 www.abnacorp.com	USER NAME = hbmeprw11cs01s	DESIGNED - FPE	REVISED -  4/8/2025 LNK
	DRAWN - LNK	REVIS	REVISED -
	PLOT SCALE = 100,0000 ' / in.	CHECKED - JMO	REVISED -
	PLOT DATE = 4/10/2025	DATE - 12/9/2024	REVISED -

STATE OF ILLINOIS
DEPARTMENT OF TRANSPORTATION

LIGHTING PLAN			
I-94 (BISHOP FORD EXPY)			
SCALE:	SHEET 11	OF 22 SHEETS	STA. 528+50 TO STA. 542+00

F.A.I. RTE.	SECTION	COUNTY	TOTAL SHEETS	SHEET NO.
94	(42-B-11-1) BR, BJR 24	COOK	761	413
CONTRACT NO. 62W87				
ILLINOIS		FED. AID PROJECT		

MODEL Default
FILE Name: W:\mepw\11cs01\CS_pdf_work_dtl\302011468_85\0152\53-sh-light1033.dgn



745 McCintock Drive
Suite 210
Burr Ridge, IL 60527
Ph. 773-451-4788
www.abnaincorp.com

USER NAME

= hbmeppw11cs01\$

DESIGNED -

FPE

DRAWN -

LNK

CHECKED -

JMO

DATE

= 12/9/2024

REVIS

= 4/8/2025 LNK

REVIS

=

REVIS

=

REVIS

=

PLOT SCALE

= 100.0000 ' / in.

PLOT DATE

= 4/10/2025




DESIGNED -	FPE	REVIS	= 4/8/2025 LNK
DRAWN -	LNK	REVIS	=
CHECKED -	JMO	REVIS	=
DATE	= 12/9/2024	REVIS	=




STATE OF ILLINOIS
DEPARTMENT OF TRANSPORTATION

LIGHTING PLAN
I-94 (BISHOP FORD EXPY)

SCALE: SHEET 12 OF 22 SHEETS STA. 542+00 TO STA. 555+50

F.A.I. RTE.	SECTION	COUNTY	TOTAL SHEETS	SHEET NO.
94	(42-B-11-1) BR, BJR 24	COOK	761	414
CONTRACT NO. 62W87				
ILLINOIS FED. AID PROJECT				

 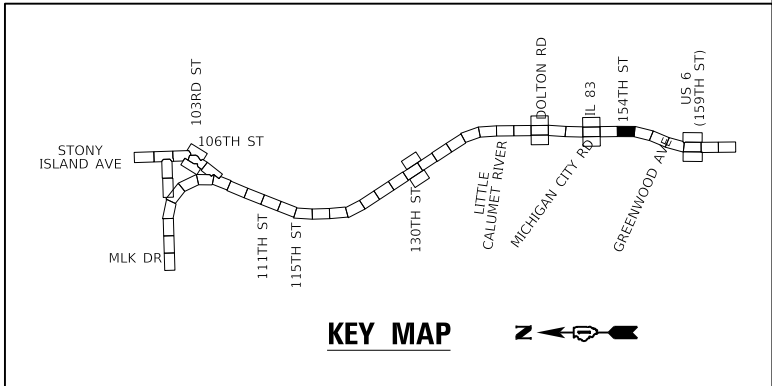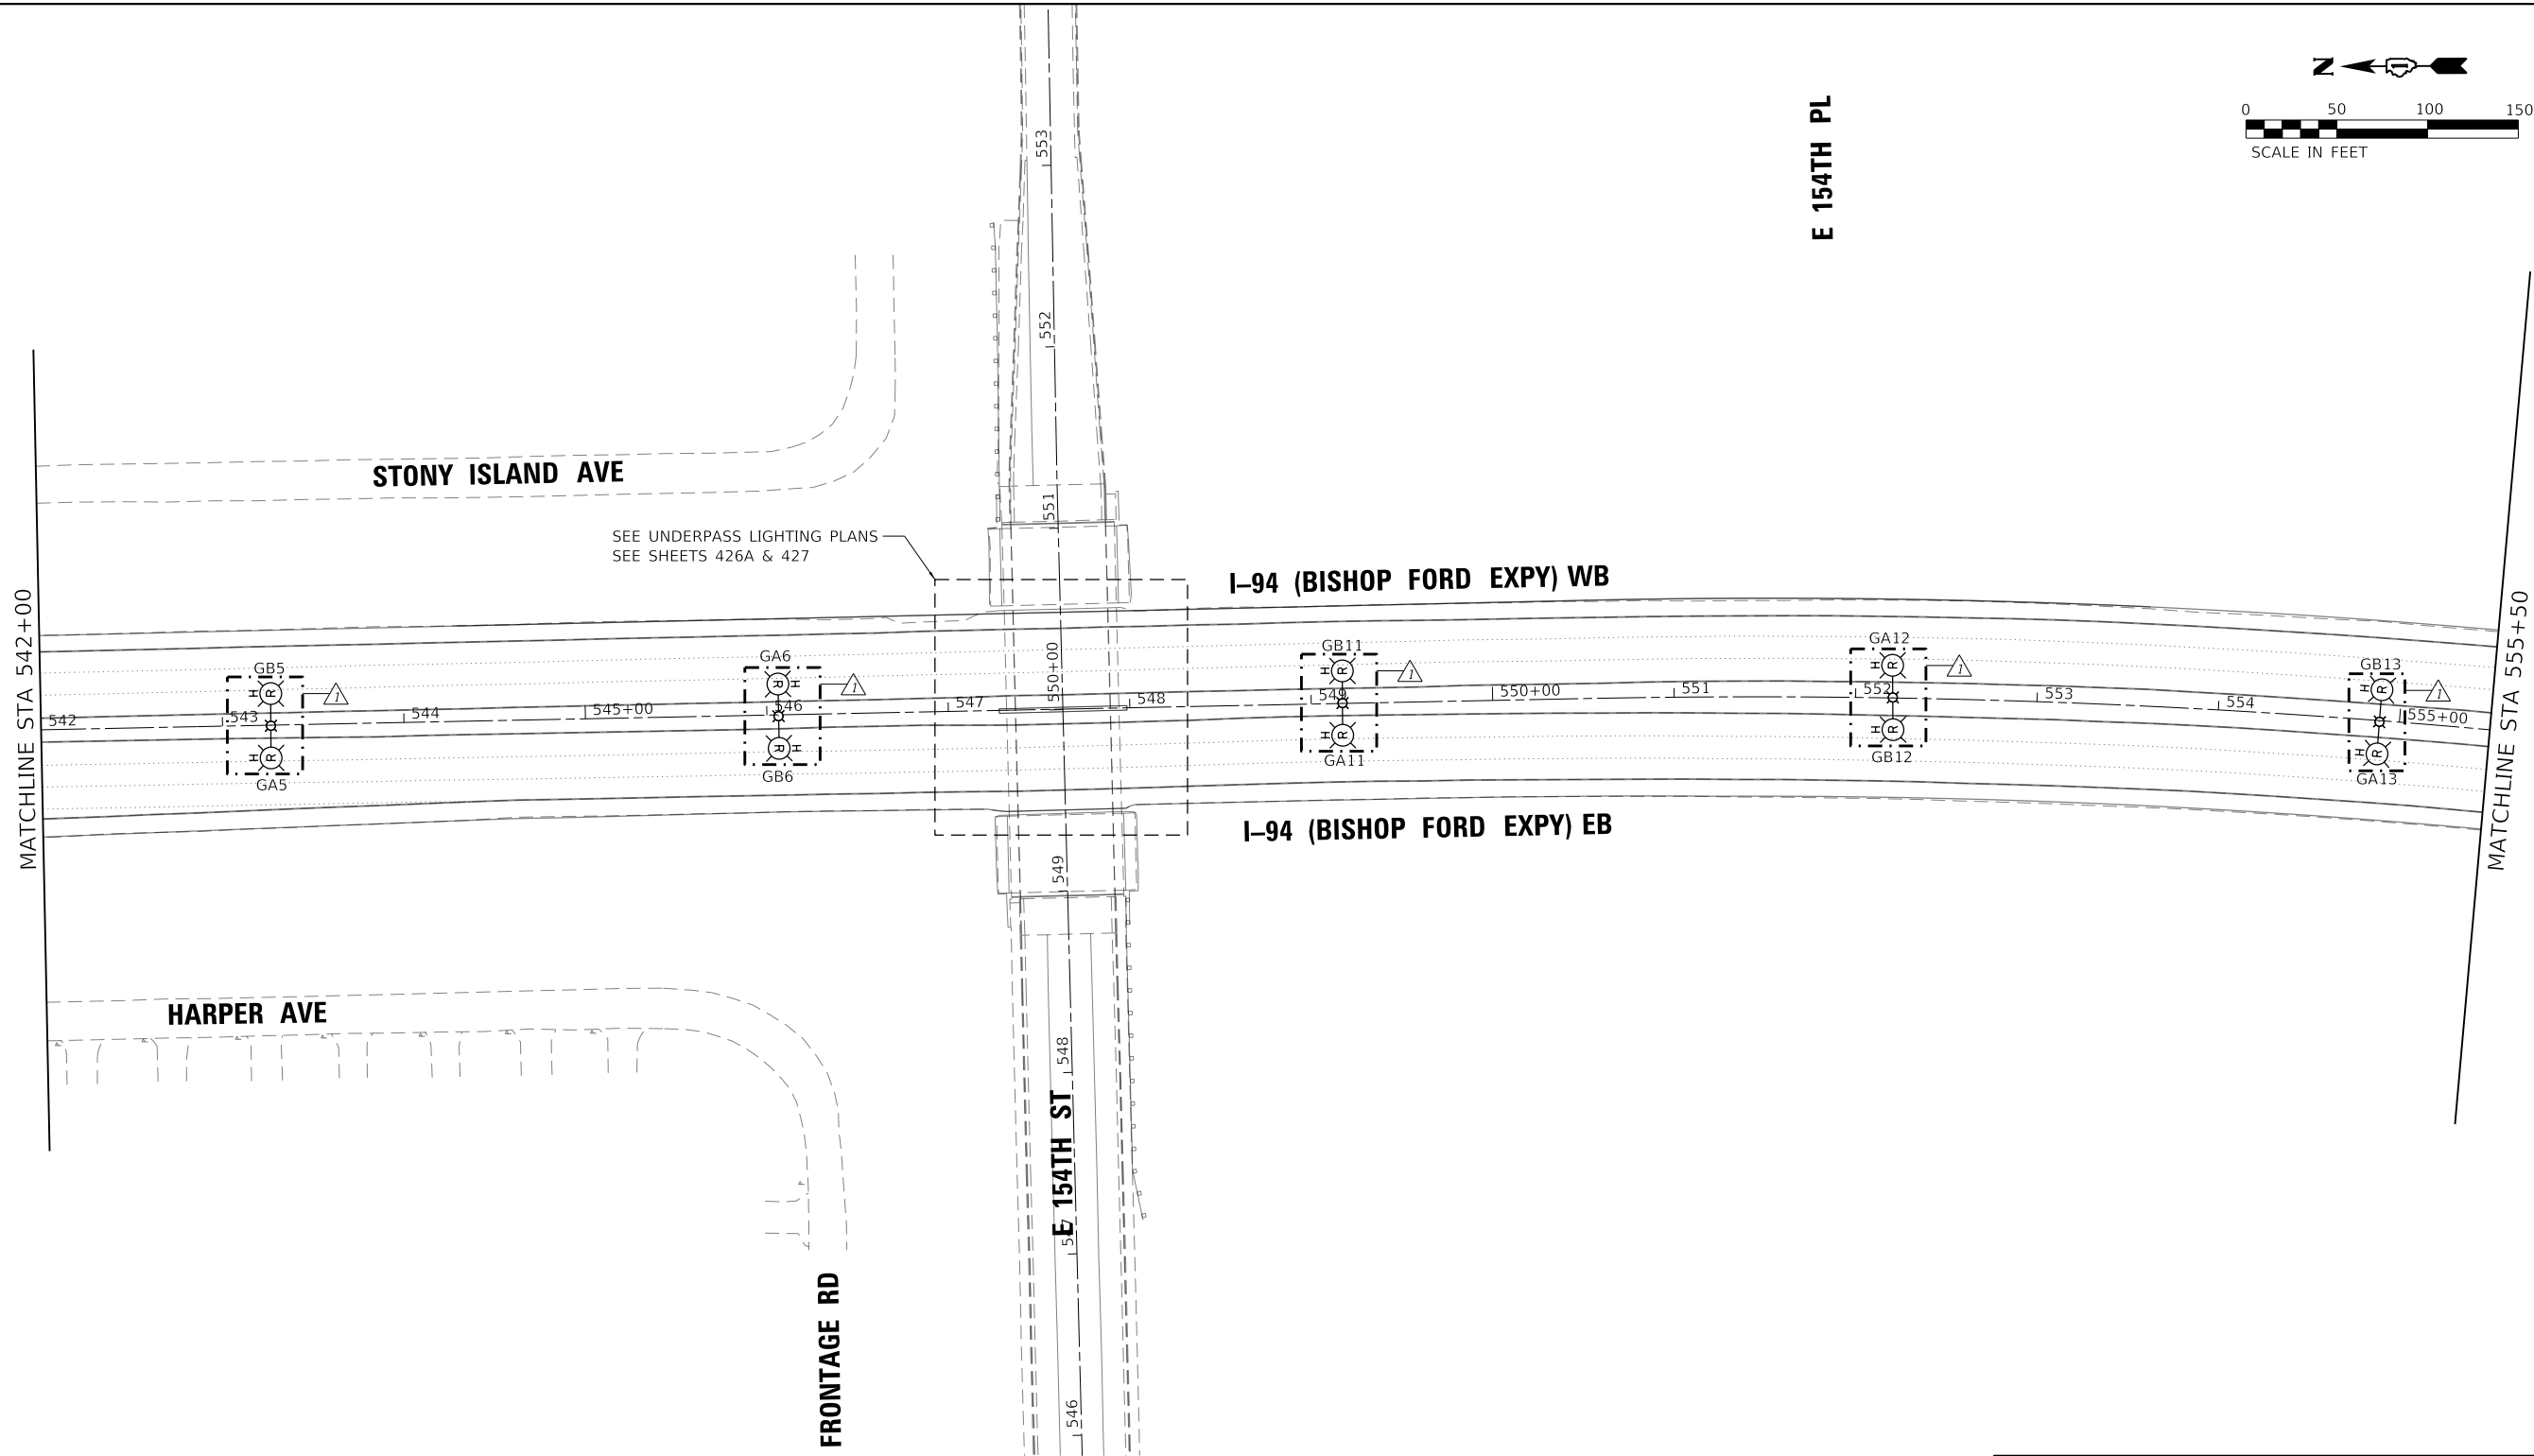

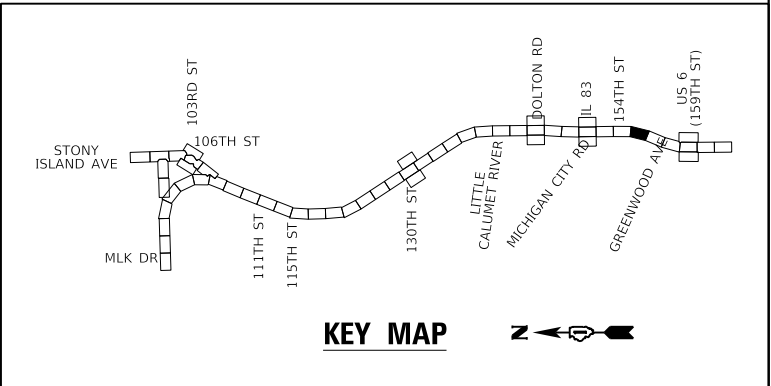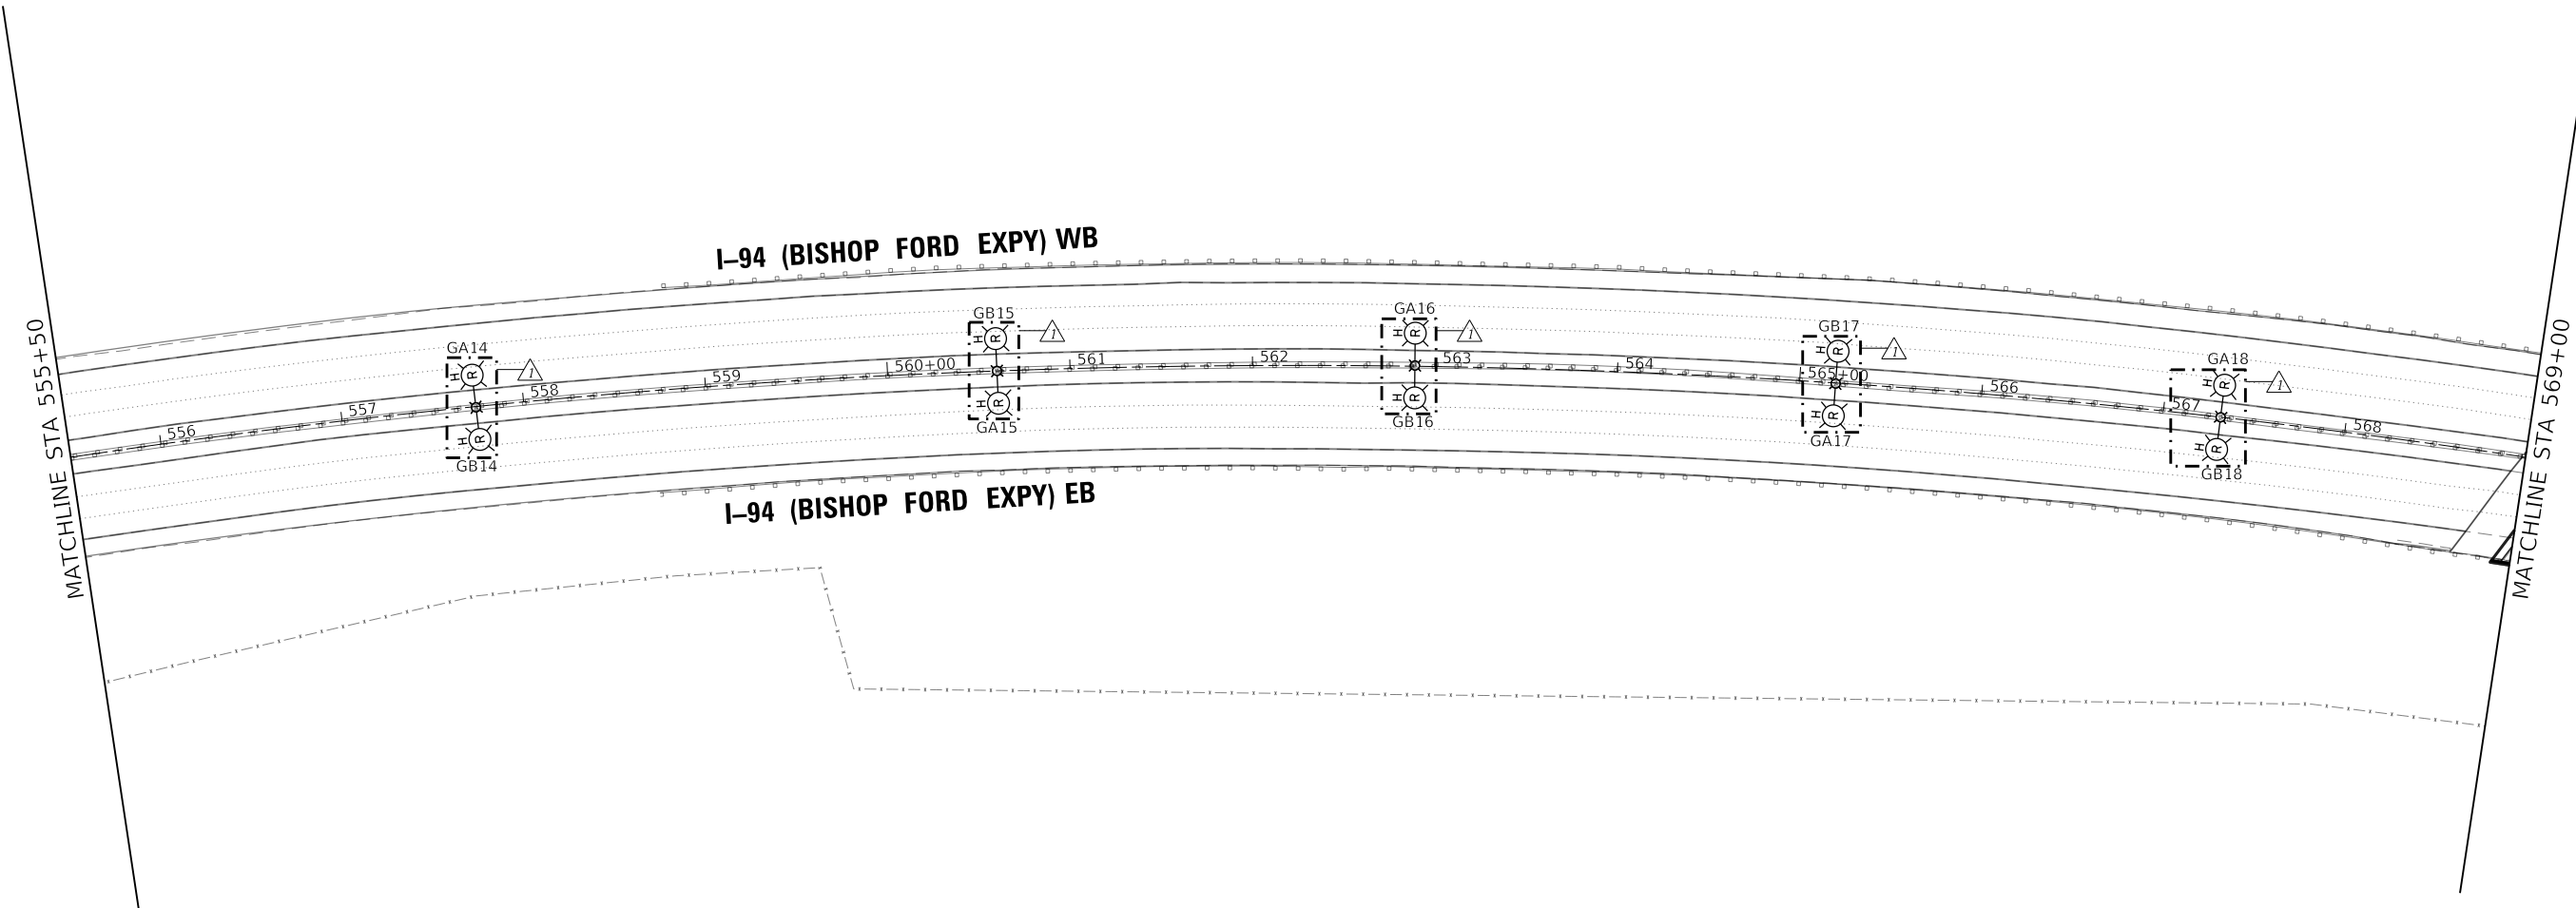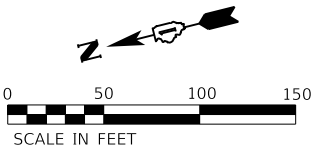

MODEL: Default
FILE: \\net1\work\11cs01\CS_gdf_work\dlr\2024\1468_86\0152\53-sh-light\024.dgn



745 McCintock Drive
Suite 210
Burr Ridge, IL 60527
Ph. 773-451-4788
www.abnacorp.com


USER NAME	= hbmeppw11cs01s	DESIGNED -	FPE	REVISED -	4/8/2025 LNK
DRAWN -	LNK	REVISED -			
PLOT SCALE	= 100,0000 ' / in.	CHECKED -	JMO	REVISED -	
PLOT DATE	= 4/10/2025	DATE -	12/9/2024	REVISED -	

STATE OF ILLINOIS
DEPARTMENT OF TRANSPORTATION


LIGHTING PLAN
I-94 (BISHOP FORD EXPY)

SCALE: SHEET 13 OF 22 SHEETS STA. 555+50 TO STA. 569+00



F.A.I. RTE.	SECTION	COUNTY	TOTAL SHEETS	SHEET NO.
94	(42-B-11-1) BR, BJR 24	COOK	761	415
CONTRACT NO. 62W87				
		ILLINOIS	FED. AID PROJECT	

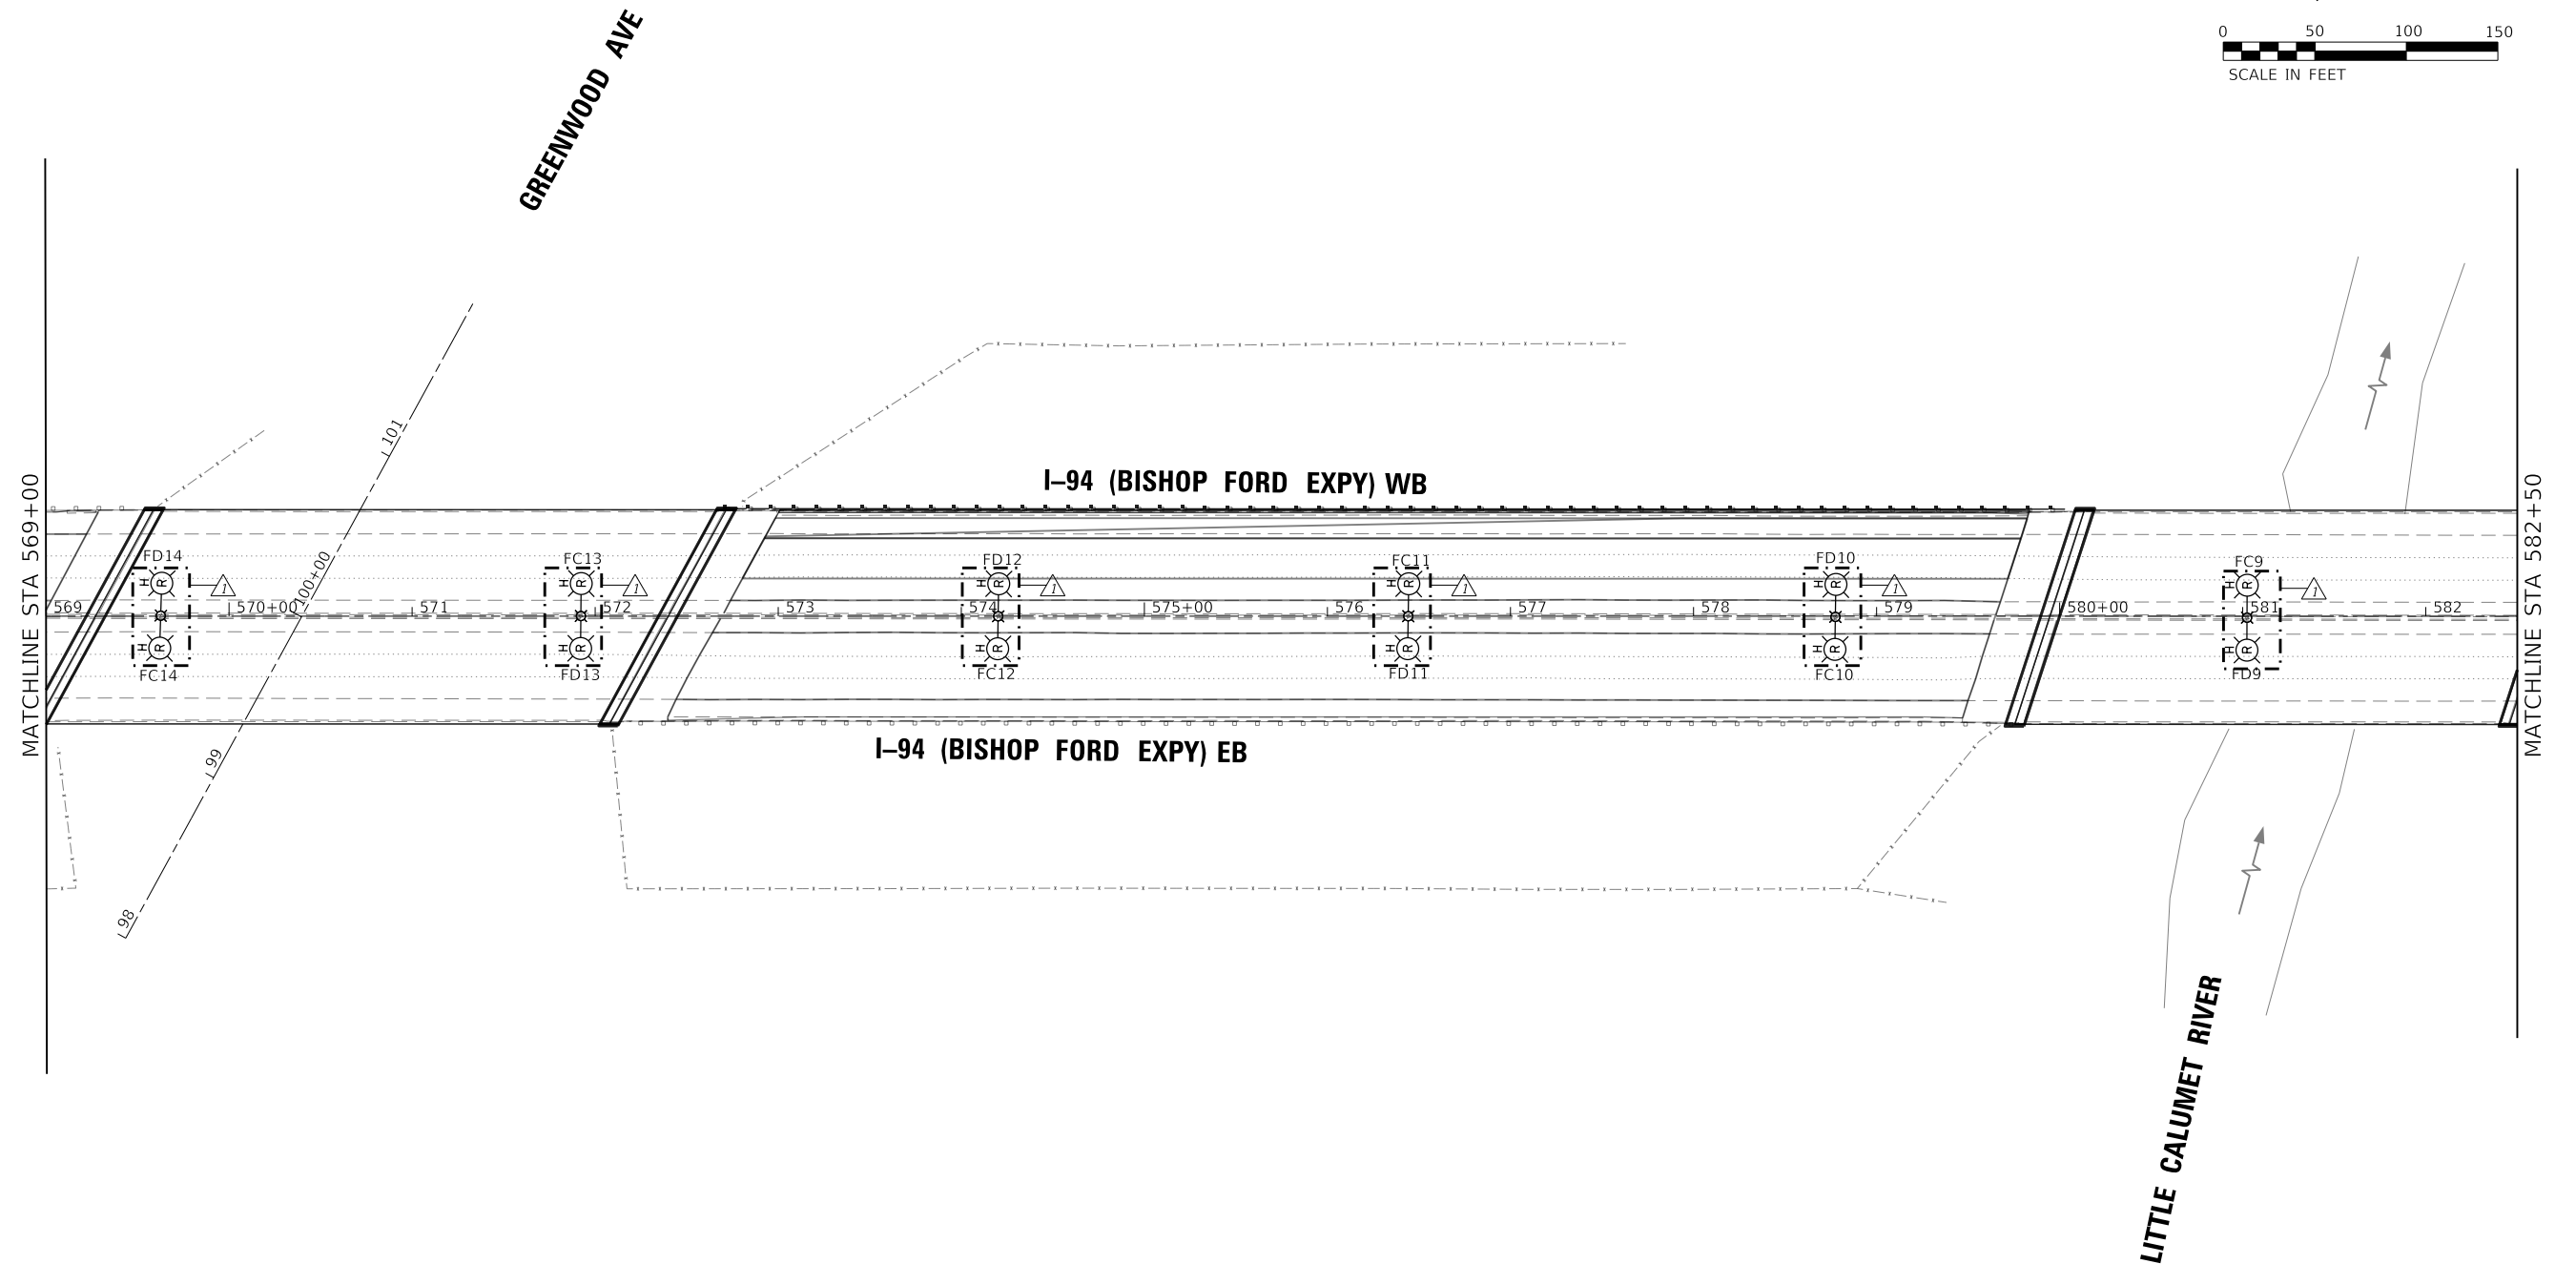

 ABNA DESIGN FIRM REG. 184,002117 www.abnaincorp.com 745 McClellan Drive Suite 210 Burr Ridge, IL 60527 Ph. 773-651-0788 www.abnaincorp.com	USER NAME = hbmepw1jics01s	DESIGNED - FPE	REVISED - 4/8/2025 LNK	STATE OF ILLINOIS DEPARTMENT OF TRANSPORTATION	LIGHTING PLAN					F.A.I.	SECTION	COUNTY	TOTAL	SHEET
	PLOT SCALE = 100,000' / in.	DRAWN - LNK	REVISED -		I-94 (BISHOP FORD EXPY)					R.T.E.			SHEETS	NO.
	PLOT DATE = 4/10/2025	CHECKED - JMO	REVISED -							94	(42-B-11-1) BR, BJR 24	COOK	761	416
		DATE = 12/9/2024	REVISED -							CONTRACT NO. 62W87				
					SCALE: SHEET 14 OF 22 SHEETS STA. 569+00 TO STA. 582+50					ILLINOIS FED. AID PROJECT				


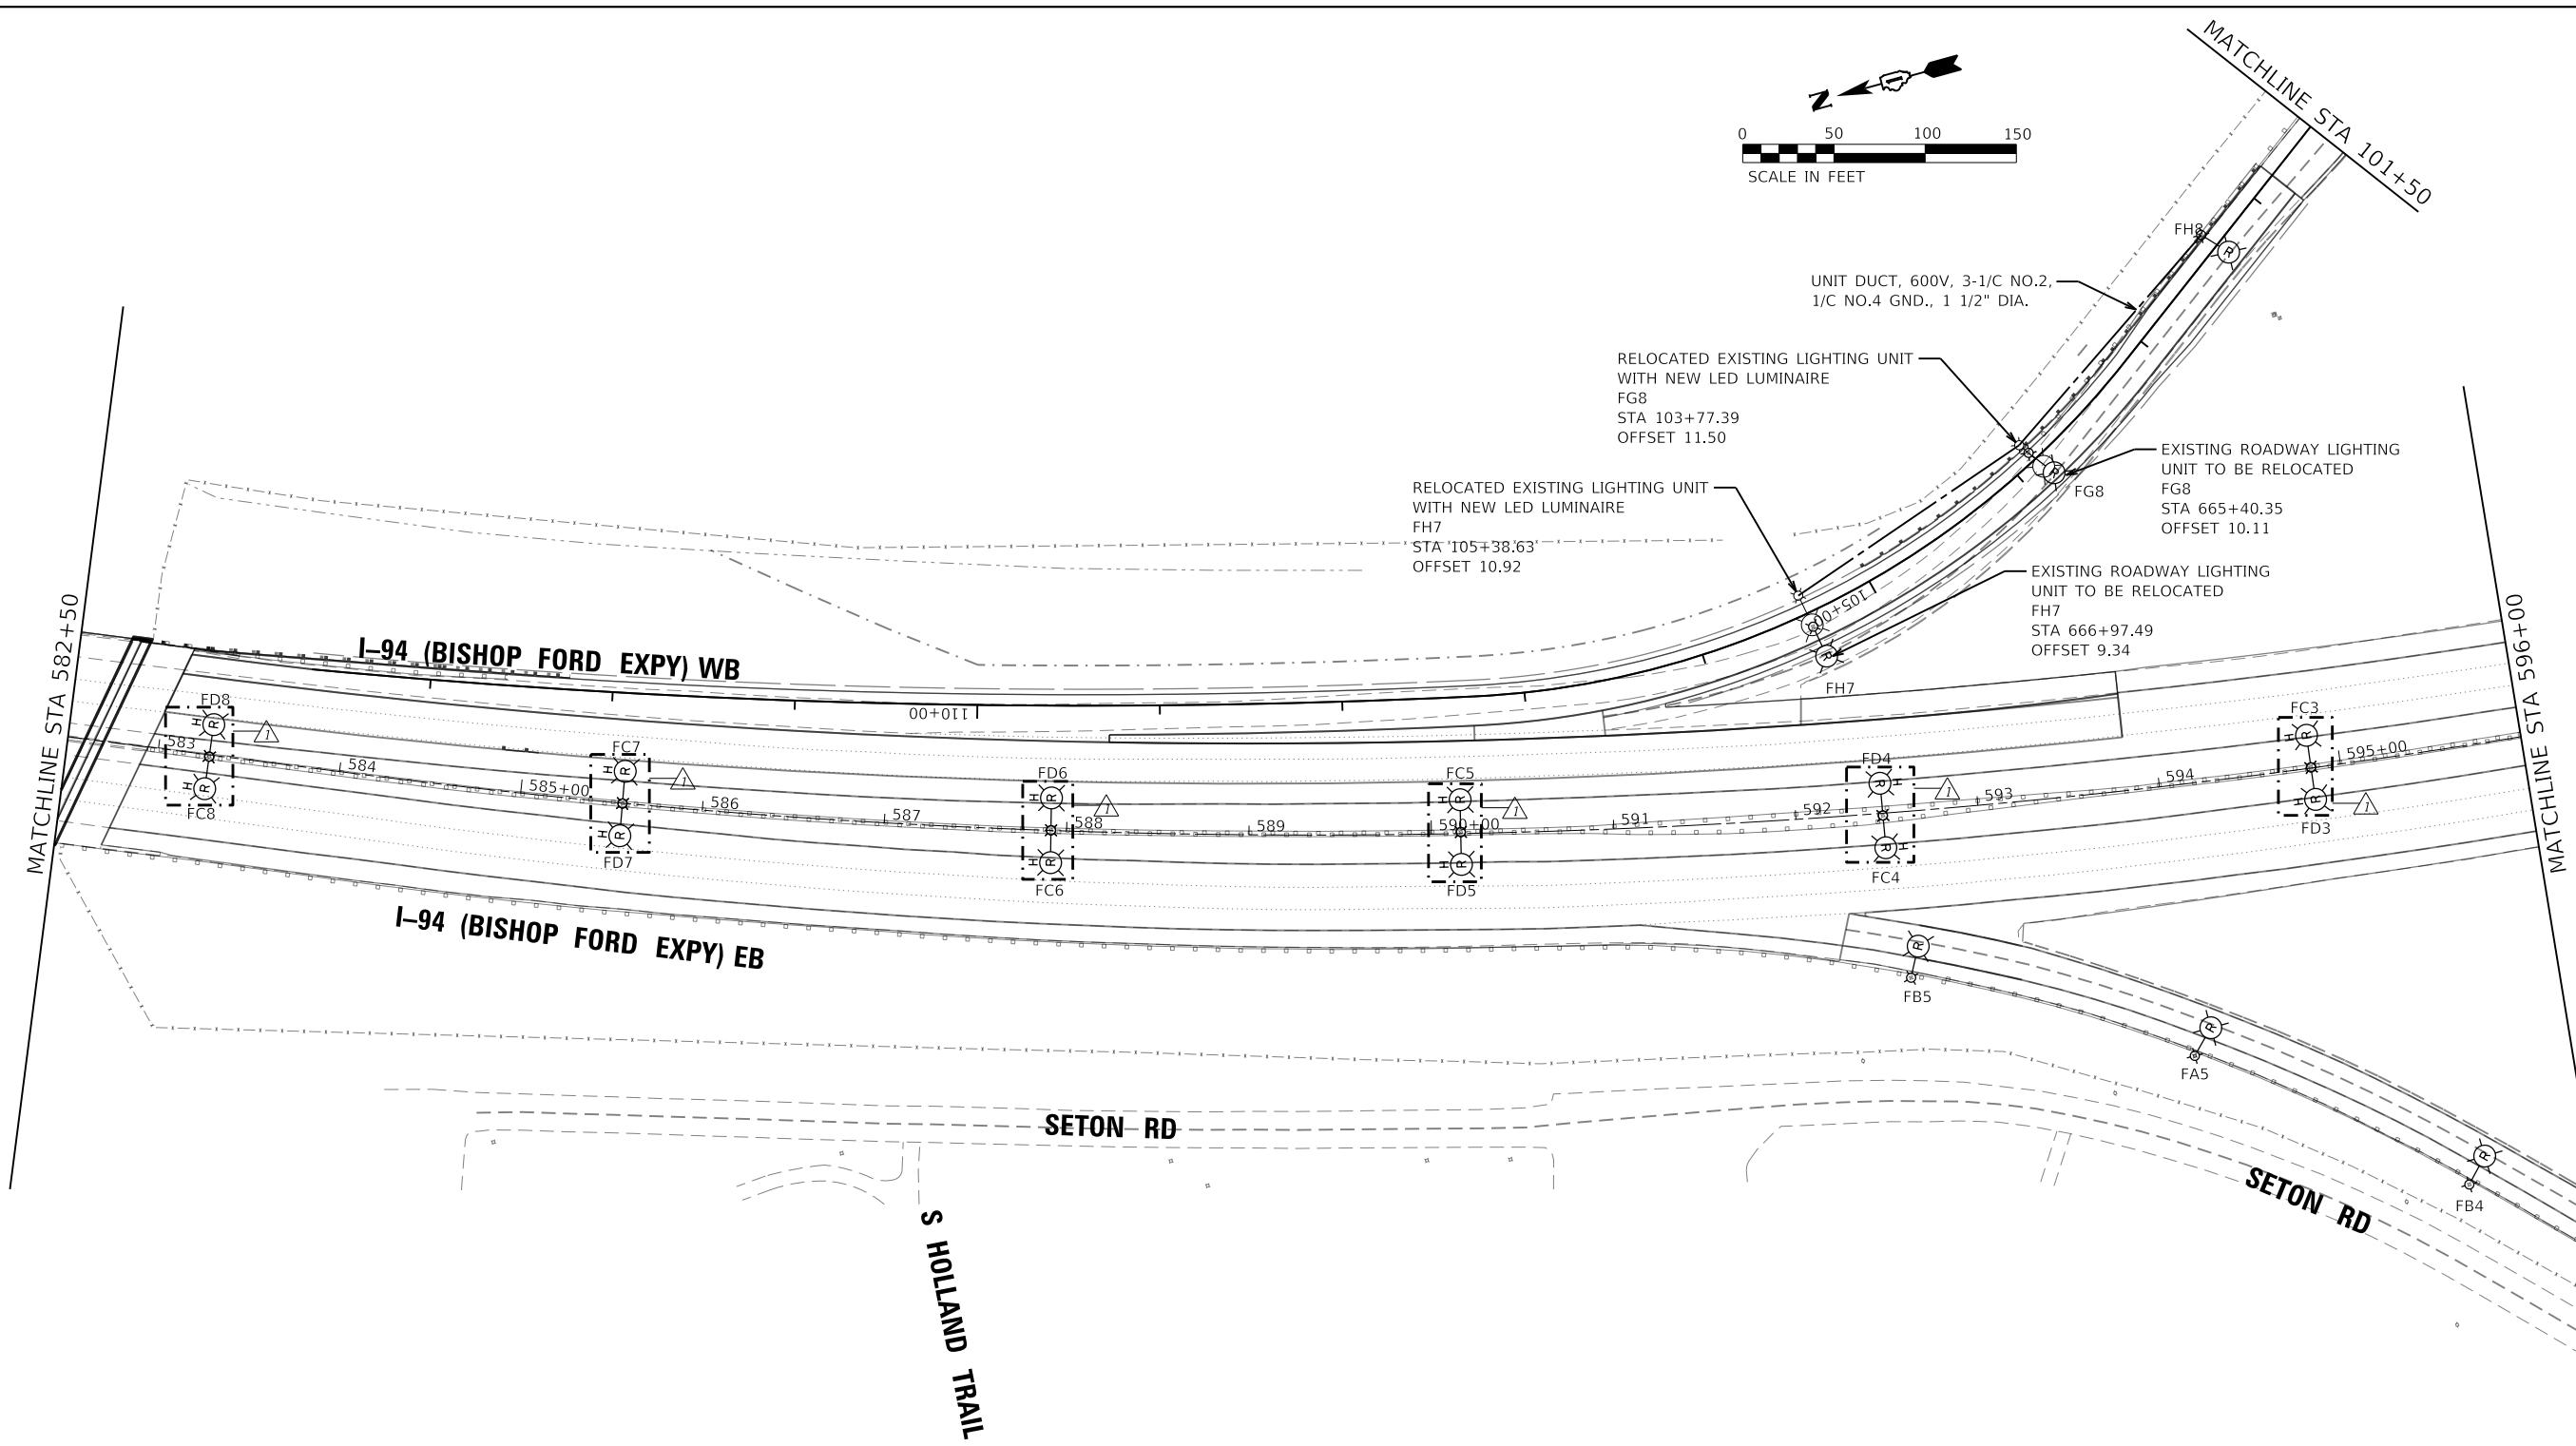


 ABNA DESIGN FROM REG. 104,002117 745 McClellan Drive Suite 210 Burr Ridge, IL 60527 Ph. 773-851-4788 www.abnacorp.com	USER NAME = hbmepw11ics01s	DESIGNED - FPE	REVISED - 4/8/2025 LNK	STATE OF ILLINOIS DEPARTMENT OF TRANSPORTATION	LIGHTING PLAN I-94 (BISHOP FORD EXPY)	F.A.I. RTE.	SECTION	COUNTY	TOTAL SHEETS	SHEET NO.	
	PLOT SCALE = 100,000 ' / in.	CHECKED - JMO	REVISED -			94	(42-B-11-1) BR, BJR 24	COOK	761	417	
	PLOT DATE = 4/10/2025	DATE - 12/9/2024	REVISED -			CONTRACT NO. 62W87					
	SCALE:					SHEET 15	OF 22	SHEETS	STA. 582+50	TO STA. 596+00	
										ILLINOIS FED. AID PROJECT	

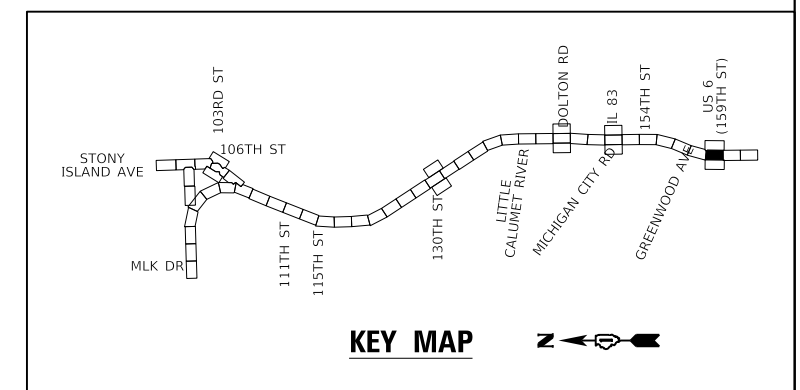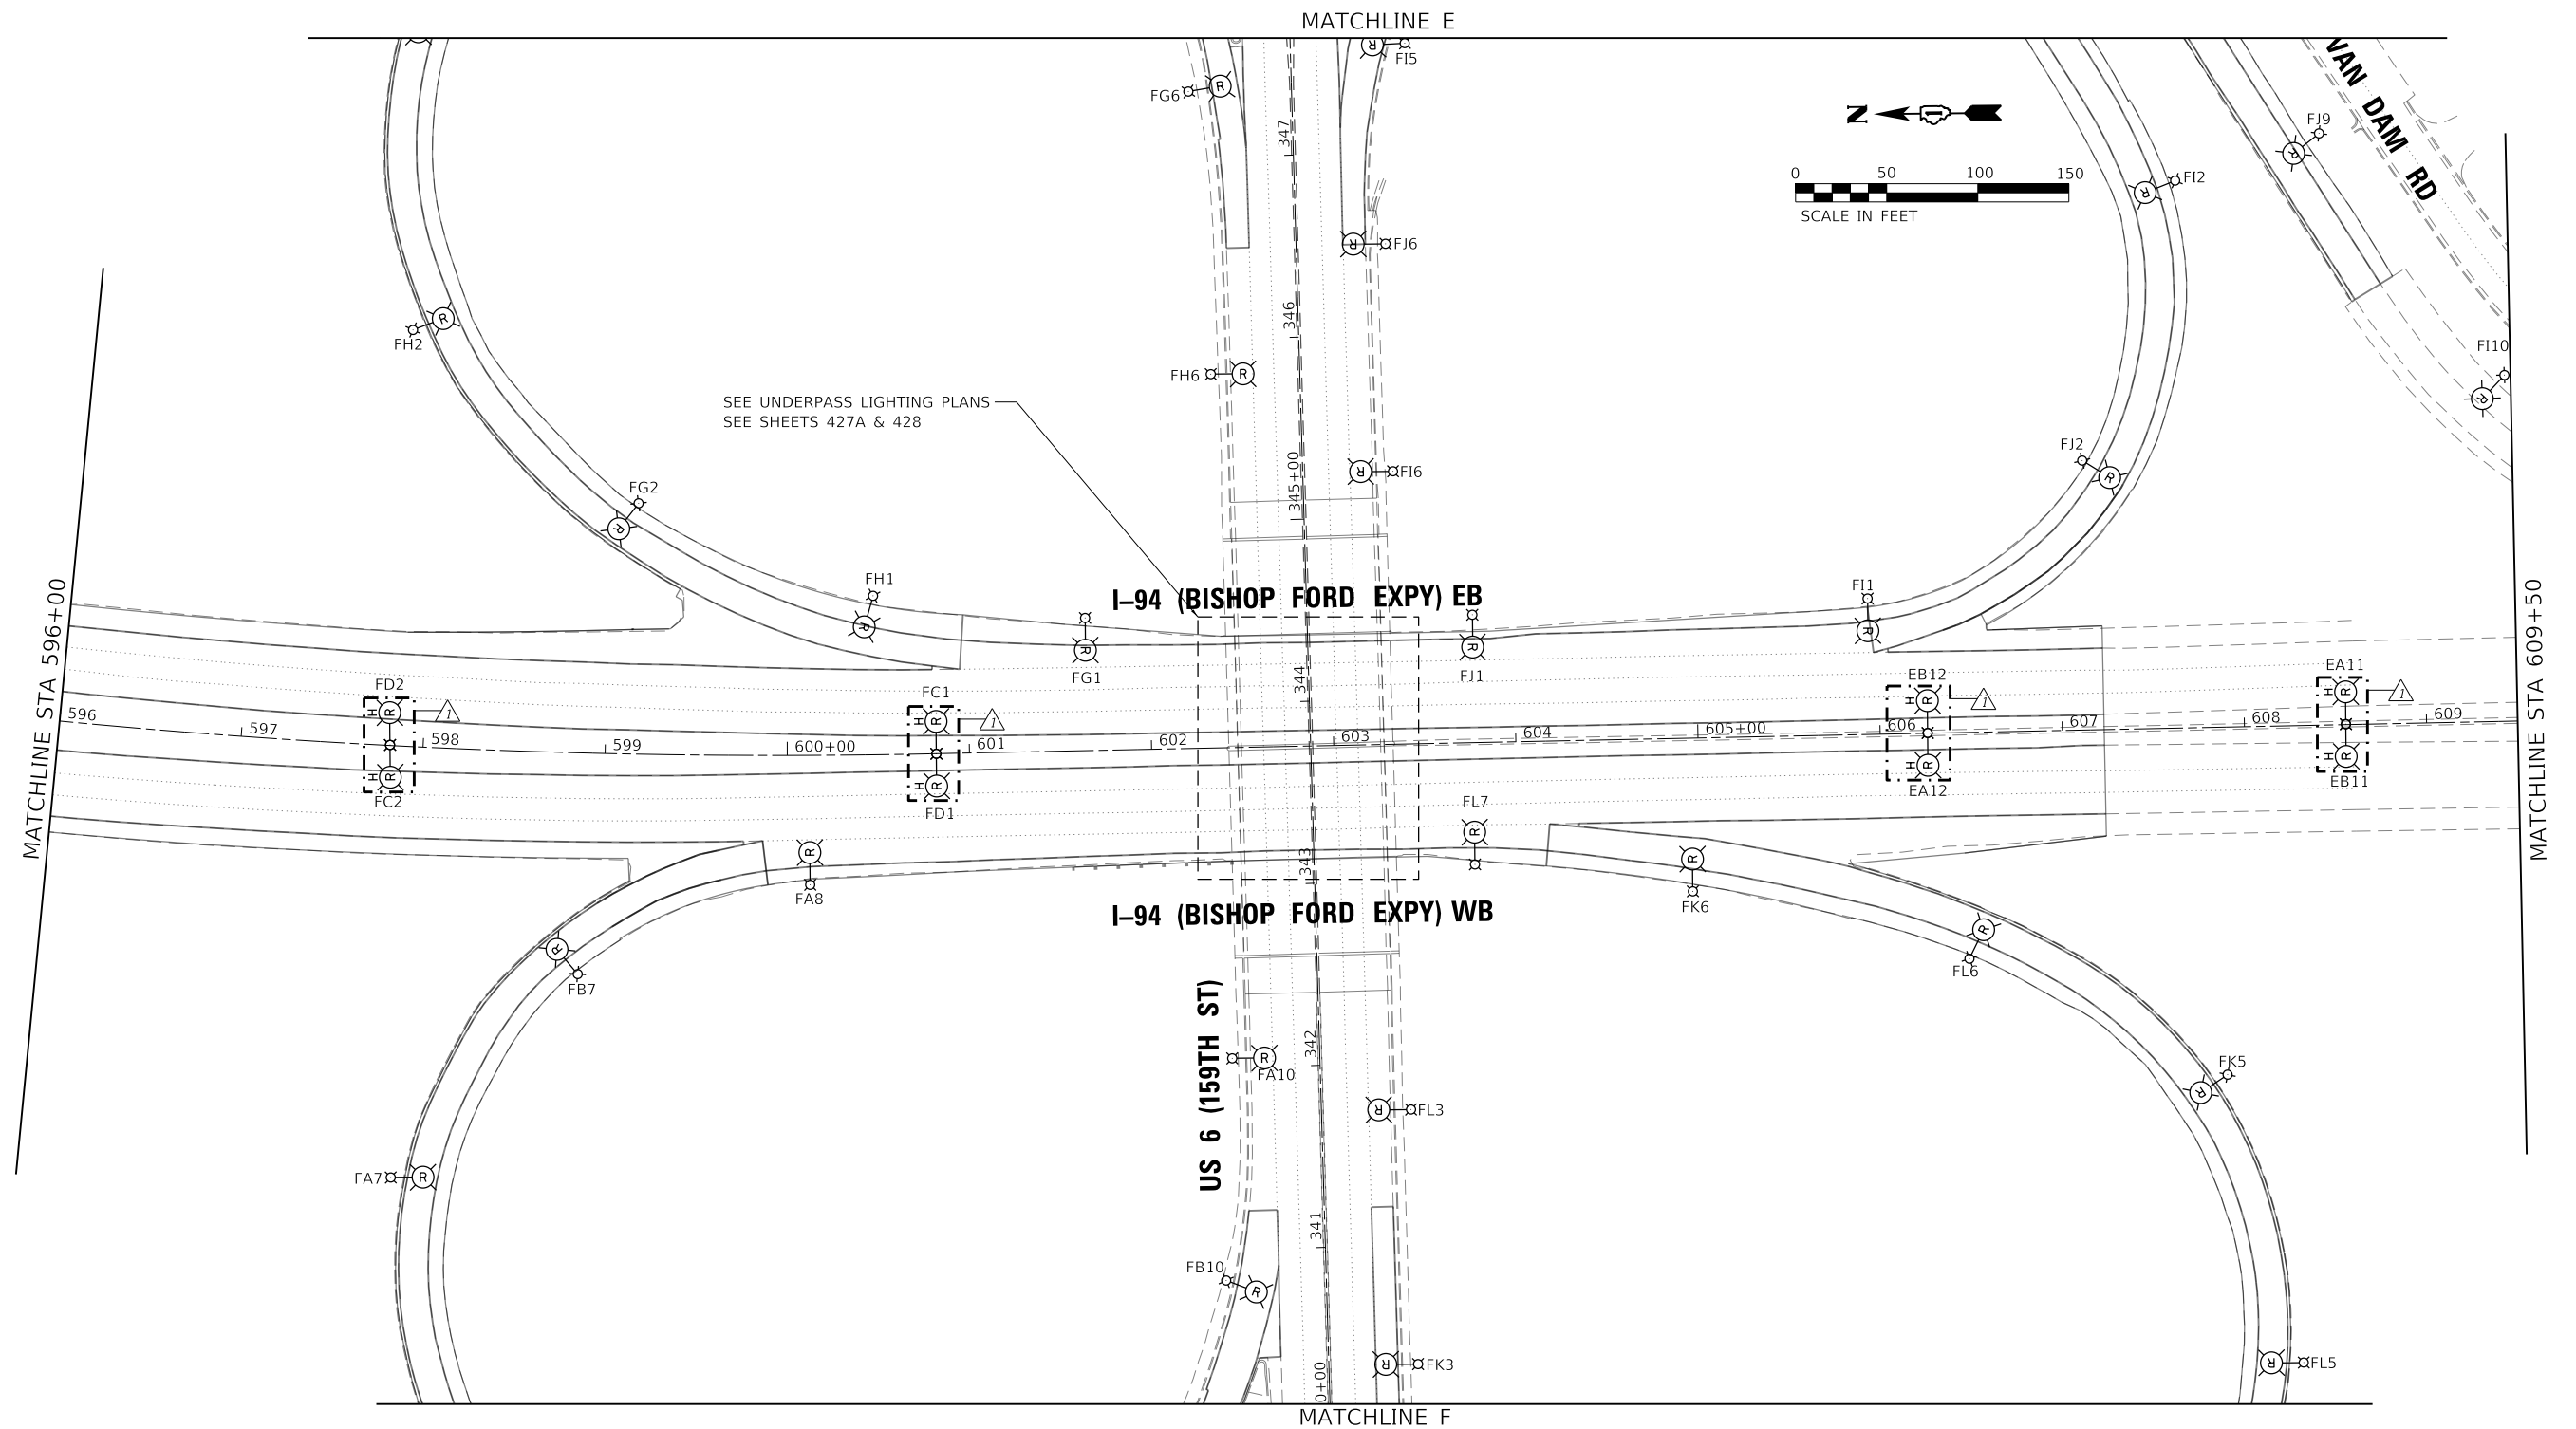

NOTES:

- 1 LIGHTING SYSTEM, INCLUDING WIRING INSTALLED ON PREVIOUS CONTRACT.
- 2 LUMINAIRES FOR ROADWAY AND UNDERPASS TO BE REPLACED WITH LED LUMINAIRES

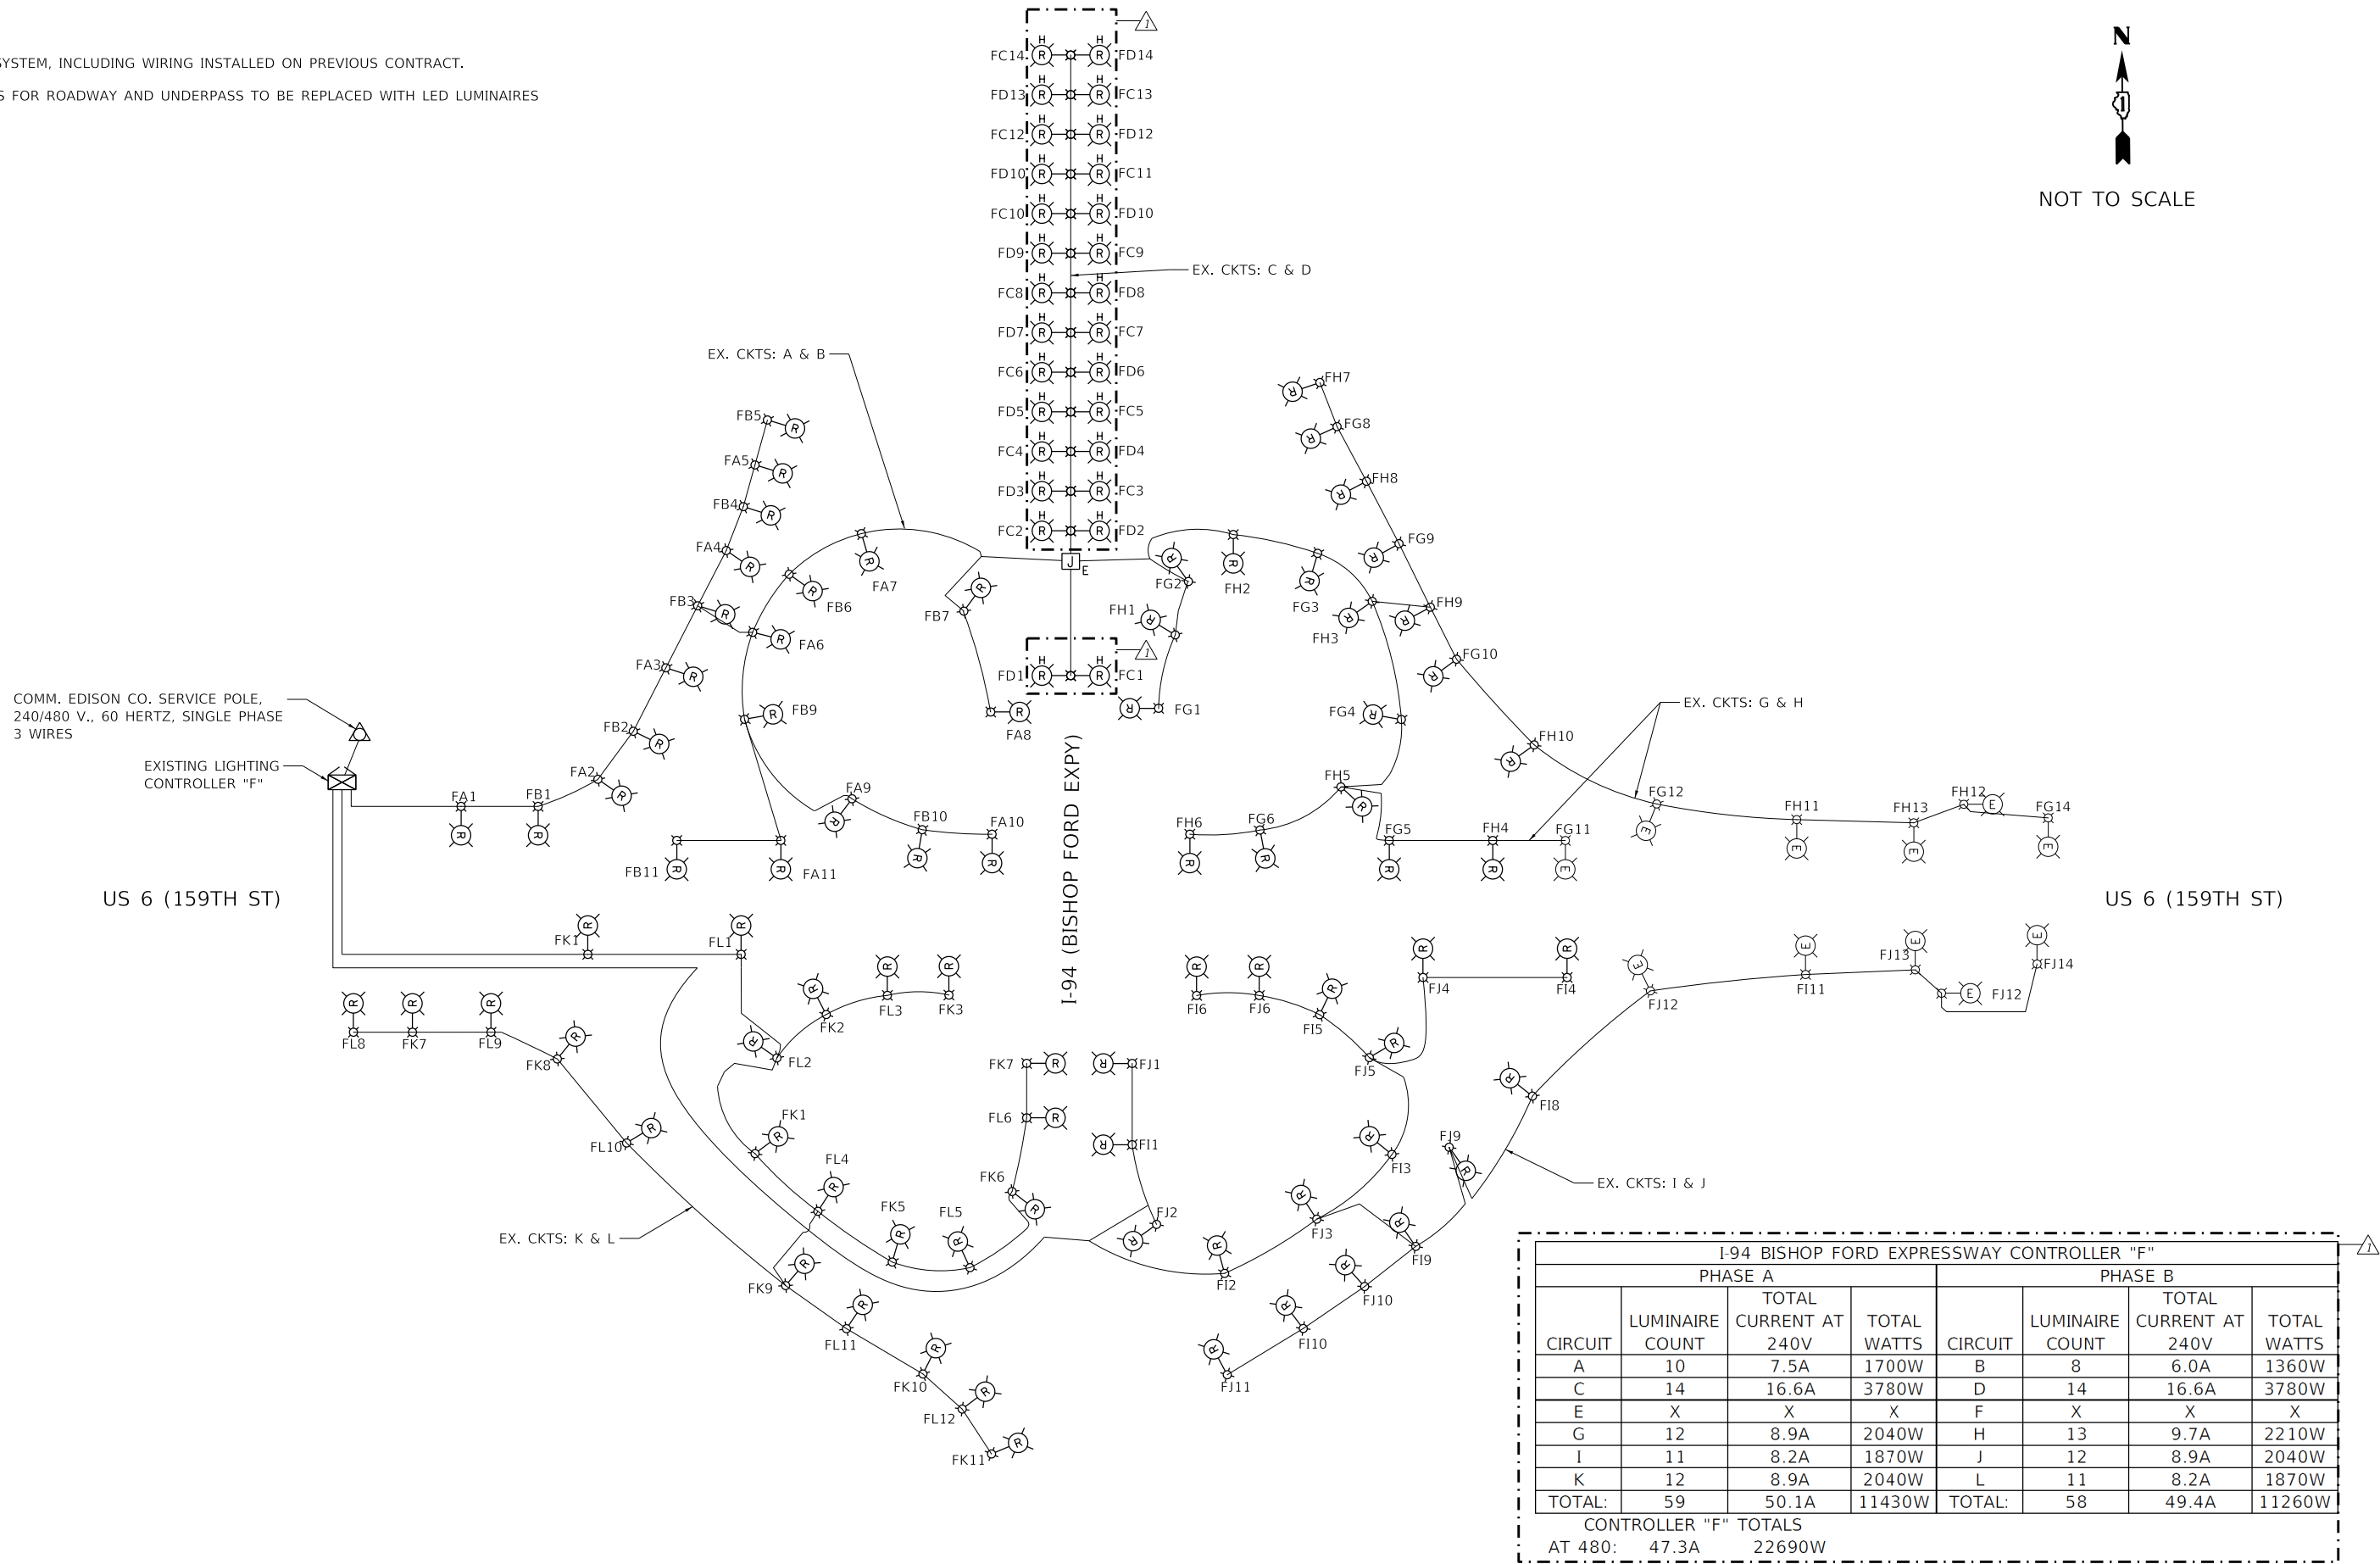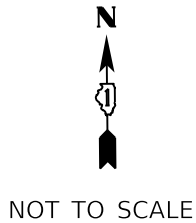

I-94 BISHOP FORD EXPRESSWAY CONTROLLER "F"							
PHASE A				PHASE B			
CIRCUIT	LUMINAIRE COUNT	TOTAL CURRENT AT 240V	TOTAL WATTS	CIRCUIT	LUMINAIRE COUNT	TOTAL CURRENT AT 240V	TOTAL WATTS
A	10	7.5A	1700W	B	8	6.0A	1360W
C	14	16.6A	3780W	D	14	16.6A	3780W
E	X	X	X	F	X	X	X
G	12	8.9A	2040W	H	13	9.7A	2210W
I	11	8.2A	1870W	J	12	8.9A	2040W
K	12	8.9A	2040W	L	11	8.2A	1870W
TOTAL:	59	50.1A	11430W	TOTAL:	58	49.4A	11260W
CONTROLLER "F" TOTALS							
AT 480:		47.3A	22690W				

MODEL Default
FILE Name: W:\msepaw11\cs01\CS_gdf_work_dtl\3020411468_2010\162\K53-ctrl-light-one line diagram-02.dgn



USER NAME = hbmepw11cs01s	DESIGNED - FPE	REVISED - 4/8/2025 LNK
	DRAWN - LNK	REVISED -
PLOT SCALE = 100,0000 ' / in.	CHECKED - JMO	REVISED -
PLOT DATE = 4/10/2025	DATE - 12/9/2024	REVISED -


STATE OF ILLINOIS
DEPARTMENT OF TRANSPORTATION

LIGHTING PLAN ONE LINE DIAGRAM CONTROLLER "F"
I-94 (BISHOP FORD EXPY)

SCALE: SHEET 21 OF 22 SHEETS STA. TO STA.

F.A.I. RTE.	SECTION	COUNTY	TOTAL SHEETS	SHEET NO.
94	(42-B-11-1) BR, BJR 24	COOK	761	423
CONTRACT NO. 62W87				
ILLINOIS FED. AID PROJECT				

NOT TO SCALE

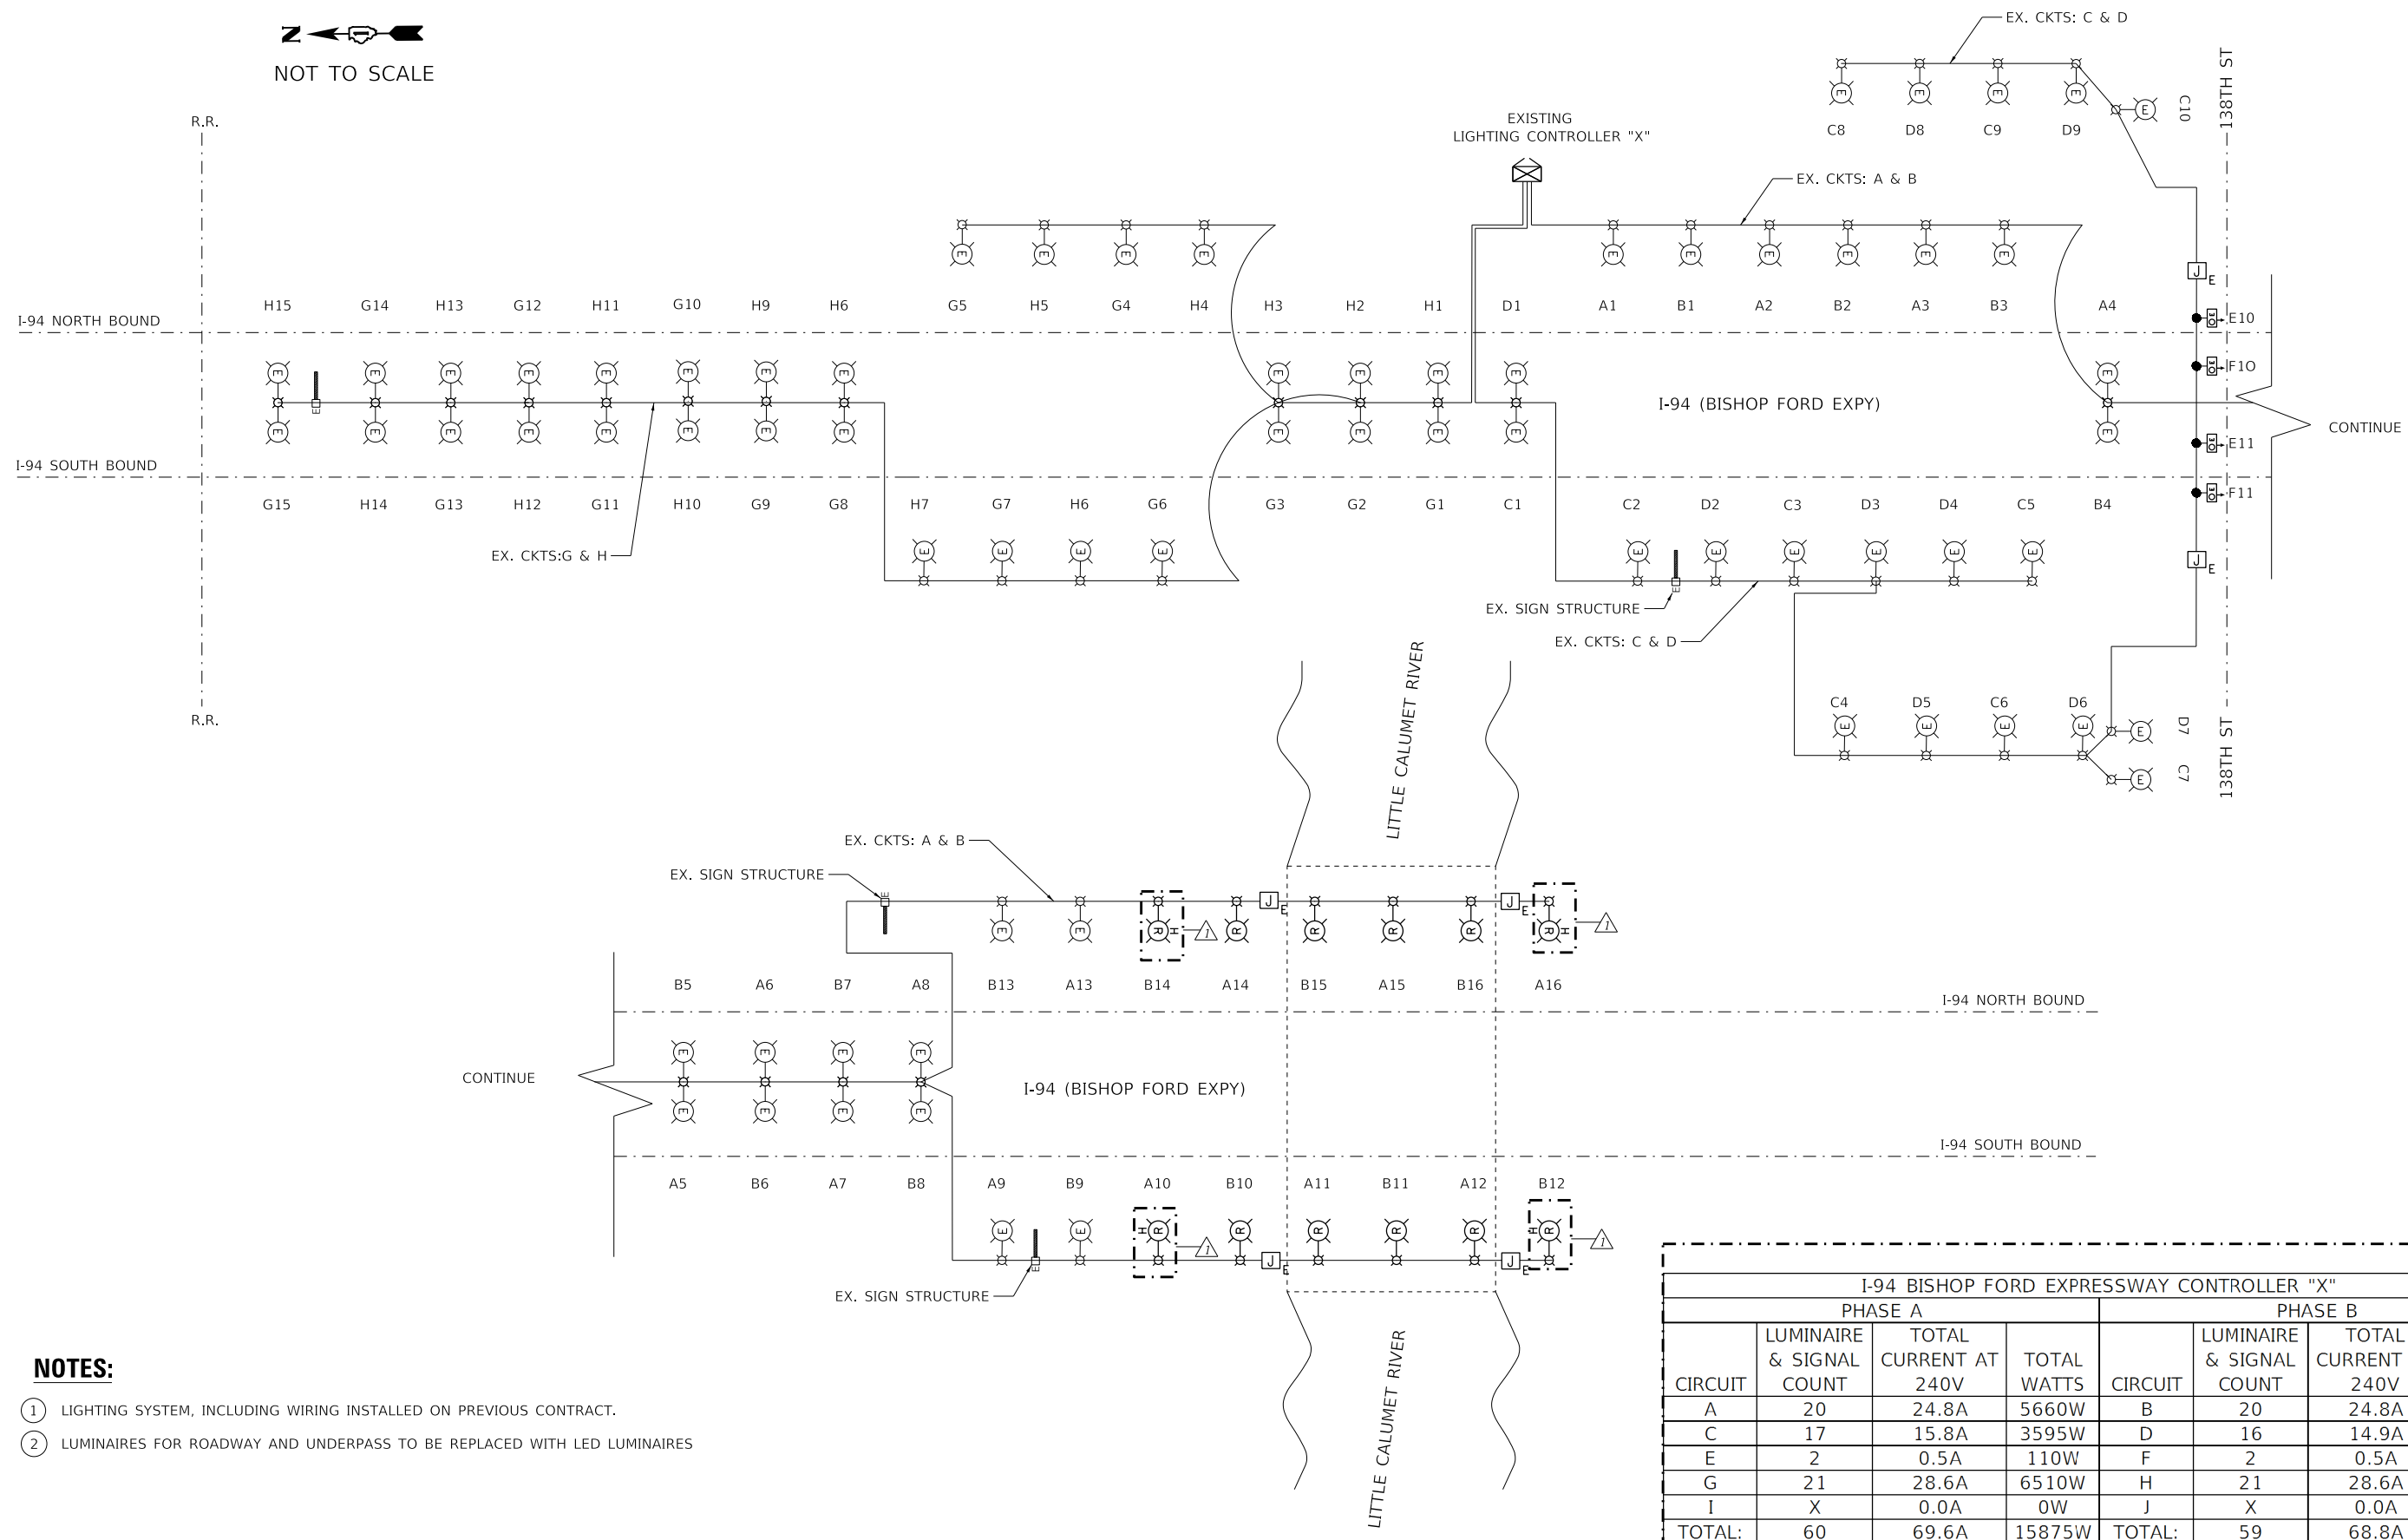

NOTES:

- 1 LIGHTING SYSTEM, INCLUDING WIRING INSTALLED ON PREVIOUS CONTRACT.
- 2 LUMINAIRES FOR ROADWAY AND UNDERPASS TO BE REPLACED WITH LED LUMINAIRES

I-94 BISHOP FORD EXPRESSWAY CONTROLLER "X"							
PHASE A				PHASE B			
CIRCUIT	LUMINAIRE & SIGNAL COUNT	TOTAL CURRENT AT 240V	TOTAL WATTS	CIRCUIT	LUMINAIRE & SIGNAL COUNT	TOTAL CURRENT AT 240V	TOTAL WATTS
A	20	24.8A	5660W	B	20	24.8A	5660W
C	17	15.8A	3595W	D	16	14.9A	3395W
E	2	0.5A	110W	F	2	0.5A	110W
G	21	28.6A	6510W	H	21	28.6A	6510W
I	X	0.0A	0W	J	X	0.0A	0W
TOTAL:	60	69.6A	15875W	TOTAL:	59	68.8A	15675W
CONTROLLER "X" TOTALS							
AT 480:		65.7A	31550W				

MODEL: Default
FILE: \\miller\c:\wms\wms\11cs01\CS_gdf_work_dtl\30201448_2085D163K53-ctrl-light-one line diagram-04.dgn



745 McClellan Drive
Suite 210
Burr Ridge, IL 60527
Ph: 773-451-4788
www.abnacorp.com


USER NAME = hbmeprw11cs01s	DESIGNED - FPE	REVISED - 4/8/2025 LNK
	DRAWN - LNK	REVISED -
PLOT SCALE = 100,0000 ' / in.	CHECKED - JMO	REVISED -
PLOT DATE = 4/10/2025	DATE - 02/17/2025	REVISED -

STATE OF ILLINOIS
DEPARTMENT OF TRANSPORTATION


LIGHTING PLAN ONE LINE DIAGRAM CONTROLLER "X"
I-94 (BISHOP FORD EXPY)

SCALE: SHEET OF SHEETS STA. TO STA.

F.A.I. RTE.	SECTION	COUNTY	TOTAL SHEETS	SHEET NO.
94	(42-B-11-1) BR, BJR 24	COOK	761	424A
CONTRACT NO. 62W87				
ILLINOIS FED. AID PROJECT				

 

- EXISTING LIGHTING
CONTROLLER "G"

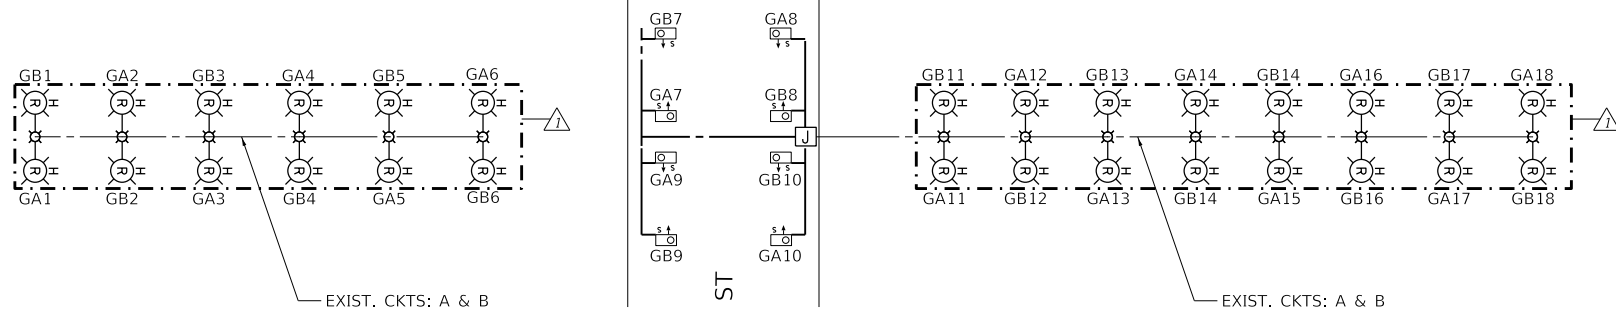

- ① LIGHTING SYSTEM, INCLUDING WIRING INSTALLED ON PREVIOUS CONTRACT.
- ② LUMINAIRES FOR ROADWAY AND UNDERPASS TO BE REPLACED WITH LED LUMINAIRES

I-94 BISHOP FORD EXPRESSWAY CONTROLLER "G"							
PHASE A				PHASE B			
CIRCUIT	LUMINAIRE COUNT	TOTAL CURRENT AT 240V	TOTAL WATTS	CIRCUIT	LUMINAIRE COUNT	TOTAL CURRENT AT 240V	TOTAL WATTS
A	18	17.7A	4040W	B	18	17.7A	4040W
C	X	X	X	D	X	X	0W
E	X	X	X	F	X	X	0W
G	X	X	X	H	X	X	0W
I	X	X	X	J	X	X	0W
K	X	X	X	L	X	X	0W
TOTAL:	18	17.7A	4040W	TOTAL:	18	17.7A	4040W
CONTROLLER "G" TOTALS							
AT 480:		16.8A	8080W				

USER NAME = hbmeprw1l1cs01s	DESIGNED - FPE	REVISED -  4/8/2025 LNK
	DRAWN - LNK	REVISED -
PLOT SCALE = 100,0000 ' / in.	CHECKED - JMO	REVISED -
PLOT DATE = 4/10/2025	DATE - 12/9/2024	REVISED -

**STATE OF ILLINOIS
DEPARTMENT OF TRANSPORTATION**

LIGHTING PLAN ONE LINE DIAGRAM CONTROLLER "G"
I-94 (BISHOP FORD EXPY)

SCALE:	SHEET 22	OF 22	SHEETS	STA.	TO STA.
--------	----------	-------	--------	------	---------

F.A.I. RTE.	SECTION	COUNTY	TOTAL SHEETS	SHEET NO.
94	(42-B-11-1) BR, BJR 24	COOK	761	424
		CONTRACT NO. 62W87		
		ILLINOIS	FED. AID PROJECT	

NOTES:


- 1

THE EXISTING CABLE, CONDUIT, AND JUNCTION BOXES SHALL BE REPLACED WITH NEW CABLE, CONDUIT AND JUNCTION BOXES.
- 2

THE PROPOSED LED LUMINAIRES SHALL BE INSTALLED PER IDOT DISTRICT 1 STANDARDS (SUSPENDED MOUNT LED UNDERPASS LUMINAIRE INSTALLATION DETAILS, STANDARD BE-901).
- 3

THE PROPOSED UNDERPASS LIGHTING UNIT SHALL BE SPACED 8.5 FEET FROM THE EDGE OF THE BRIDGE ON BOTH SIDES AND 2 FEET FORM THE EDGE OF PAVEMENT
- 4

DIMENSIONS SHOWN ON THE PLANS SHALL BE FOLLOWED. DISTANCES SHALL NOT BE SCALED FROM THE PLANS.

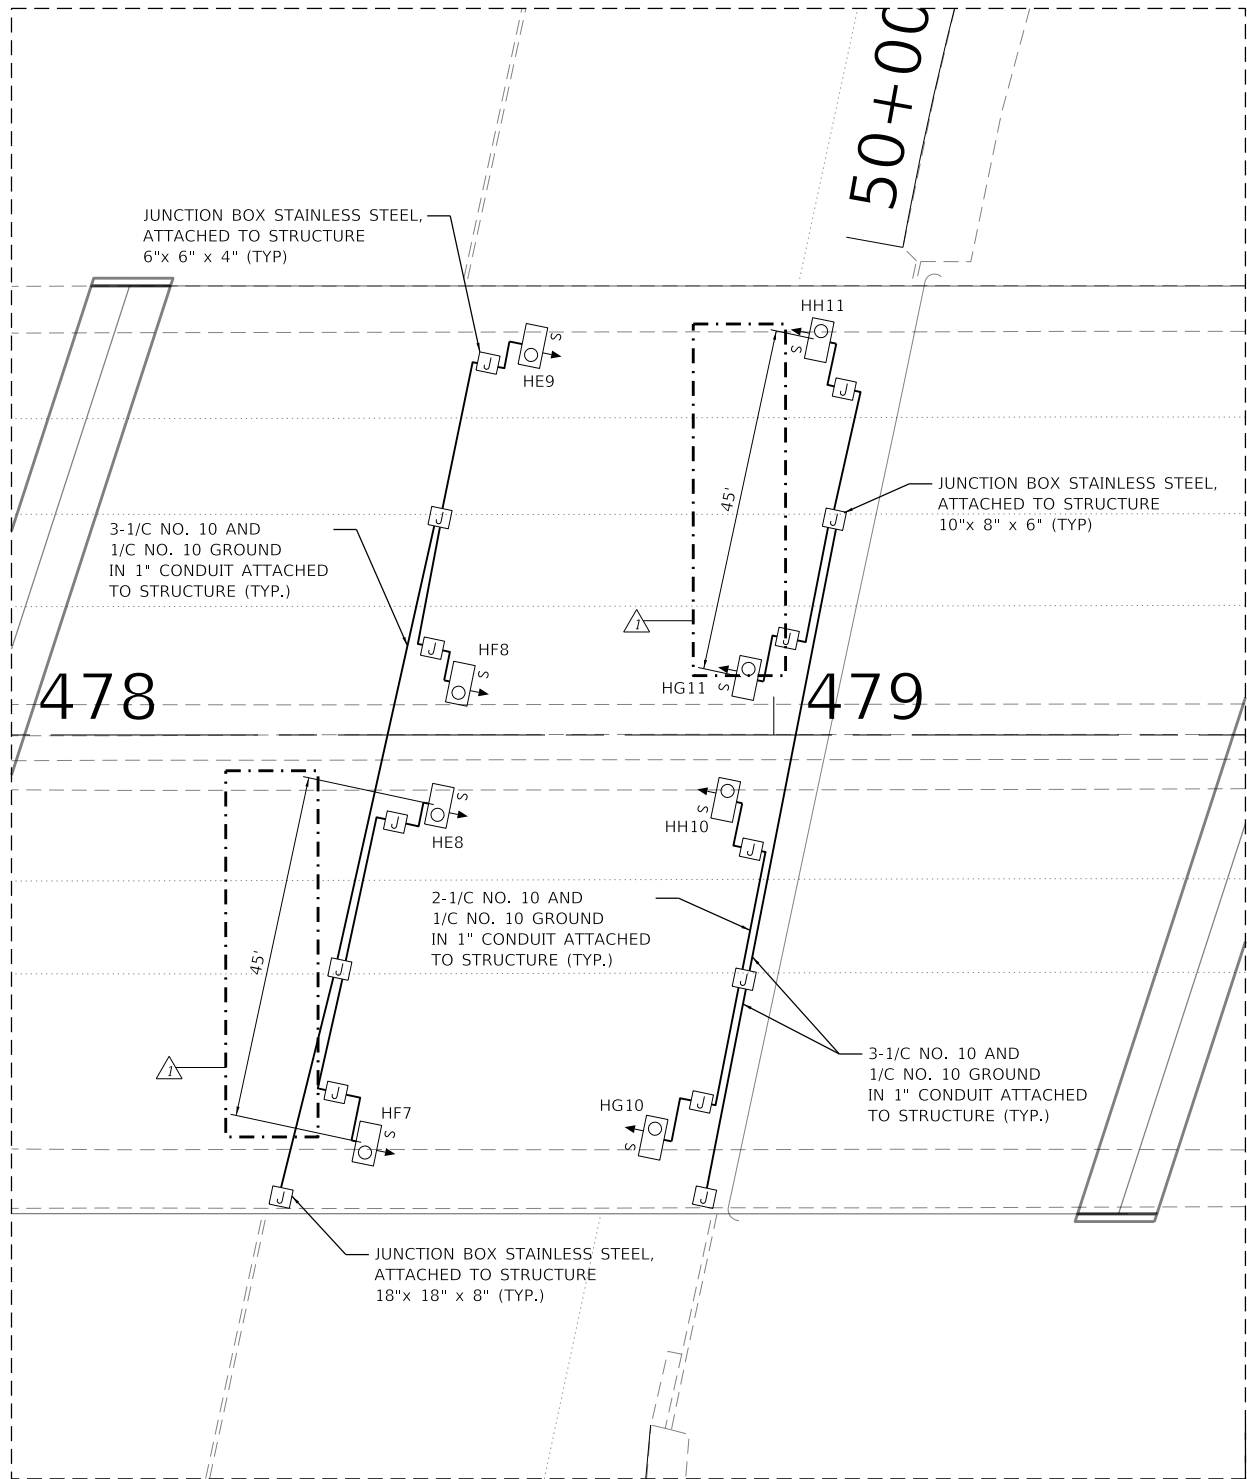

I-94 (BISHOP FORD EXPY) OVER DOLTON AVE.
UNDERPASS LIGHTING

MODEL Default
FILE Name: I:\mepw\11cs01\CS_gdf_work_dtl\3020\1468_135\0162\K53-ct-light028-4.dgn



745 McCintock Drive
Suite 210
Burr Ridge, IL 60527
Ph. 773-451-4788
www.abnacorp.com

USER NAME	= hbmepw11cs01\$
PLOT SCALE	= 100,0000 ' / in.
PLOT DATE	= 4/10/2025

DESIGNED -	FPE
DRAWN -	LNK
CHECKED -	JMO
DATE -	12/9/2024



REVISED -	4/8/2025 LNK
REVISED -	
REVISED -	
REVISED -	

STATE OF ILLINOIS
DEPARTMENT OF TRANSPORTATION

LIGHTING PLAN PROPOSED UNDERPASS
I-94 (BISHOP FORD EXPY) OVER DOLTON AVE.

SCALE: SHEET 1 OF 1 SHEETS STA. TO STA.

F.A.I. RTE.	SECTION	COUNTY	TOTAL SHEETS	SHEET NO.
94	(42-B-11-1) BR, BJR 24	COOK	761	426
CONTRACT NO. 62W87				
ILLINOIS FED. AID PROJECT				

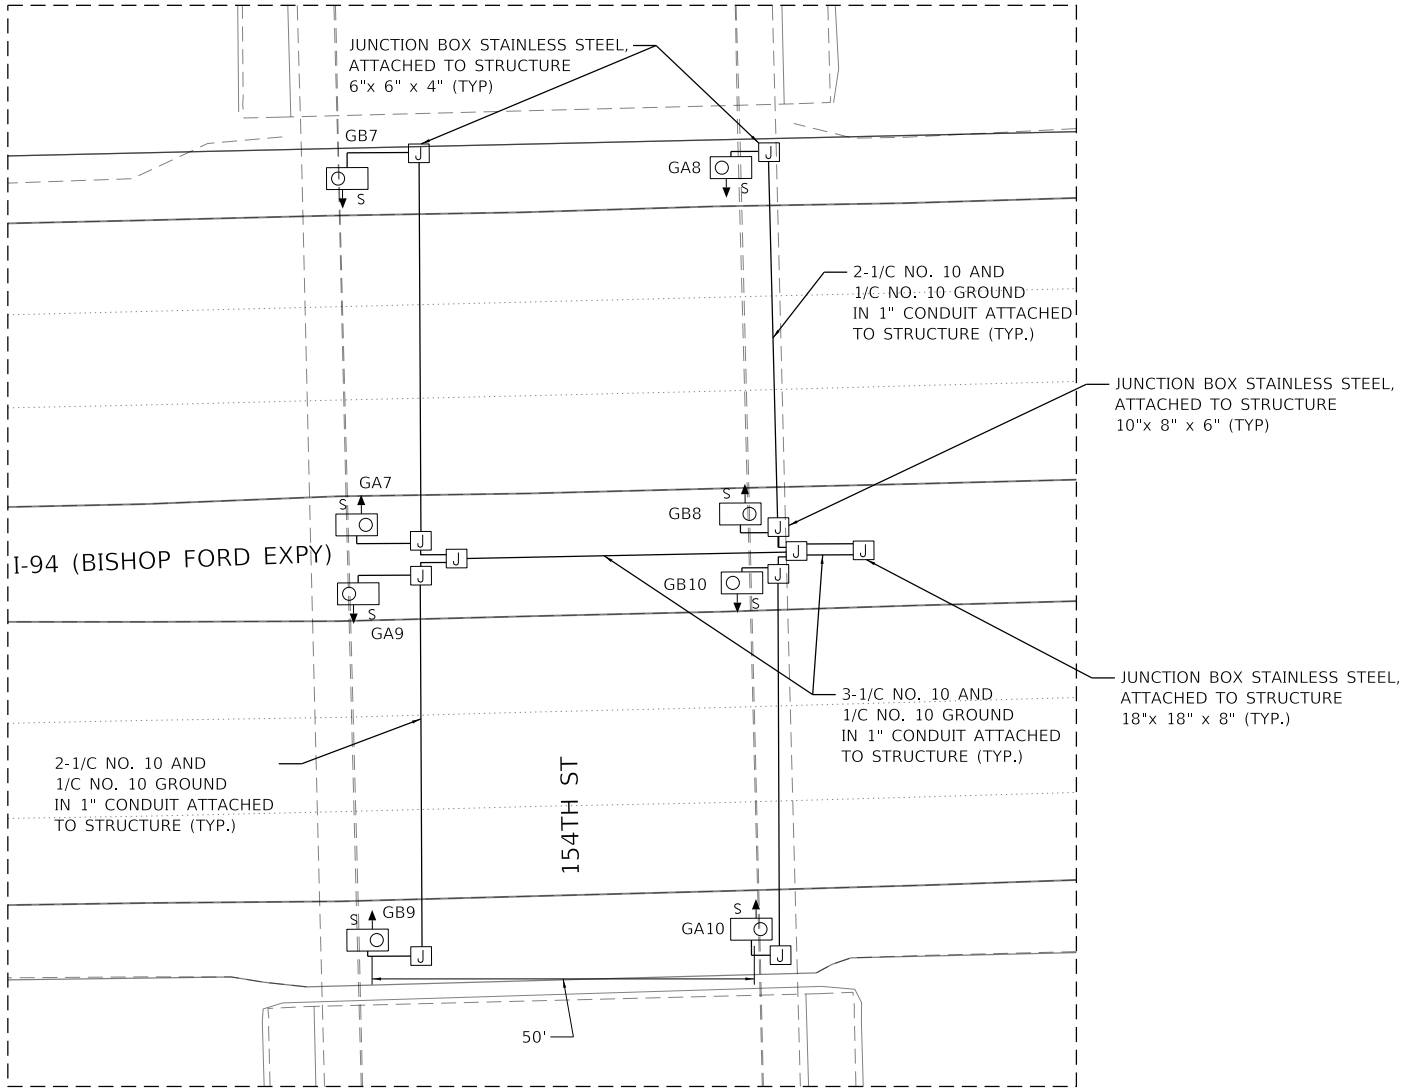 

I-94 (BISHOP FORD EXPY) AND 154TH ST UNDERPASS LIGHTING

NOTES:

- 1

THE EXISTING CABLE, CONDUIT, AND JUNCTION BOXES SHALL BE REPLACED WITH NEW CABLE, CONDUIT AND JUNCTION BOXES.
- 2

THE PROPOSED LED LUMINAIRES SHALL BE INSTALLED PER IDOT DISTRICT 1 STANDARDS (SUSPENDED MOUNT LED UNDERPASS LUMINAIRE INSTALLATION DETAILS, STANDARD BE-901).
- 3

THE PROPOSED UNDERPASS LIGHTING UNIT SHALL BE SPACED 6 FEET FROM THE EDGE OF THE BRIDGE ON BOTH SIDES AND 2 FEET FORM THE EDGE OF PAVEMENT
- 4

DIMENSIONS SHOWN ON THE PLANS SHALL BE FOLLOWED. DISTANCES SHALL NOT BE SCALED FROM THE PLANS.

MODEL: Default
FILE NAME: W:\mshw\11cs01\CS_pdfs\work_dtl\32024\1468_243\D162\K53-ctd-light0324.dgn



745 McCintock Drive
Suite 210
Burr Ridge, IL 60527
Ph. 773-451-4788
www.abnacorp.com


USER NAME	= hbmepw11cs01s	DESIGNED -	FPE	REVISED -	4/8/2025 LNK
DRAWN -	LNK	REVISED -			
PLOT SCALE	= 100,0000 ' / in.	CHECKED -	JMO	REVISED -	
PLOT DATE	= 4/10/2025	DATE -	12/9/2024	REVISED -	

STATE OF ILLINOIS
DEPARTMENT OF TRANSPORTATION


LIGHTING PLAN PROPOSED UNDERPASS
I-94 (BISHOP FORD EXPY) AND 154TH ST

SCALE: SHEET 1 OF 1 SHEETS STA. TO STA.

F.A.I. RTE.	SECTION	COUNTY	TOTAL SHEETS	SHEET NO.
94	(42-B-11-1) BR, BJR 24	COOK	761	427
CONTRACT NO. 62W87				
		ILLINOIS	FED. AID PROJECT	

 

I-94 (BISHOP FORD EXPY)

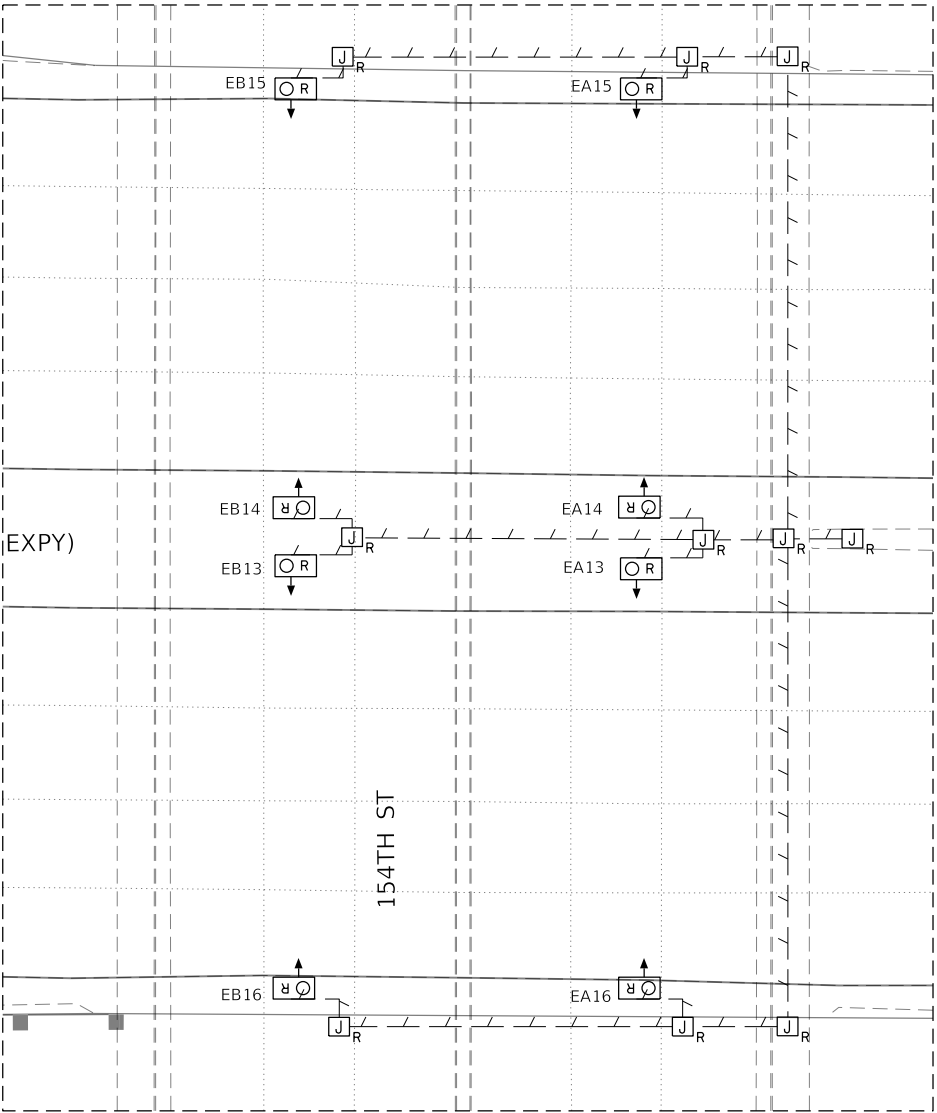

I-94 (BISHOP FORD EXPY) AND US 6 (159TH ST) UNDERPASS LIGHTING

NOTE:

- ① THE EXISTING CABLE, CONDUIT, AND JUNCTION BOXES SHALL BE REPLACED WITH NEW CABLE, CONDUIT AND JUNCTION BOXES.

MODEL Default
FILE Name: 62W87-11cs01UCS.pdf
work_dtl303211468-27AUD162K53-ctd-light0374.dgn



745 McCintock Drive
Suite 210
Burr Ridge, IL 60527
Ph. 773-451-4788
www.abnacorp.com



USER NAME = hbmeqpw11cs01s	DESIGNED - FPE	REVISED - 4/8/2025 LNK
	DRAWN - LNK	REVISED -
PLOT SCALE = 100,0000 ' / in.	CHECKED - JMO	REVISED -
PLOT DATE = 4/11/2025	DATE - 12/6/2024	REVISED -

STATE OF ILLINOIS
DEPARTMENT OF TRANSPORTATION

LIGHTING PLAN EXISTING UNDERPASS
I-94 (BISHOP FORD EXPY) AND US 6 (159TH ST)

SCALE: SHEET 1 OF 1 SHEETS STA. TO STA.

F.A.I. RTE.	SECTION	COUNTY	TOTAL SHEETS	SHEET NO.
94	(42-B-11-1) BR, BJR 24	COOK	761	427A
CONTRACT NO. 62W87				
		ILLINOIS	FED. AID PROJECT	

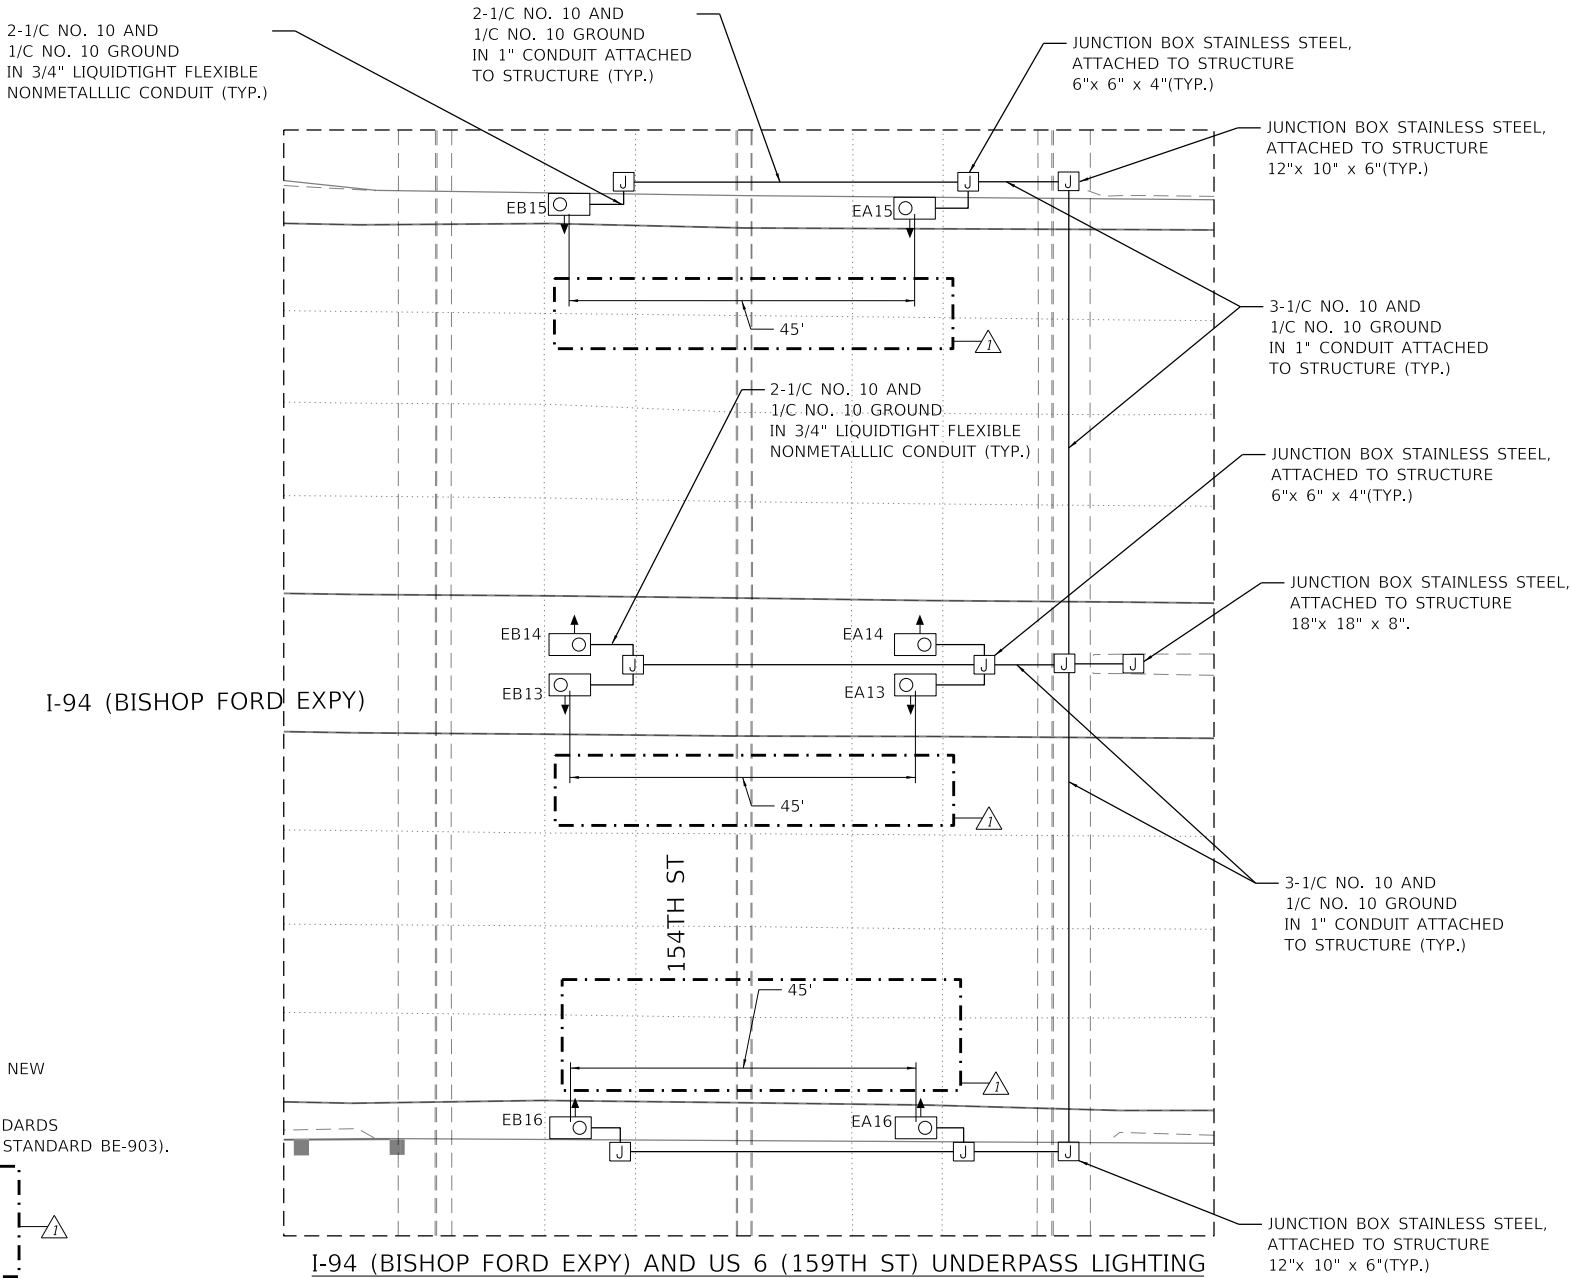 

NOTES:

- 1 THE EXISTING CABLE, CONDUIT, AND JUNCTION BOXES SHALL BE REPLACED WITH NEW CABLE, CONDUIT AND JUNCTION BOXES.
- 2 THE PROPOSED LED LUMINAIRES SHALL BE INSTALLED PER IDOT DISTRICT 1 STANDARDS (PIER / ABUTMENT MOUNTED LED UNDERPASS LUMINAIRE INSTALLATION DETAILS, STANDARD BE-903).
- 3 THE PROPOSED UNDERPASS LIGHTING UNIT SHALL BE SPACED 23 FEET FROM THE EDGE OF THE BRIDGE ON BOTH SIDES.
- 4 DIMENSIONS SHOWN ON THE PLANS SHALL BE FOLLOWED. DISTANCES SHALL NOT BE SCALED FROM THE PLANS.

MODEL Default
FILE Name: W:\mnpw\11cs01\CS_pdf_work_dtl\3025\1468_24\UD 62\K53-ctd-light\037-3.dgn



DESIGN FIRM REG. 184,002117

745 McClellan Drive
Suite 210
Burr Ridge, IL 60527
Ph. 773-451-4788
www.abnacorp.com

USER NAME = hbmeqpw11cs01\$	DESIGNED - FPE	REVISED - 4/8/2025 LNK
	DRAWN - LNK	REVISED -
PLOT SCALE = 100,0000 ' / in.	CHECKED - JMO	REVISED -
PLOT DATE = 4/10/2025	DATE - 12/6/2024	REVISED -

STATE OF ILLINOIS
DEPARTMENT OF TRANSPORTATION

LIGHTING PLAN PROPOSED UNDERPASS
I-94 (BISHOP FORD EXPY) AND US 6 (159TH ST)


SCALE: SHEET 1 OF 1 SHEETS STA. TO STA.

F.A.I. RTE.	SECTION	COUNTY	TOTAL SHEETS	SHEET NO.
94	(42-B-11-1) BR, BJR 24	COOK	761	428
CONTRACT NO. 62W87				
ILLINOIS FED. AID PROJECT				

By APL Date 11/16/09



 FOR INFORMATION ONLY

- | | |
|---|---|
|  | EXISTING UNIT DUCT |
|  | EXISTING UNIT DUCT |
|  | PROPOSED UNIT DUCT
3-1/2" NO. 4 AND 1-1/2" NO. 6 GND,
IEPR-TYP RHW, 1 1/4" DIA POLYETHYLENE |
|  | EXISTING LIGHTING UNIT |
|  | EXISTING LIGHTING CONTROLLER "X" |
|  | EXISTING JUNCTION BOX |
|  | EXISTING SIGN STRUCTURE |
|  | EXISTING UNDERPASS LIGHTING UNIT |
|  | SPLICE |



1. ALL WORK MUST MEET CURRENT NATIONAL ELECTRIC CODE AND DISTRICT ONE GENERAL GUIDELINES
2. A MAINTENANCE TRANSFER MUST TAKE PLACE BEFORE ANY WORK CAN BE DONE.
3. UNDERGROUND SPLICING OF CABLES IS NOT PERMITTED. SPLICING SHALL BE ACCOMPLISHED IN THE LIGHT POLES.

STATE OF ILLINOIS
DEPARTMENT OF TRANSPORTATION

ONE-LINE DIAGRAM & GENERAL NOTES
I-94 (BISHOP FORD EXPRESSWAY)
W OF MLK DR. TO S OF DOLTON AVE

P.A. SITE	SECTION	COUNTY	TOTAL SHEETS	SHEET NO.
CONTRACT NO.				
BLINDS, FIB. AND PROJECT				


60608

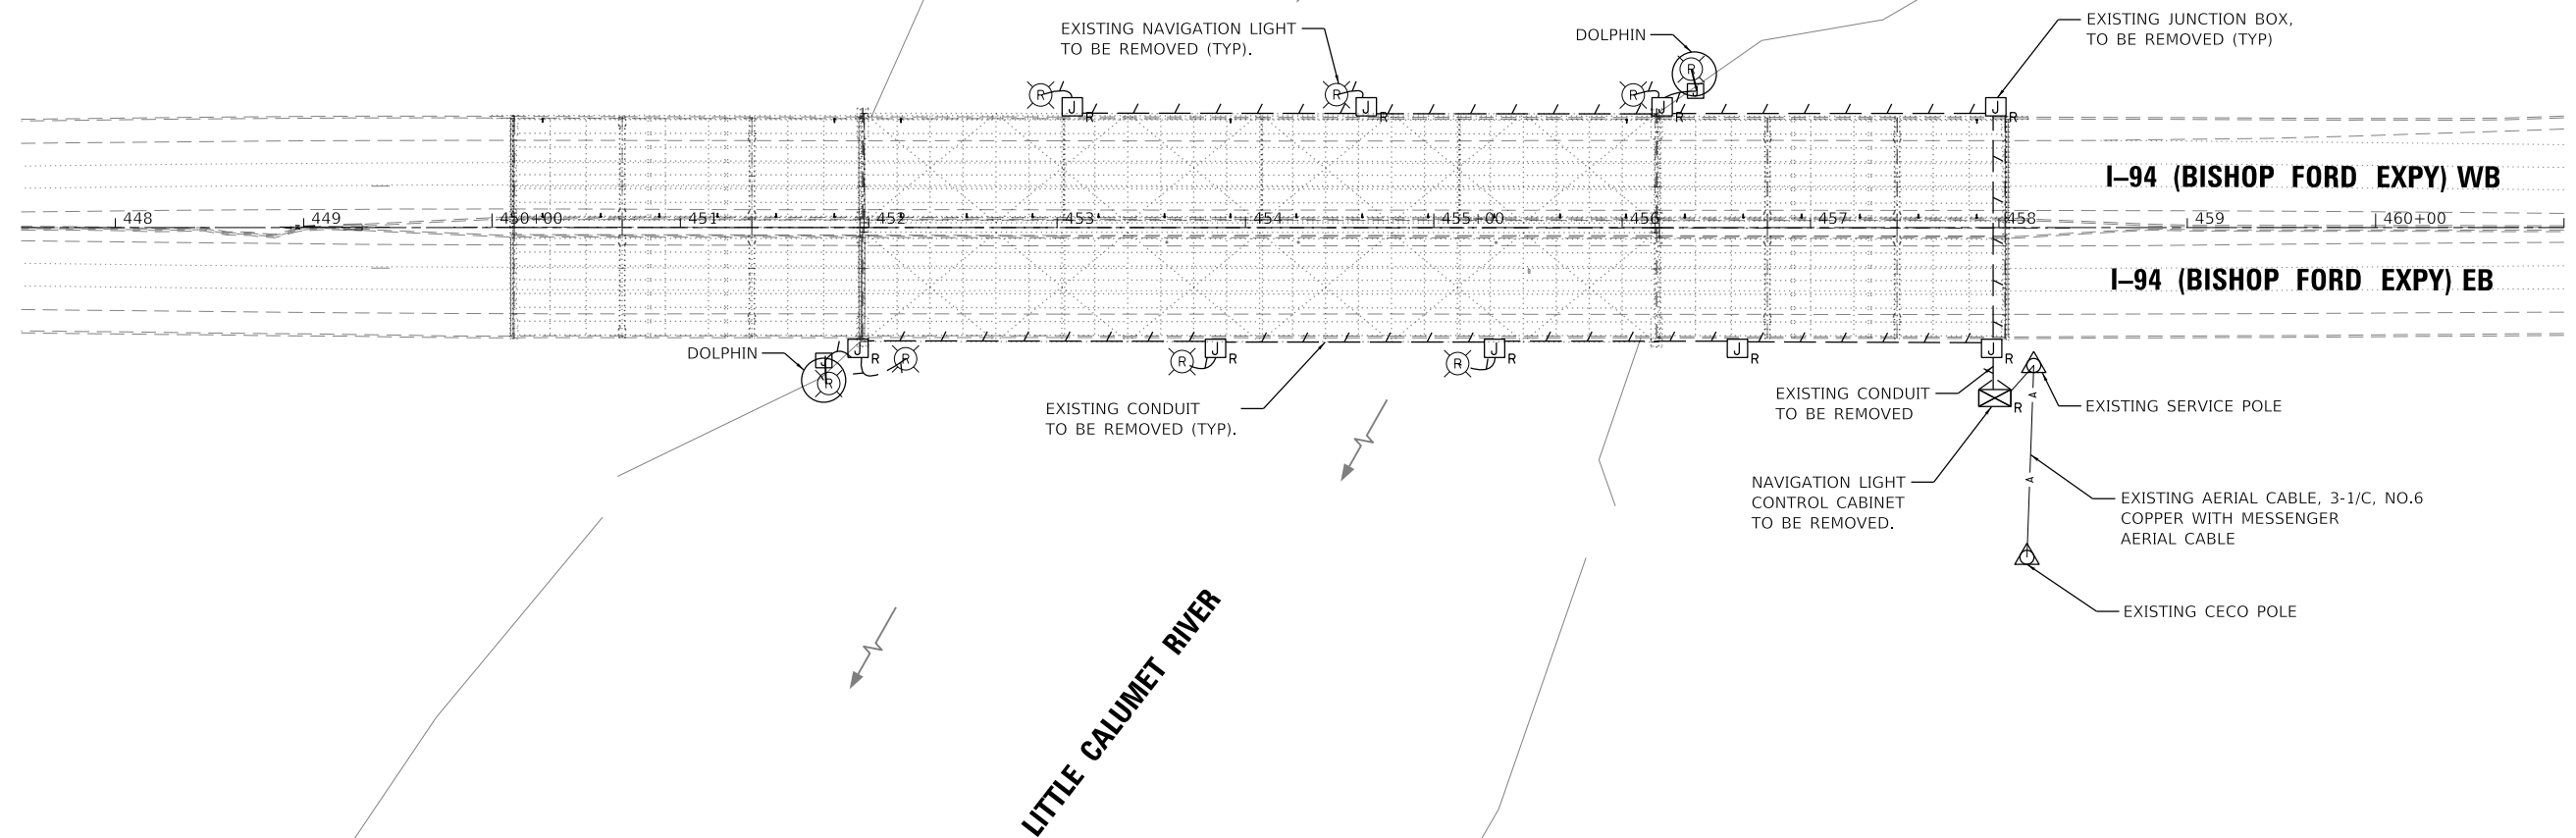
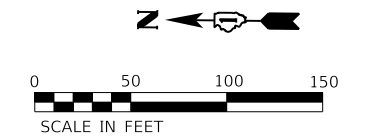


NOTES:

- ① EXISTING NAVIGATION LIGHTING UNIT TO BE REMOVED AND ALL ASSOCIATED CONDUIT, CABLE, JUNCTION BOXES.
- ② THE CONTRACTOR SHALL OBTAIN COAST GUARD APPROVAL FOR ANY WORK THAT MAY INTERFERE WITH NAVIGATION OPERATIONS OF THE NAVIGABLE WATERS
- ③ A WORK PLAN SHALL BE PREPARED BY THE CONTRACTOR, REVIEWED AND APPROVED BY THE ENGINEER AND BE SUBMITTED BY THE ENGINEER TO THE COAST GUARD AT THE ADDRESS LISTED BELOW FOR APPROVAL.

BRIDGE ADMINISTRATOR
US COAST GUARD
NINTH COAST GUARD DISTRICT
1240 E. NINTH ST.
CLEVELAND, OH 44119-2060

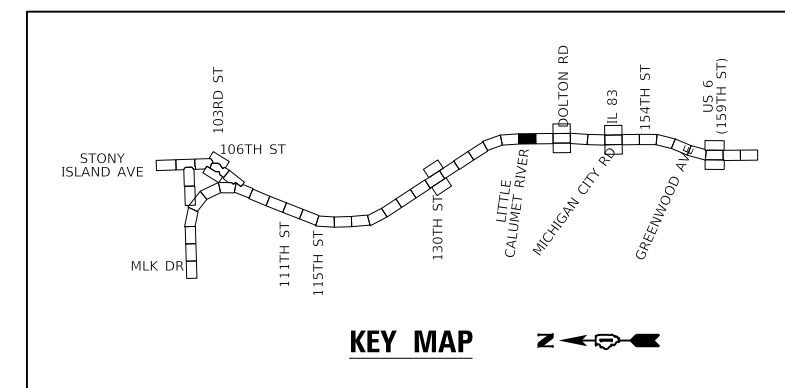


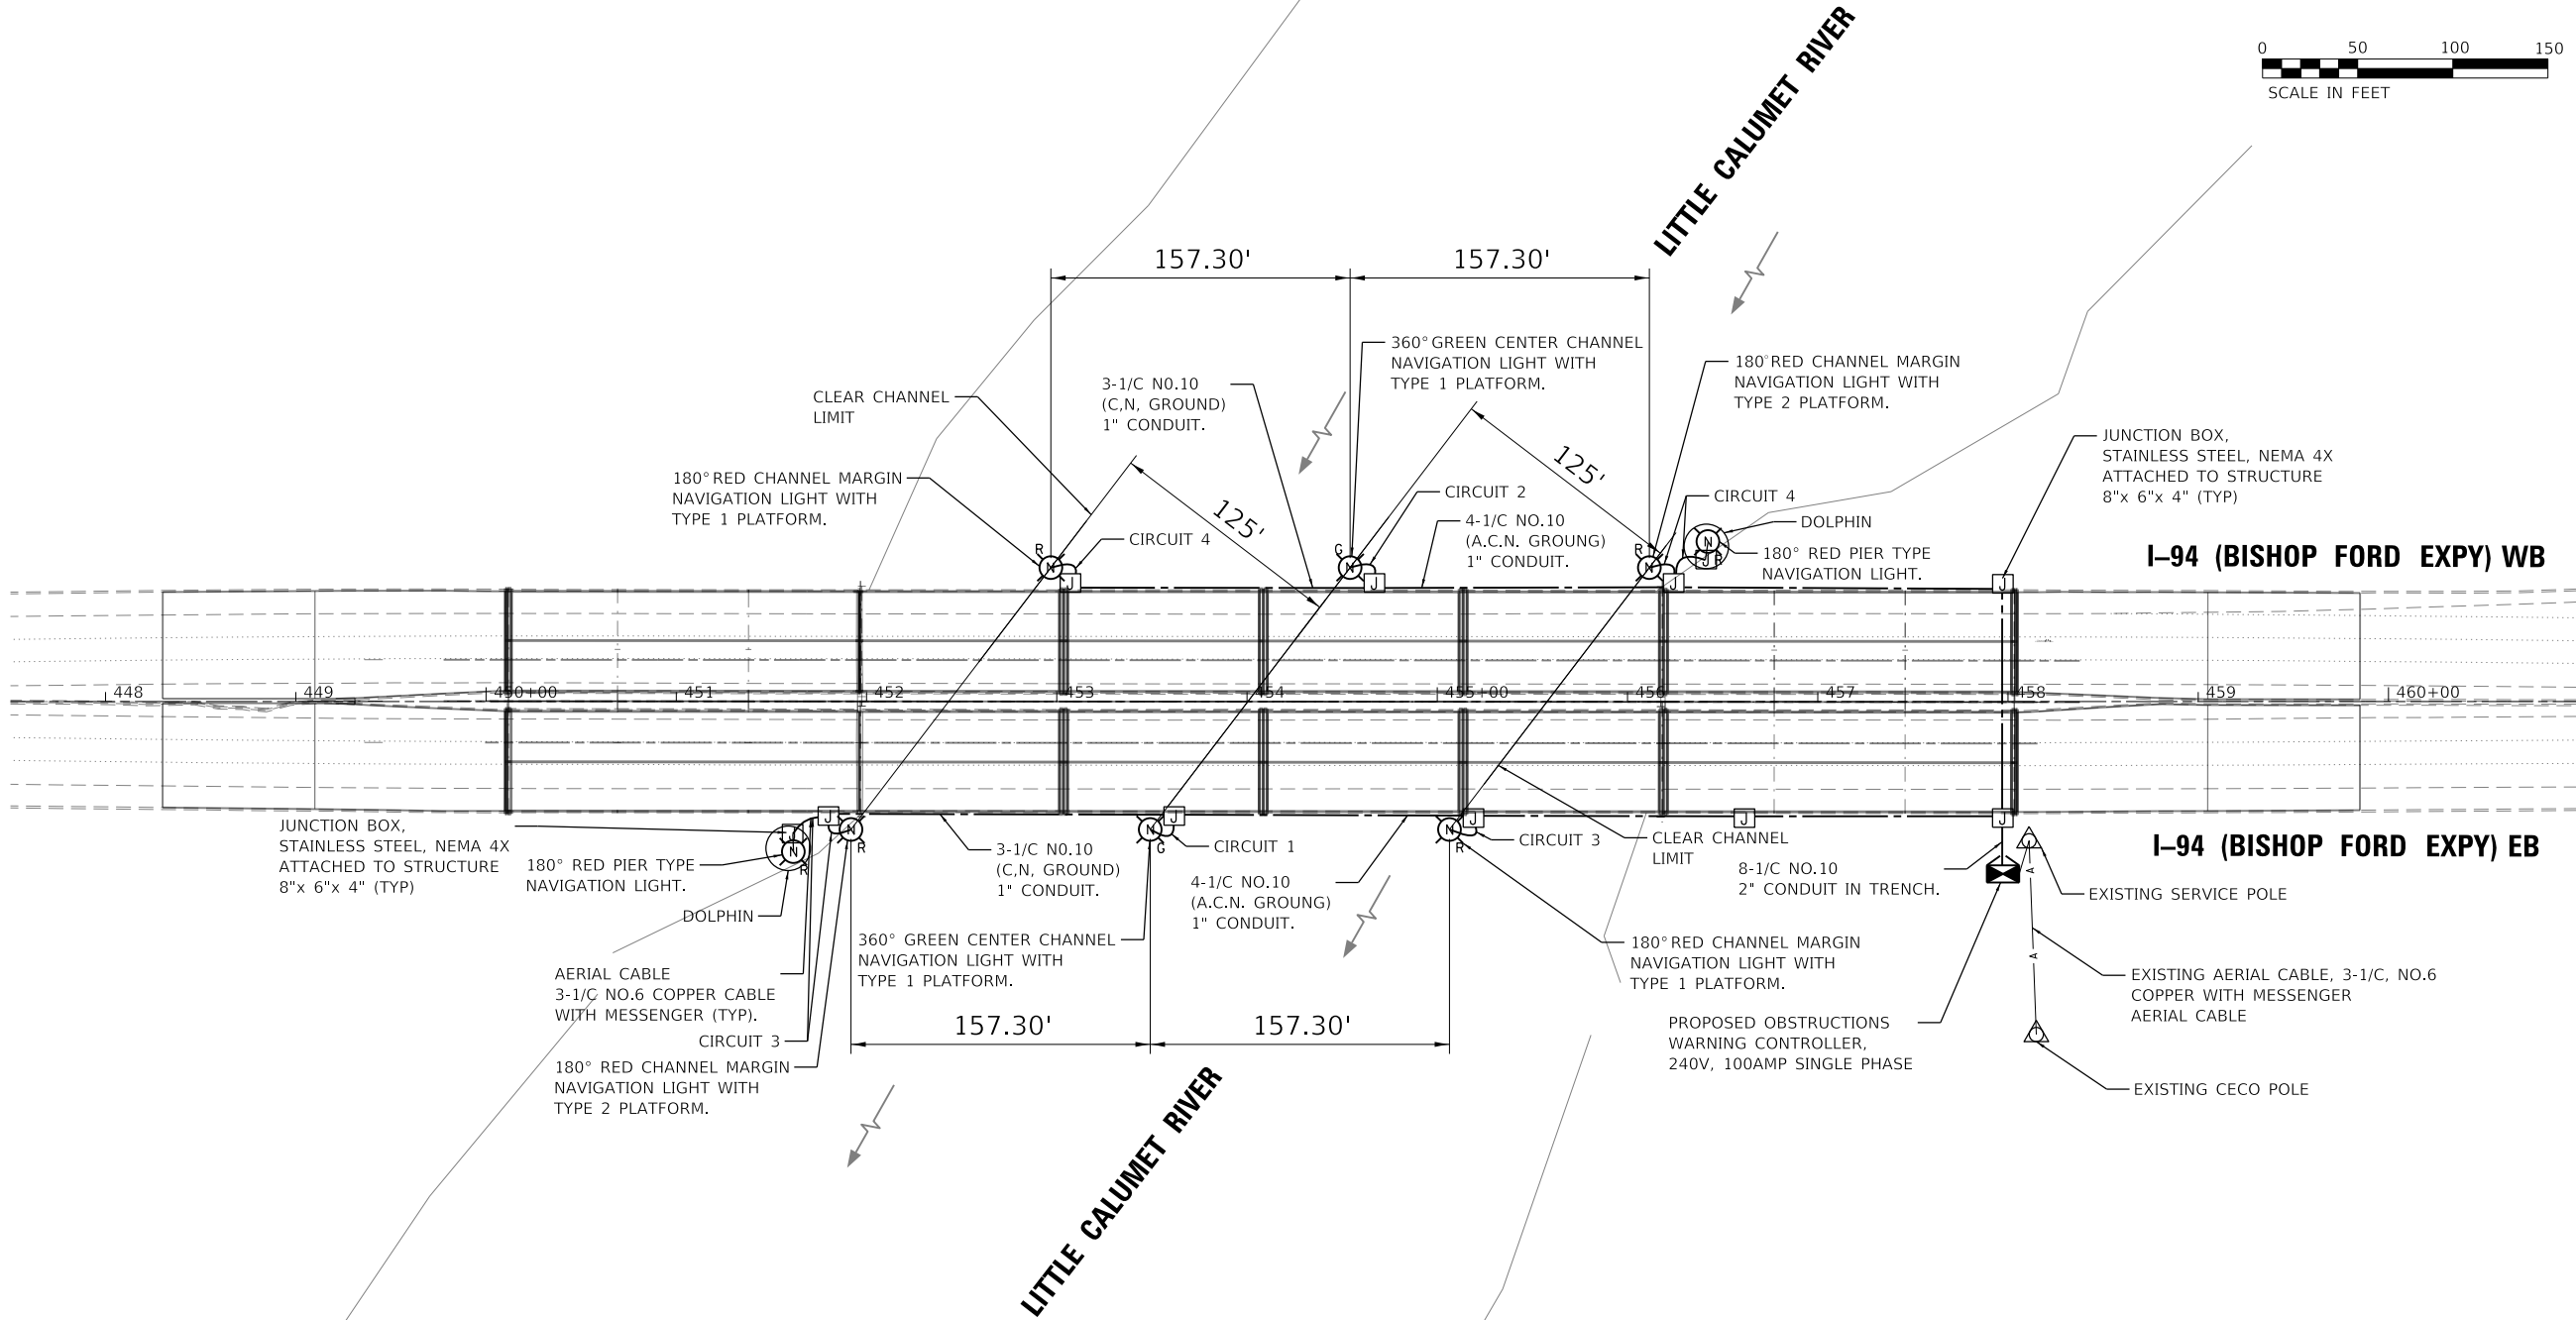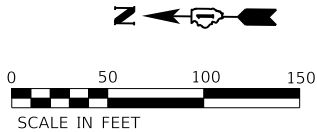

NOTES:

- 1 THE EXISTING NAVIGATION LIGHTING SHALL REMAIN OPERATIONAL UNTIL THE PROPOSED NAVIGATION LIGHTING ARE INSTALLED AND OPERATIONAL.
- 2 THE PROPOSED NAVIGATION LIGHTING UNIT LOCATIONS AND SPACING SHALL MATCH THE EXISTING. CONTRACTOR SHALL FIELD VERIFY EXISTING LOCATIONS.
- 3 FOR MAINTENANCE OF THE NAVIGATION LIGHTING SYSTEM SEE THE SPECIAL PROVISION "MAINTENANCE OF LIGHTING SYSTEMS".
- 4 RECONNECT PROPOSED OBSTRUCTIONS WARNING CONTROLLER TO EXISTING SERVICE POLE.
- 5 THE CONTRACTOR SHALL OBTAIN COAST GUARD APPROVAL FOR ANY WORK THAT MAY INTERFERE WITH NAVIGATION OPERATIONS OF THE NAVIGABLE WATERS
- 6 A WORK PLAN SHALL BE PREPARED BY THE CONTRACTOR, REVIEWED AND APPROVED BY THE ENGINEER AND BE SUBMITTED BY THE ENGINEER TO THE COAST GUARD AT THE ADDRESS LISTED BELOW FOR APPROVAL.

BRIDGE ADMINISTRATOR
US COAST GUARD
NINTH COAST GUARD DISTRICT
1240 E. NINTH ST.
CLEVELAND, OH 441199-2060

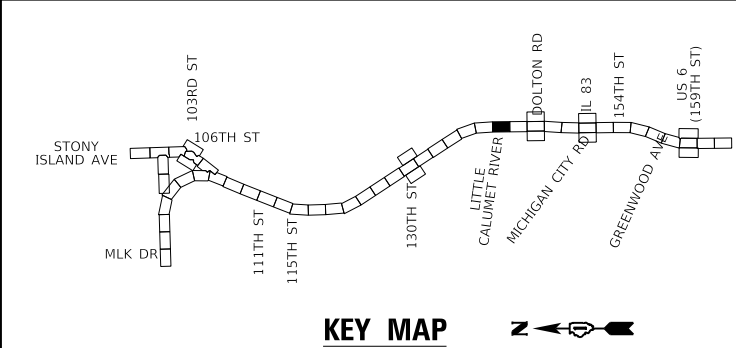

KEY MAP



MODEL Default
FILE Name: W:\mnpw\11cs01\ICS.pdf, work_dir\3020\1468_263\D\62K53-chr-navigat-c01.dgn

 745 McClellan Drive Suite 210 Burr Ridge, IL 60527 Ph. 773-451-4788 www.abnacorp.com	USER NAME = hbmepw11cs01s	DESIGNED - FPE	REVISED - 4/8/2025 LNK
		DRAWN - LNK	REVISED -
	PLOT SCALE = 100,0000 ' / in.	CHECKED - FPE	REVISED -
	PLOT DATE = 4/11/2025	DATE - 01/22/2025	REVISED -

STATE OF ILLINOIS
DEPARTMENT OF TRANSPORTATION

LIGHTING PLAN PROPOSED NAVIGATION LIGHTING			
I-94 (BISHOP FORD EXPY)			
SCALE:	SHEET 2	OF 8 SHEETS	STA. TO STA.

F.A.I. RTE.	SECTION	COUNTY	TOTAL SHEETS	SHEET NO.
94	(42-B-11-1) BR, BJR 24	COOK	761	428F
CONTRACT NO. 62W87				
ILLINOIS FED. AID PROJECT				

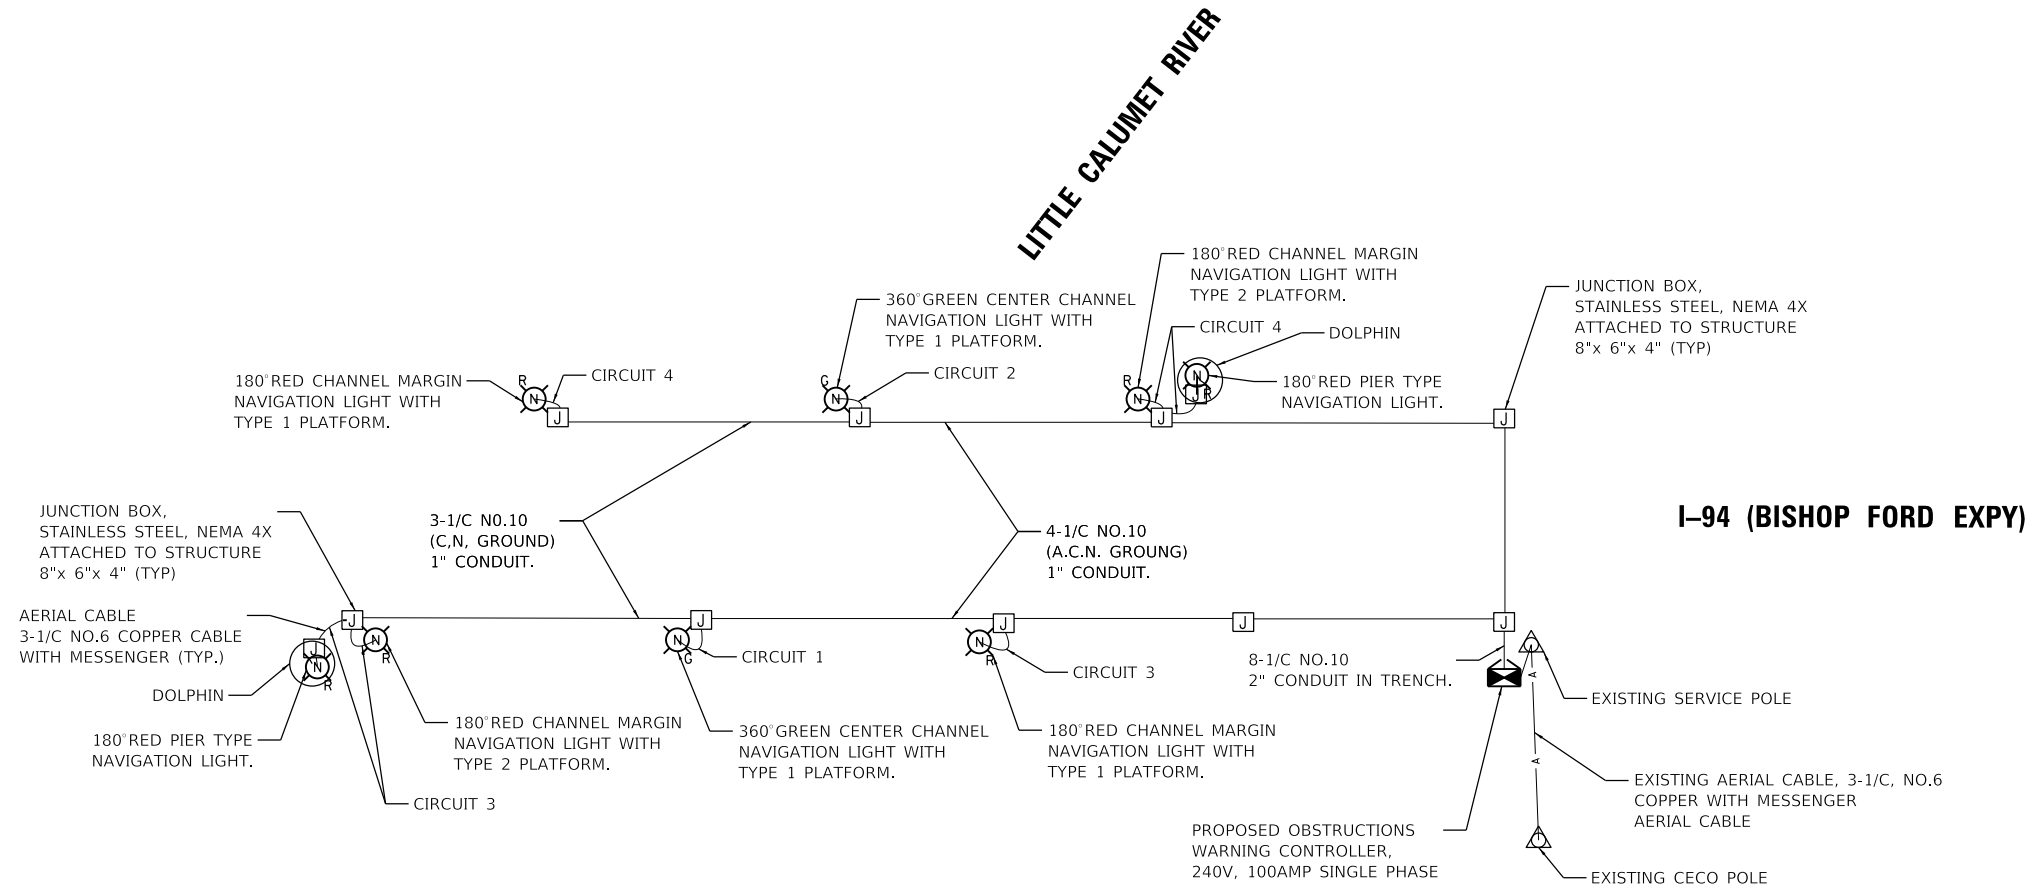 

MODEL Default
FILE Name: W:\mepw\11cs01\CS_gdf_work_dtl\320201468_264UD162\K32-chnavlight-02.dgn



745 McCintock Drive
Suite 210
Burr Ridge, IL 60527
Ph. 773-451-4788
www.abnaincorp.com

USER NAME = hbmeppw11cs01s	DESIGNED - FPE	REVISED - 4/8/2025 LNK
	DRAWN - LNK	REVISED -
PLOT SCALE = 100,0000 ' / in.	CHECKED - FPE	REVISED -
PLOT DATE = 4/11/2025	DATE - 01/22/2025	REVISED -


STATE OF ILLINOIS
DEPARTMENT OF TRANSPORTATION

LIGHTING PLAN PROPOSED NAVIGATION ONE LINE DIADRAM
I-94 (BISHOP FORD EXPY)

SCALE: SHEET 3 OF 8 SHEETS STA. TO STA.

F.A.I. RTE.	SECTION	COUNTY	TOTAL SHEETS	SHEET NO.
94	(42-B-11-1) BR, BJR 24	COOK	761	428G
CONTRACT NO. 62W87				
ILLINOIS FED. AID PROJECT				

MODEL Default
FILE Name: W:\mwpw11cs01\CS_gdf_work_dtl\320201468_265\D162\K53-shc-navigation-c03.dgn

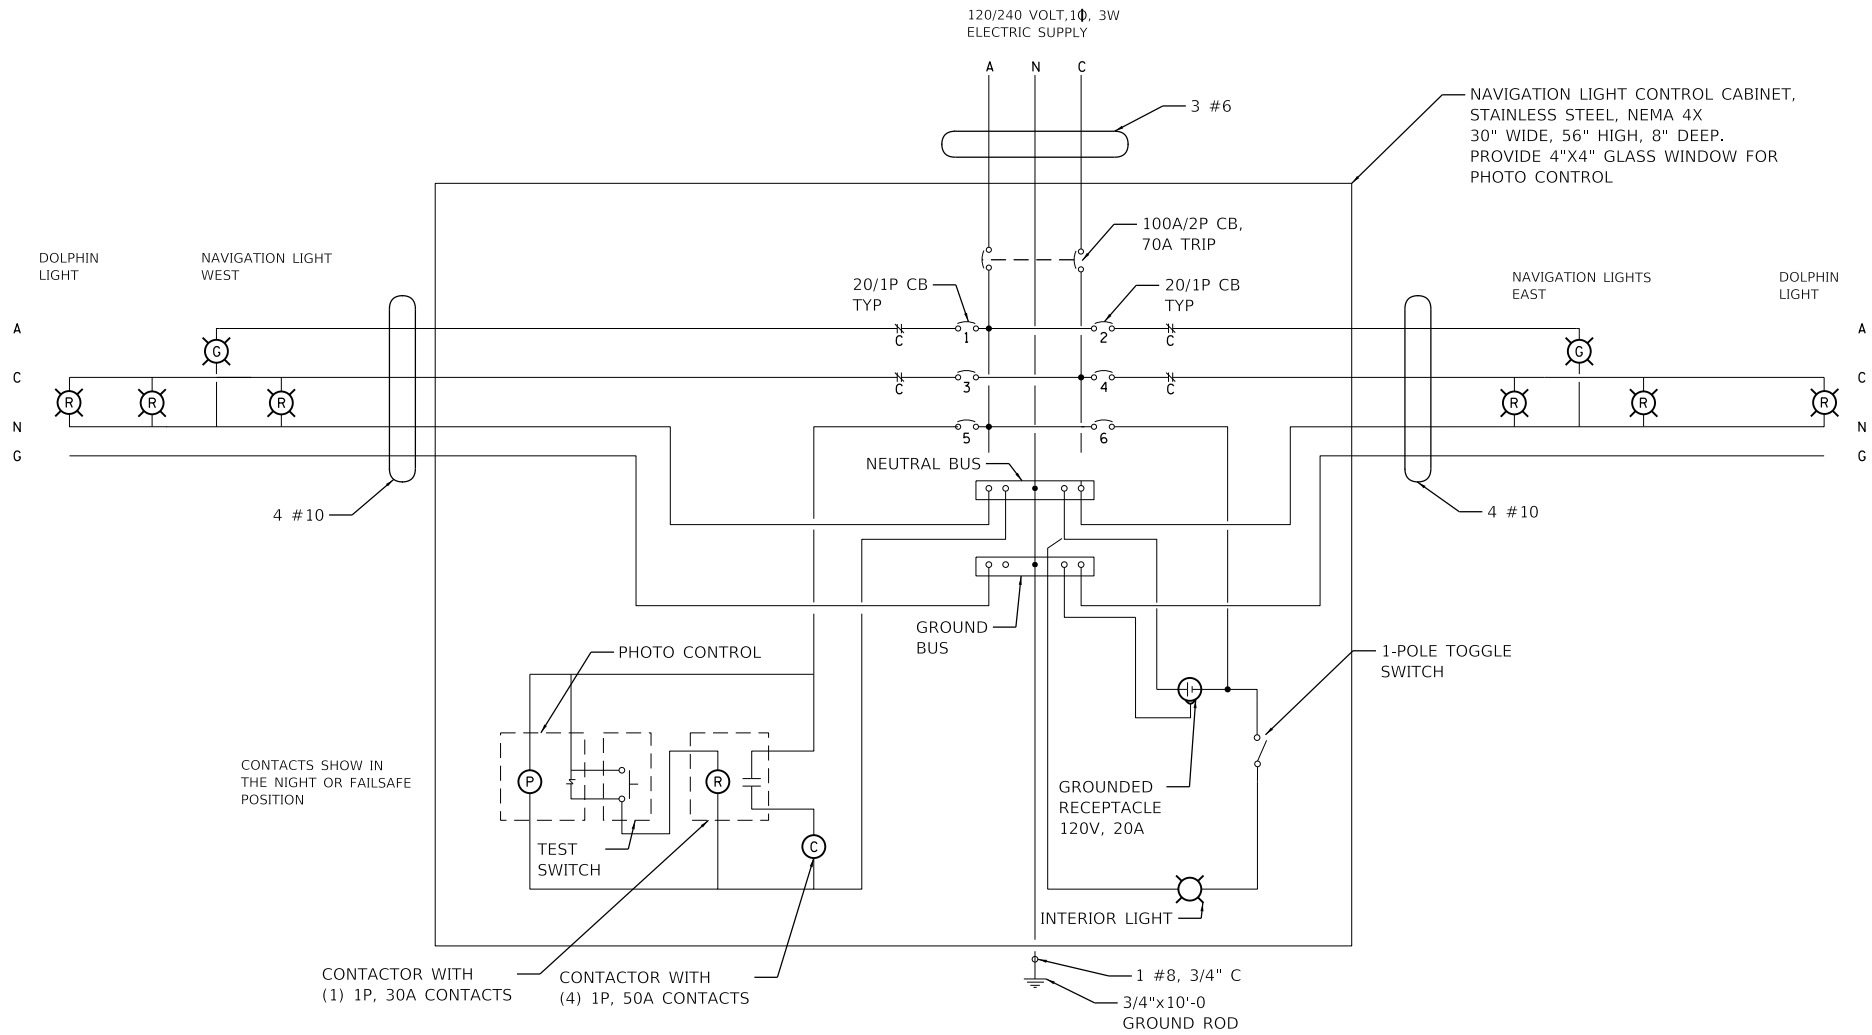

745 McCintock Drive
Suite 210
Burr Ridge, IL 60527
Ph. 773-451-4788
www.abnaincorp.com

USER NAME	= hbmepw11cs01s
PLOT SCALE	= 100,0000 ' / in.
PLOT DATE	= 4/11/2025

DESIGNED -	FPE
DRAWN -	LNK
CHECKED -	FPE
DATE -	01/22/2025


REVISED -	4/8/2025 LNK
REVISED -	
REVISED -	
REVISED -	

STATE OF ILLINOIS
DEPARTMENT OF TRANSPORTATION


LIGHTING PLAN PROPOSED NAVIGATION CONTROL CABINET
I-94 (BISHOP FORD EXPY)

SCALE: SHEET 4 OF 8 SHEETS STA. TO STA.


F.A.I. RTE.	SECTION	COUNTY	TOTAL SHEETS	SHEET NO.
94	(42-B-11-1) BR, BJR 24	COOK	761	428H
CONTRACT NO. 62W87				
ILLINOIS FED. AID PROJECT				

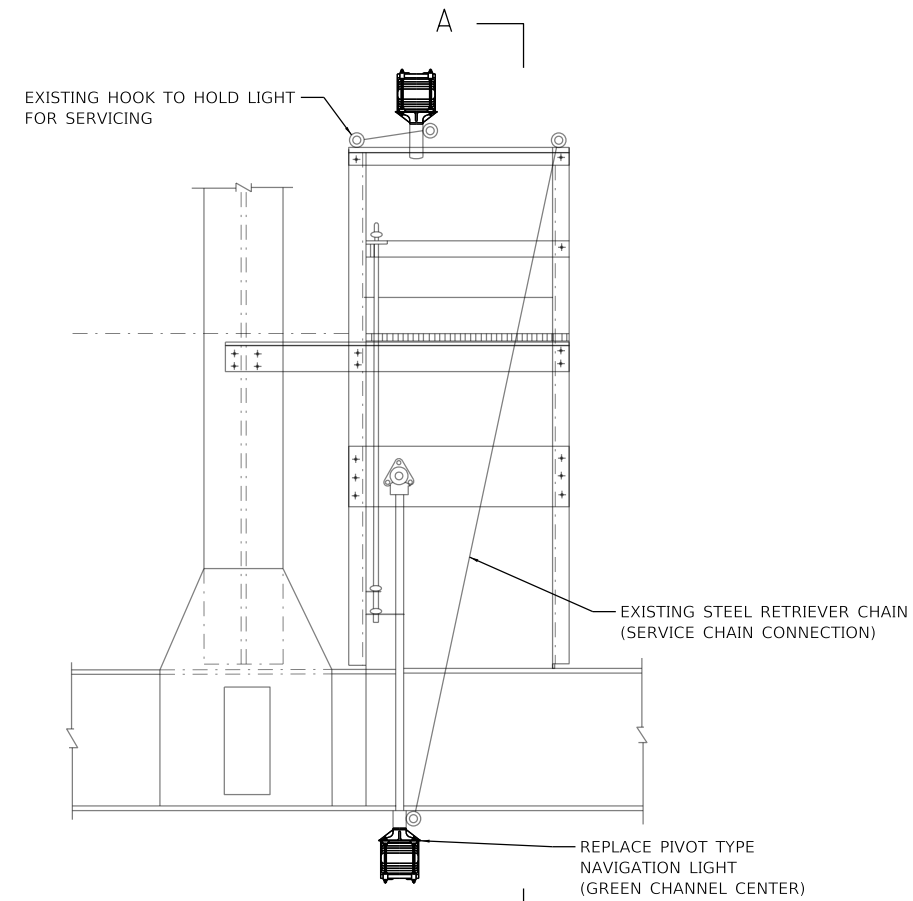


ELEVATION TYPE-1 PLATFORM

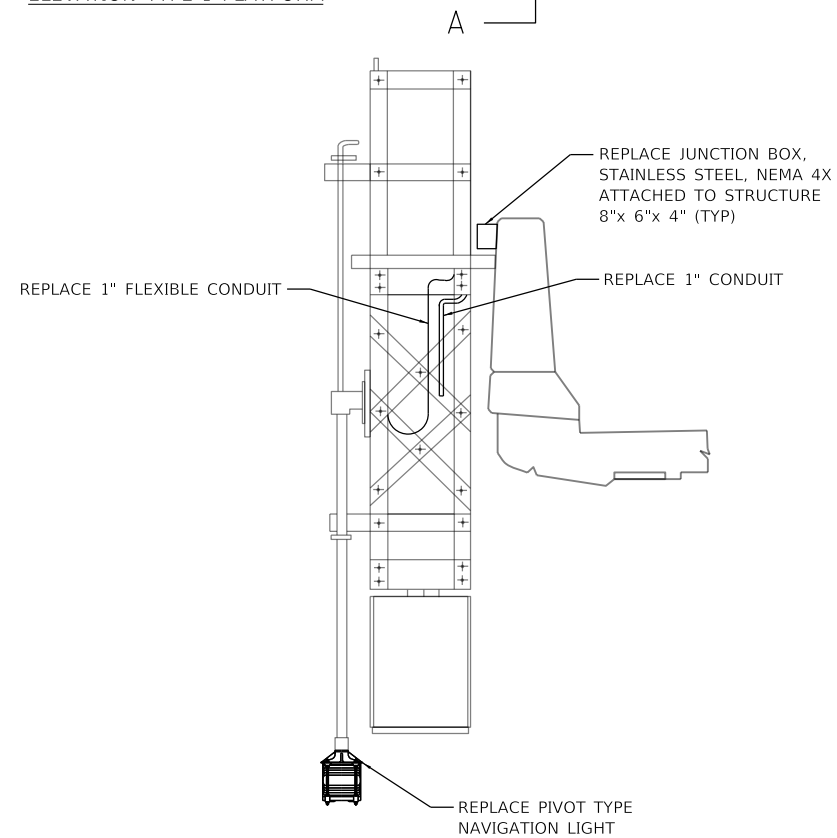

SECTION A-A

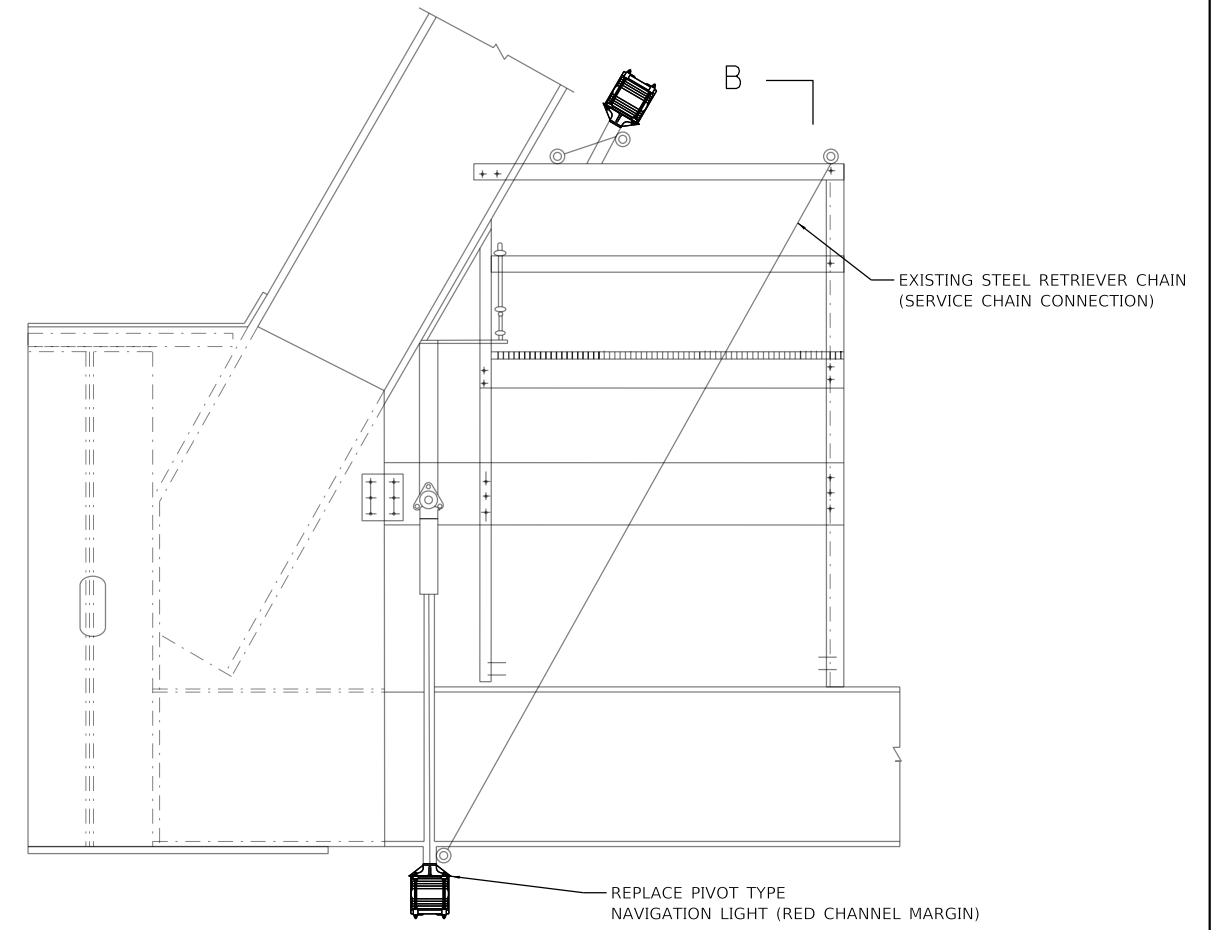

ELEVATION TYPE-2 PLATFORM

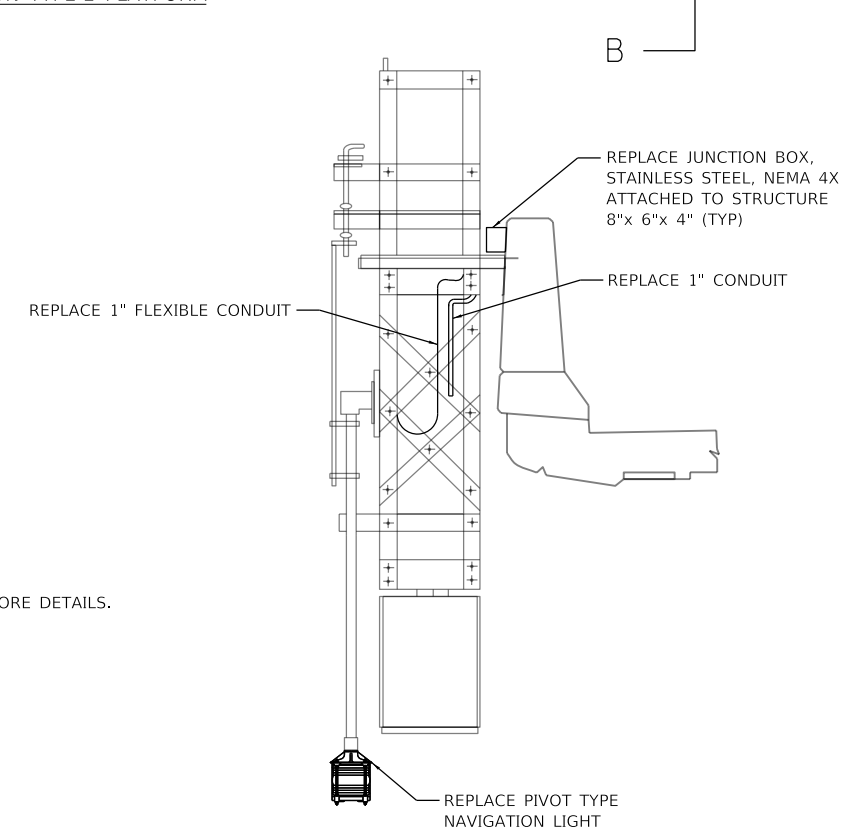


SECTION B-B


NOTE:

① SEE SHEET 428L FOR MORE DETAILS.

$\triangle 1$ ADDED SHEET

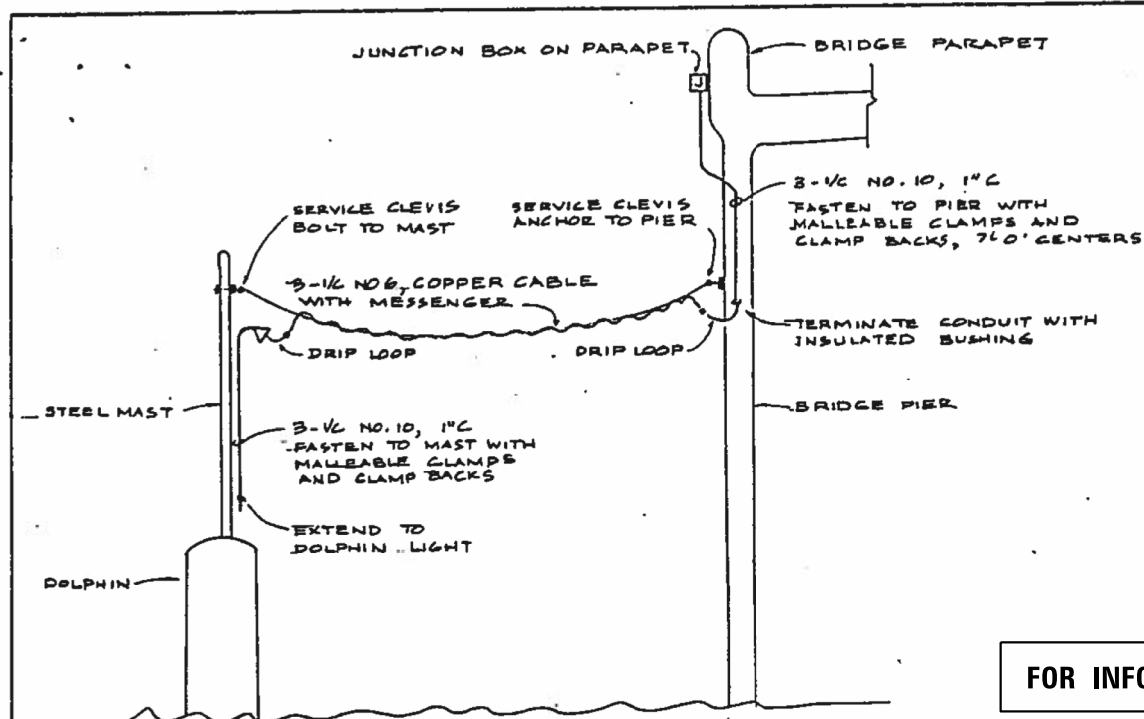

FOR INFORMATION ONLY



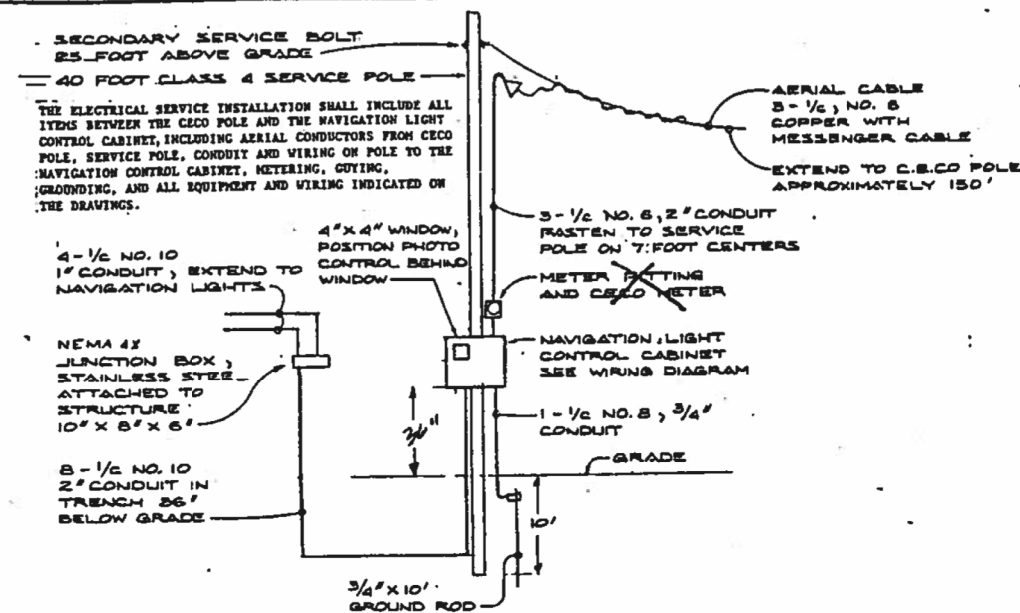


SERVICE POLE DETAIL

NO SCALE

ELECTRIC SERVICE FOR DOLPHIN LIGHTS DETAIL

NO SCALE

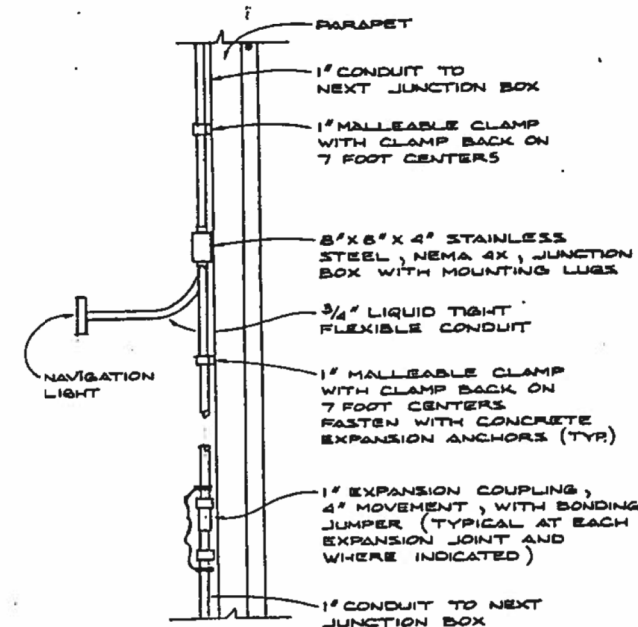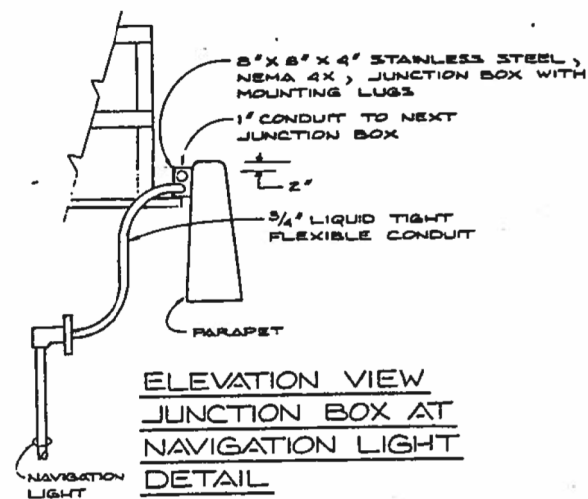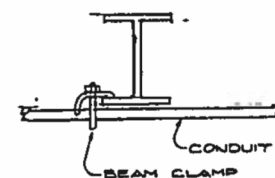

WALKER ELECTRIC

P.O. BOX 545 LAKE BLUFF, IL 60

☐ APPROVED ☐ DISAPPROVED☐ APP'D AS NOTED

BY James H. Moore DATE 10/30/1

JOB NAME: CALLMET EXT

JOB NUMBER

REFERENCE

STATE OF ILLINOIS
DEPARTMENT OF TRANSPORT.

F.A.I.-94

NAVIGATION LIGHTING DETAILS

SCALE *NONE* DRAWN BY
DATE *NOV. 1991* CHECKED BY

GENERAL NOTES:

1.

Reinforcement bars designated (E) shall be epoxy coated.
2.

Plan dimensions and details relative to the existing structure have been taken from existing plans and are subject to nominal construction variations. The Contractor shall field-verify existing dimensions and details affecting new construction and make necessary approved adjustments prior to construction or ordering of materials. Such variations shall not cause for additional compensation for a change in the scope of the work; however, the Contractor will be paid for the quantity actually furnished at the unit price bid for the work.
3.

The Contractor may request copies of existing construction plans that are currently on file with the Illinois Department of Transportation (IDOT). The request shall be in writing with the understanding that any reproduction cost will be the Contractors expense and at no additional cost to the Department.
4.

All exposed concrete edges shall have a ¾" x 45" chamfer except where shown otherwise.
5.

Protective coat shall be applied to the top of reconstructed transverse joint areas, top of new latex concrete overlay, and top and inside faces of parapets.
6.

Joint openings shall be adjusted according to Article 520.04 of the standard specifications when the deck is poured at an ambient temperature other than 50°F.
7.

Prior to pouring the new concrete deck, all heavy or loose rust, loose mill scale, and other loose detrimental foreign material shall be removed from the surfaces in contact with concrete (SSPC-SP3 standards). Tightly adhered paint may remain unless otherwise noted. Removal shall be accomplished by methods that will not damage the steel and the cost will be paid for according to Article 109.04 of the Standard Specifications. As directed by the Engineer, existing construction accessories welded to the top flange of beams and girders shall be removed. The weld areas shall be ground flush and inspected for cracks using magnetic particle testing (MT) or dye penetrant testing (PT) by qualified personnel approved by the Engineer. Any cracks that cannot be removed by grinding ¼ inch deep shall be identified and reported to the Bureau of Bridges and Structures for further disposition. The cost of removing welded accessories, grinding and inspecting weld areas and grinding cracks will be paid for according to Article 109.04 of the Standard Specifications.
8.

The Contractor shall take all necessary precautions for the protection of passing vehicles and pedestrians from falling objects and/or materials until completion of the work.
9.

It shall be the Contractors responsibility to locate and protect any utilities or facilities on, within or under the bridge deck including but not limited to under deck lighting, traffic signals or signs attached to the structure. Any damage to existing utilities caused by the Contractor in the performance of the work shall be repaired by the Contractor, to the satisfaction of the Engineer, at no cost to the Department.
10.

The Contractor shall exercise extreme caution during Concrete Removal to avoid damaging the steel beams and diaphragms to remain. Any damage to existing elements to remain cause by the Contractor in the performance of the work shall be repaired by the Contractor, to the satisfaction of the Engineer, at no cost to the Department.
11.

Cleaning and field painting of structural steel shall be done under a separate painting contract.
12.

For SMA overlay on Approach Slab, see Civil Sheets.
13.

The existing structural steel coating contains lead. The Contractor shall take appropriate precautions to deal with the presence of lead on this project.
14.

Adjacent I-94 WB bridge is not shown throughout the plans for clarity.
15.

The Contractor is responsible to protect the existing conduit and junction box embedded in the parapet during removal and construction. Any damage to the existing conduit and junction box shall be repaired by the Contractor at no additional cost to the Department.
16.

Concrete Sealer shall be applied to the designated areas of the abutments and piers.
17.

Prior to the application of the Concrete Sealer, the Contractor shall clean all existing debris from the abutment seats. The method of debris removal shall not damage the existing concrete and shall be approved by the Engineer. See special provision for Debris Removal.
18.

The Engineer shall show actual locations and size of deck repairs on As-built Plans.

INDEX OF SHEETS

S04-01	General Plan and Elevation
S04-02	General Notes, Index of Sheets & TBOM
S04-03	Stage Construction (Sheet 1 of 2)
S04-04	Stage Construction (Sheet 2 of 2)
S04-05	Temporary Concrete Barrier
S04-06	Deck Repair Plan (Sheet 1 of 2)
S04-07	Deck Repair Plan (Sheet 2 of 2)
S04-08	Drainage Scupper Adjustment Details
S04-09	N. Abut. Joint Removal & Replacement (Sht. 1 of 3)
S04-10	N. Abut. Joint Removal & Replacement (Sht. 2 of 3)
S04-11	N. Abut. Joint Removal & Replacement (Sht. 3 of 3)
S04-12	Pier 2 Joint Removal & Replacement (Sht. 1 of 2)
S04-13	Pier 2 Joint Removal & Replacement (Sht. 2 of 2)
S04-14	S. Abut. Joint Removal & Replacement (Sht. 1 of 3)
S04-15	S. Abut. Joint Removal & Replacement (Sht. 2 of 3)
S04-16	S. Abut. Joint Removal & Replacement (Sht. 3 of 3)
S04-17	Preformed Joint Strip Seal
S04-18	North Abutment Repairs
S04-19	South Abutment Repairs
S04-20	Pier 1 Repairs
S04-21	Pier 2 Repairs
S04-22	Pier 3 Repairs
S04-23	Pier 4 Repairs
S04-24	Pier 5 Repairs
S04-25	Slope Wall Repairs
S04-26	Bar Splicer Assembly & Mechanical Splicer Detail

TOTAL BILL OF MATERIAL

ITEM	UNIT	SUPER	SUB	TOTAL
Porous Granular Embankment	Cu Yd	-	1	1
Concrete Removal	Cu Yd	32.6	-	32.6
Protective Shield	Sq Yd	1,921	-	1,921
Concrete Superstructure	Cu Yd	36.9	-	36.9
Protective Coat	Sq Yd	3,120	-	3,120
Reinforcement Bars, Epoxy Coated	Pound	5,050	-	5,050
Bar Splicers	Each	48	-	48
Preformed Joint Seal 2 1/2"	Foot	414	-	414
Preformed Joint Strip Seal	Foot	210	-	210
Concrete Sealer	Sq Ft	-	4,241	4,241
Epoxy Crack Injection	Foot	-	36	36
Bolt Replacement	Each	-	2	2
Bridge Deck Grooving (Longitudinal)	Sq Yd	2,217	-	2,217
Slope Wall Crack Sealing	Foot	-	50	50
Deck Drain Extensions	Each	16	-	16
Drainage Scuppers To Be Adjusted	Each	2	-	2
Bridge Deck Latex Concrete Overlay, 3 Inches	Sq Yd	2,617	-	2,617
Bridge Deck Scarification 3/4"	Sq Yd	2,617	-	2,617
Structural Repair Of Concrete (Depth Equal To Or Less Than 5 Inches)	Sq Ft	-	268	268
Structural Repair Of Concrete (Depth Greater Than 5 Inches)	Sq Ft	-	3	3
Deck Slab Repair (Full Depth, Type I)	Sq Yd	0.1	-	0.1
Diamond Grinding (Bridge Section)	Sq Yd	2,511	-	2,511
Temporary Shoring And Cribbing	Each	-	2	2



PROPOSED SCOPE OF WORK

1.

Provide Protective shield within limits indicated on the plans.
2.

Perform Deck Slab Repairs and adjust and extend existing scuppers and floor drains as required.
3.

Perform ¾" Bridge Deck Scarification.
4.

Reconstruct Expansion Joints at the North and South abutments and Pier 2 and install new preformed joint strip seals.
5.

Apply 3" Bridge Deck Latex Concrete Overlay on Bridge Deck.
6.

Perform ¼" Diamond Grinding to top of bridge deck and abutment hatch block.
7.

Perform Bridge Deck Grooving (Longitudinal) on traffic lanes.
8.

Apply protective coat to the top of reconstructed transverse joint areas, top of new latex concrete overlay and top and inside faces of parapets.
9.

Perform structural repair of concrete to all spalled and delaminated areas, and perform low pressure epoxy injection to all open cracks (⅛"-wide and wider), for the abutments and piers as noted on the plans.
10.

Perform Slope Wall repairs.

STATE OF ILLINOIS
DEPARTMENT OF TRANSPORTATION

GENERAL NOTES, INDEX OF SHEETS & TBOM
STRUCTURE NO. 016-0160 (EB)

SHEET S04-02 OF S04-26 SHEETS

F.A.I. RTE.	SECTION	COUNTY	TOTAL SHEETS	SHEET NO.
94	(42-B-11-1) BR, BJR 24	COOK	761	560
		CONTRACT NO. 62W87		
ILLINOIS		FED.AID PROJECT		



USER NAME	=	hbmepw11cs01\$	DESIGNED	-	DEO, AWD	REVISED	-	04/08/2025 LAB
			DRAWN	-	DEO, AWD	REVISED	-	
PLOT SCALE	=	0:2,0000 " = 1 in.	CHECKED	-	MI, LAB	REVISED	-	
PLOT DATE	=	4/7/2025	DATE	-	12/9/2024	REVISED	-	

MODEL: Default
FILE NAME: \\hbmepw11cs01\CS_pdf_work_dir\3007\1428_3\10160160-62W87-02-EB-GenNotes.dgn