



**STORM SEWER AND STRUCTURE REMOVAL**

FLARED END SECTION REMOVAL  
 903+00, 27.0 LT.  
 STORM SEWER REMOVAL  
 STA. 902+64 TO 902+33 - 33'

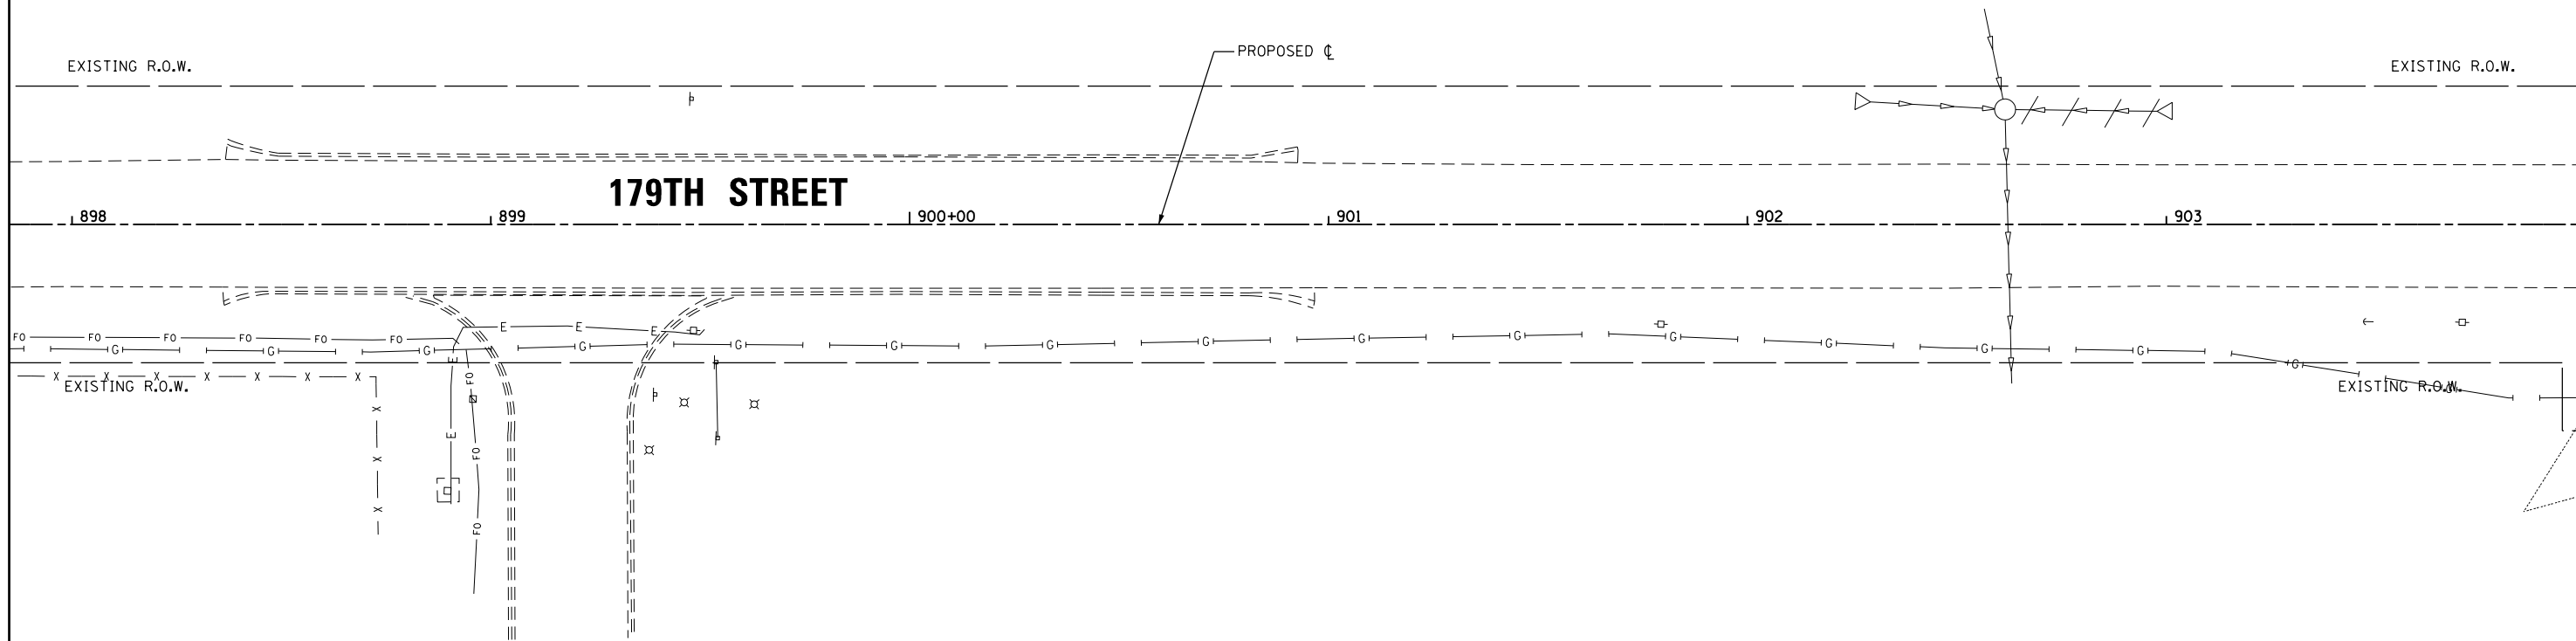

MATCH LINE STA. 904+00.00  
SEE SHEET DU-27

**NOTE:**  
 1. SEE DRAWING DN-01 FOR DRAINAGE LEGEND AND NOTES.  
 2. SEE DRAWINGS DS-01 THROUGH DS-11 FOR STRUCTURE AND PIPE INFORMATION

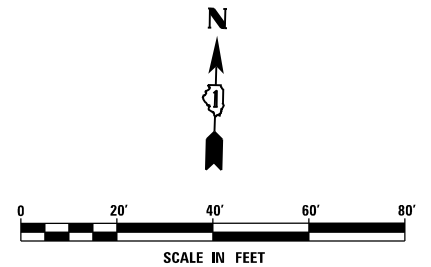

**URS**  
 100 S. WACKER DR.  
 SUITE 600  
 CHICAGO, IL 60606  
 TEL (312) 935-1000  
 FAX (312) 935-4998

FILE NAME = D160F05-KEA-SHT-DRAINEX26.dgn	USER NAME = Frank.Stallone	DESIGNED - MGS	REVISED -
SHT.PLAN	PLOT SCALE = 40.0001' / in.	DRAWN - REW	REVISED -
	PLOT DATE = 3/14/2013	CHECKED - JRS	REVISED -
		DATE - 03/13/13	REVISED -

**STATE OF ILLINOIS  
 DEPARTMENT OF TRANSPORTATION**

**EXISTING DRAINAGE PLAN - 179TH STREET**

SCALE: 1"=20' SHEET 26 OF 35 SHEETS STA. BEGIN TO STA. 904+00.00

F.A.P. RTE. 330	SECTION 103R-3	COUNTY COOK	TOTAL SHEETS 932	SHEET NO. 282
<b>DU-26</b>			CONTRACT NO. 60F05	
ILLINOIS FED. AID PROJECT				