



SEE DU-64 FOR 175TH ST. PROPOSED DRAINAGE

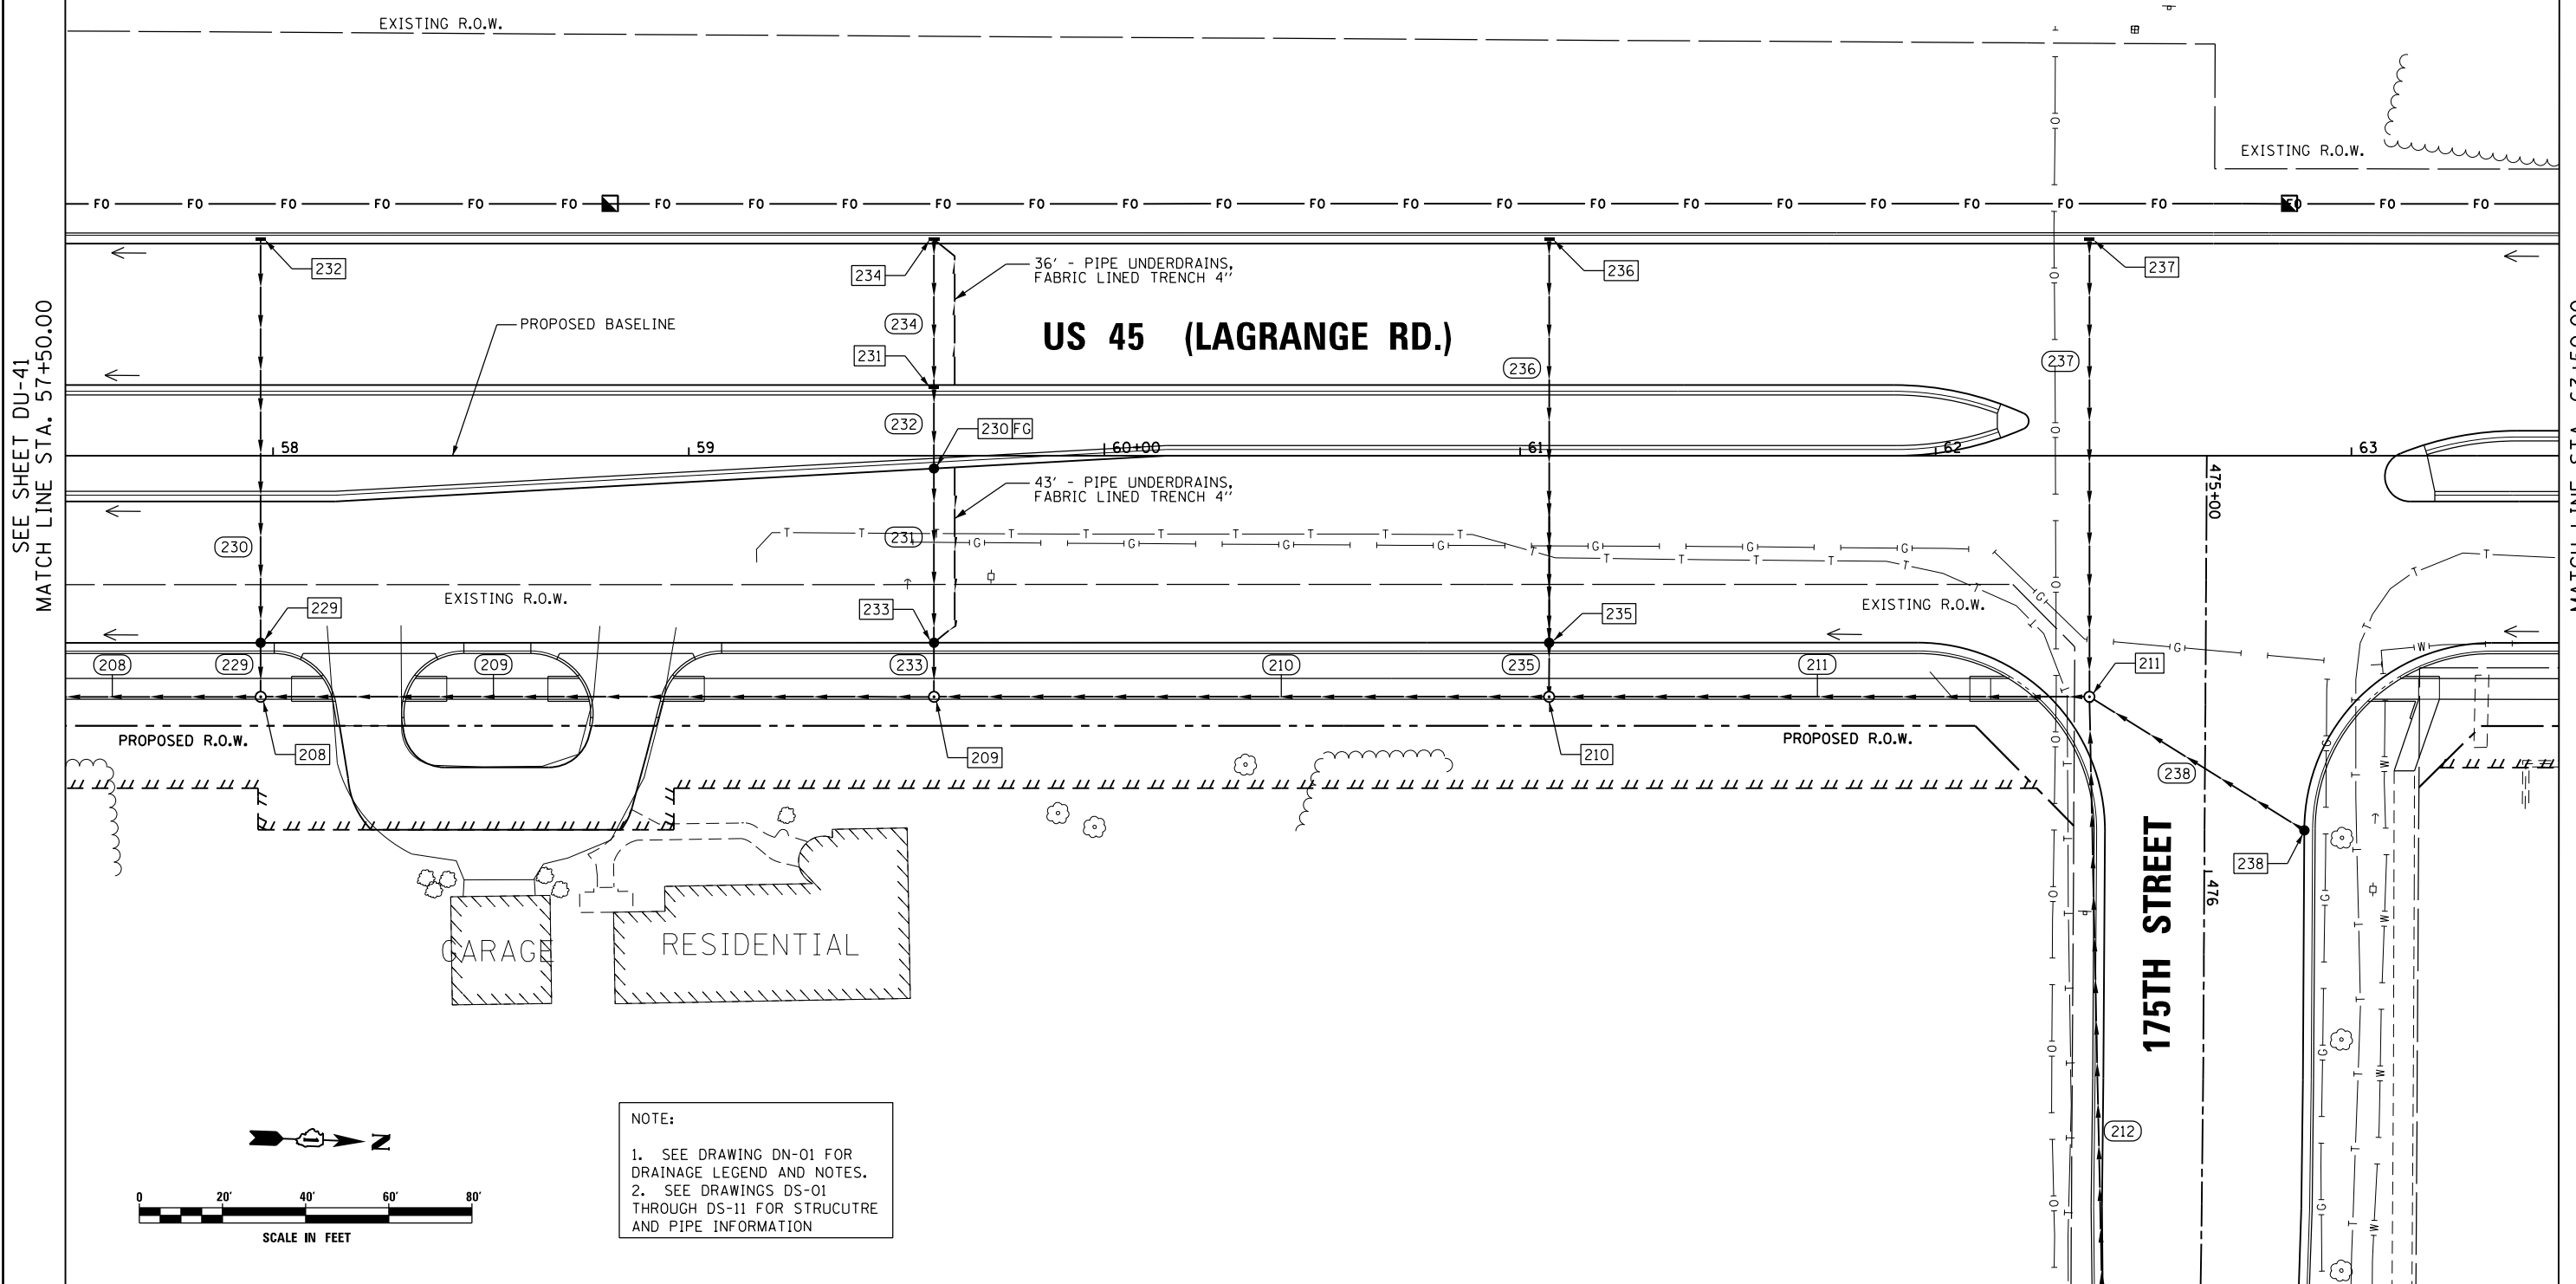

SEE SHEET DU-41  
MATCH LINE STA. 57+50.00

MATCH LINE STA. 63+50.00  
SEE SHEET DU-43

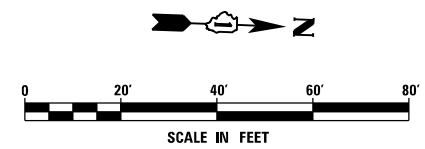

NOTE:  
1. SEE DRAWING DN-01 FOR DRAINAGE LEGEND AND NOTES.  
2. SEE DRAWINGS DS-01 THROUGH DS-11 FOR STRUCTURE AND PIPE INFORMATION

URS  
100 S. WACKER DR.  
SUITE 600  
CHICAGO, IL 60606  
TEL (312) 939-1000  
FAX (312) 939-4998

FILE NAME = D160F05-KEA-SHT-DRAINPR07.dgn	USER NAME = Anthony.Plutz	DESIGNED - MGS	REVISED -
SHT.PLAN	PLOT SCALE = 40.0001' / in.	DRAWN - REW	REVISED -
	PLOT DATE = 3/13/2013	CHECKED - JRS	REVISED -
		DATE - 03/13/13	REVISED -

STATE OF ILLINOIS  
DEPARTMENT OF TRANSPORTATION

PROPOSED DRAINAGE PLAN - US 45 (LAGRANGE ROAD)  
SCALE: 1"=20' SHEET 7 OF 35 SHEETS STA. 57+50.00 TO STA. 63+50.00

F.A.P. RTE. 330	SECTION 103R-3	COUNTY COOK	TOTAL SHEETS 932	SHEET NO. 298
DU-42			CONTRACT NO. 60F05	
ILLINOIS FED. AID PROJECT				