


SEE SHEET DU-51
MATCH LINE STA. 117+50.00

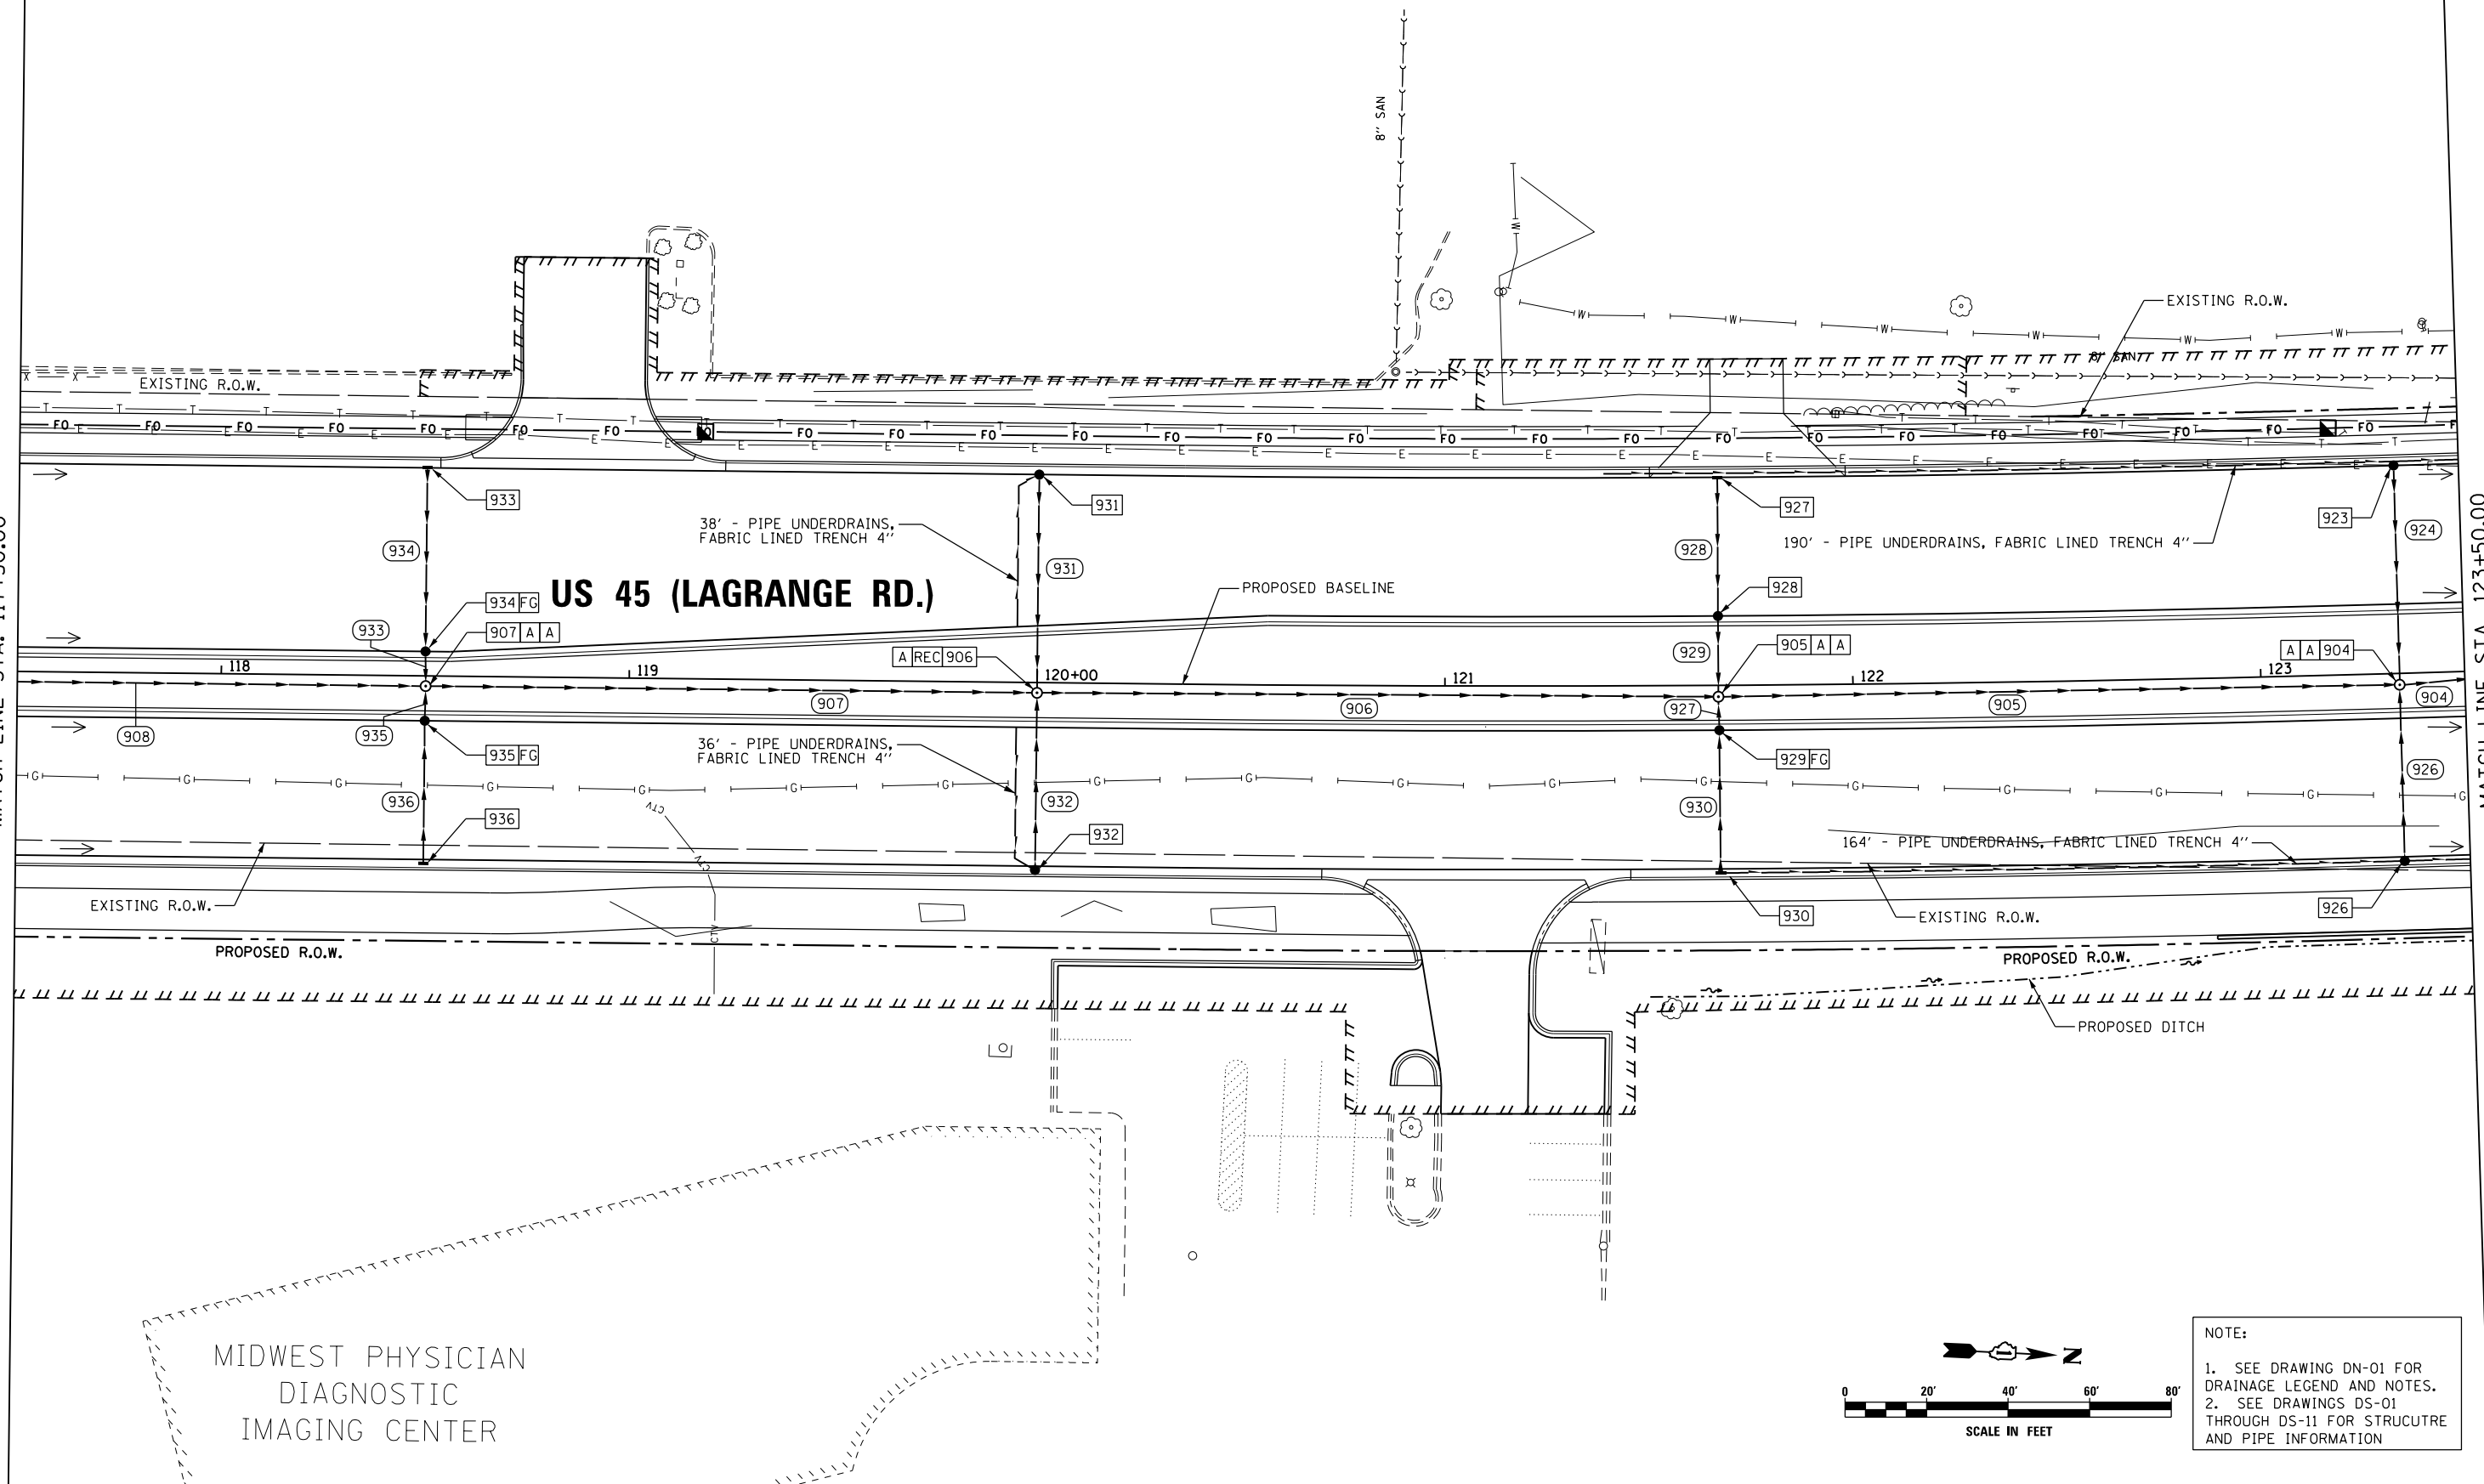

MIDWEST PHYSICIAN
DIAGNOSTIC
IMAGING CENTER

MATCH LINE STA. 123+50.00
SEE SHEET DU-53

NOTE:
1. SEE DRAWING DN-01 FOR DRAINAGE LEGEND AND NOTES.
2. SEE DRAWINGS DS-01 THROUGH DS-11 FOR STRUCTURE AND PIPE INFORMATION

FILE NAME = D160F05-KEA-SHT-DRAINPR17.dgn	USER NAME = Anthony.Plutz	DESIGNED - MGS	REVISED -
SHT.PLAN	PLOT SCALE = 40.0001' / in.	DRAWN - REW	REVISED -
	PLOT DATE = 3/13/2013	CHECKED - JRS	REVISED -
		DATE - 03/13/13	REVISED -

**STATE OF ILLINOIS
DEPARTMENT OF TRANSPORTATION**

PROPOSED DRAINAGE PLAN - US 45 (LAGRANGE ROAD)

SCALE: 1"=20' SHEET 17 OF 35 SHEETS STA. 117+50.00 TO STA. 123+50.00

F.A.P. RTE.	SECTION	COUNTY	TOTAL SHEETS	SHEET NO.
330	103R-3	COOK	932	308
DU-52			CONTRACT NO. 60F05	
ILLINOIS FED. AID PROJECT				