



**PROPOSED STRUCTURES AND PIPES**

NONE

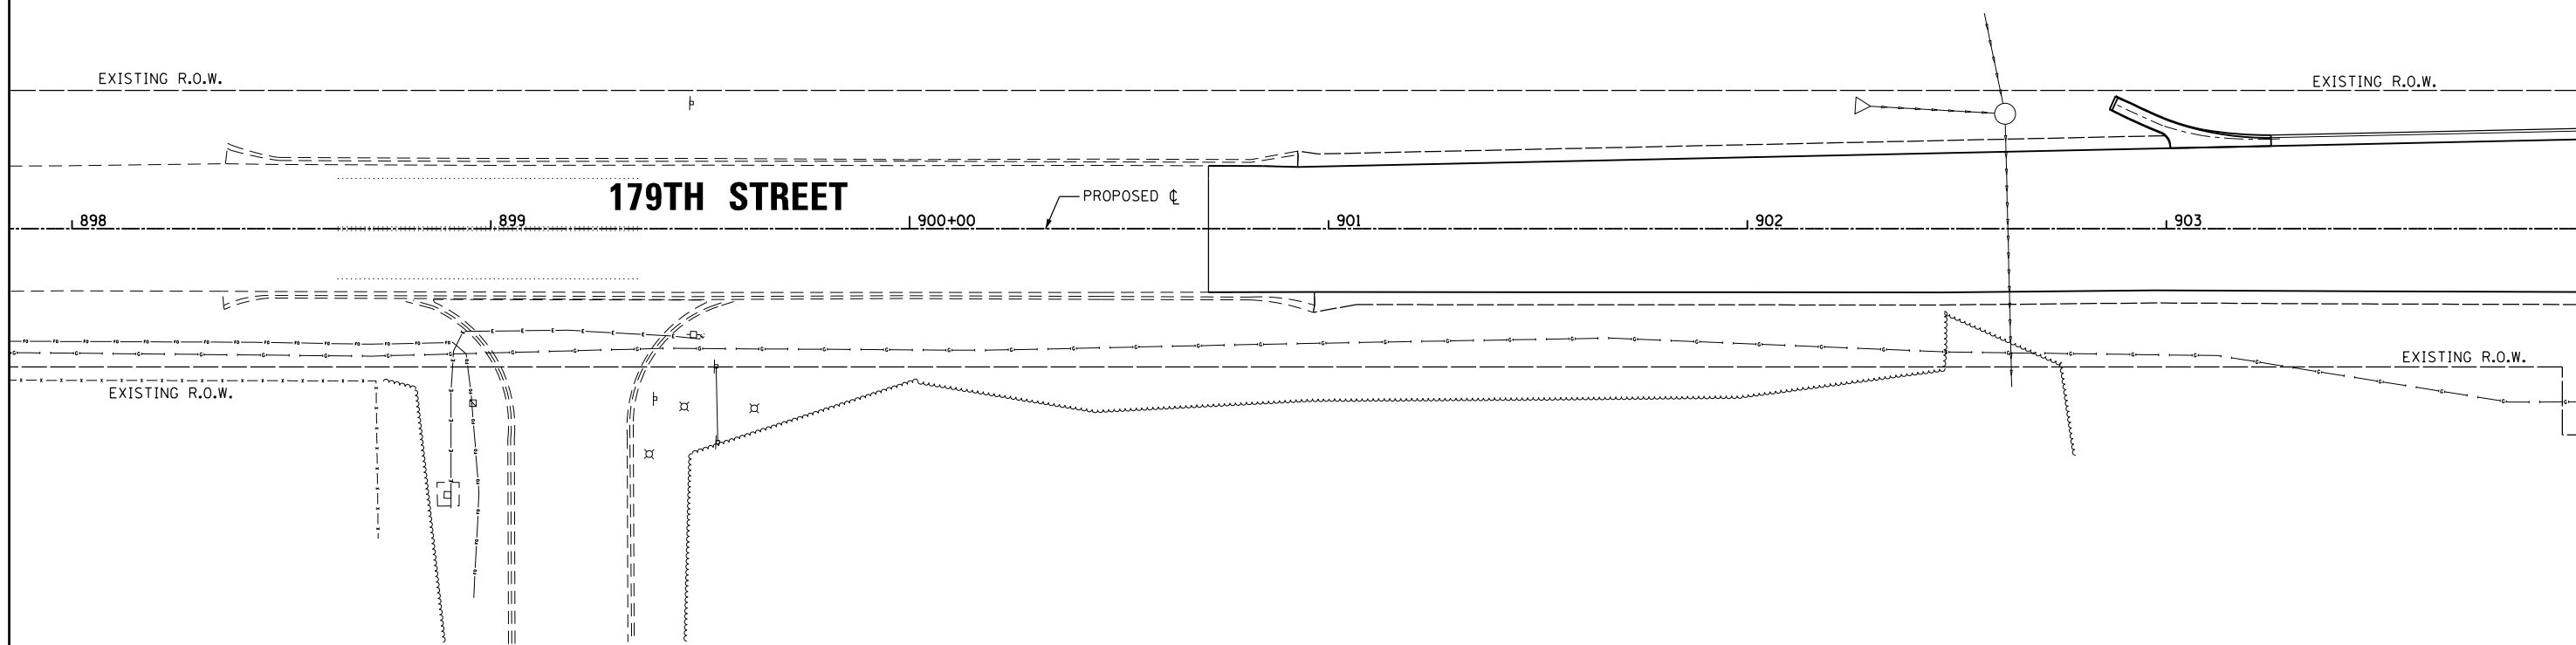

MATCH LINE STA. 904+00.00  
SEE SHEET DU-62

**NOTE:**  
1. SEE DRAWING DN-01 FOR DRAINAGE LEGEND AND NOTES.  
2. SEE DRAWINGS DS-01 THROUGH DS-11 FOR STRUCTURE AND PIPE INFORMATION

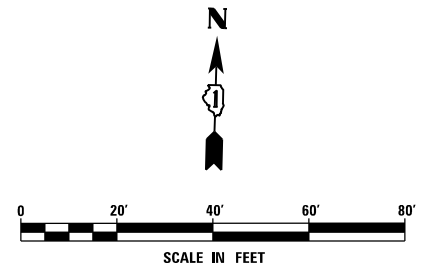

**URS**  
100 S. WACKER DR.  
SUITE 600  
CHICAGO, IL 60606  
TEL (312) 939-1000  
FAX (312) 939-4998

FILE NAME = D160F05-KEA-SHT-DRAINPR26.dgn	USER NAME = Anthony.Plutz	DESIGNED - MGS	REVISED -
SHT_PLAN	PLOT SCALE = 40.0001' / in.	DRAWN - REW	REVISED -
	PLOT DATE = 3/13/2013	CHECKED - JRS	REVISED -
		DATE - 03/13/13	REVISED -

**STATE OF ILLINOIS  
DEPARTMENT OF TRANSPORTATION**

**PROPOSED DRAINAGE PLAN - 179TH STREET**

SCALE: 1"=20' SHEET 26 OF 35 SHEETS STA. BEGIN TO STA. 904+00.00

F.A.P. RTE. 330	SECTION 103R-3	COUNTY COOK	TOTAL SHEETS 932	SHEET NO. 317
<b>DU-61</b>		CONTRACT NO. 60F05		
ILLINOIS FED. AID PROJECT				