


SEE SHEET DU-61  
 MATCH LINE STA. 904+00.00

MATCH LINE STA. 910+00.00  
 SEE SHEET DU-63

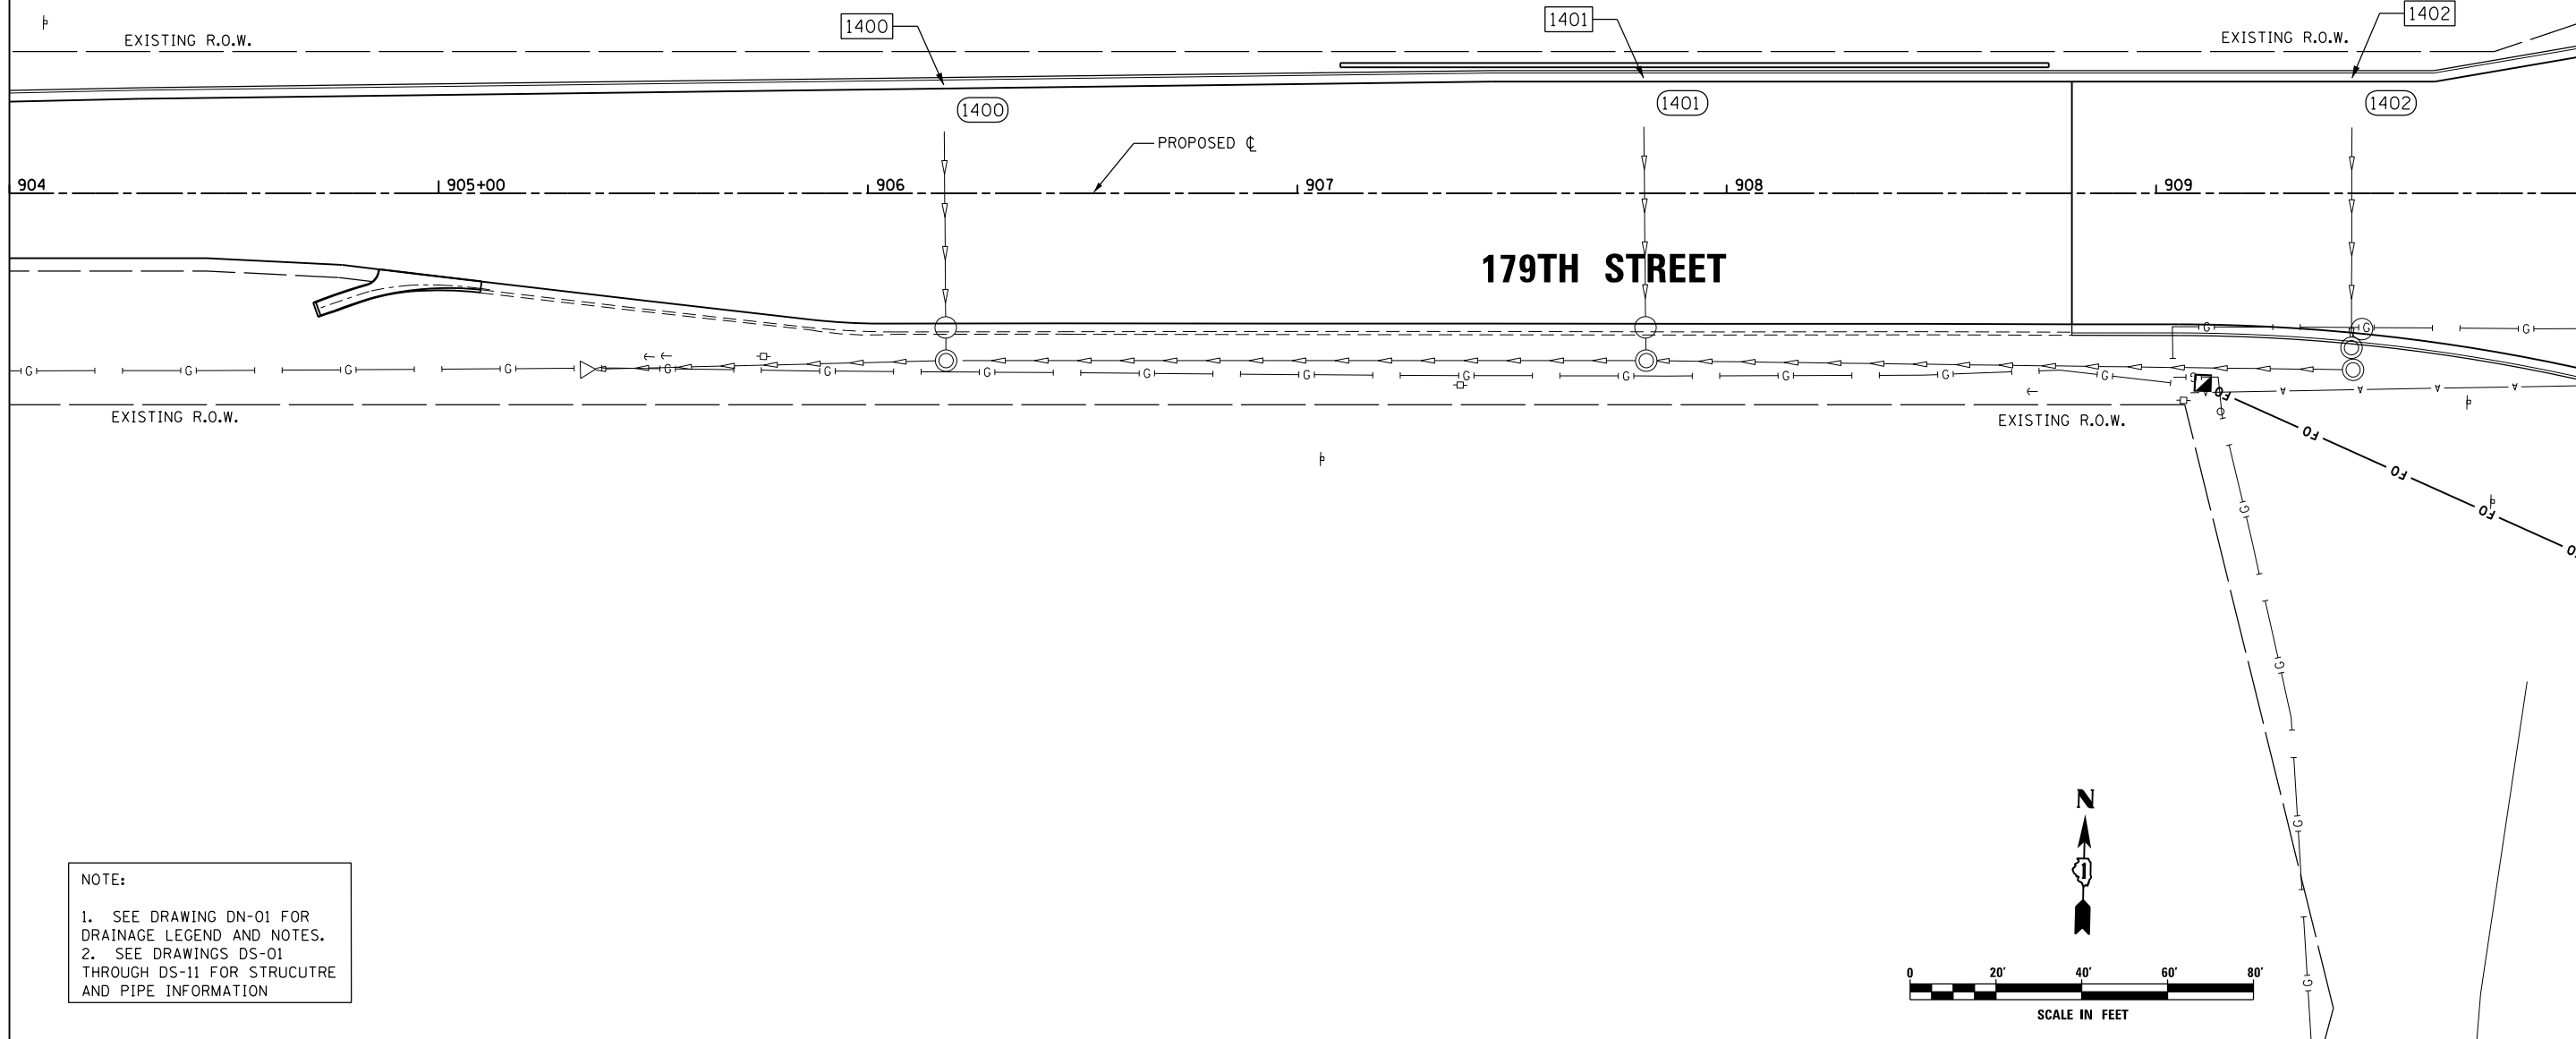

**NOTE:**  
 1. SEE DRAWING DN-01 FOR DRAINAGE LEGEND AND NOTES.  
 2. SEE DRAWINGS DS-01 THROUGH DS-11 FOR STRUCTURE AND PIPE INFORMATION

FILE NAME = D:\160F05-KEA-SHT-DRAINPR27.dgn	USER NAME = Anthony.Plutz	DESIGNED - MGS	REVISED -
SHT.PLAN	PLOT SCALE = 40.0001' / in.	DRAWN - REW	REVISED -
	PLOT DATE = 3/13/2013	CHECKED - JRS	REVISED -
		DATE - 03/13/13	REVISED -

**STATE OF ILLINOIS  
 DEPARTMENT OF TRANSPORTATION**

**PROPOSED DRAINAGE PLAN - 179TH STREET**  
 SCALE: 1"=20' SHEET 27 OF 35 SHEETS STA. 904+00.00 TO STA. 910+00.00

F.A.P. RTE. 330	SECTION 103R-3	COUNTY COOK	TOTAL SHEETS 932	SHEET NO. 318
<b>DU-62</b>			CONTRACT NO. 60F05	
ILLINOIS FED. AID PROJECT				