

FILE NAME =
 D160F05-KEA-SHT-DRAINPR29.dgn
 SHT.PLAN


USER NAME = Anthony.Plutz
 DESIGNED - MGS
 DRAWN - REW
 PLOT SCALE = 48.0001' / in.
 PLOT DATE = 3/13/2013

REVISED -
 REVISED -
 REVISED -
 REVISED -


**STATE OF ILLINOIS
 DEPARTMENT OF TRANSPORTATION**

PROPOSED DRAINAGE PLAN - 175TH STREET
 SCALE: 1"=20' SHEET 29 OF 35 SHEETS STA. TO STA.

| F.A.P. RTE. | SECTION | COUNTY | TOTAL SHEETS | SHEET NO. |
|---------------------------|---------|--------|---------------------------|-----------|
| 330 | 103R-3 | COOK | 932 | 320 |
| DU-64 | | | CONTRACT NO. 60F05 | |
| ILLINOIS FED. AID PROJECT | | | | |

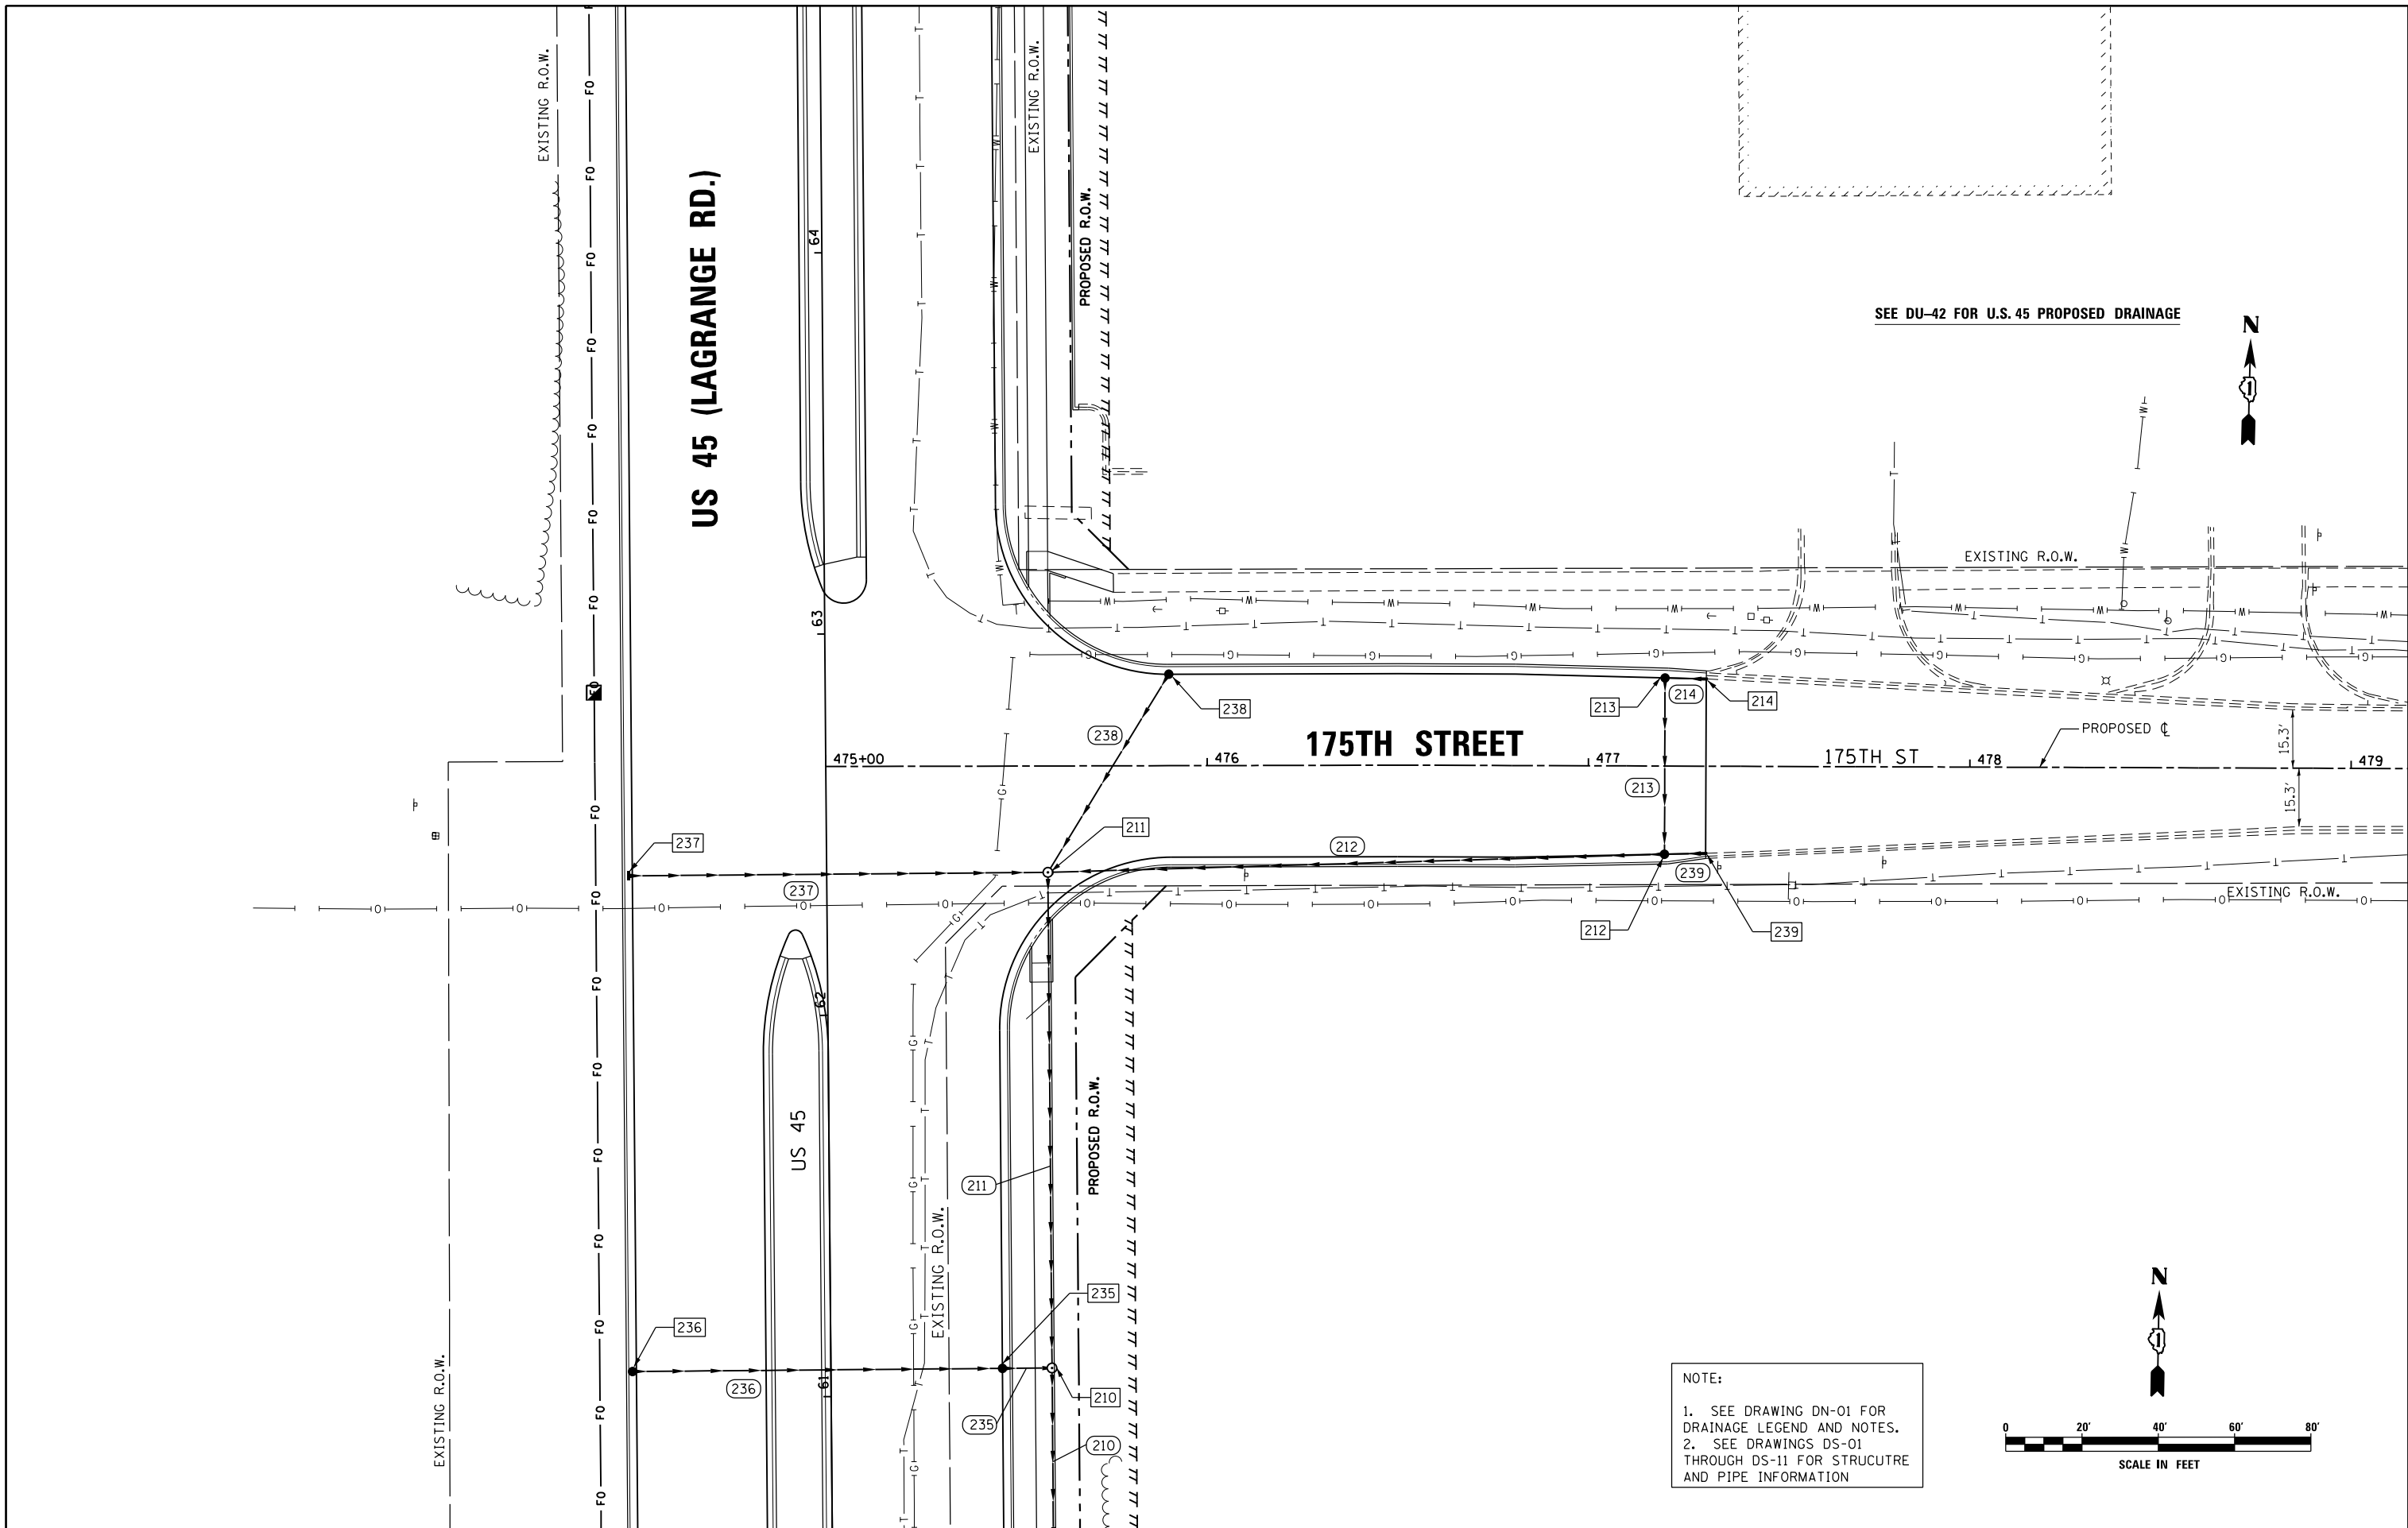

SEE DU-42 FOR U.S. 45 PROPOSED DRAINAGE

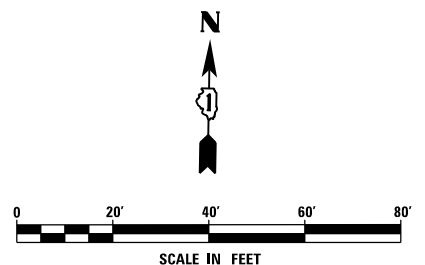

NOTE:
 1. SEE DRAWING DN-01 FOR DRAINAGE LEGEND AND NOTES.
 2. SEE DRAWINGS DS-01 THROUGH DS-11 FOR STRUCTURE AND PIPE INFORMATION