


s:\projects\3009 1-90_cumberland-patrick\project work\disciplines\electrical\sheet\DI60J14-sht-light-02.dgn

2/18/2013 2:43:16 PM

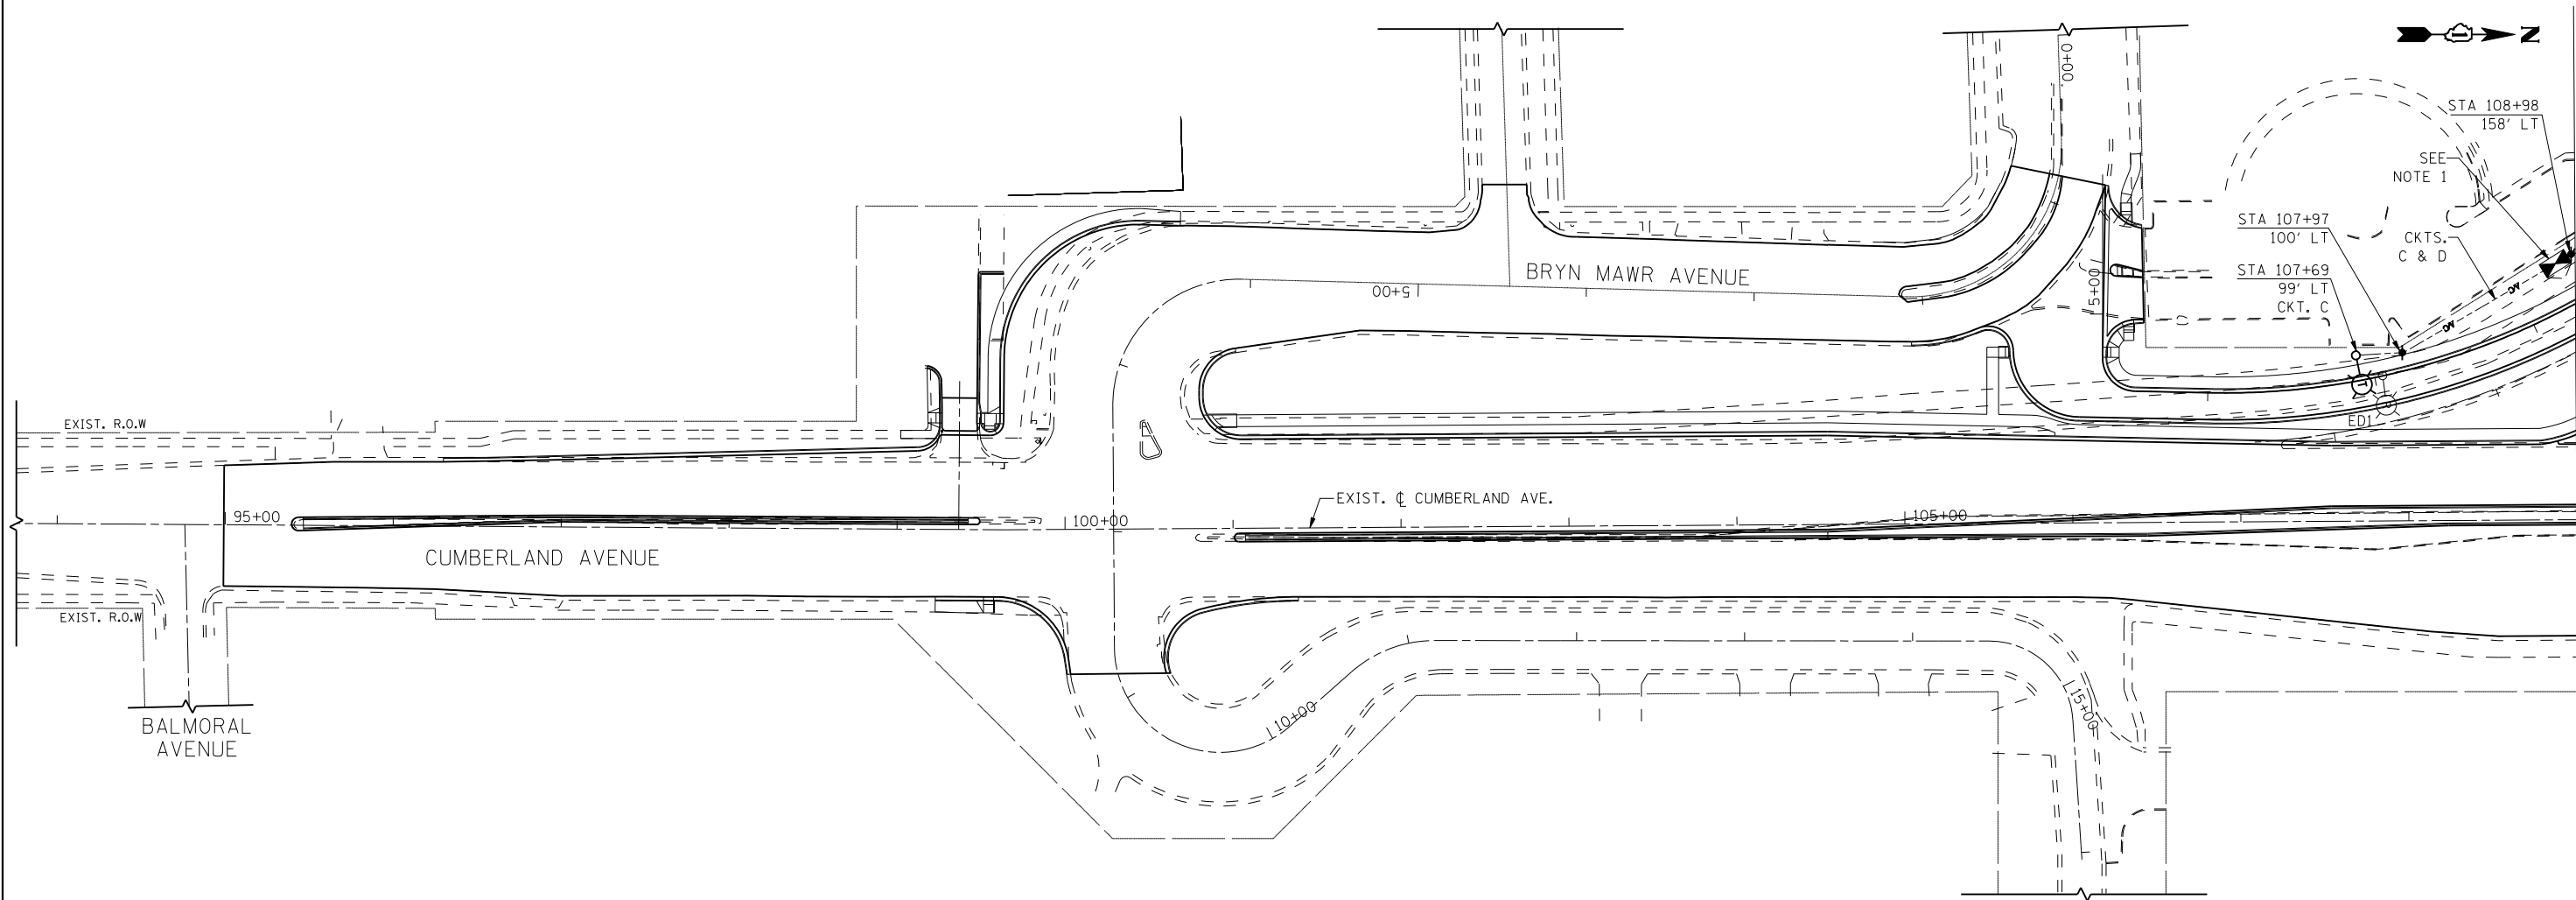

- NOTES:**
1. REMOVE EXISTING LIGHTING CONTROLLER "E" AND SALVAGE TO IDOT. CONTROLLER SHALL BE REPLACED WITH NEW CONTROLLER ON EXISTING FOUNDATION. SEE PROPOSED IDOT LIGHTING PLANS.
 2. TEMPORARY WOOD POLES ALONG RAMP 6 SHALL BE FURNISHED WITH 400W TYPE M-C-III LUMINAIRES.



USER NAME =	DESIGNED - RAS	REVISED -
	DRAWN - RAS	REVISED -
PLOT SCALE =	CHECKED - MKR	REVISED -
PLOT DATE =	DATE - 2/18/2013	REVISED -



**STATE OF ILLINOIS
DEPARTMENT OF TRANSPORTATION**

**IDOT TEMPORARY LIGHTING AND REMOVAL PLAN
CUMBERLAND AVENUE**

SCALE: 1" = 50' SHEET NO. 1 OF 2 SHEETS STA. 93+76 TO STA. 109+00

F.A.U. RTE.	SECTION	COUNTY	TOTAL SHEETS	SHEET NO.
2746	1616B	COOK	404	234
CONTRACT NO. 60J14				
ILLINOIS FED. AID PROJECT				

LT-02