


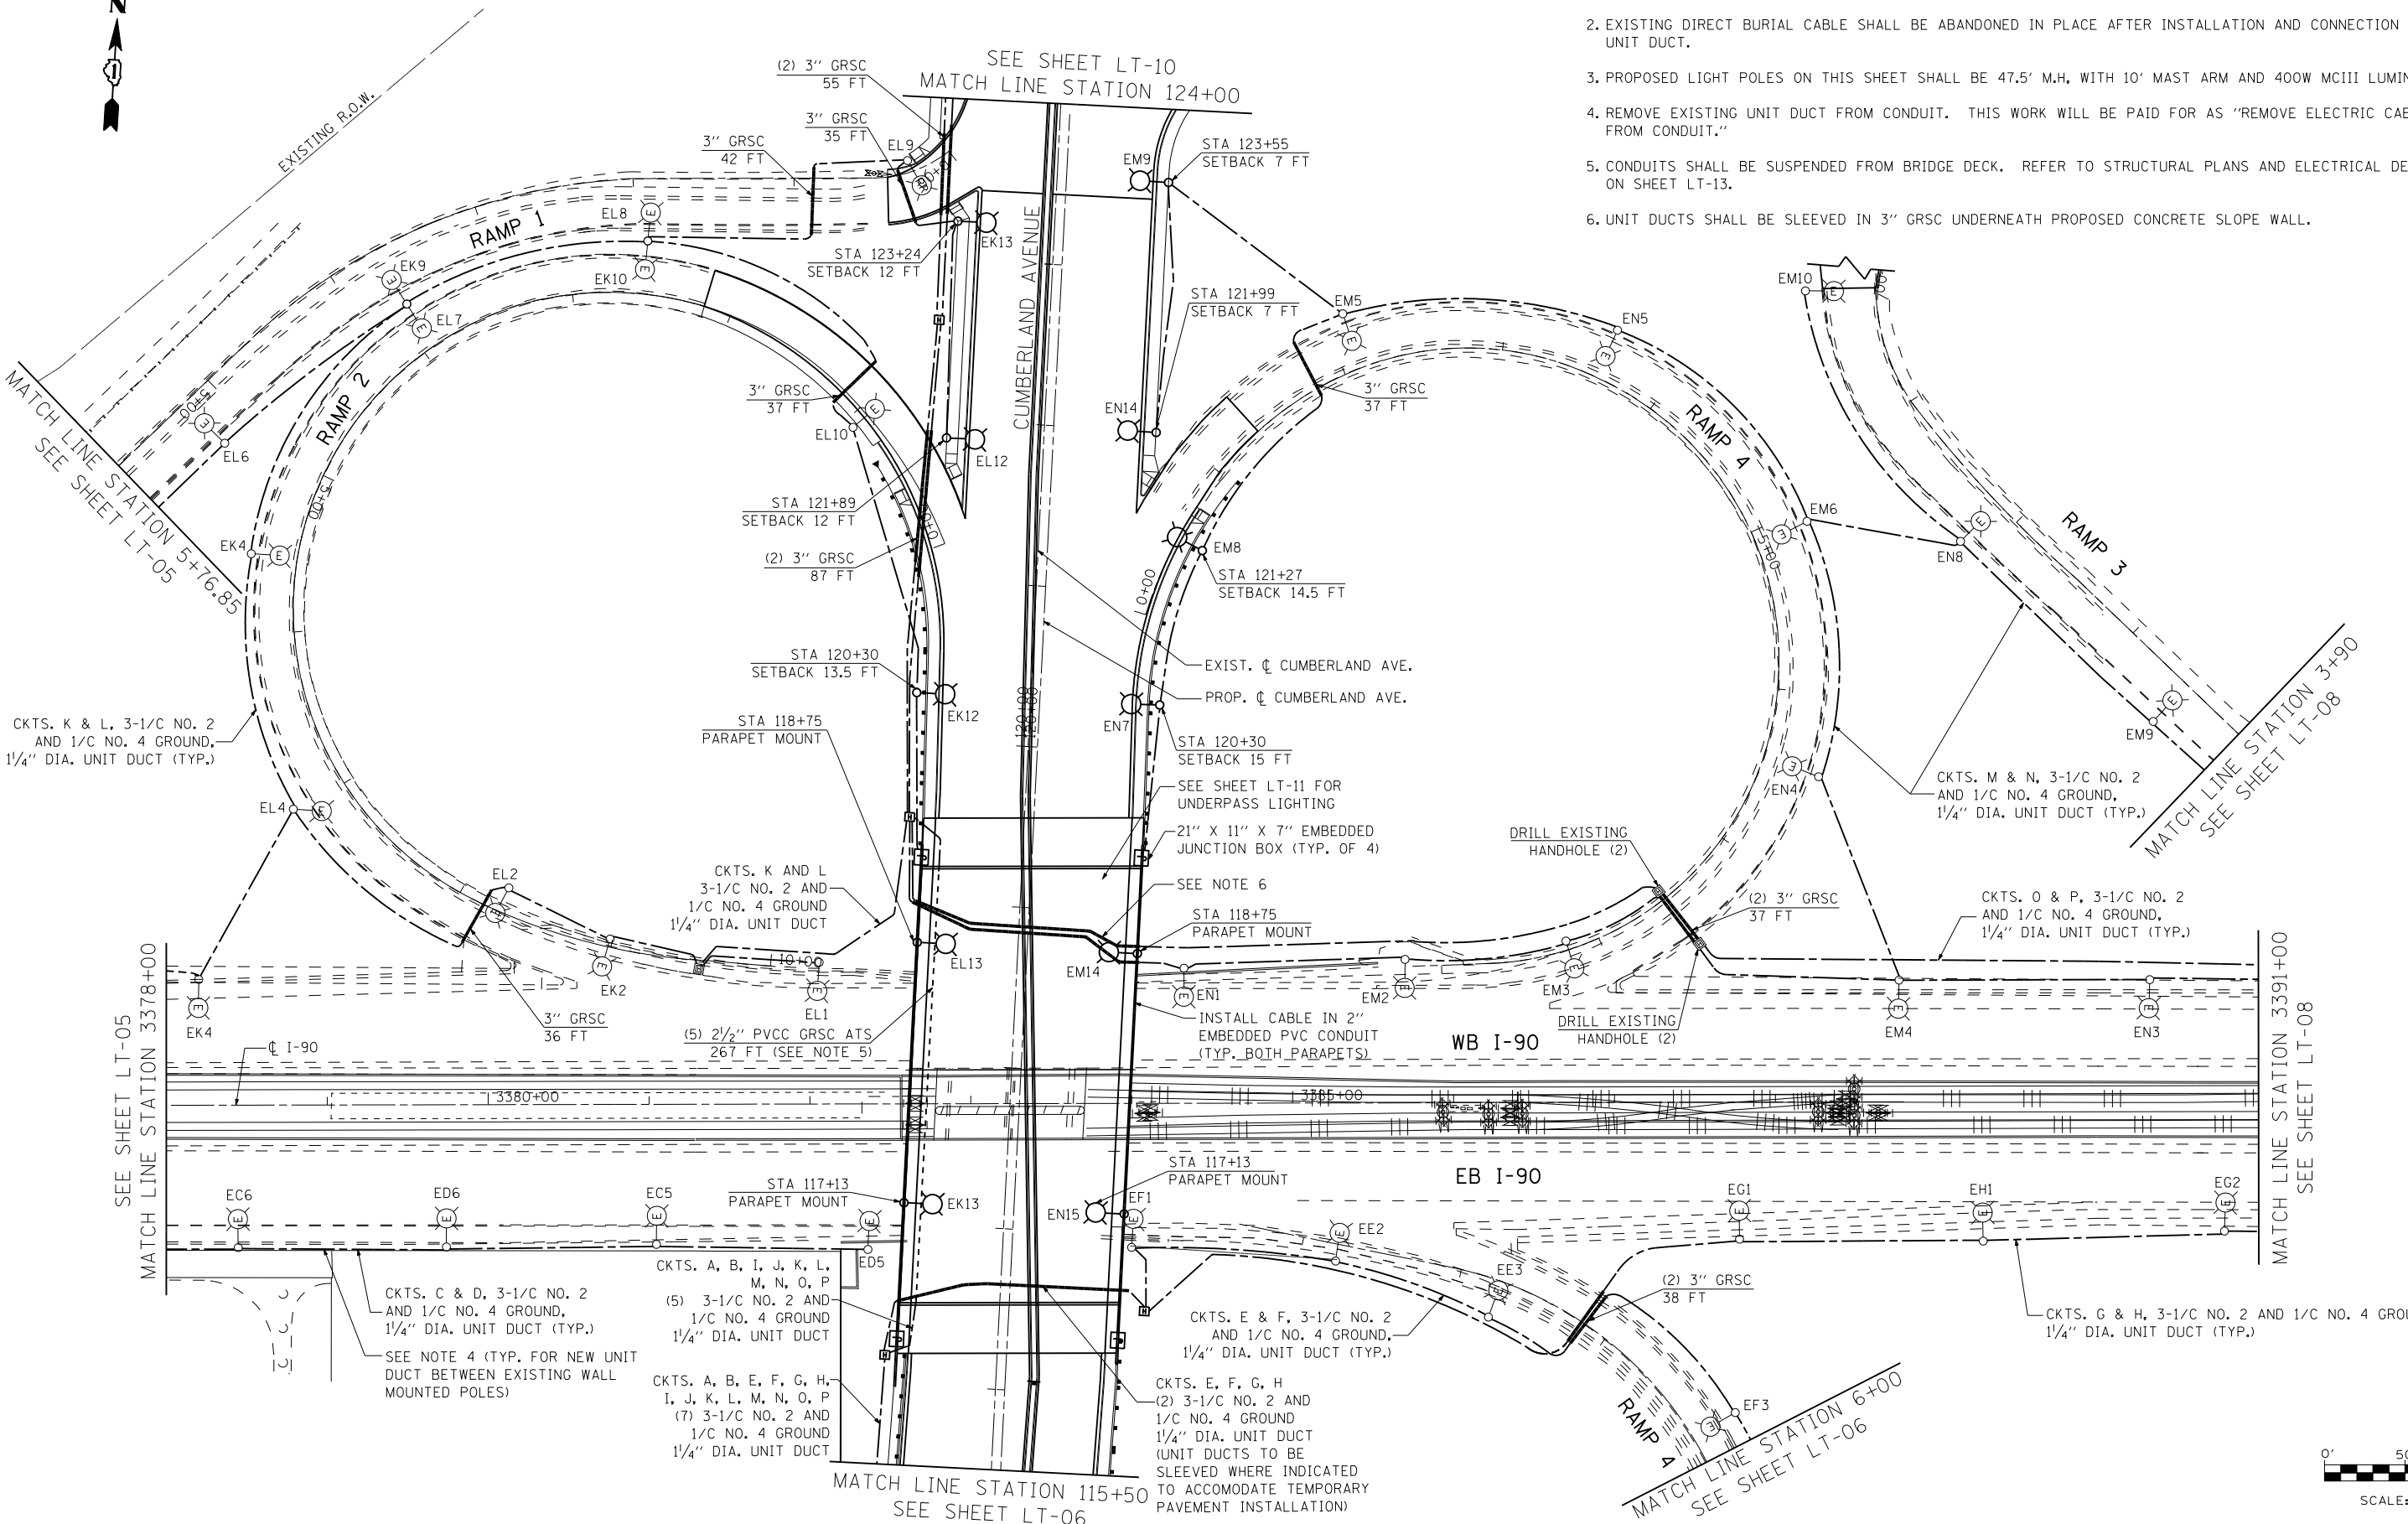

NOTES:

1. UTILIZE EXISTING CONDUIT ENTRANCES IN FOUNDATION TO ROUTE NEW UNIT DUCT TO EXISTING LIGHT POLE. REMOVE AND REPLACE EXISTING FUSE KIT AT POLE BASE.
2. EXISTING DIRECT BURIAL CABLE SHALL BE ABANDONED IN PLACE AFTER INSTALLATION AND CONNECTION OF NEW UNIT DUCT.
3. PROPOSED LIGHT POLES ON THIS SHEET SHALL BE 47.5' M.H, WITH 10' MAST ARM AND 400W MCIII LUMINAIRE.
4. REMOVE EXISTING UNIT DUCT FROM CONDUIT. THIS WORK WILL BE PAID FOR AS "REMOVE ELECTRIC CABLE FROM CONDUIT."
5. CONDUITS SHALL BE SUSPENDED FROM BRIDGE DECK. REFER TO STRUCTURAL PLANS AND ELECTRICAL DETAILS ON SHEET LT-13.
6. UNIT DUCTS SHALL BE SLEEVED IN 3" GRSC UNDERNEATH PROPOSED CONCRETE SLOPE WALL.

s:\projects\3009_1-90_cumberland-patrick-work\disciplines\electrical\sheet\DI60J14-sht-light.07.dgn
 2/18/2013 2:43:25 PM



| | | |
|--------------|------------------|-----------|
| USER NAME = | DESIGNED - RAS | REVISED - |
| PLOT SCALE = | DRAWN - RAS | REVISED - |
| PLOT DATE = | CHECKED - MKR | REVISED - |
| | DATE - 2/18/2013 | REVISED - |



**STATE OF ILLINOIS
DEPARTMENT OF TRANSPORTATION**

**PROPOSED IDOT LIGHTING PLAN
I-90 AT CUMBERLAND AVENUE**

SCALE: 1" = 50' SHEET NO. 3 OF 6 SHEETS STA. 3378+00 TO STA. 3391+00

| | | | | |
|---------------------------|---------|--------|--------------|-----------|
| F.A.U. RTE. | SECTION | COUNTY | TOTAL SHEETS | SHEET NO. |
| 2746 | 1616B | COOK | 404 | 239 |
| CONTRACT NO. 60J14 | | | | |
| ILLINOIS FED. AID PROJECT | | | | |

LT-07