


 


s:\projects\3009 1-90\_cumberland-patrick\project work\disciplines\electrical\sheet\DI60J14-sht-light.09.dgn

2/18/2013 2:43:30 PM

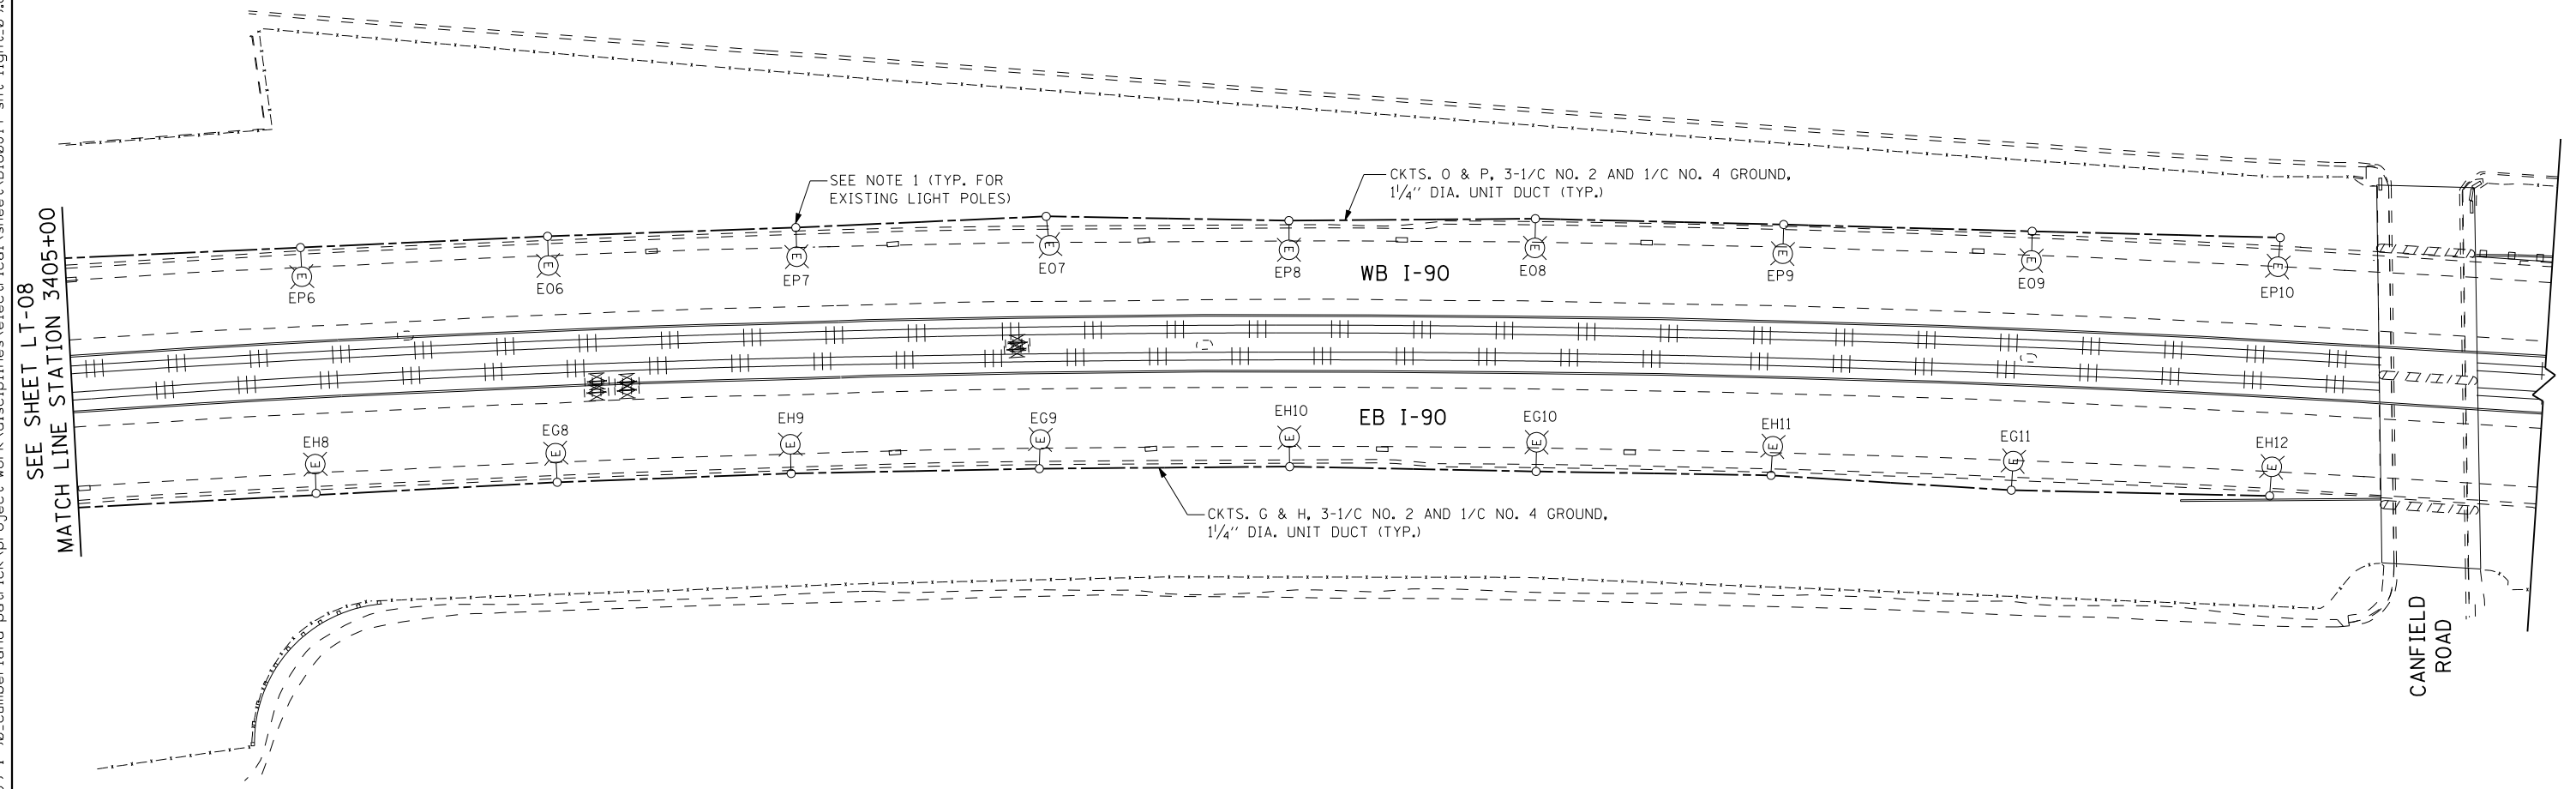

- NOTES:**
- UTILIZE EXISTING CONDUIT ENTRANCES IN FOUNDATION TO ROUTE NEW UNIT DUCT TO EXISTING LIGHT POLE. REMOVE AND REPLACE EXISTING FUSE KIT AT POLE BASE.
  - EXISTING DIRECT BURIAL CABLE SHALL BE ABANDONED IN PLACE AFTER INSTALLATION AND CONNECTION OF NEW UNIT DUCT.



USER NAME =	DESIGNED - RAS	REVISED -
	DRAWN - RAS	REVISED -
PLOT SCALE =	CHECKED - MKR	REVISED -
PLOT DATE =	DATE - 2/18/2013	REVISED -



**STATE OF ILLINOIS  
DEPARTMENT OF TRANSPORTATION**

**PROPOSED IDOT LIGHTING PLAN  
I-90 AT CUMBERLAND AVENUE**

SCALE: 1" = 50'    SHEET NO. 5 OF 6 SHEETS    STA. 3405+00 TO STA. 3420+00

F.A.U. RTE.	SECTION	COUNTY	TOTAL SHEETS	SHEET NO.
2746	1616B	COOK	404	241
CONTRACT NO. 60J14				
ILLINOIS FED. AID PROJECT				

LT-09