


STORM SEWER REMOVAL 12"
 STA. 212+80.6 TO 212+84.2 - 62' (TBF=9.9 CU YD)
 STA. 214+82.3 TO 214+82.9 - 63' (TBF=10.2 CU YD)
 STA. 214+82.9 TO 215+27.9 - 41' (TBF=6.5 CU YD)
 STA. 216+73.2 TO 216+75.6 - 63' (TBF=10.0 CU YD)

REMOVING CATCH BASINS
 212+80.58, 34.6 RT
 212+84.17, 31.6 LT
 214+82.30, 31.6 LT
 214+82.93, 34.9 RT
 215+27.94, 34.9 RT
 215+73.16, 34.8 RT
 215+75.59, 31.7 LT

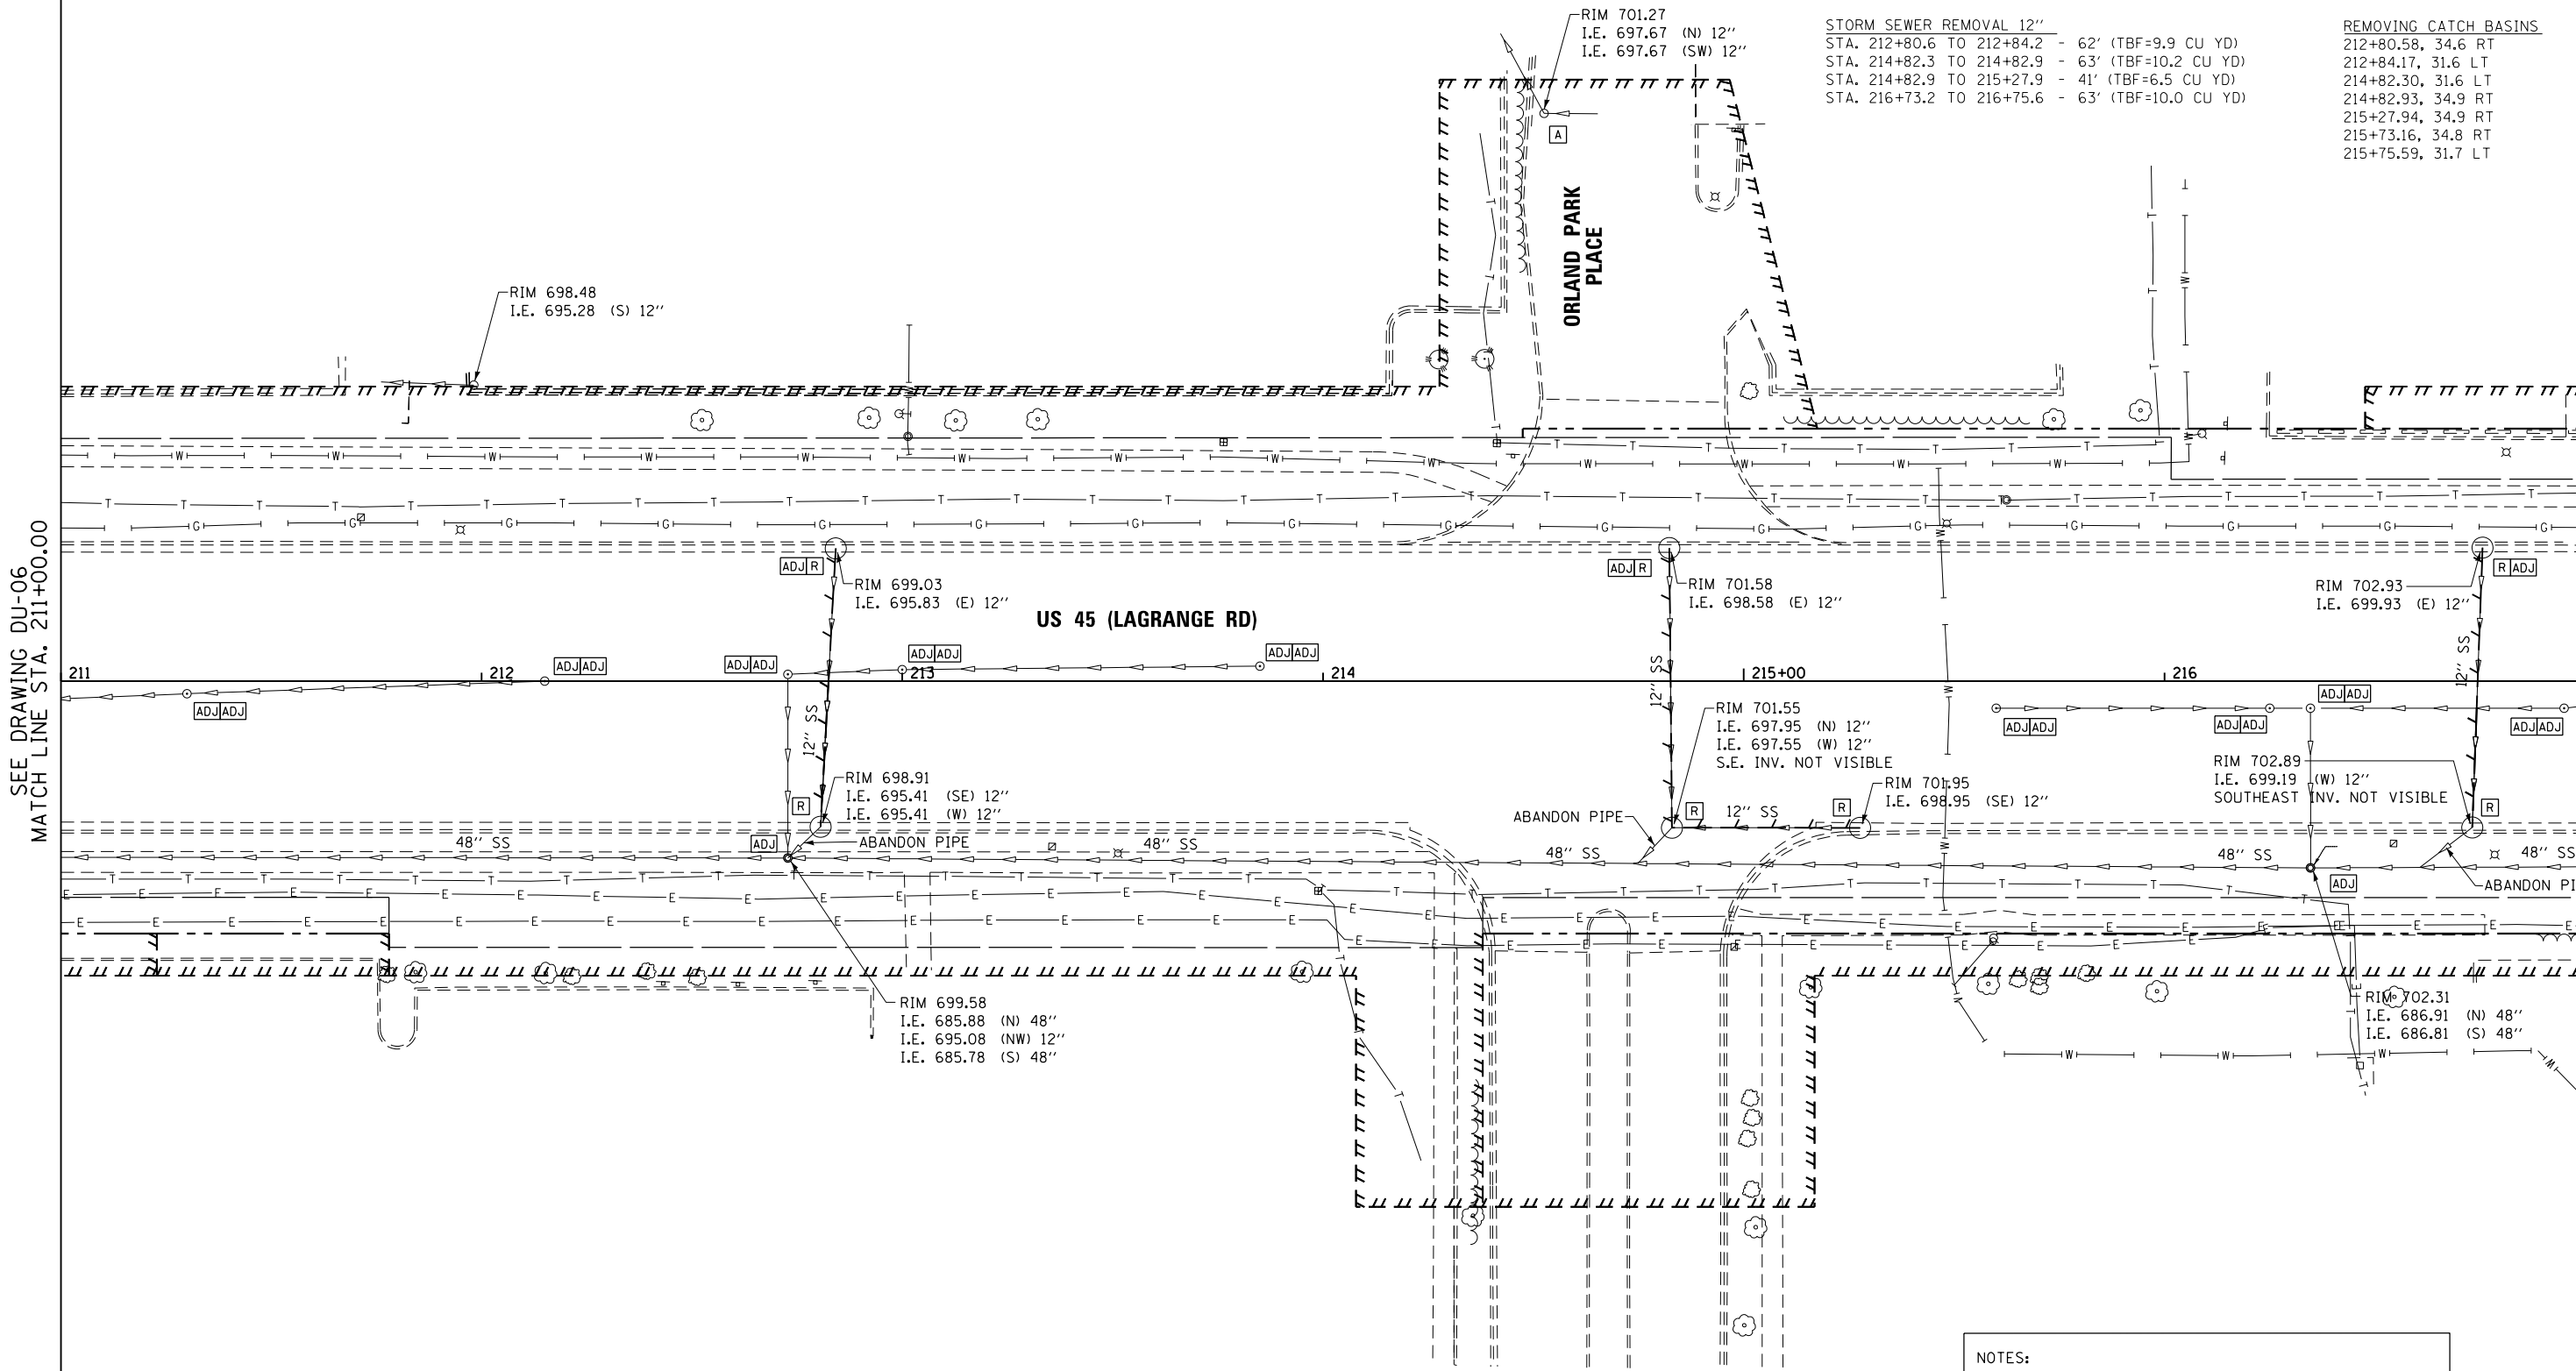

SEE DRAWING DU-06
 MATCH LINE STA. 211+00.00

MATCH LINE STA. 217+00.00
 SEE DRAWING DU-08

NOTES:
 1. SEE DRAWING DN-01 FOR DRAINAGE LEGEND AND NOTES.
 2. SEE DRAWINGS DS-01 THROUGH DS-09 FOR STRUCTURE AND PIPE INFORMATION.

100 S. WACKER DR.
 SUITE 600
 CHICAGO, IL 60606
 TEL (312) 939-1000
 FAX (312) 939-4998

URS

FILE NAME = D160M61-SHT-DRAINEX07.dgn	USER NAME = Anthony.Plutz	DESIGNED - EJD	REVISED -	STATE OF ILLINOIS DEPARTMENT OF TRANSPORTATION	EXISTING DRAINAGE PLAN - US 45 (LAGRANGE ROAD)			F.A.P. RTE. 330	SECTION 103R-4	COUNTY COOK	TOTAL SHEETS 877	SHEET NO. 165
SHT.PLAN	PLOT SCALE = 48.0000' / in.	CHECKED - JWM	REVISED -		SCALE: 1"=20'	SHEET 7 OF 17 SHEETS	STA. 211+00.00 TO STA. 217+00.00	DU-07		CONTRACT NO. 60M61		
	PLOT DATE = 3/14/2013	DATE - 03/13/2013	REVISED -		ILLINOIS FED. AID PROJECT							