



STORM SEWER REMOVAL 12"
 STA. 223+00.0 TO 223+04.2 - 66' (TBF=33.6 CU YD)
 STA. 223+42.5 TO 223+36.9 - 6' (TBF=1.6 CU YD)
 STA. 223+72.3 TO 223+42.5 - 28' (TBF=5.3 CU YD)
 STA. 224+42.7 TO 224+42.0 - 15' (TBF=2.0 CU YD)
 STA. 226+05.5 TO 226+12.7 - 5' (TBF=1.7 CU YD)
 STA. 226+12.3 TO 226+13.0 - 72' (TBF=14.6 CU YD)

REMOVING CATCH BASINS
 223+04.19, 22.9 LT
 223+42.54, 37.1 LT
 224+42.70, 31.5 LT
 226+12.34, 44.0 RT
 226+13.03, 31.4 LT

STORM SEWER REMOVAL 24"
 STA. 223+28.1 TO 223+36.9 - 94' (TBF=122.8 CU YD)

REMOVING CATCH BASINS
 TO MAINTAIN FLOW
 224+42.03, 35.0 RT

REMOVING MANHOLES
 223+40.00, 46.0' LT

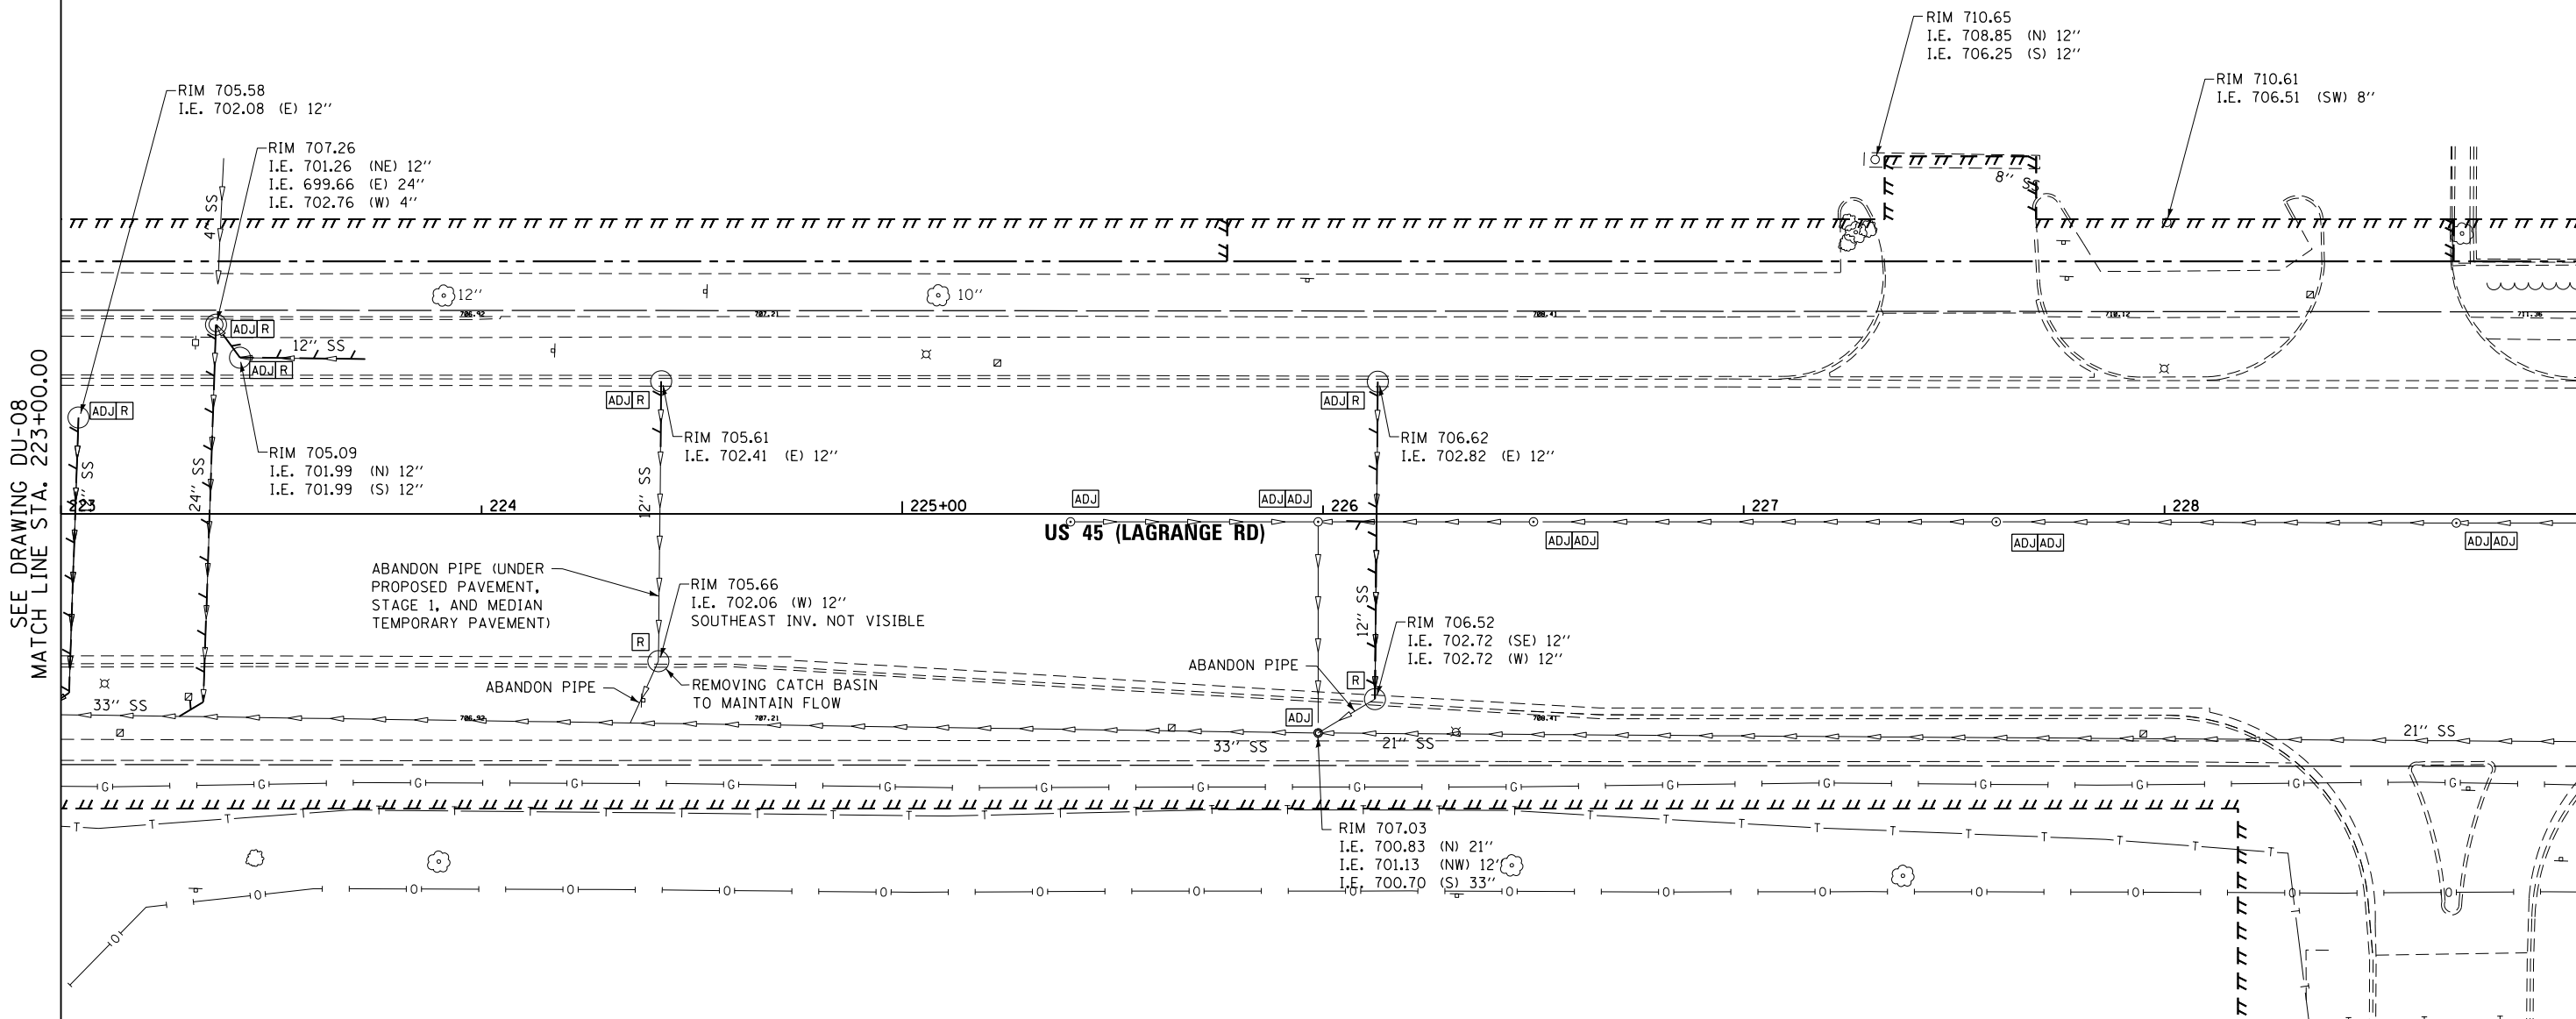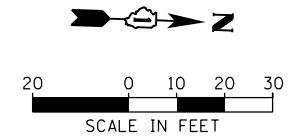

SEE DRAWING DU-08
 MATCH LINE STA. 223+00.00

MATCH LINE STA. 229+00.00
 SEE DRAWING DU-10

NOTES:
 1. SEE DRAWING DN-01 FOR DRAINAGE LEGEND AND NOTES.
 2. SEE DRAWINGS DS-01 THROUGH DS-09 FOR STRUCTURE AND PIPE INFORMATION.

100 S. WACKER DR.
 SUITE 600
 CHICAGO, IL 60606
 TEL (312) 939-1000
 FAX (312) 939-4998



FILE NAME = D160M61-SHT-DRAINEX09.dgn	USER NAME = Anthony.Plutz	DESIGNED - EJD	REVISED -
		DRAWN - EJD	REVISED -
		CHECKED - JWM	REVISED -
SHT.PLAN	PLOT DATE = 3/14/2013	DATE - 03/13/2013	REVISED -

**STATE OF ILLINOIS
 DEPARTMENT OF TRANSPORTATION**

EXISTING DRAINAGE PLAN - US 45 (LAGRANGE ROAD)

SCALE: 1"=20' SHEET 9 OF 17 SHEETS STA. 223+00.00 TO STA. 229+00.00

F.A.P. RTE. 330	SECTION 103R-4	COUNTY COOK	TOTAL SHEETS 877	SHEET NO. 167
DU-09			CONTRACT NO. 60M61	
ILLINOIS FED. AID PROJECT				