
 


SEE DRAWING DU-31
MATCH LINE STA. 193+00.00

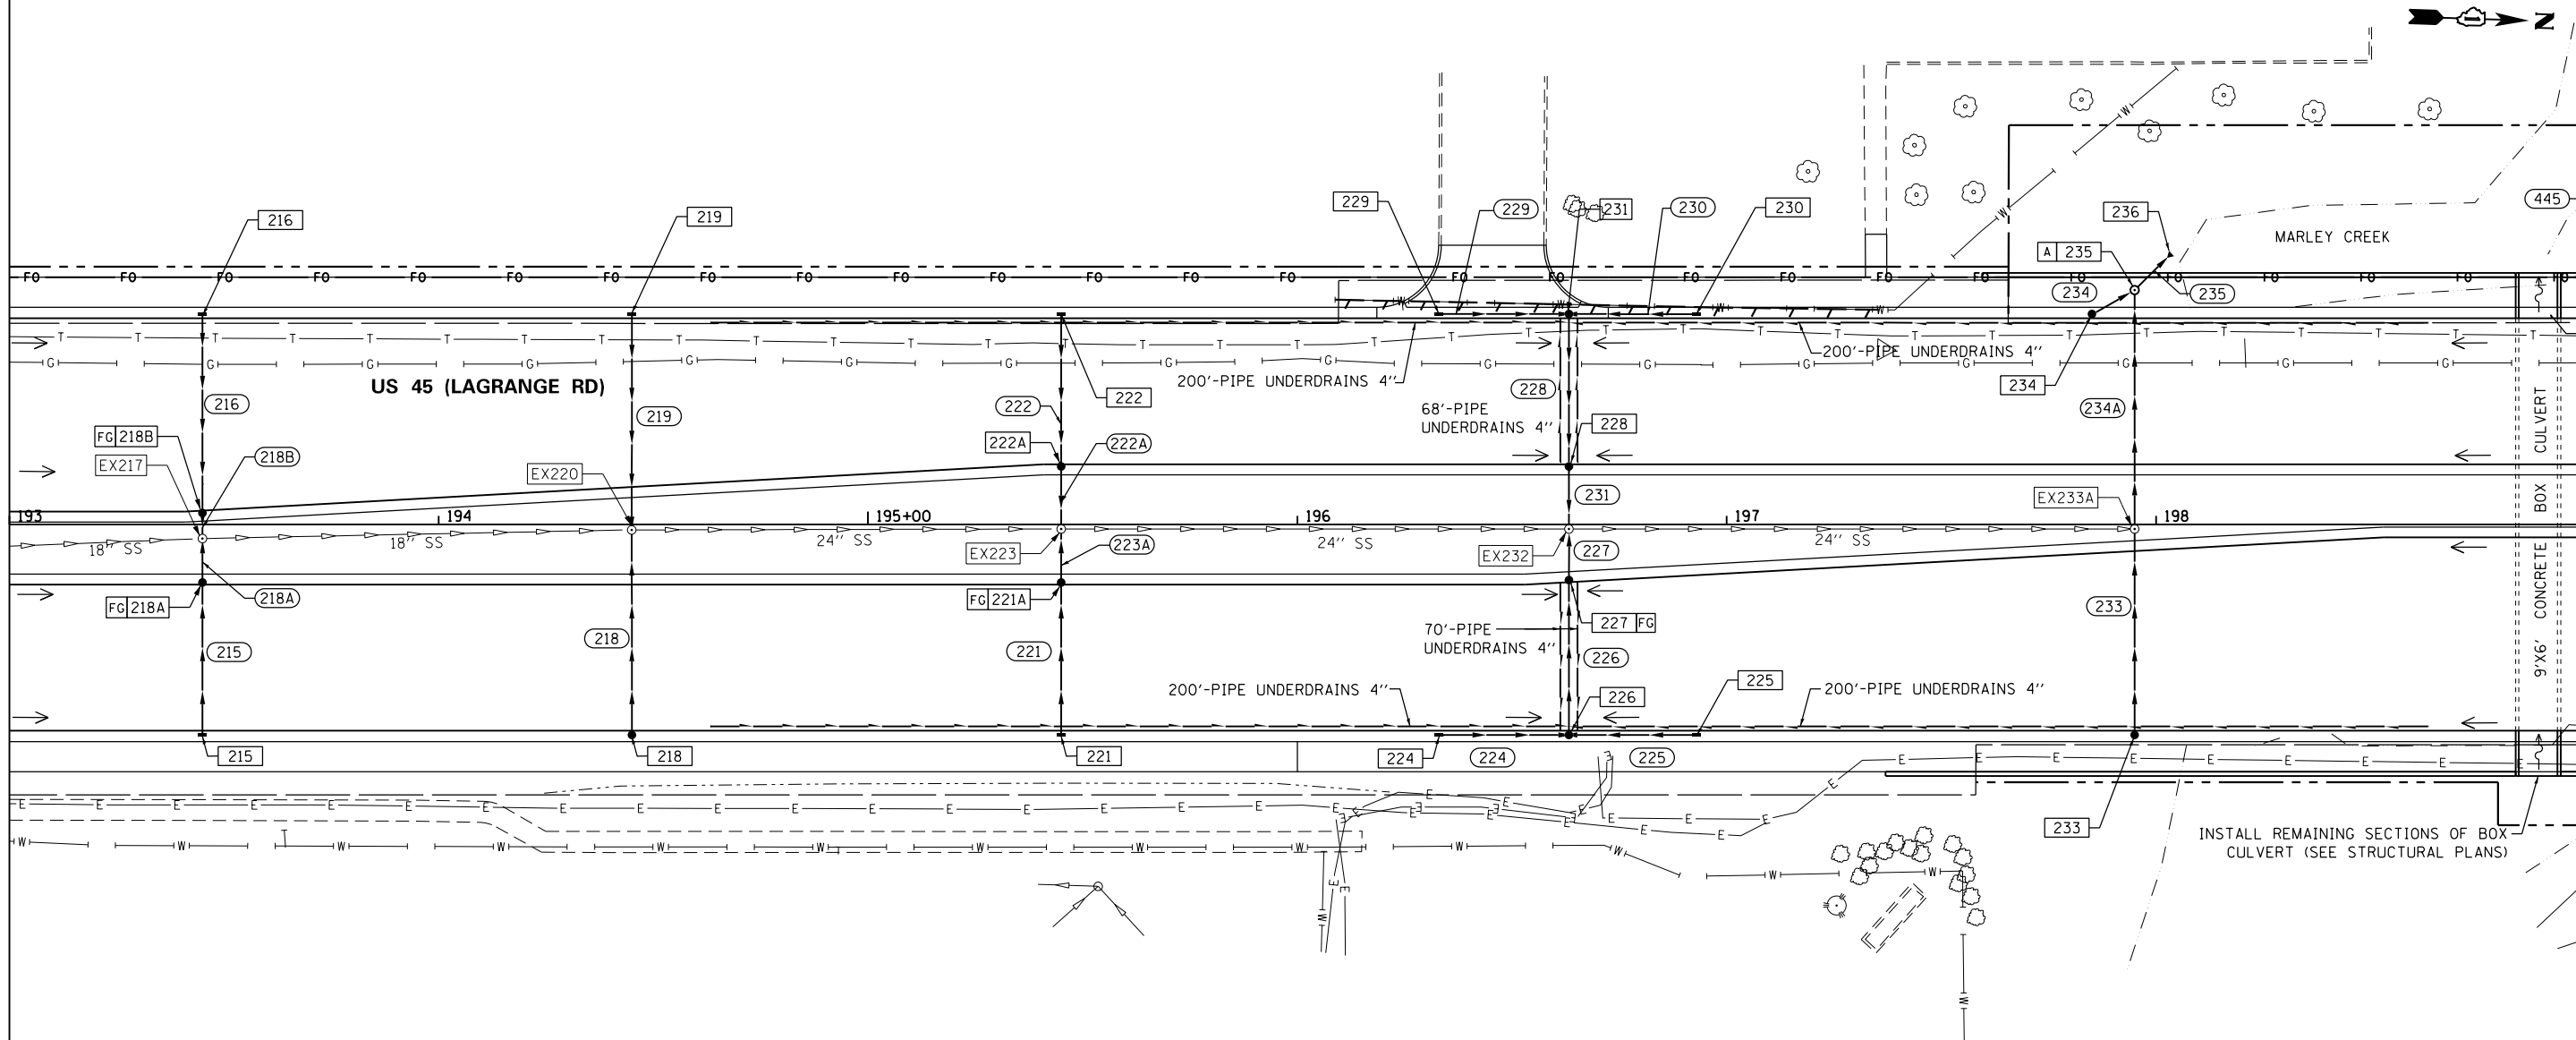

MATCH LINE STA. 199+00.00
SEE DRAWING DU-33



- NOTES:
- SEE DRAWING DN-01 FOR DRAINAGE LEGEND AND NOTES.
 - SEE DRAWINGS DS-01 THROUGH DS-09 FOR STRUCTURE AND PIPE INFORMATION.

FILE NAME = D160M61-SHT-DRAINPR04.dgn	USER NAME = Frank.Stallone	DESIGNED - EJD	REVISED -
SHT_PLAN	PLOT SCALE = 40.0000' / in.	DRAWN - EJD	REVISED -
	PLOT DATE = 3/15/2013	CHECKED - JWM	REVISED -
		DATE - 03/13/2013	REVISED -

STATE OF ILLINOIS DEPARTMENT OF TRANSPORTATION	DESIGNED - EJD	REVISED -
	DRAWN - EJD	REVISED -
	CHECKED - JWM	REVISED -
	DATE - 03/13/2013	REVISED -

**STATE OF ILLINOIS
DEPARTMENT OF TRANSPORTATION**

PROPOSED DRAINAGE PLAN - US 55 (LAGRANGE ROAD)

SCALE: 1"=20' SHEET 4 OF 17 SHEETS STA. 193+00.00 TO STA. 199+00.00

F.A.P. RTE. 330	SECTION 103R-4	COUNTY COOK	TOTAL SHEETS 877	SHEET NO. 190
DU-32			CONTRACT NO. 60M61	
ILLINOIS FED. AID PROJECT				