
 


SEE DRAWING DU-34
 MATCH LINE STA. 211+00.00

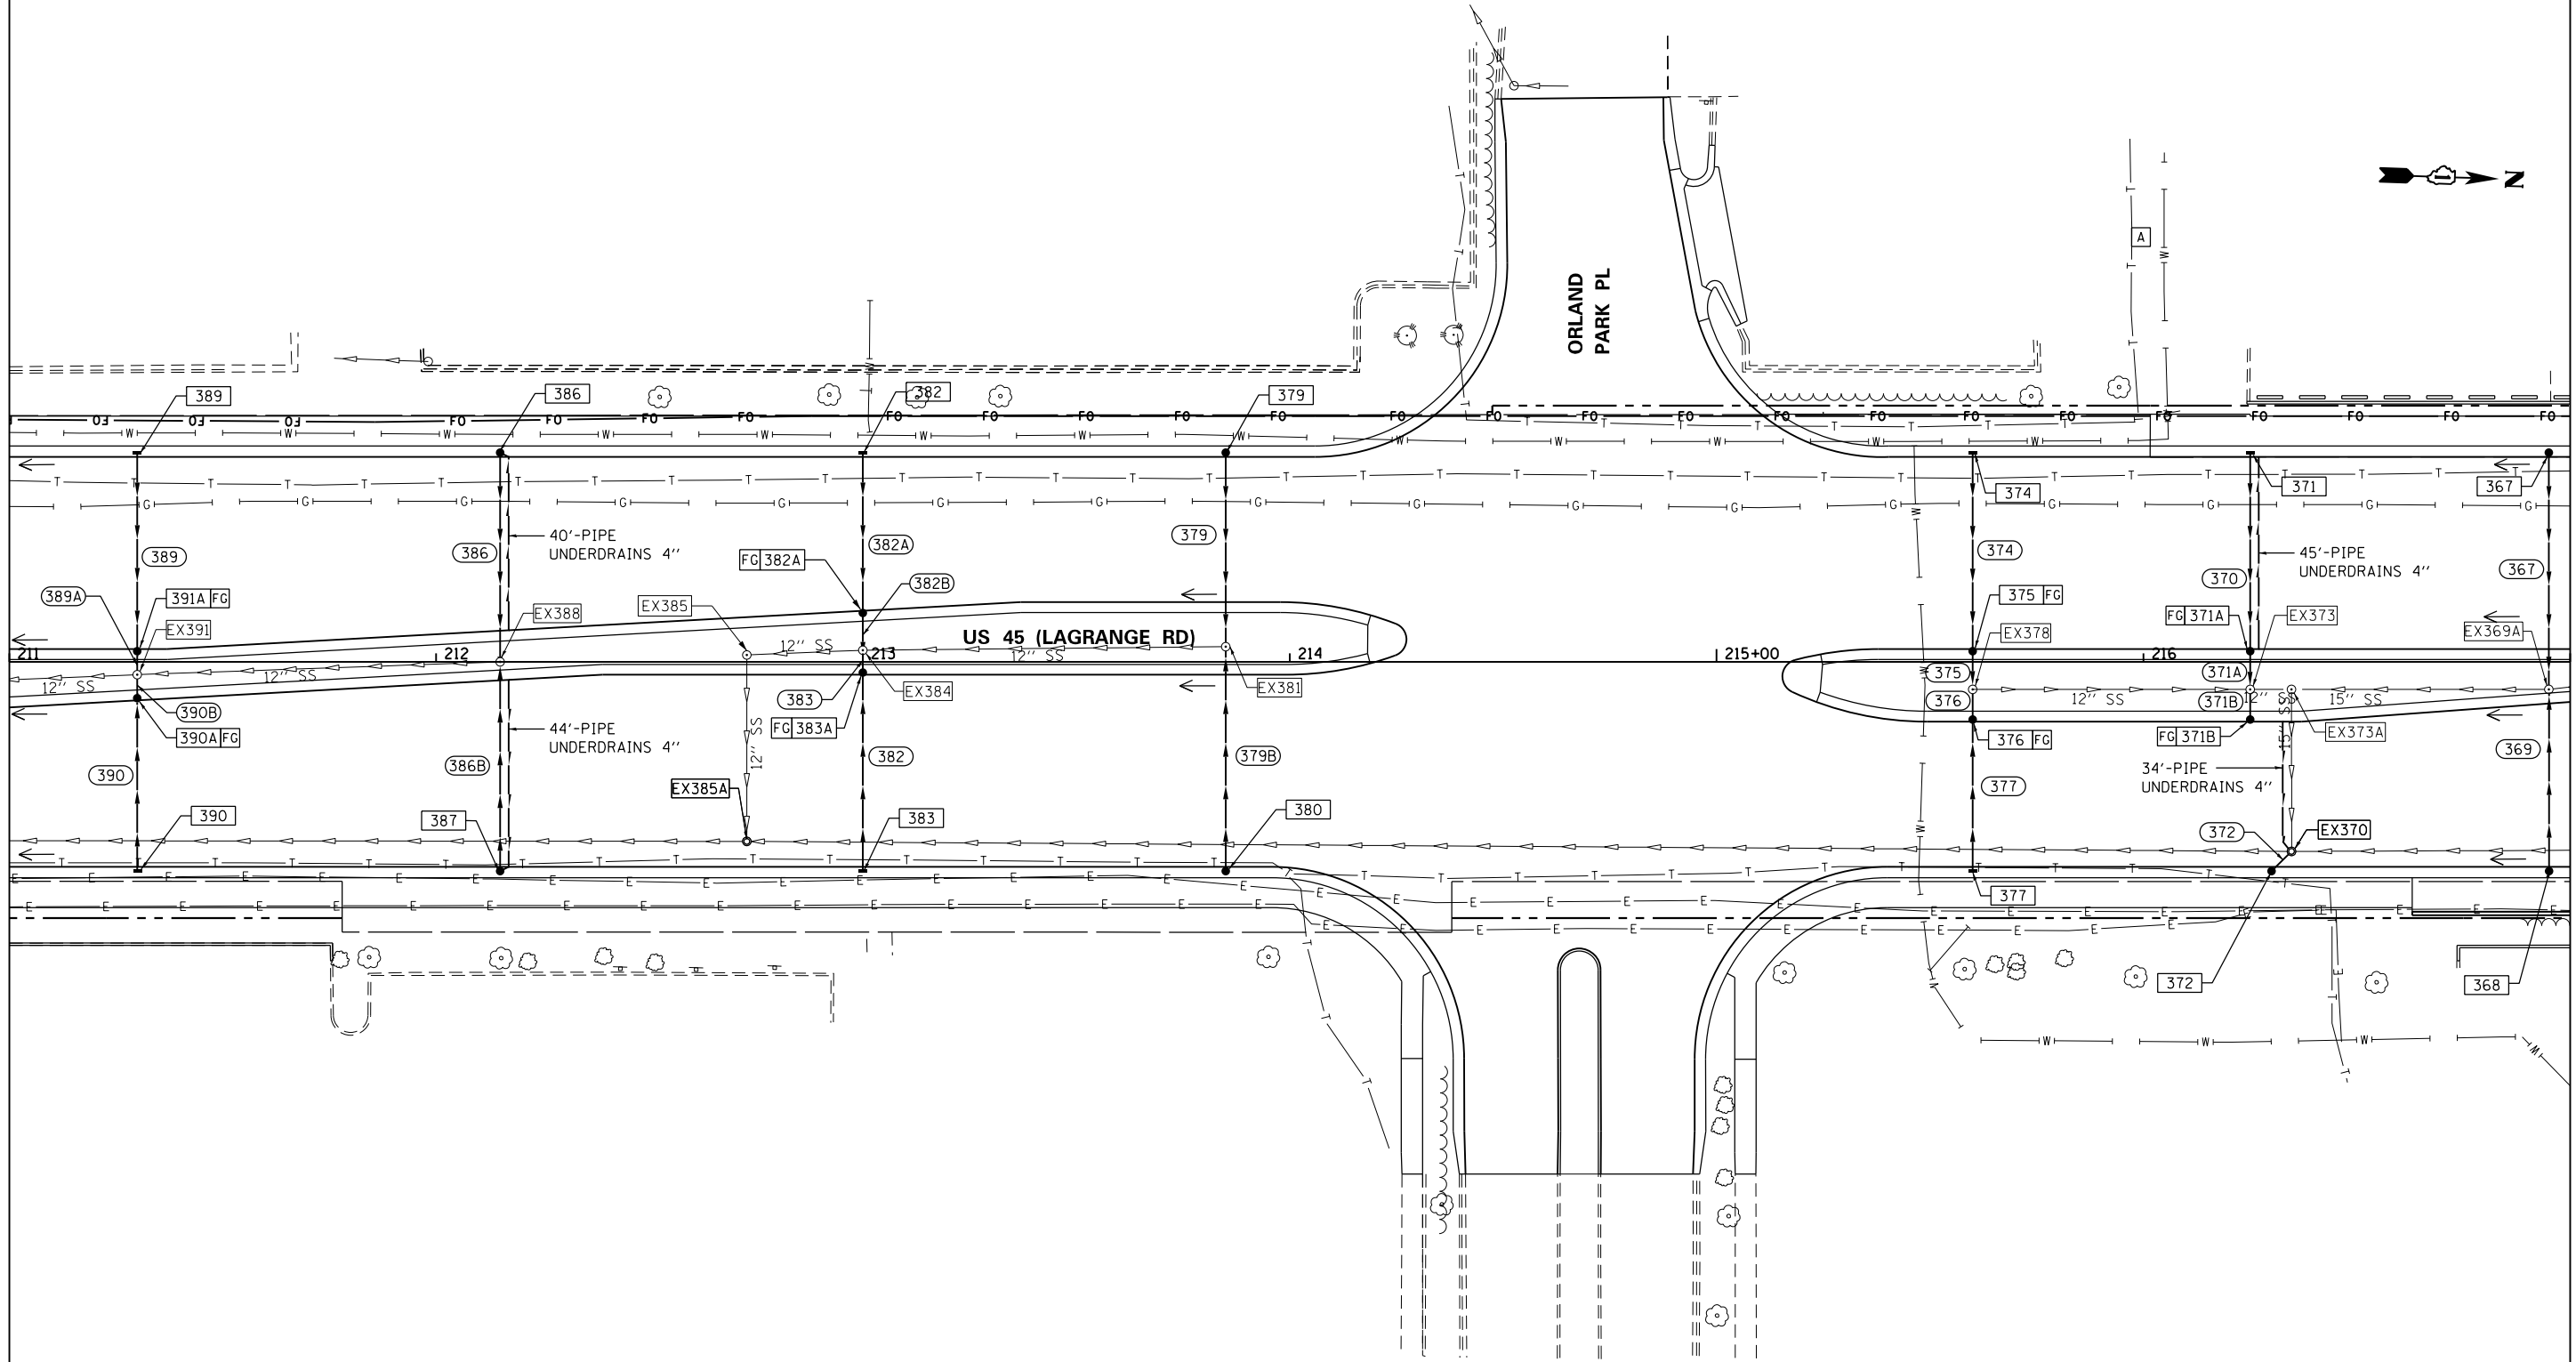

MATCH LINE STA. 217+00.00
 SEE DRAWING DU-36



- NOTES:
- SEE DRAWING DN-01 FOR DRAINAGE LEGEND AND NOTES.
 - SEE DRAWINGS DS-01 THROUGH DS-09 FOR STRUCTURE AND PIPE INFORMATION.

FILE NAME = D160M61-SHT-DRAINPR07.dgn	USER NAME = Frank_Stallone	DESIGNED - EJD	REVISED -
		DRAWN - EJD	REVISED -
	PLOT SCALE = 48.0000' / in.	CHECKED - JWM	REVISED -
SHT.PLAN	PLOT DATE = 3/15/2013	DATE - 03/13/2013	REVISED -

**STATE OF ILLINOIS
 DEPARTMENT OF TRANSPORTATION**

PROPOSED DRAINAGE PLAN - US 55 (LAGRANGE ROAD)

SCALE: 1"=20' SHEET 7 OF 17 SHEETS STA. 211+00.00 TO STA. 217+00.00

F.A.P. RTE.	SECTION	COUNTY	TOTAL SHEETS	SHEET NO.
330	103R-4	COOK	877	193
DU-35			CONTRACT NO. 60M61	
ILLINOIS FED. AID PROJECT				