
 


SEE DRAWING DU-39  
 MATCH LINE STA. 240+00.00

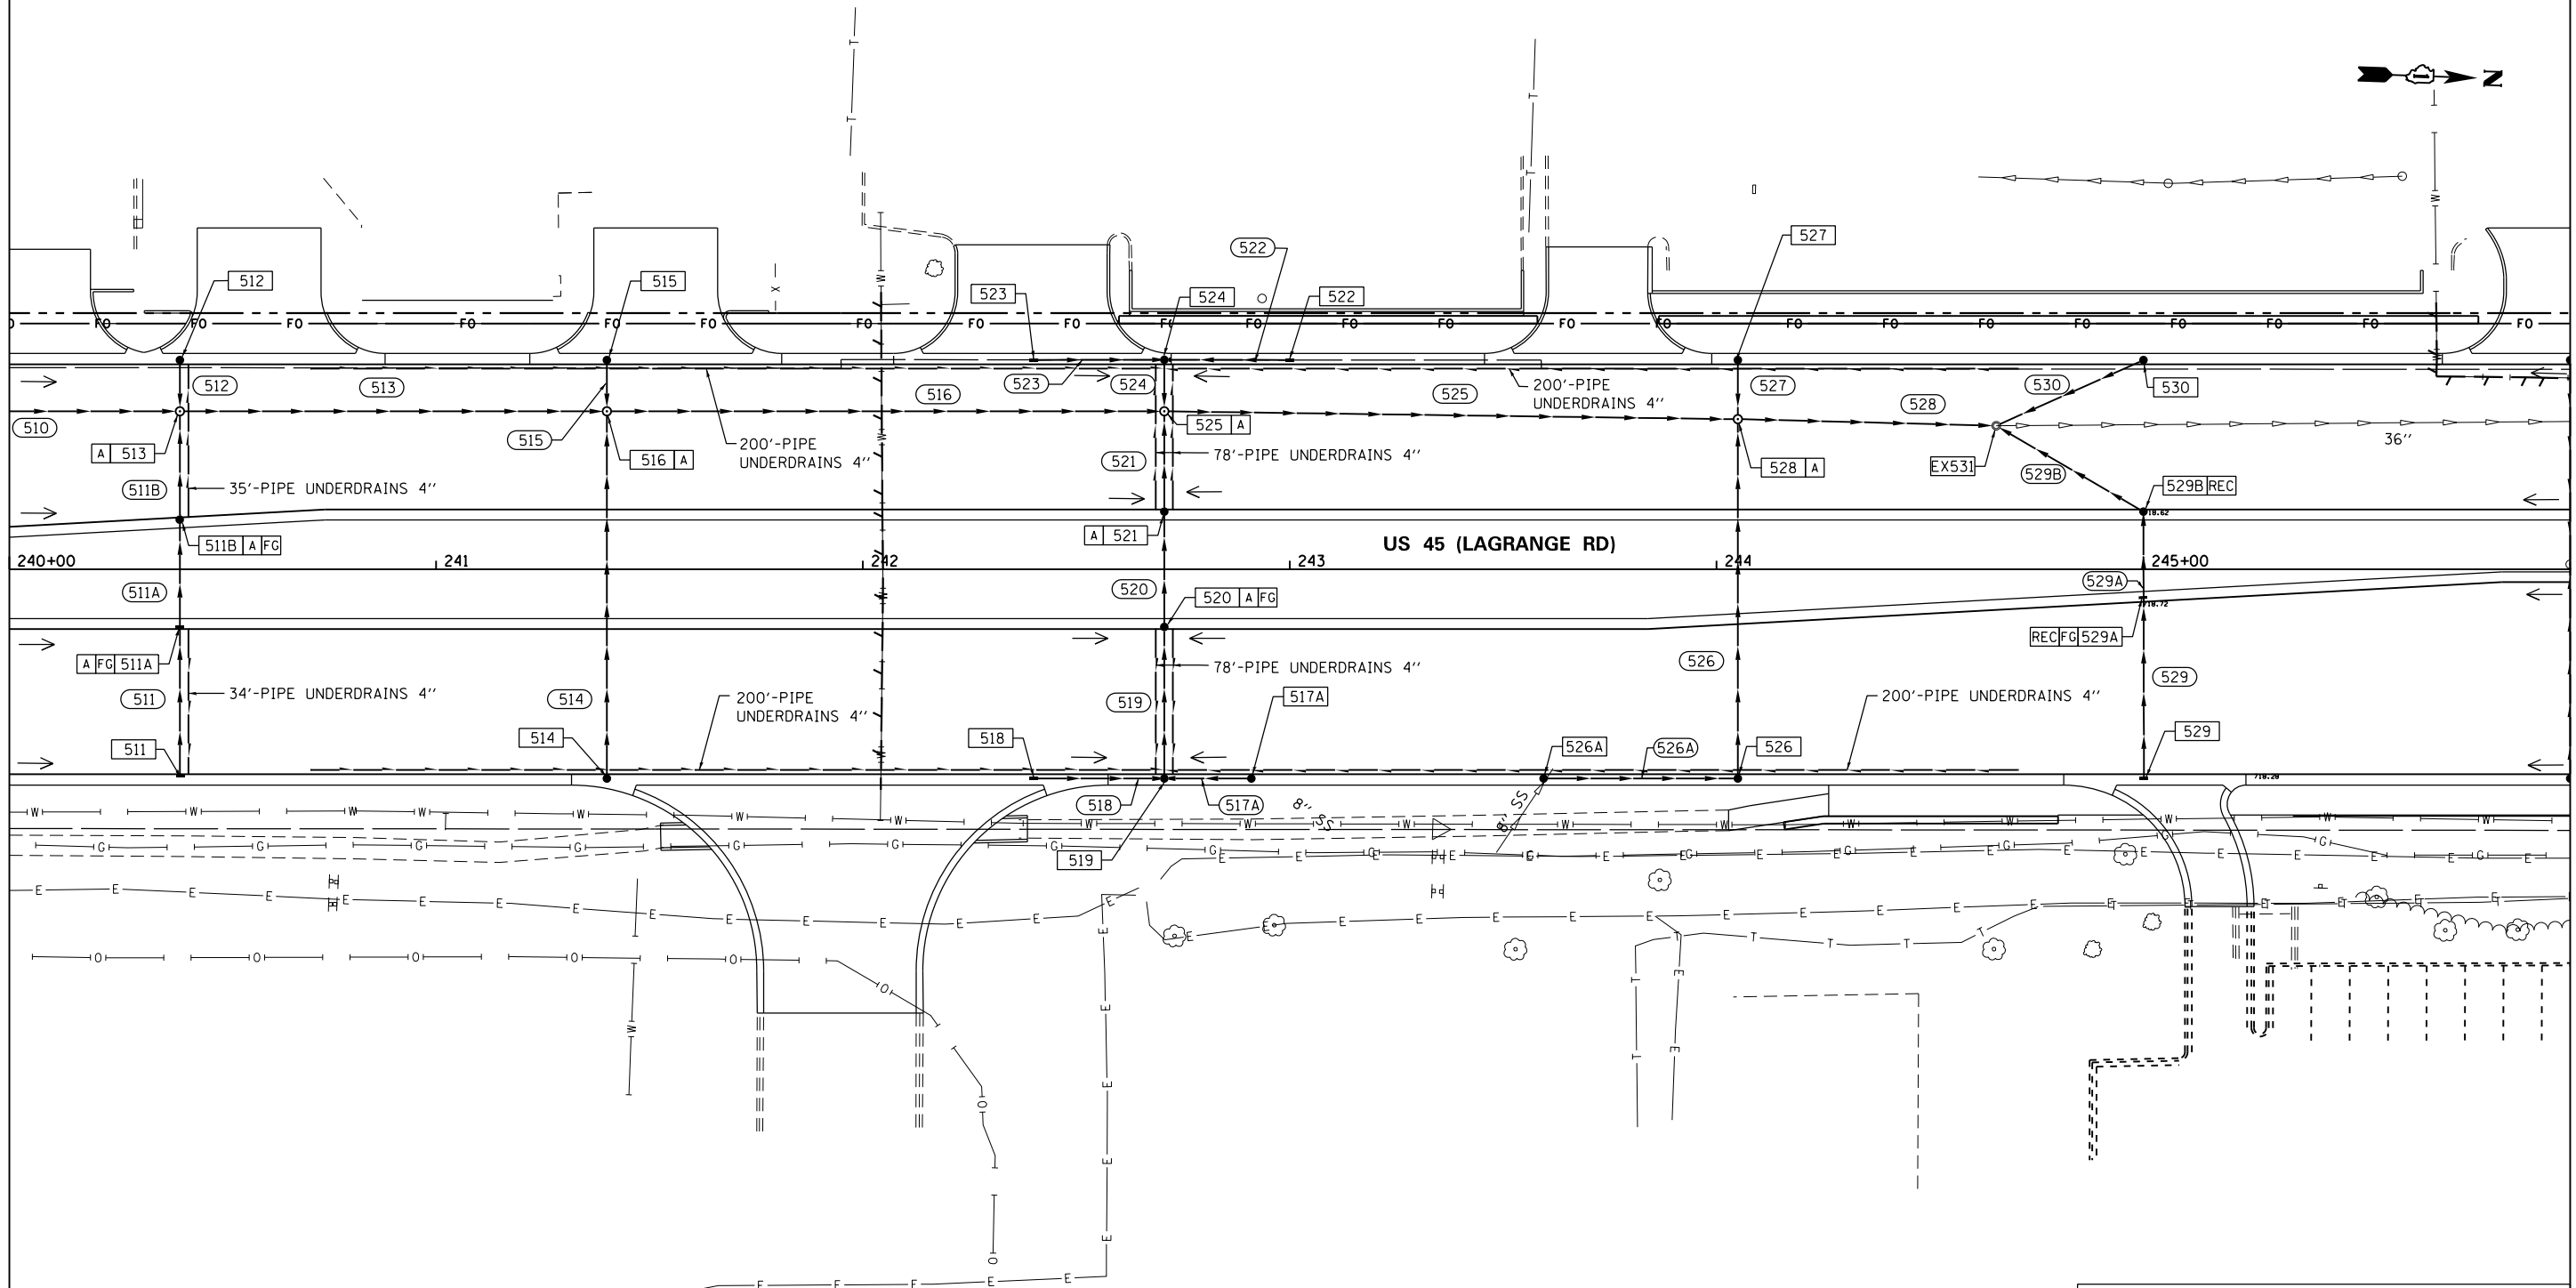

MATCH LINE STA. 246+00.00  
 SEE DRAWING DU-41



NOTES:  
 1. SEE DRAWING DN-01 FOR DRAINAGE LEGEND AND NOTES.  
 2. SEE DRAWINGS DS-01 THROUGH DS-09 FOR STRUCTURE AND PIPE INFORMATION.

FILE NAME = D160M61-SHT-DRAINPR12.dgn	USER NAME = Frank.Stallone	DESIGNED - EJD	REVISED -
SHT.PLAN	PLOT SCALE = 40.0000' / in.	DRAWN - EJD	REVISED -
	PLOT DATE = 3/15/2013	CHECKED - JWM	REVISED -
		DATE - 03/13/2013	REVISED -

**STATE OF ILLINOIS  
 DEPARTMENT OF TRANSPORTATION**

**PROPOSED DRAINAGE PLAN - US 45 (LAGRANGE ROAD)**  
 SCALE: 1"=20' SHEET 12 OF 17 SHEETS STA. 240+00.00 TO STA. 246+00.00

F.A.P. RTE.	SECTION	COUNTY	TOTAL SHEETS	SHEET NO.
330	103R-4	COOK	877	198
<b>DU-40</b>			<b>CONTRACT NO. 60M61</b>	
ILLINOIS FED. AID PROJECT				