
 


SEE DRAWING DU-44
 MATCH LINE STA. 270+00.00

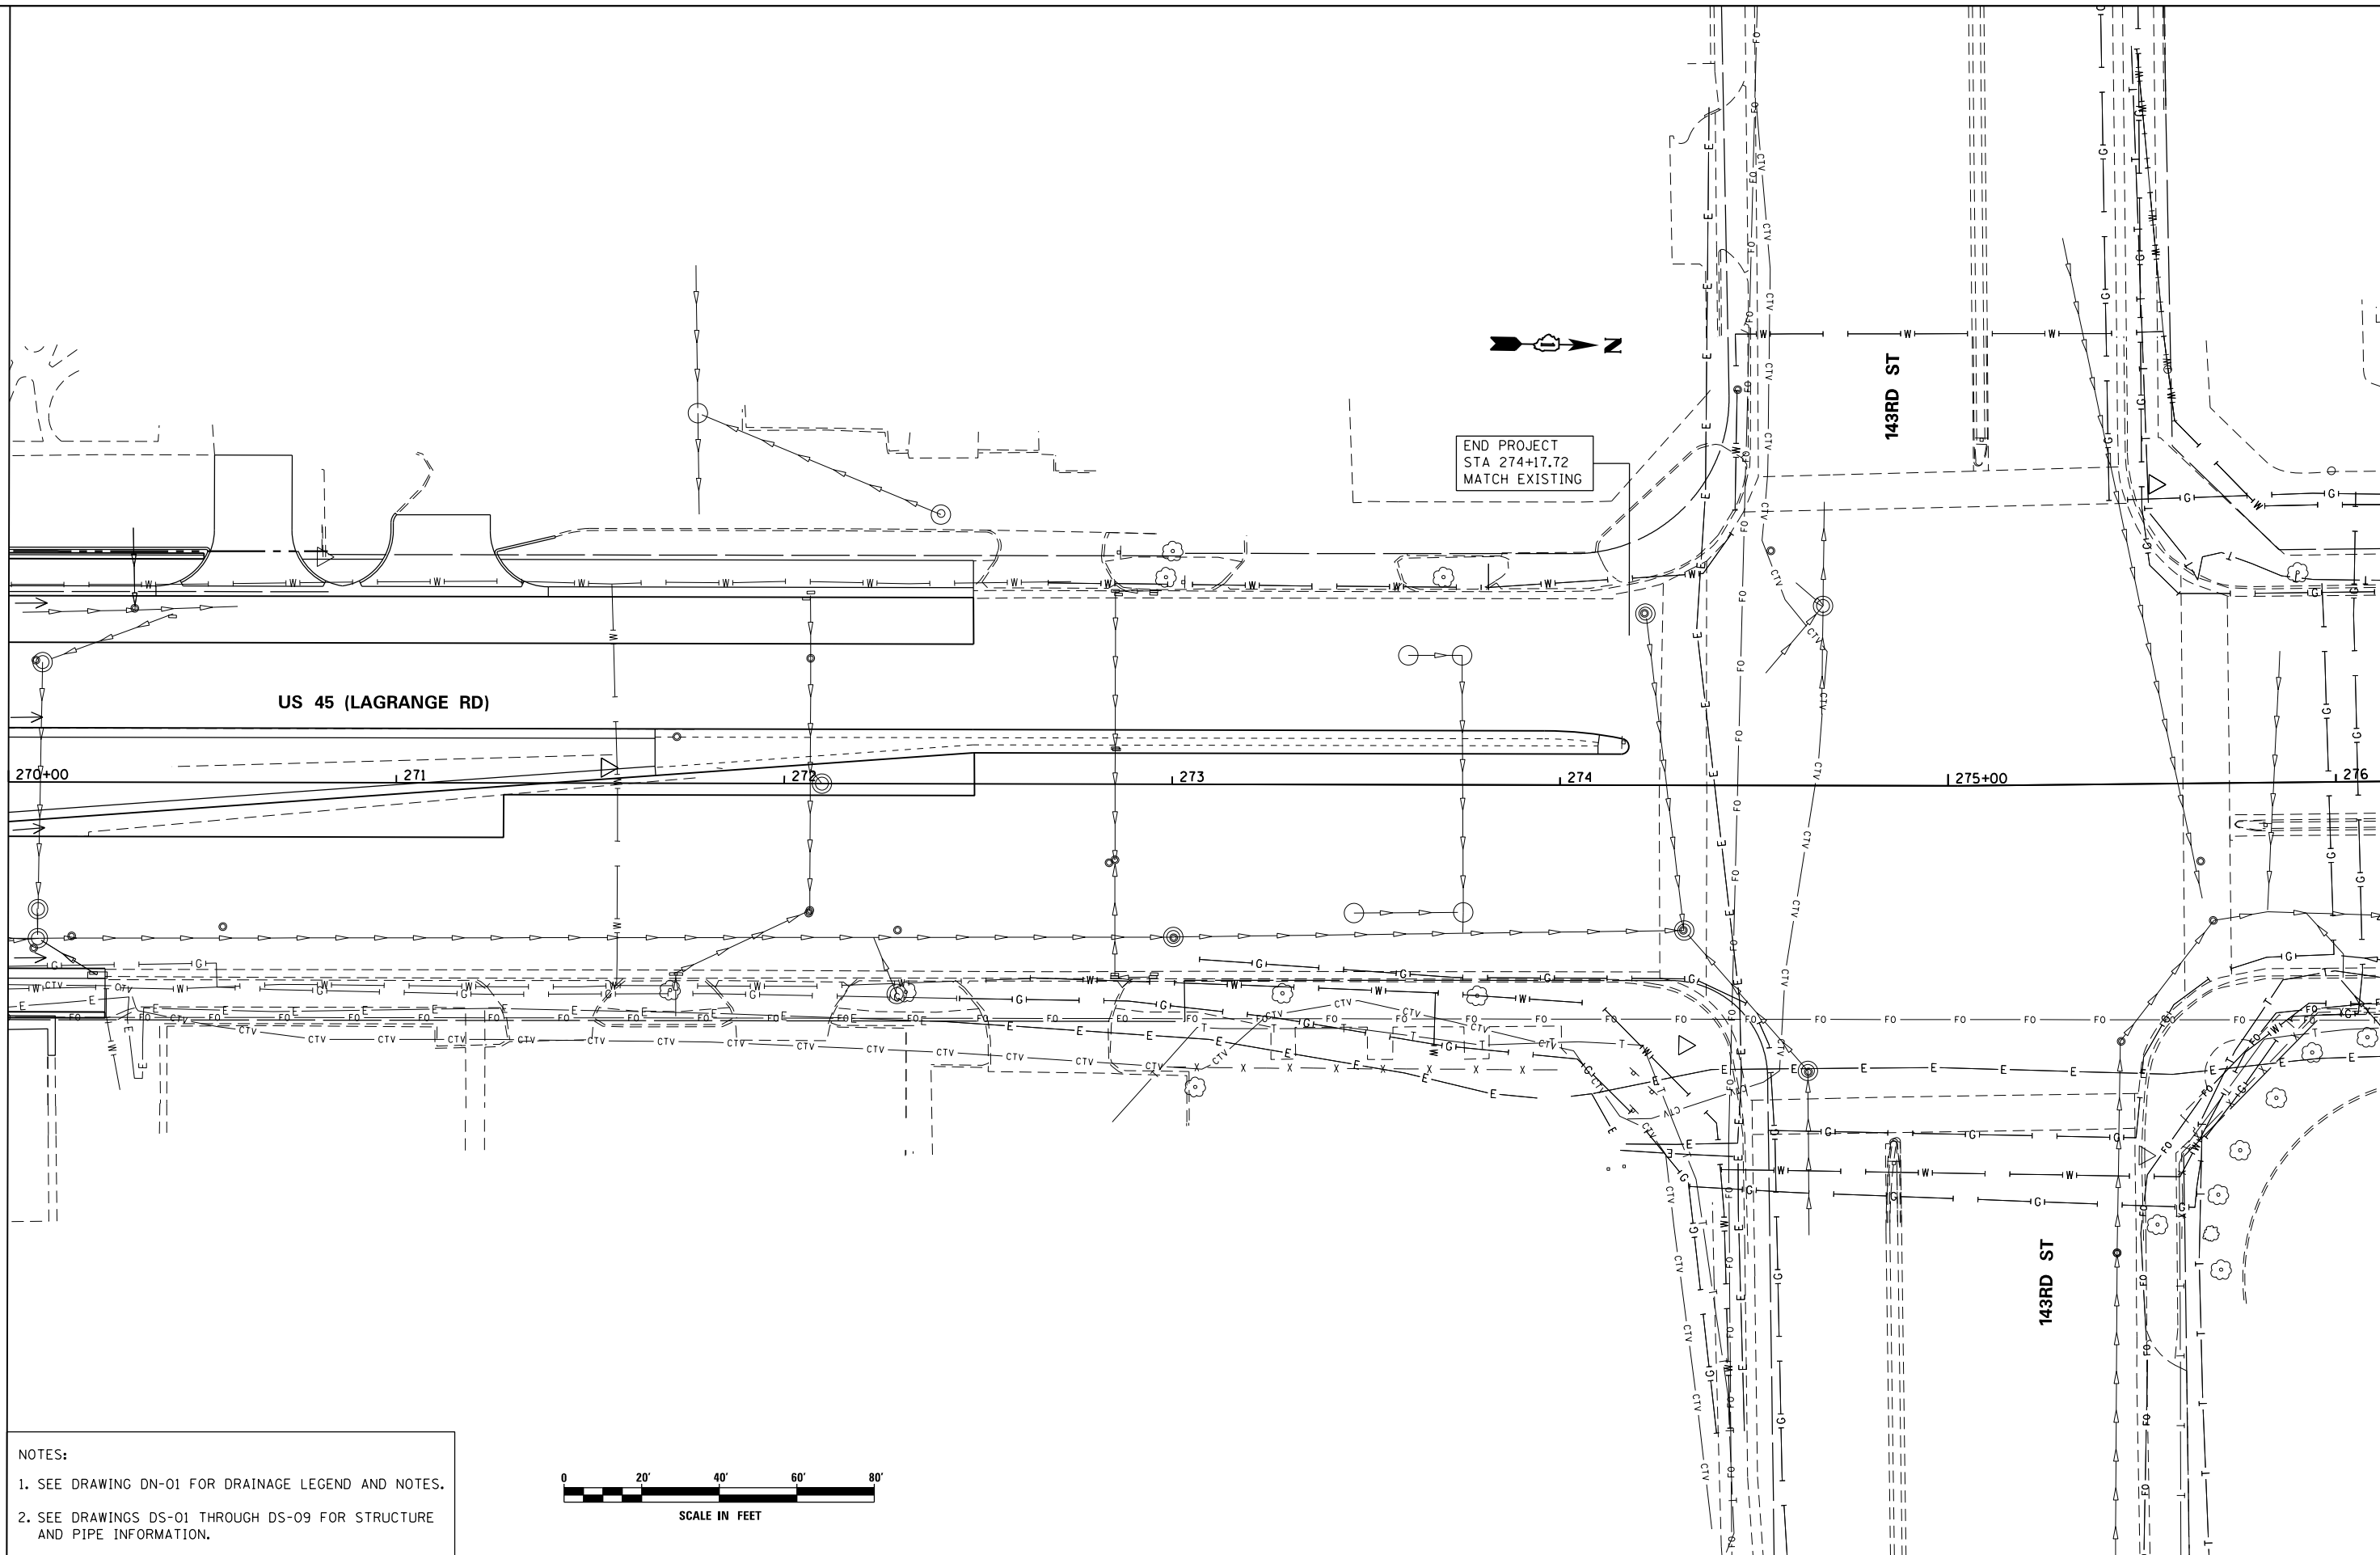

- NOTES:
- SEE DRAWING DN-01 FOR DRAINAGE LEGEND AND NOTES.
 - SEE DRAWINGS DS-01 THROUGH DS-09 FOR STRUCTURE AND PIPE INFORMATION.



FILE NAME = D160M61-SHT-DRAINPR17.dgn	USER NAME = Frank_Stallone	DESIGNED - EJD	REVISED -
SHT_PLAN	PLOT SCALE = 48.0000' / in.	DRAWN - EJD	REVISED -
	PLOT DATE = 3/15/2013	CHECKED - JWM	REVISED -
		DATE - 03/13/2013	REVISED -

**STATE OF ILLINOIS
 DEPARTMENT OF TRANSPORTATION**

PROPOSED DRAINAGE PLAN - US 55 (LAGRANGE ROAD)

SCALE: 1"=20' SHEET 17 OF 17 SHEETS STA. 270+00.00 TO STA. END

F.A.P. RTE. 330	SECTION 103R-4	COUNTY COOK	TOTAL SHEETS 877	SHEET NO. 203
DU-45		CONTRACT NO. 60M61		
ILLINOIS FED. AID PROJECT				