
 


PROJECT LIMITS
STA 499+74.21
MATCH EXISTING

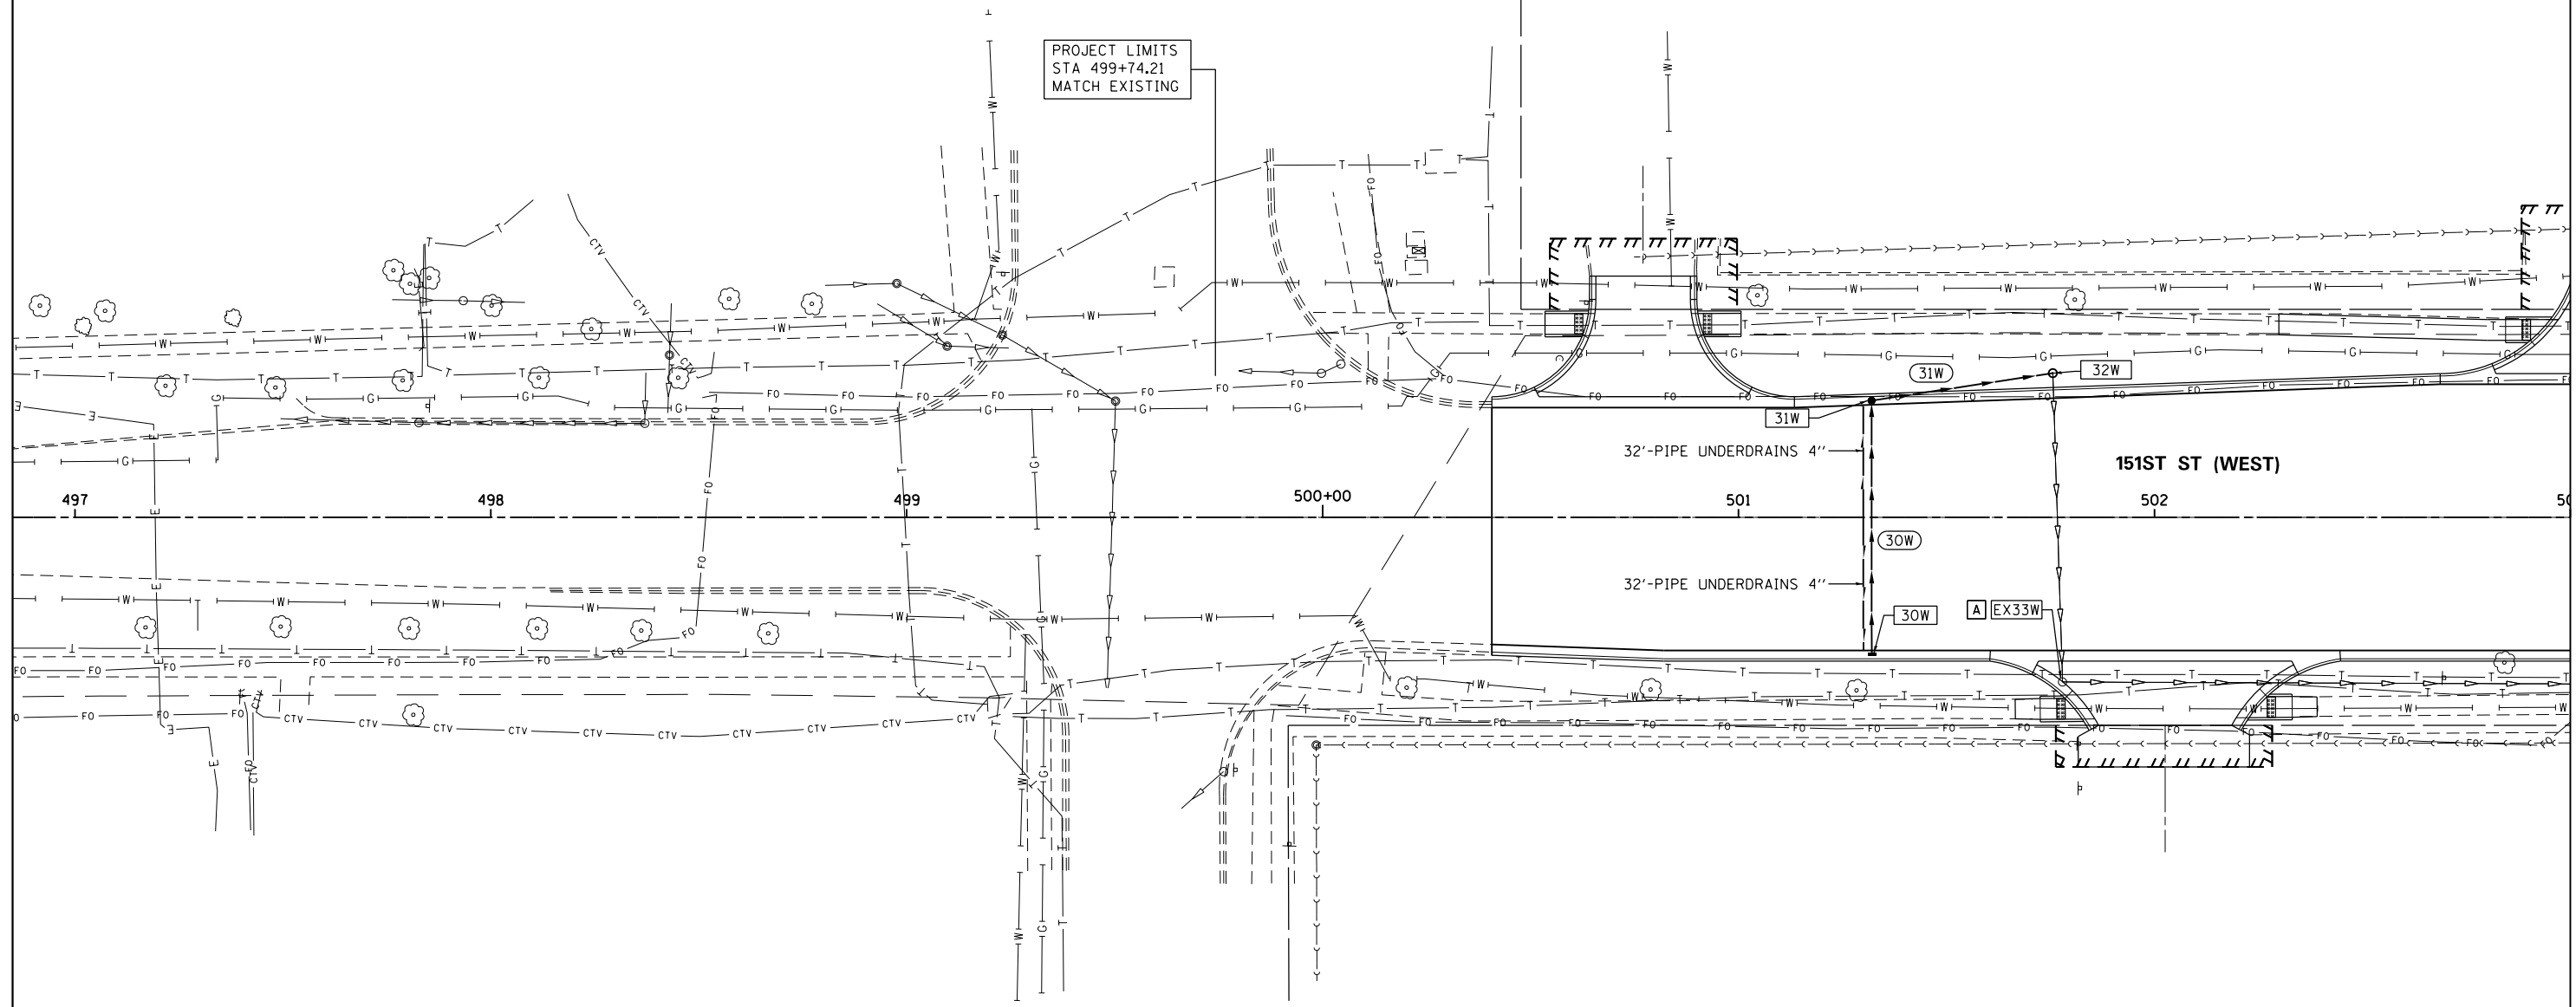

MATCH LINE STA: 503+00.00
SEE DRAWING DU-49



- NOTES:
- SEE DRAWING DN-01 FOR DRAINAGE LEGEND AND NOTES.
 - SEE DRAWINGS DS-01 THROUGH DS-09 FOR STRUCTURE AND PIPE INFORMATION.

URS
100 S. WACKER DR.
SUITE 600
CHICAGO, IL 60606
TEL (312) 939-1000
FAX (312) 939-4198

FILE NAME = D160M61-SHT-DRAINPR20.dgn	USER NAME = Frank_Stallone	DESIGNED - EJD	REVISED -
SHT.PLAN	PLOT SCALE = 40.0000' / in.	DRAWN - EJD	REVISED -
	PLOT DATE = 3/15/2013	CHECKED - JWM	REVISED -
		DATE - 03/13/2013	REVISED -

STATE OF ILLINOIS
DEPARTMENT OF TRANSPORTATION

PROPOSED DRAINAGE PLAN - 151ST STREET
SCALE: 1"=20' SHEET 1 OF 3 SHEETS STA. BEGIN TO STA. 503+00.00

F.A.P. RTE.	SECTION	COUNTY	TOTAL SHEETS	SHEET NO.
330	103R-4	COOK	877	206
DU-48			CONTRACT NO. 60M61	
ILLINOIS FED. AID PROJECT				