 


- NOTES:
- SEE DRAWING DN-01 FOR DRAINAGE LEGEND AND NOTES.
  - SEE DRAWINGS DS-01 THROUGH DS-09 FOR STRUCTURE AND PIPE INFORMATION.



FILE NAME = D160M61-SHT-DRAINPR25.dgn  
 SHT.PLAN

USER NAME = Frank.Stallone  
 PLOT SCALE = 48.0000' / in.  
 PLOT DATE = 3/15/2013

DESIGNED - EJD  
 DRAWN - EJD  
 CHECKED - JWM  
 DATE - 03/13/2013


REVISED -  
 REVISED -  
 REVISED -  
 REVISED -

STATE OF ILLINOIS  
 DEPARTMENT OF TRANSPORTATION

PROPOSED DRAINAGE PLAN - 147TH STREET

SCALE: 1"=20' SHEET 1 OF 2 SHEETS STA. BEGIN TO STA. 230+00.00

F.A.P. RTE.	SECTION	COUNTY	TOTAL SHEETS	SHEET NO.
330	103R-4	COOK	877	211
<b>DU-53</b>			CONTRACT NO. 60M61	
ILLINOIS FED. AID PROJECT				

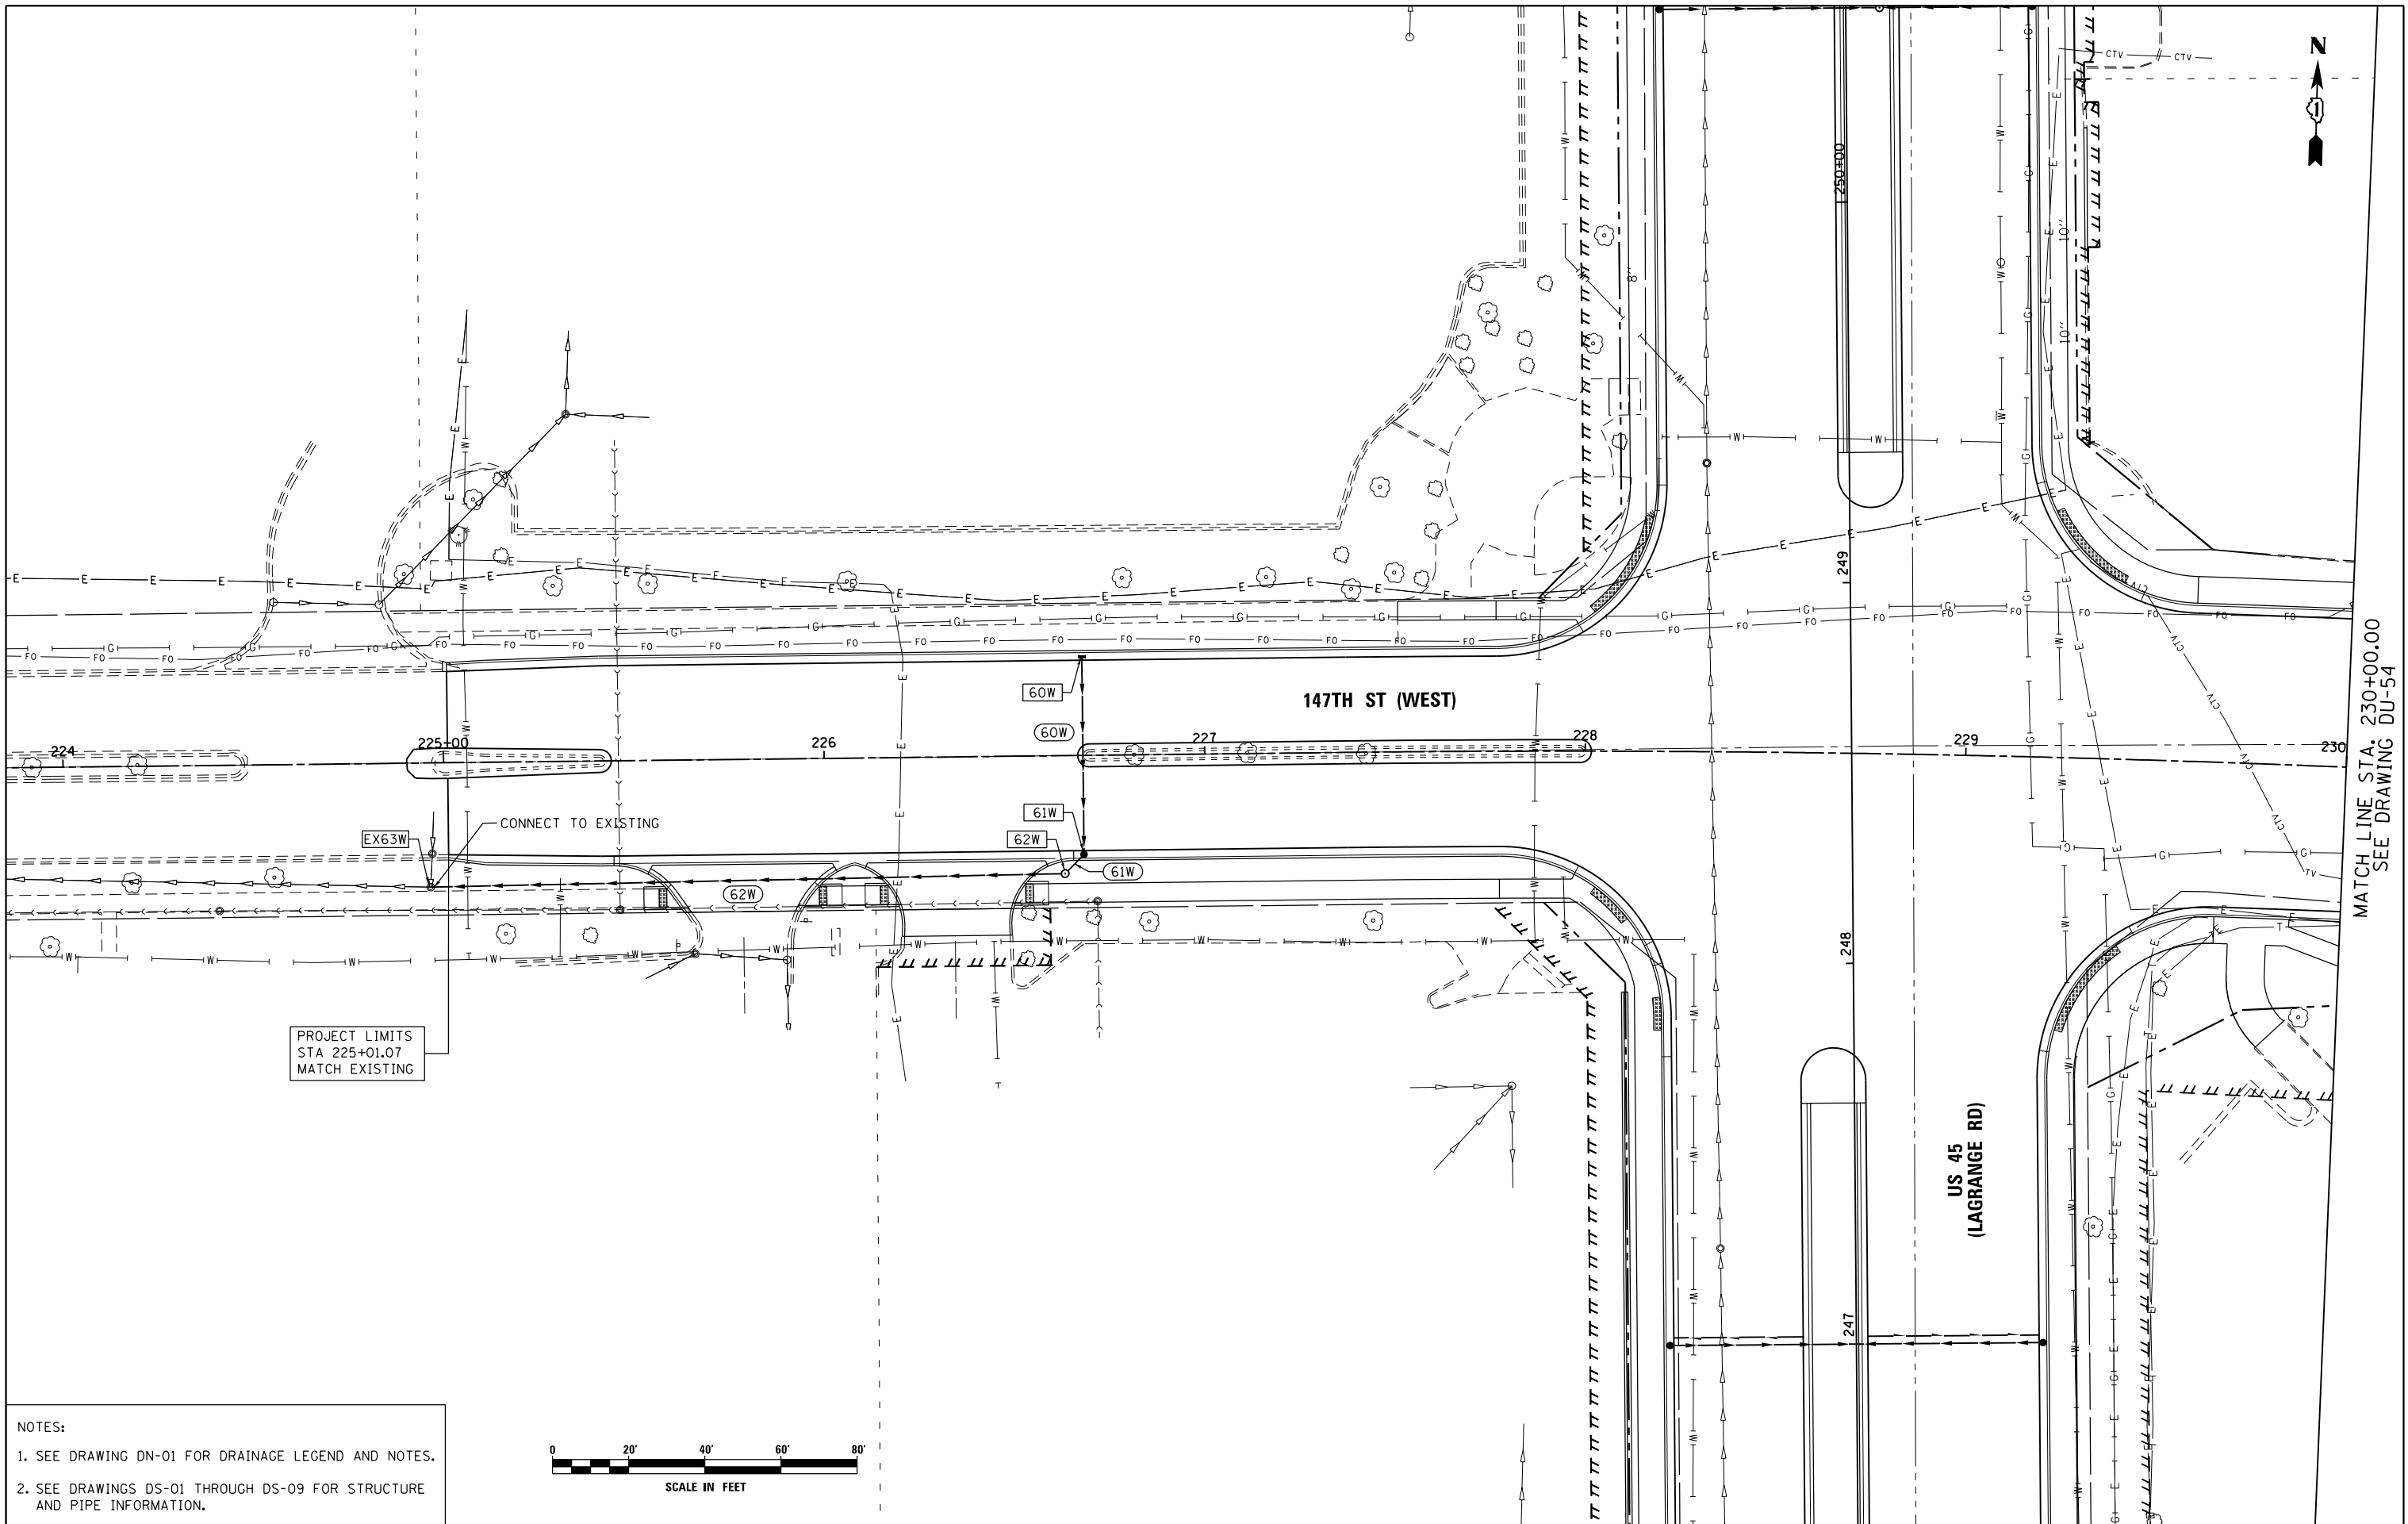

MATCH LINE STA: 230+00.00  
 SEE DRAWING DU-54