

PLAN	SURVEYED	DATE
	PLOTTED	
	NOTE BOOK	
	NO.	
	ALIGNED	
	CHECKED	
	FILE NAME	
	NO.	



PROFILE	SURVEYED	DATE
	PLOTTED	
	NOTE BOOK	
	NO.	
	GRADES CHECKED	
	STRUCTURE	
	NOTATIONS CHECKED	
	NO.	

100 S. WACKER DR.
SUITE 500
CHICAGO, IL 60606
TEL (312) 329-4000
FAX (312) 329-4098

URS

SEE DRAWING WT-02
MATCH LINE STA. 187+00.00

MATCH LINE STA. 193+00.00
SEE DRAWING WT-04

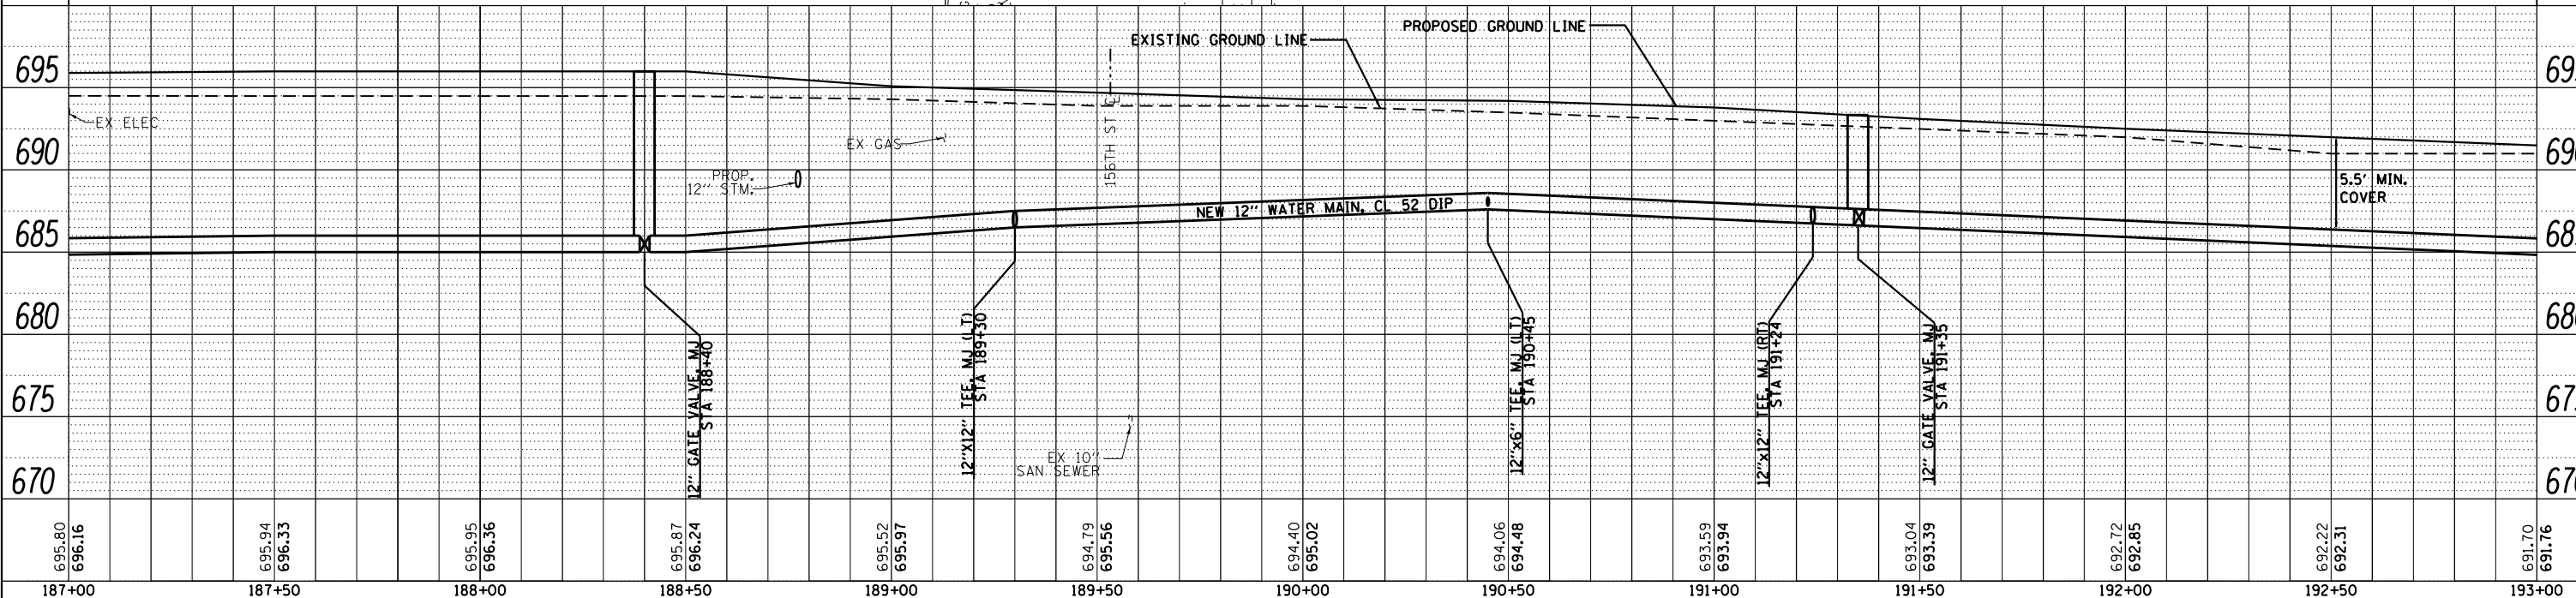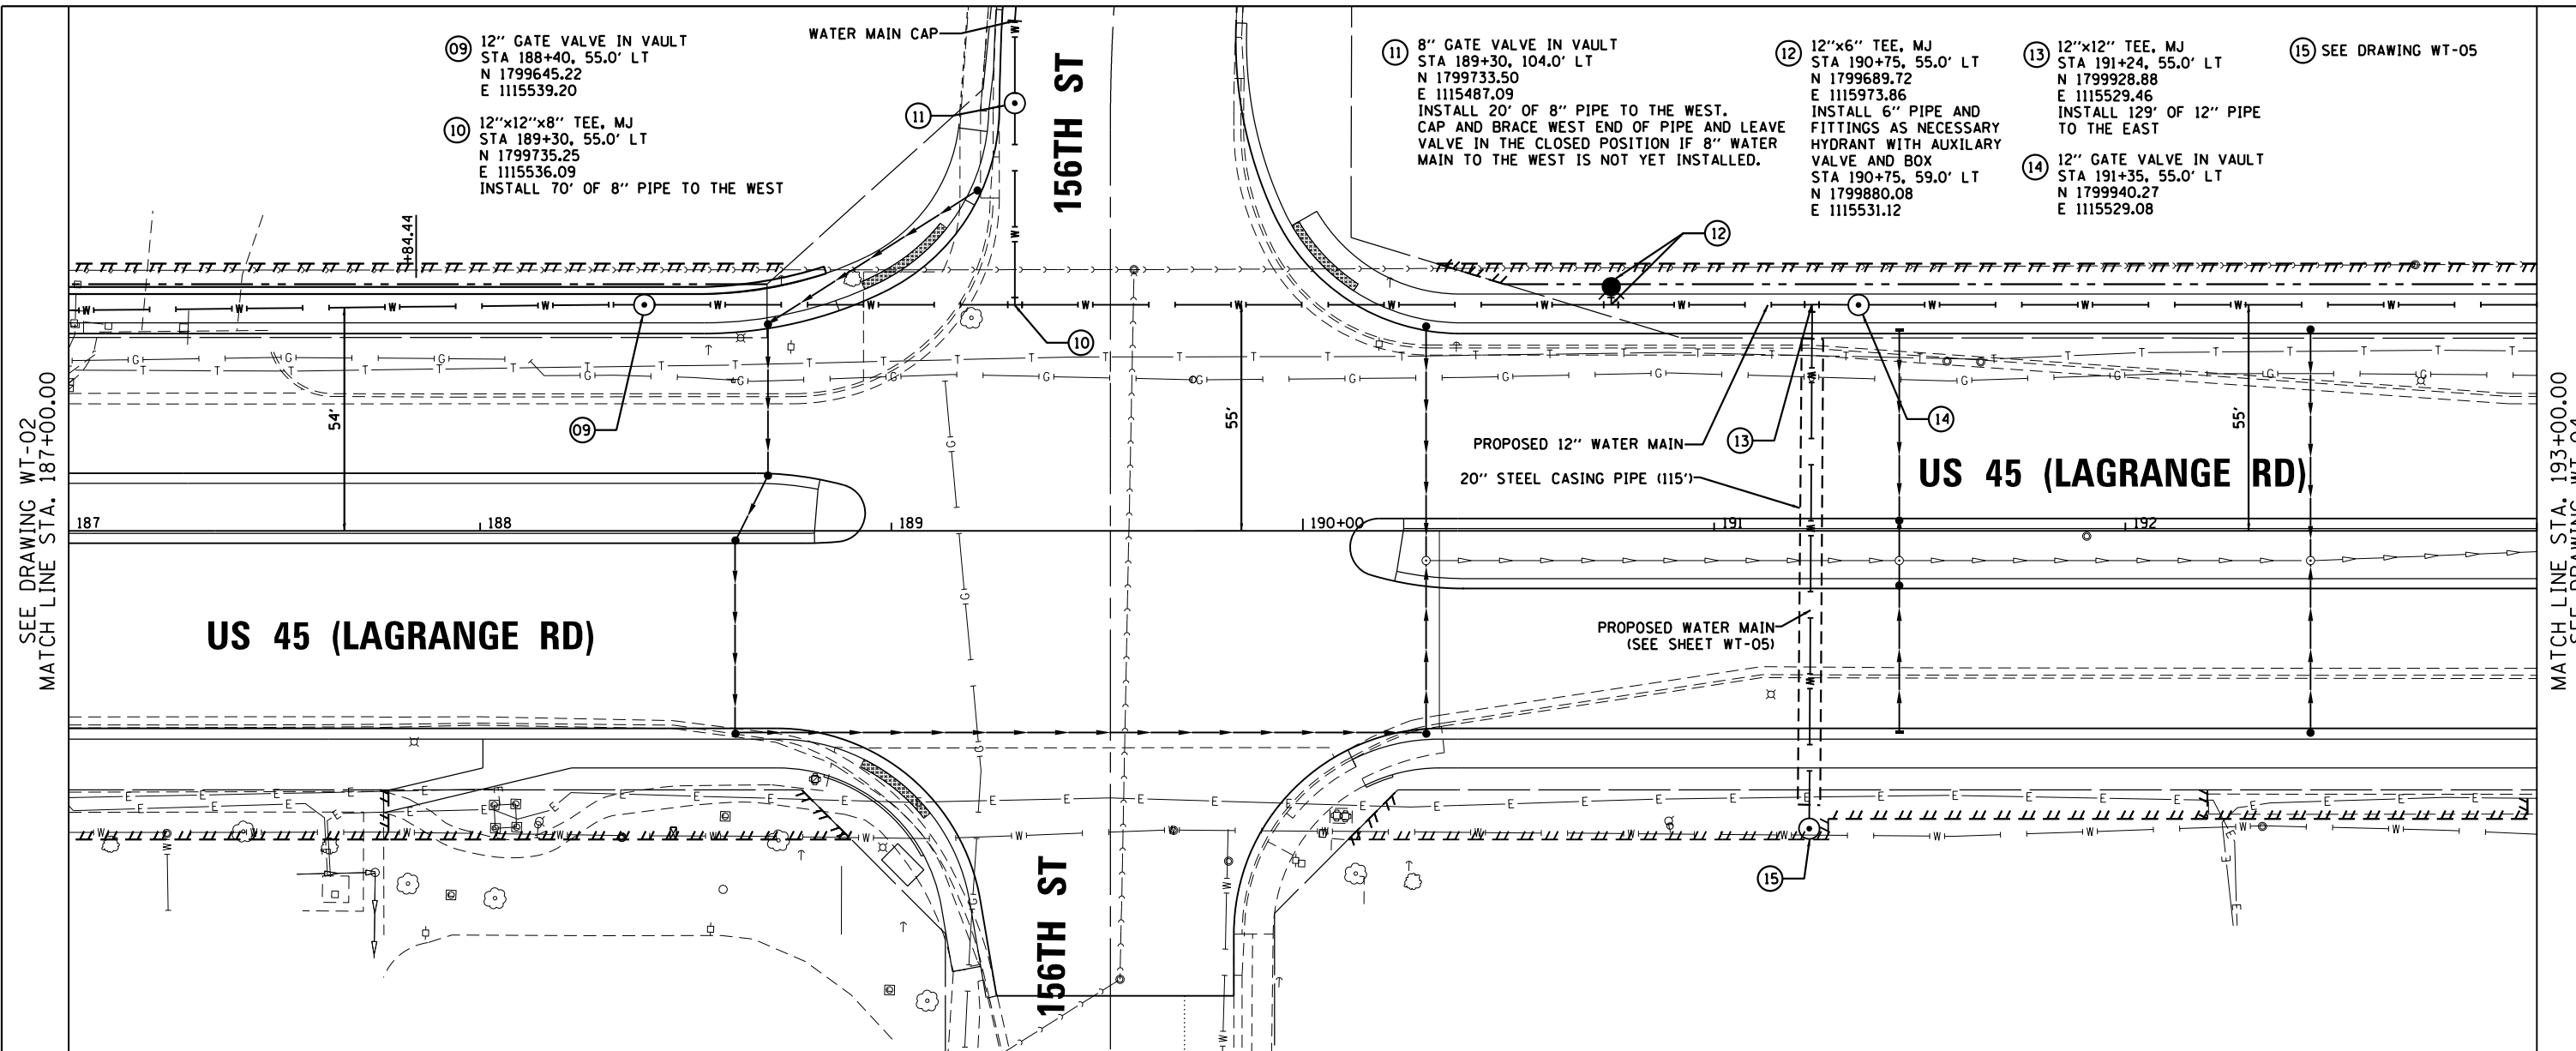

FILE NAME =	USER NAME = Anthony.Plutz	DESIGNED - DF	REVISED -	STATE OF ILLINOIS DEPARTMENT OF TRANSPORTATION	WATER MAIN - PROPOSED PLAN AND PROFILE US 45 (LAGRANGE ROAD)	F.A.P. RTE.	SECTION	COUNTY	TOTAL SHEETS	SHEET NO.
D160M61-SHT-WATER03.dgn		DRAWN - DF	REVISED -			330	103R-4	COOK	877	234
PLOT SCALE = 40.0000' / in.		CHECKED - TDW	REVISED -			WT-03		CONTRACT NO. 60M61		
PLOT DATE = 3/14/2013		DATE - 03/13/2013	REVISED -			SCALE: 1"=20'H; 1"=5'V		SHEET 3 OF 21 SHEETS		STA. 187+00.00 TO STA. 193+00.00

ILLINOIS FED. AID PROJECT