

PLAN	SURVEYED	DATE
	PLOTTED	BY
	NOTE BOOK	
	NO.	
	ALIGNED	
	CHECKED	
	FILE NAME	
	NO.	

PROFILE	SURVEYED	DATE
	PLOTTED	BY
	NOTE BOOK	
	NO.	
	GRADES CHECKED	
	STRUCTURE	
	NOTATIS	
	CPAD	



100 S. WACKER DR.
SUITE 500
CHICAGO, IL 60606
TEL (312) 329-4000
FAX (312) 329-4098

URS

SEE DRAWING WT-03
MATCH LINE STA. 193+00.00

MATCH LINE STA. 199+00.00

- ①6 12"x6" TEE, MJ
STA 193+60, 55.0' LT
N 1800164.98
E 1115521.44
INSTALL 6" PIPE AND FITTINGS
AS NECESSARY
HYDRANT WITH AUXILIARY VALVE AND BOX
STA 193+60, 59.0' LT
N 1800164.79
E 1115517.73
- ①7 12"x6" TEE, MJ
STA 197+12, 55.0' LT
N 1800516.67
E 1115509.42
INSTALL 6" PIPE AND FITTINGS AS NECESSARY
HYDRANT WITH AUXILIARY VALVE AND BOX
STA 197+12, 59.0' LT
N 1800516.59
E 1115505.75
- ①8 12"-45° BEND, MJ
STA 197+45, 55.0' LT
N 1800549.37
E 1115508.32
- ①9 12" GATE VALVE IN VAULT
STA 197+49, 59.0' LT
N 1800553.53
E 1115504.25
- ②0 CONNECTION TO EXISTING 12" WATER MAIN
STA 197+60, 68.5' LT
N 1800563.56
E 1115494.44

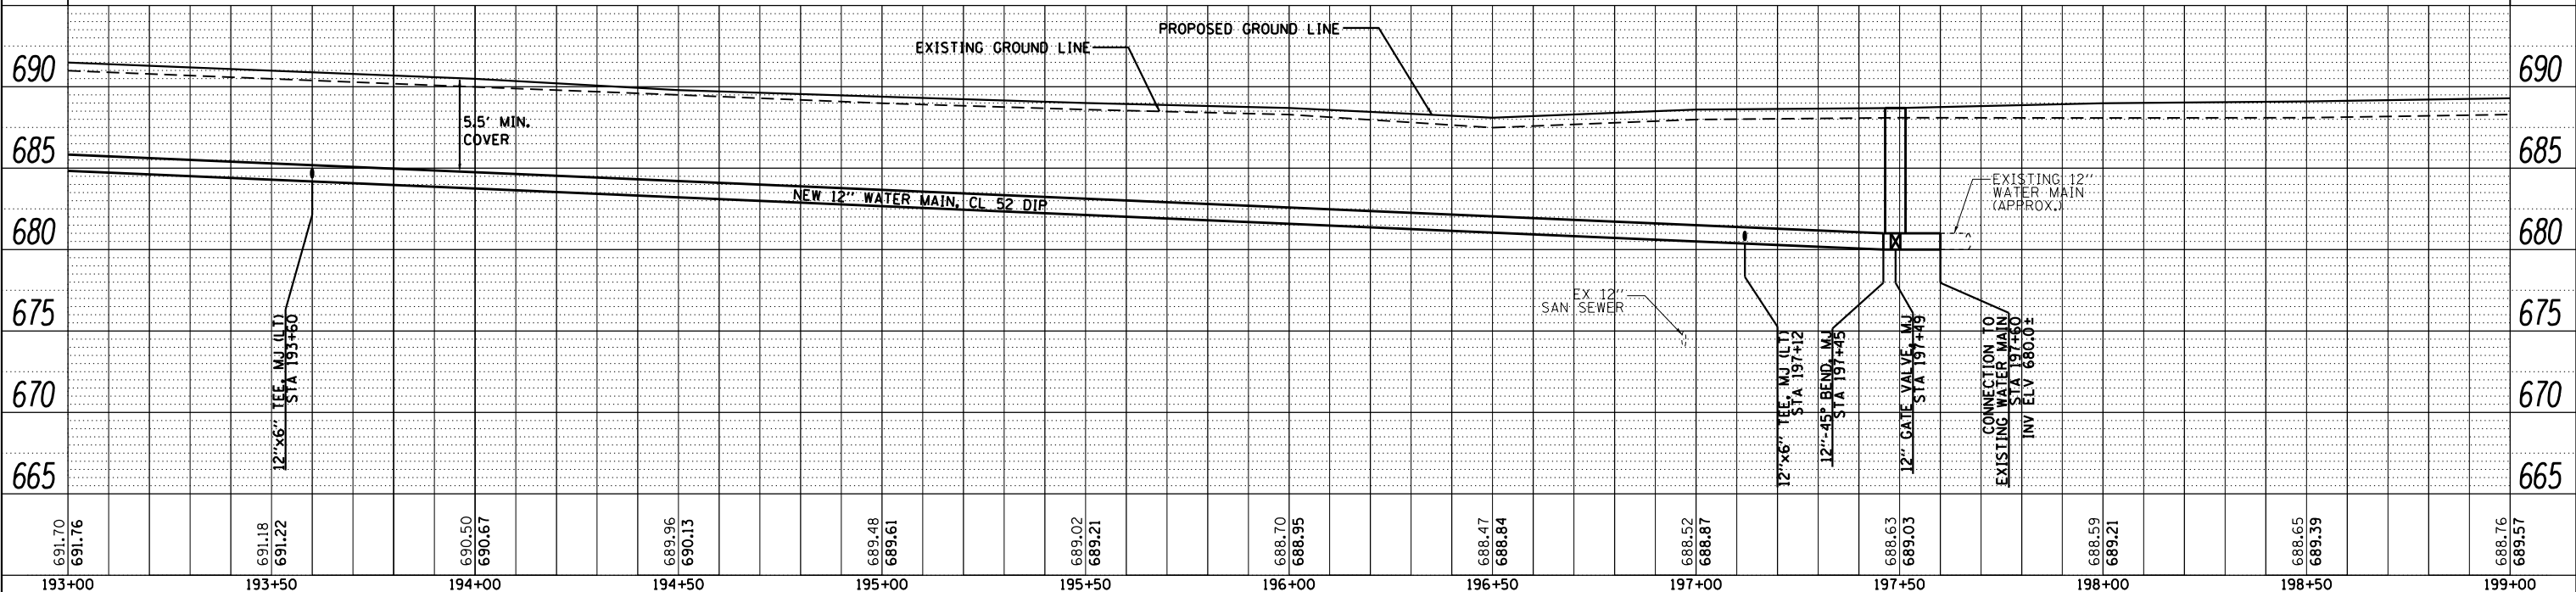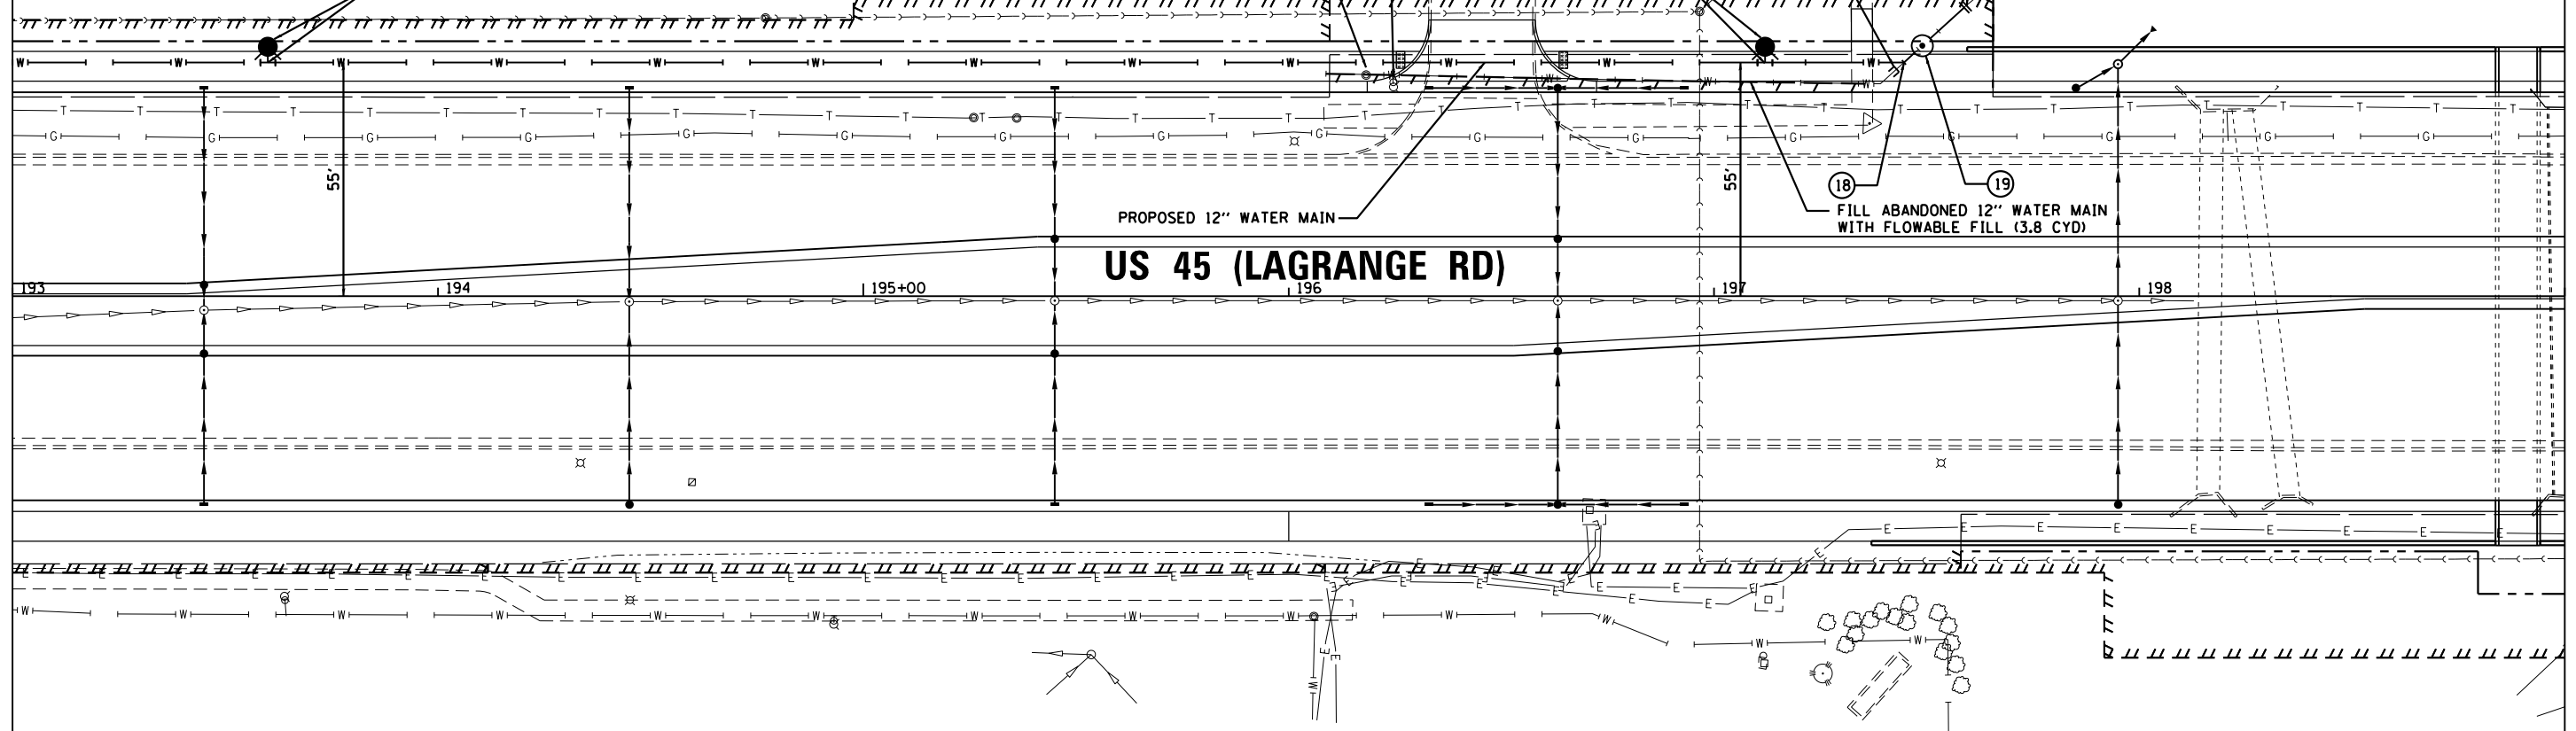

FILE NAME =	USER NAME = Anthony.Plutz	DESIGNED - DF	REVISED -	STATE OF ILLINOIS DEPARTMENT OF TRANSPORTATION	WATER MAIN - PROPOSED PLAN AND PROFILE US 45 (LAGRANGE ROAD)	F.A.P. RTE.	SECTION	COUNTY	TOTAL SHEETS	SHEET NO.
D160M61-SHT-WATER04.dgn		DRAWN - DF	REVISED -			330	103R-4	COOK	877	235
PLOT SCALE = 40.0000' / in.		CHECKED - TDW	REVISED -			WT-04		CONTRACT NO. 60M61		
PLOT DATE = 3/14/2013		DATE - 03/13/2013	REVISED -			ILLINOIS FED. AID PROJECT				

SCALE: 1"=20'H; 1"=5' V SHEET 4 OF 21 SHEETS STA. 193+00.00 TO STA. 199+00.00