

PLAN	SURVEYED	DATE
	PLOTTED	BY
	NOTE BOOK	
	NO.	
	ALIGNED	
	CHECKED	
	FILE NAME	

PROFILE	SURVEYED	DATE
	PLOTTED	BY
	NOTE BOOK	
	NO.	
	GRADES CHECKED	
	STRUCTURE	
	NOTATIONS	
	CPAD	

100 S. WACKER DR.
SUITE 500
CHICAGO, IL 60606
TEL (312) 939-4900
FAX (312) 939-4998

URS

22 12"x6" TEE, MJ
STA 223+50, 42.0' RT
N 1803156.49
E 1115516.55
INSTALL 6" PIPE AND FITTINGS AS NECESSARY
HYDRANT WITH AUXILIARY VALVE AND BOX
STA 223+50, 59.0' RT
N 1803157.05
E 1115533.02

23 12"x8" TEE, MJ
STA 225+70, 42.0' RT
N 1803375.86
E 1115509.07
INSTALL 163.5' OF 8" PIPE TO THE EAST
SEE DRAWING WT-19



24 SEE DRAWING WT-19

25 SEE DRAWING WT-19

26 12"x6" TEE, MJ
STA 227+15, 42.0' RT
N 1803521.28
E 1115504.11
INSTALL 6" PIPE AND FITTINGS AS NECESSARY
HYDRANT WITH AUXILIARY VALVE AND BOX
STA 227+15, 59.0' RT
N 1803521.84
E 1115520.79

SEE DRAWING WT-05
MATCH LINE STA. 223+00.00

MATCH LINE STA. 229+00.00
SEE DRAWING WT-07

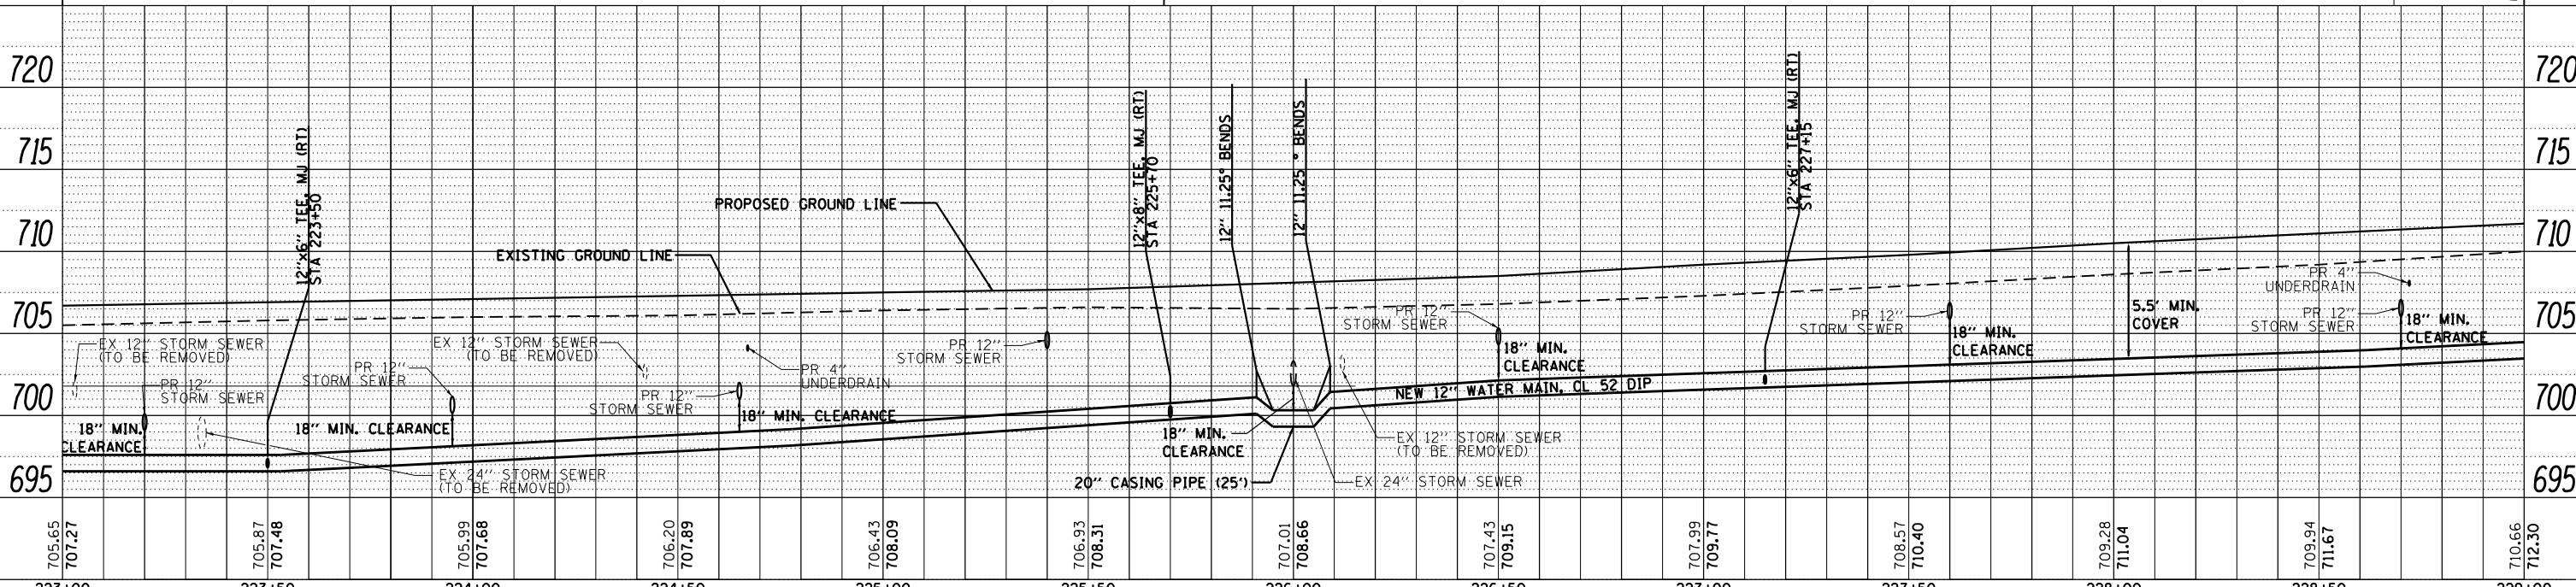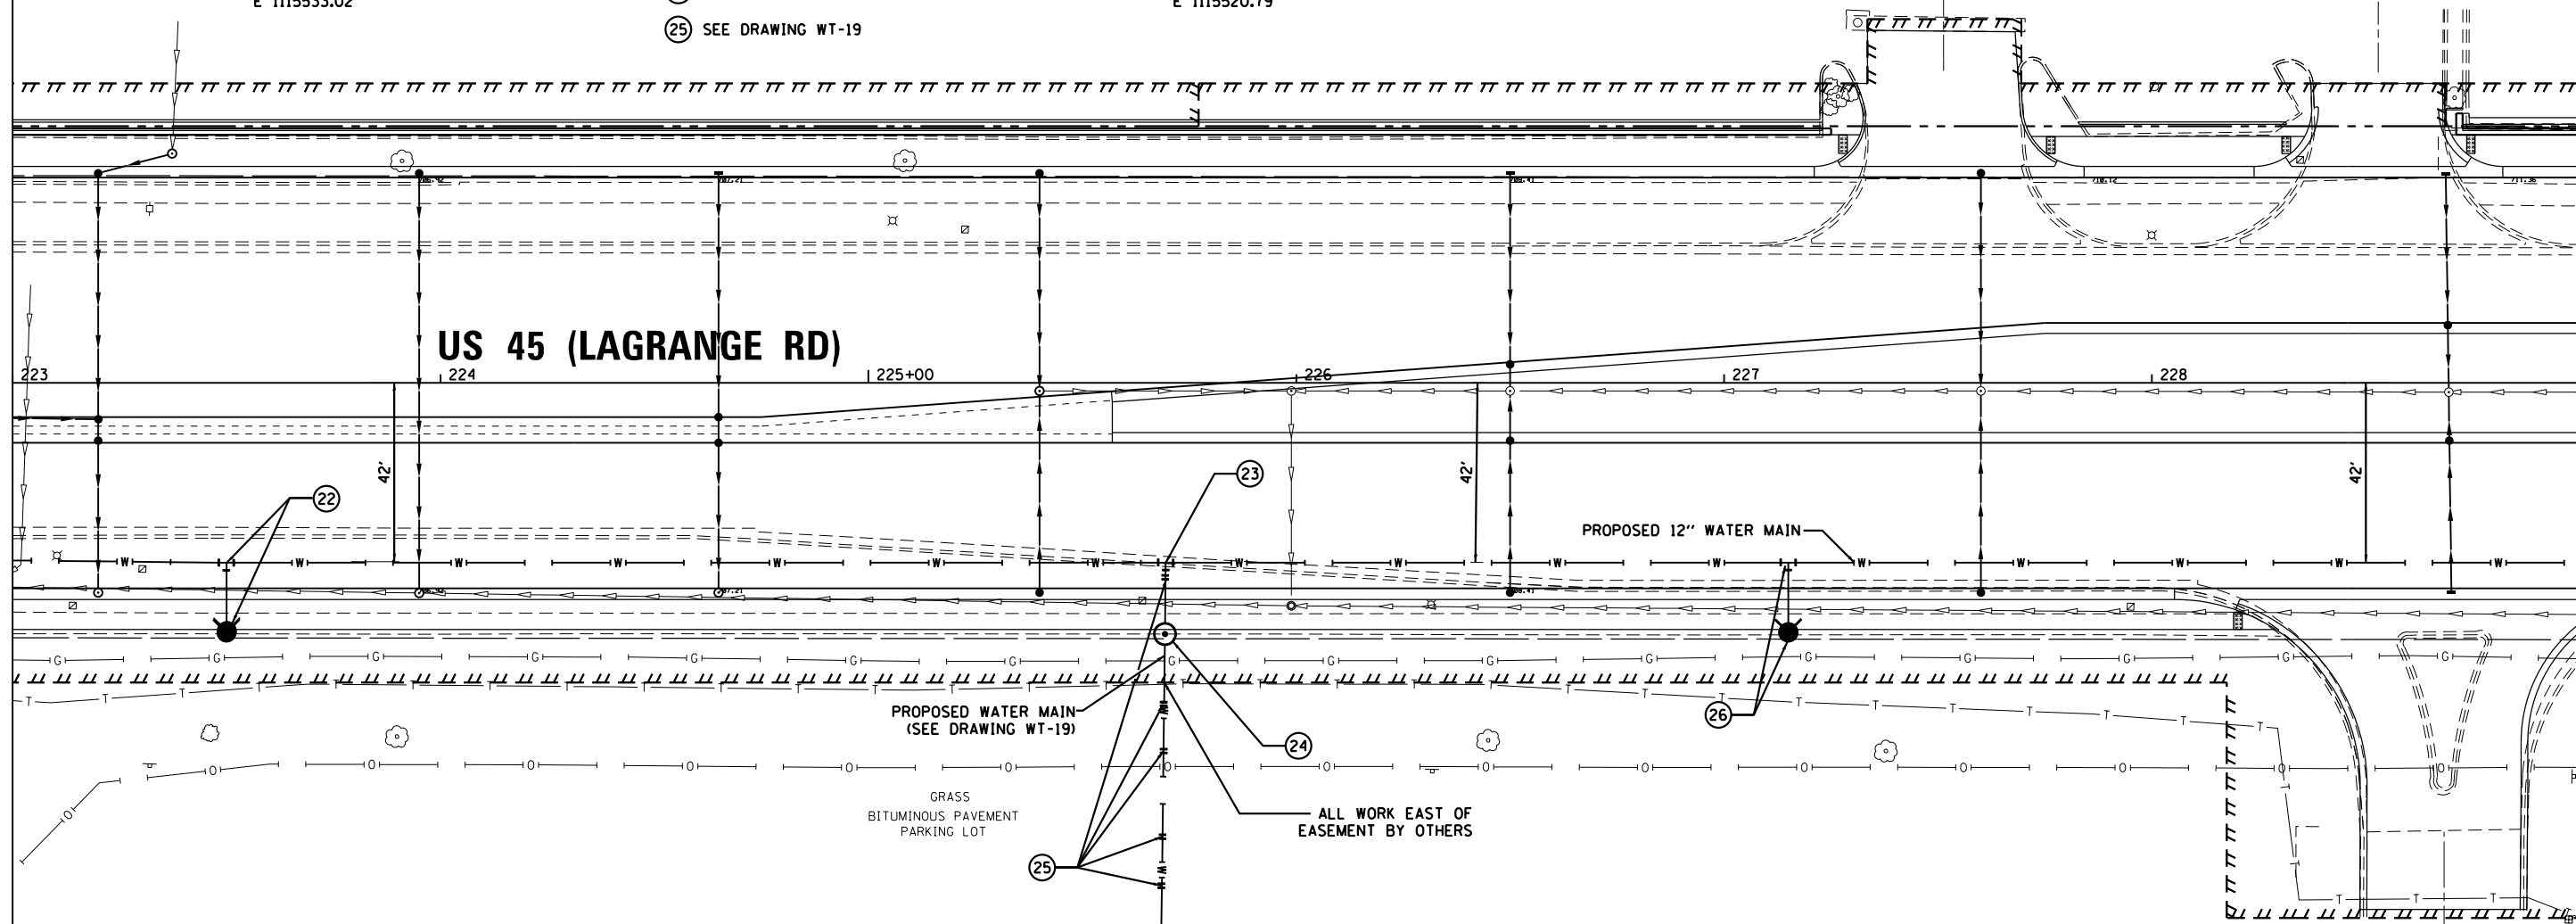

FILE NAME =	USER NAME = Anthony.Plutz	DESIGNED - DF	REVISED -	STATE OF ILLINOIS DEPARTMENT OF TRANSPORTATION	WATER MAIN - PROPOSED PLAN AND PROFILE US 45 (LAGRANGE ROAD)	F.A.P. R.T.E.	SECTION	COUNTY	TOTAL SHEETS	SHEET NO.
D160M61-SHT-WATER06.dgn		DRAWN - DF	REVISED -			330	103R-4	COOK	877	237
PLOT SCALE = 40.0000' / in.		CHECKED - TDW	REVISED -			WT-06		CONTRACT NO. 60M61		
PLOT DATE = 3/14/2013		DATE - 03/13/2013	REVISED -			ILLINOIS FED. AID PROJECT				

SCALE: 1"=20'H; 1"=5' SHEET 6 OF 21 SHEETS STA. 223+00.00 TO STA. 229+00.00