

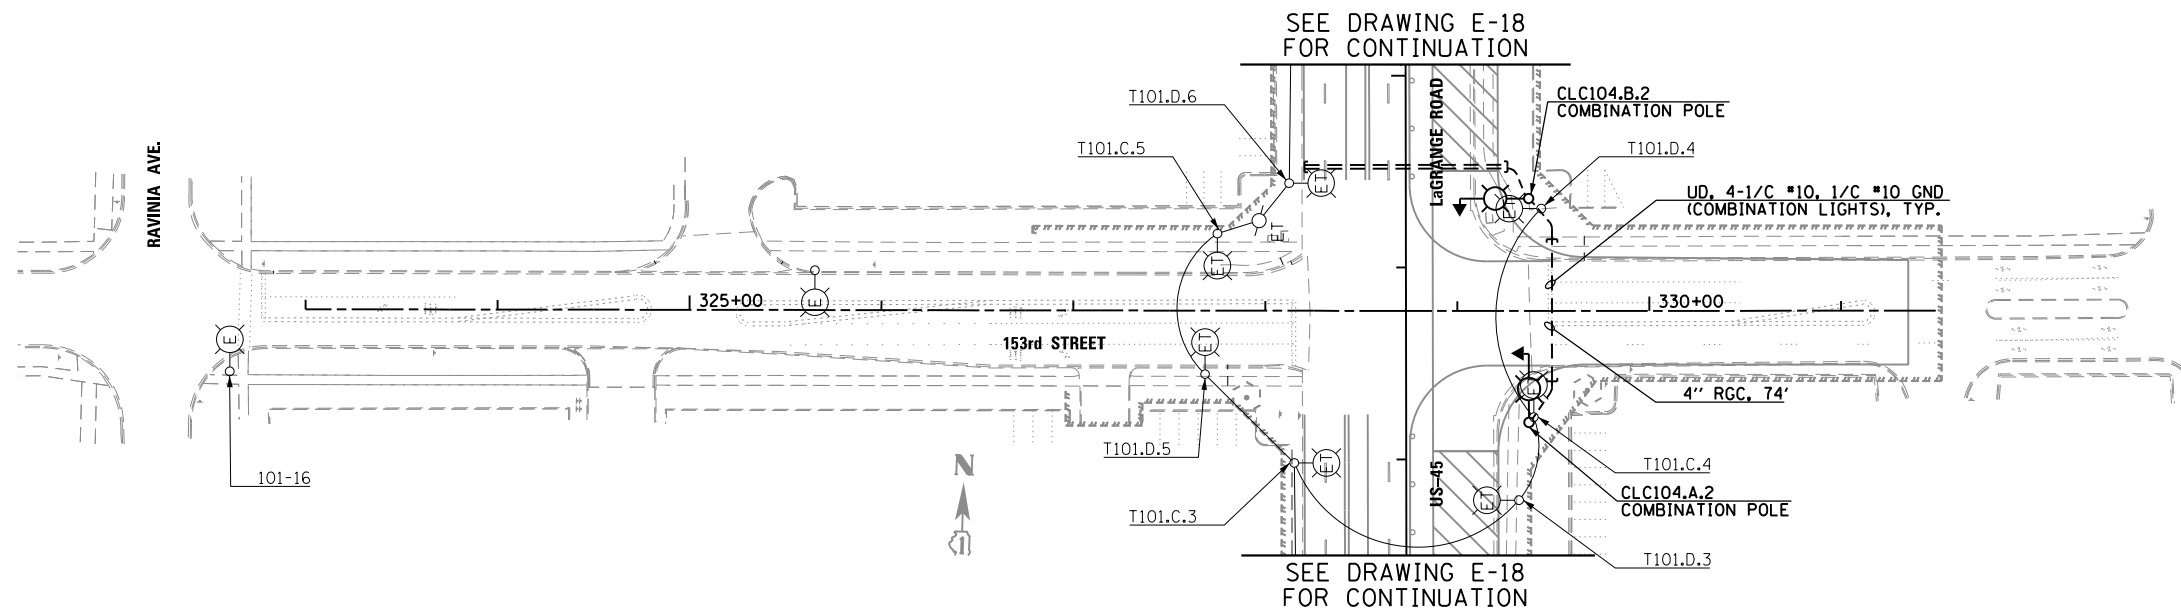


NOTES:

- SEE DRAWING E-1 FOR ELECTRICAL SYMBOL LIST AND ABBREVIATIONS. SEE DRAWING E-2 FOR ELECTRICAL GENERAL NOTES.

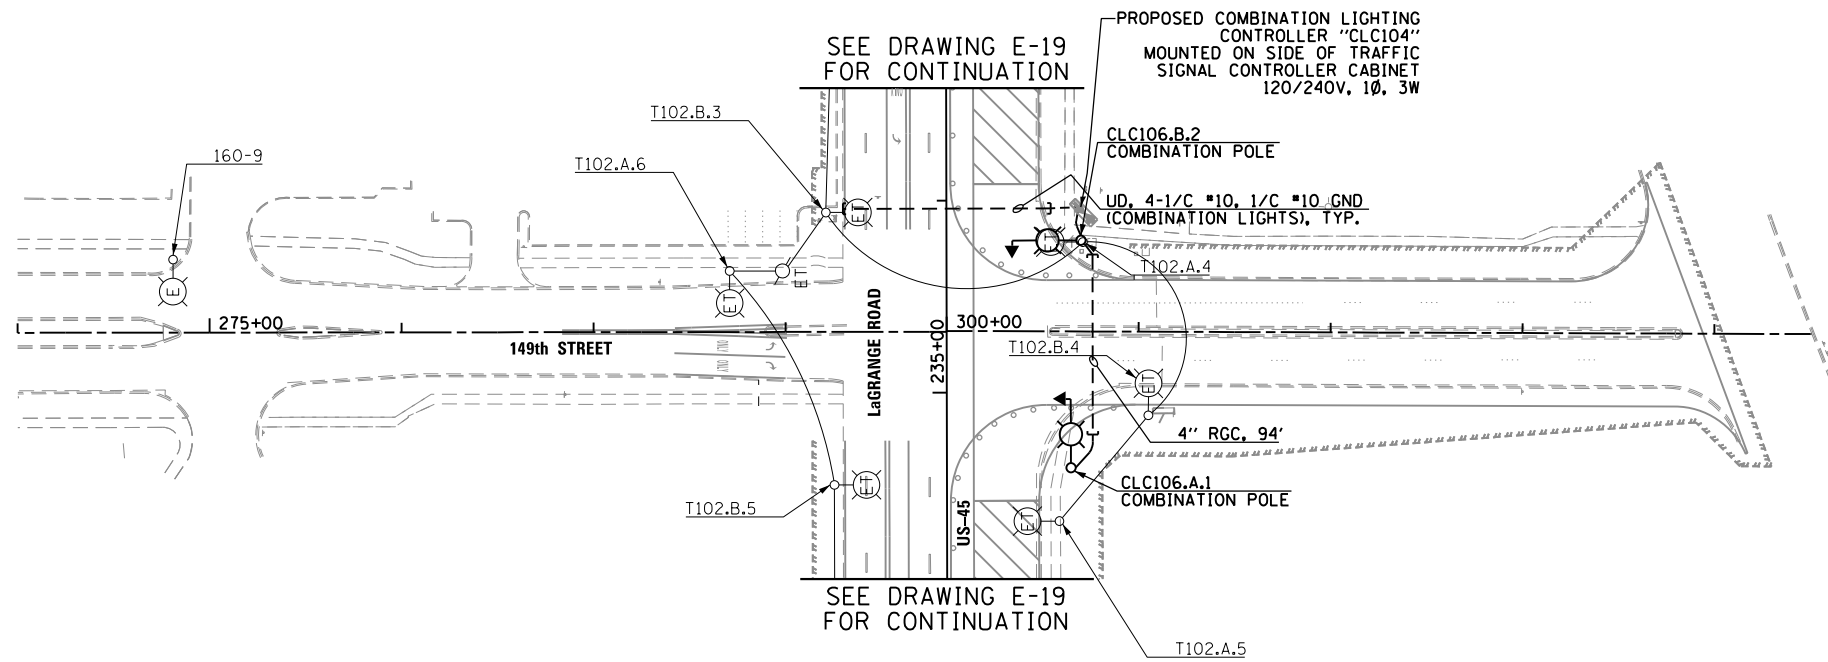

100 S. WACKER DR.
10TH FLOOR
CHICAGO, IL 60606
TEL (312) 935-1000
FAX (312) 935-4198

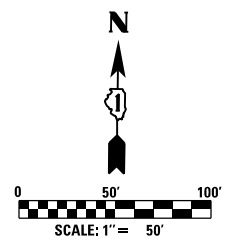

FILE NAME = D160M61-SHT-E21.dgn	USER NAME = michal_bartusiewicz	DESIGNED - MAE	REVISED -
SHT_PLAN	PLOT SCALE = 100.000000' / 1" =	DRAWN - MAE	REVISED -
	PLOT DATE = 3/15/2013	CHECKED - DAD	REVISED -
		DATE - 03/13/2013	REVISED -

**STATE OF ILLINOIS
DEPARTMENT OF TRANSPORTATION**

**153rd STREET & 149th STREET
TEMPORARY ROADWAY LIGHTING PLAN - STAGE 1A**

SCALE: 1"=50' SHEET 5 OF 7 SHEETS STA. VARIES TO STA. VARIES

F.A.P. RTE.	SECTION	COUNTY	TOTAL SHEETS	SHEET NO.
330	103R-4	COOK	877	432
E-21			CONTRACT NO. 60M61	
ILLINOIS FED. AID PROJECT				