


MATCH LINE SEE BELOW
US-45 STA 180+00

MATCH LINE SEE ABOVE
US-45 STA 180+00

MATCH LINE SEE DRAWING E-25
US-45 STA 195+00

 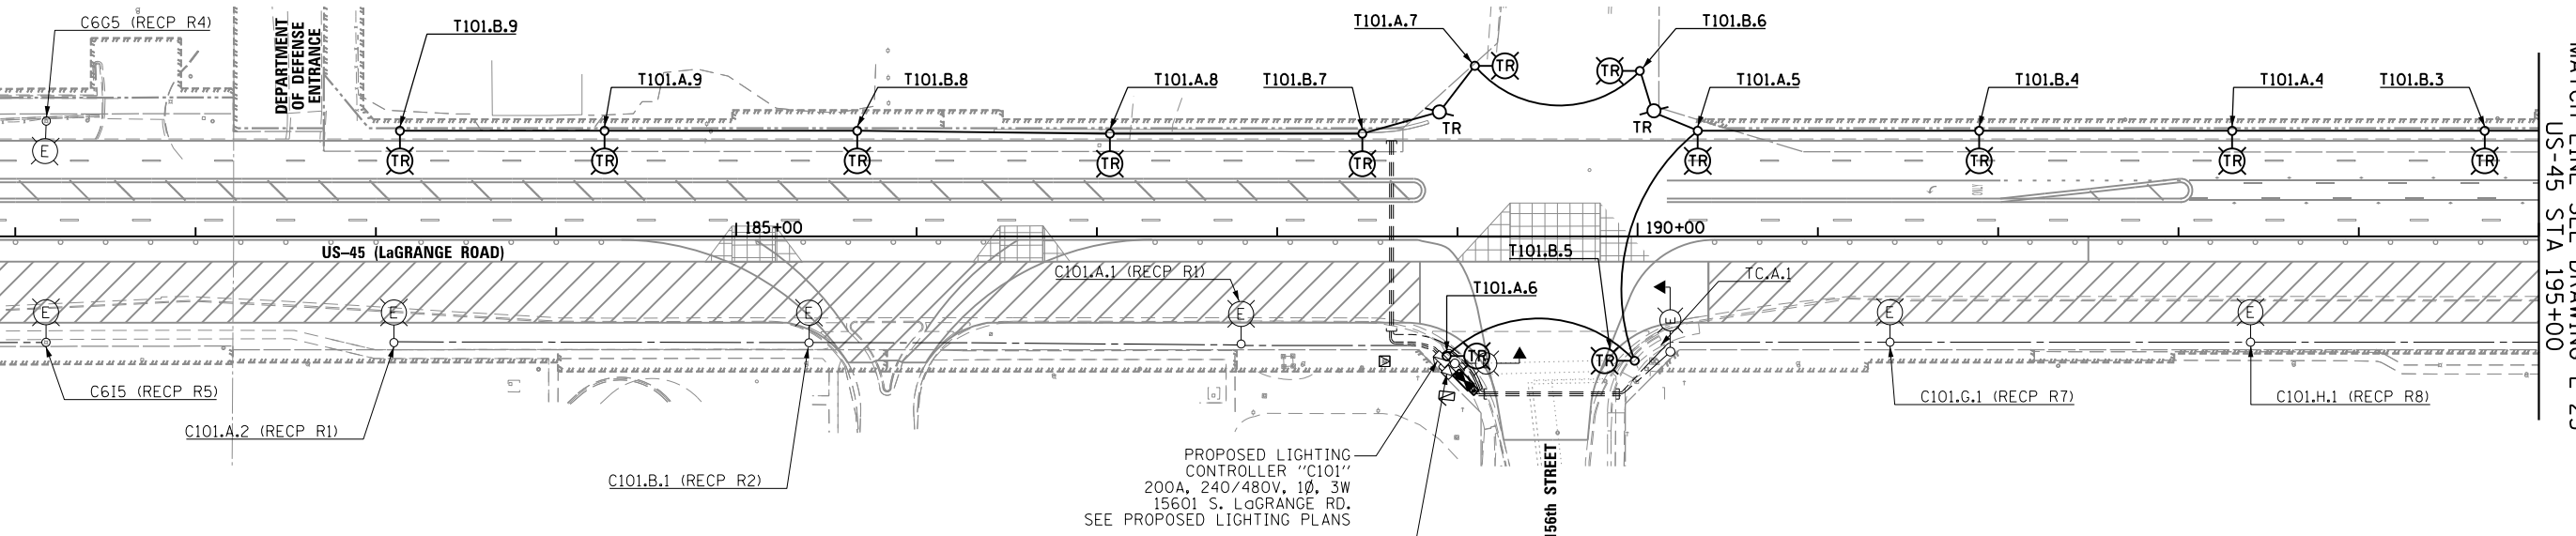


PROPOSED LIGHTING CONTROLLER "C101"
200A, 240/480V, 1Ø, 3W
15601 S. LaGRANGE RD.
SEE PROPOSED LIGHTING PLANS

PROPOSED COMED SERVICE TRANSFORMER
SEE PROPOSED LIGHTING PLANS

NOTES:

- SEE DRAWING E-1 FOR ELECTRICAL SYMBOL LIST AND ABBREVIATIONS. SEE DRAWING E-2 FOR ELECTRICAL GENERAL NOTES.
- CONTRACTOR SHALL REMOVE THE IDENTIFIED TEMPORARY LIGHTING UNITS, TEMPORARY LIGHTING CONTROLLERS, ALL ASSOCIATED UTILITY SERVICE WORK, AND THE TEMPORARY WIRING DURING CONSTRUCTION STAGE 2, ONCE ALL OF THE PROPOSED ROADWAY LIGHTING UNITS ALONG THE EAST SIDE OF LaGRANGE ROAD ARE INSTALLED, ENERGIZED, TESTED, AND APPROVED BY THE ENGINEER.



100 S. WACKER DR.
SUITE 500
CHICAGO, IL 60606
TEL (312) 939-1000
FAX (312) 939-4198



FILE NAME = D160M61-SHT-E24.dgn
SHT_PLAN
DT60M61-SHT-E24.dgn 3/15/2013 2:27:13 PM

USER NAME = michal_bar_tustewicz	DESIGNED - MAE	REVISED -
DRAWN - MAE	REVISIONS -	
PLOT SCALE = 100.000000' / 1" =	CHECKED - DAD	REVISED -
PLOT DATE = 3/15/2013	DATE - 03/13/2013	REVISED -

**STATE OF ILLINOIS
DEPARTMENT OF TRANSPORTATION**

**US 45 (LaGRANGE ROAD)
TEMPORARY ROADWAY LIGHTING PLAN - STAGE 1B**

SCALE: 1"=50' SHEET 1 OF 7 SHEETS STA. BEGIN TO STA. 195+00.00

F.A.P. RTE.	SECTION	COUNTY	TOTAL SHEETS	SHEET NO.
330	103R-4	COOK	877	435
E-24			CONTRACT NO. 60M61	
ILLINOIS FED. AID PROJECT				