

SEE DRAWING E-30 FOR CONTINUATION


NOTES:

- SEE DRAWING E-1 FOR ELECTRICAL SYMBOL LIST AND ABBREVIATIONS. SEE DRAWING E-2 FOR ELECTRICAL GENERAL NOTES.
- CONTRACTOR SHALL REMOVE THE IDENTIFIED TEMPORARY LIGHTING UNITS, TEMPORARY LIGHTING CONTROLLERS, ALL ASSOCIATED UTILITY SERVICE WORK, AND THE TEMPORARY WIRING DURING CONSTRUCTION STAGE 2, ONCE ALL OF THE PROPOSED ROADWAY LIGHTING UNITS ALONG THE EAST SIDE OF LAGRANGE ROAD ARE INSTALLED, ENERGIZED, TESTED, AND APPROVED BY THE ENGINEER.

MATCH LINE SEE DRAWING E-26
US-45 STA 255+00

MATCH LINE SEE BELOW
US-45 STA 266+00

MATCH LINE SEE ABOVE
US-45 STA 266+00

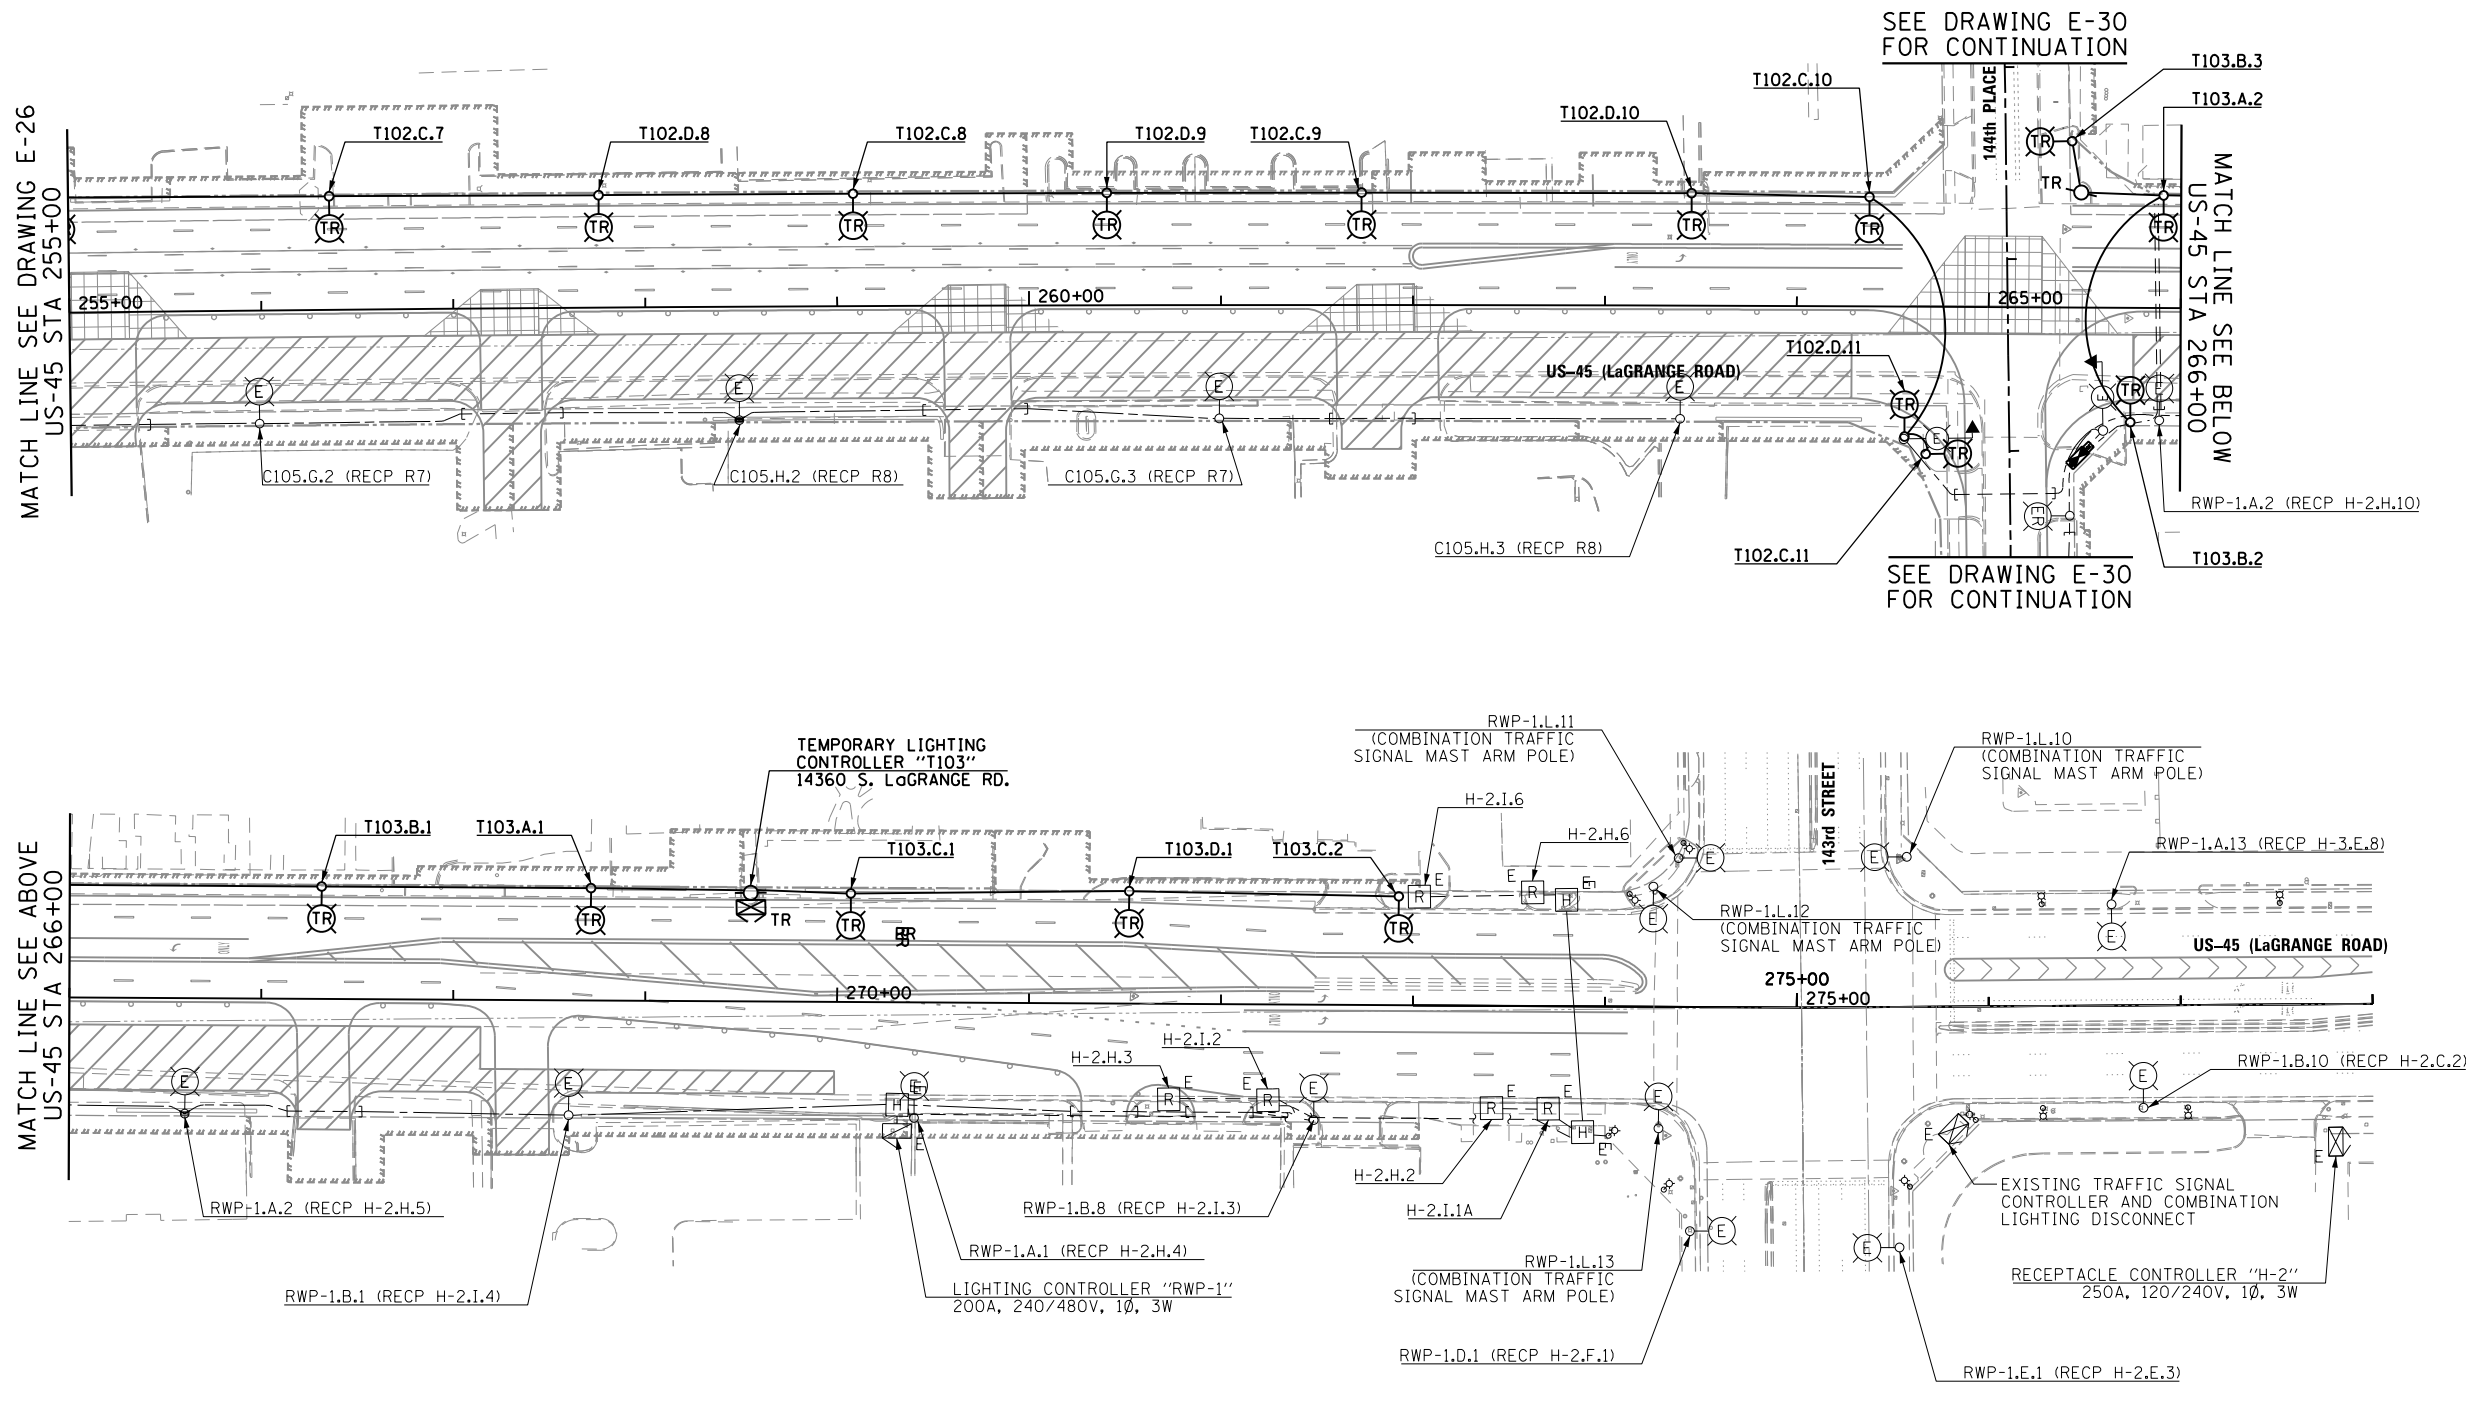

100 S. WACKER DR.
100 S. WACKER DR.
CHICAGO, IL 60606
TEL (312) 939-1000
FAX (312) 939-4198



FILE NAME = D160M61-SHT-E27.dgn	USER NAME = michal_bar_tusiewicz	DESIGNED - MAE	REVISED -
SHT_PLAN	PLOT SCALE = 100.000000' / in.	DRAWN - MAE	REVISED -
D160M61-SHT-E27.dgn 3/15/2013 2:27:15 PM	PLOT DATE = 3/15/2013	CHECKED - DAD	REVISED -
		DATE - 03/13/2013	REVISED -

**STATE OF ILLINOIS
DEPARTMENT OF TRANSPORTATION**

**US 45 (LaGRANGE ROAD)
TEMPORARY ROADWAY LIGHTING PLAN - STAGE 1B**

SCALE: 1"=50' SHEET 4 OF 7 SHEETS STA. 255+00.00 TO STA. 278+00.00

F.A.P. RTE.	SECTION	COUNTY	TOTAL SHEETS	SHEET NO.
330	103R-4	COOK	877	438
E-27			CONTRACT NO. 60M61	
ILLINOIS FED. AID PROJECT				