



NOTES:

1. SEE DRAWING E-1 FOR ELECTRICAL SYMBOL LIST AND ABBREVIATIONS. SEE DRAWING E-2 FOR ELECTRICAL GENERAL NOTES.
2. CONTRACTOR SHALL REMOVE THE IDENTIFIED TEMPORARY LIGHTING UNITS, TEMPORARY LIGHTING CONTROLLERS, ALL ASSOCIATED UTILITY SERVICE WORK, AND THE TEMPORARY WIRING DURING CONSTRUCTION STAGE 2, ONCE ALL OF THE PROPOSED ROADWAY LIGHTING UNITS ALONG THE EAST SIDE OF LAGRANGE ROAD ARE INSTALLED, ENERGIZED, TESTED, AND APPROVED BY THE ENGINEER.

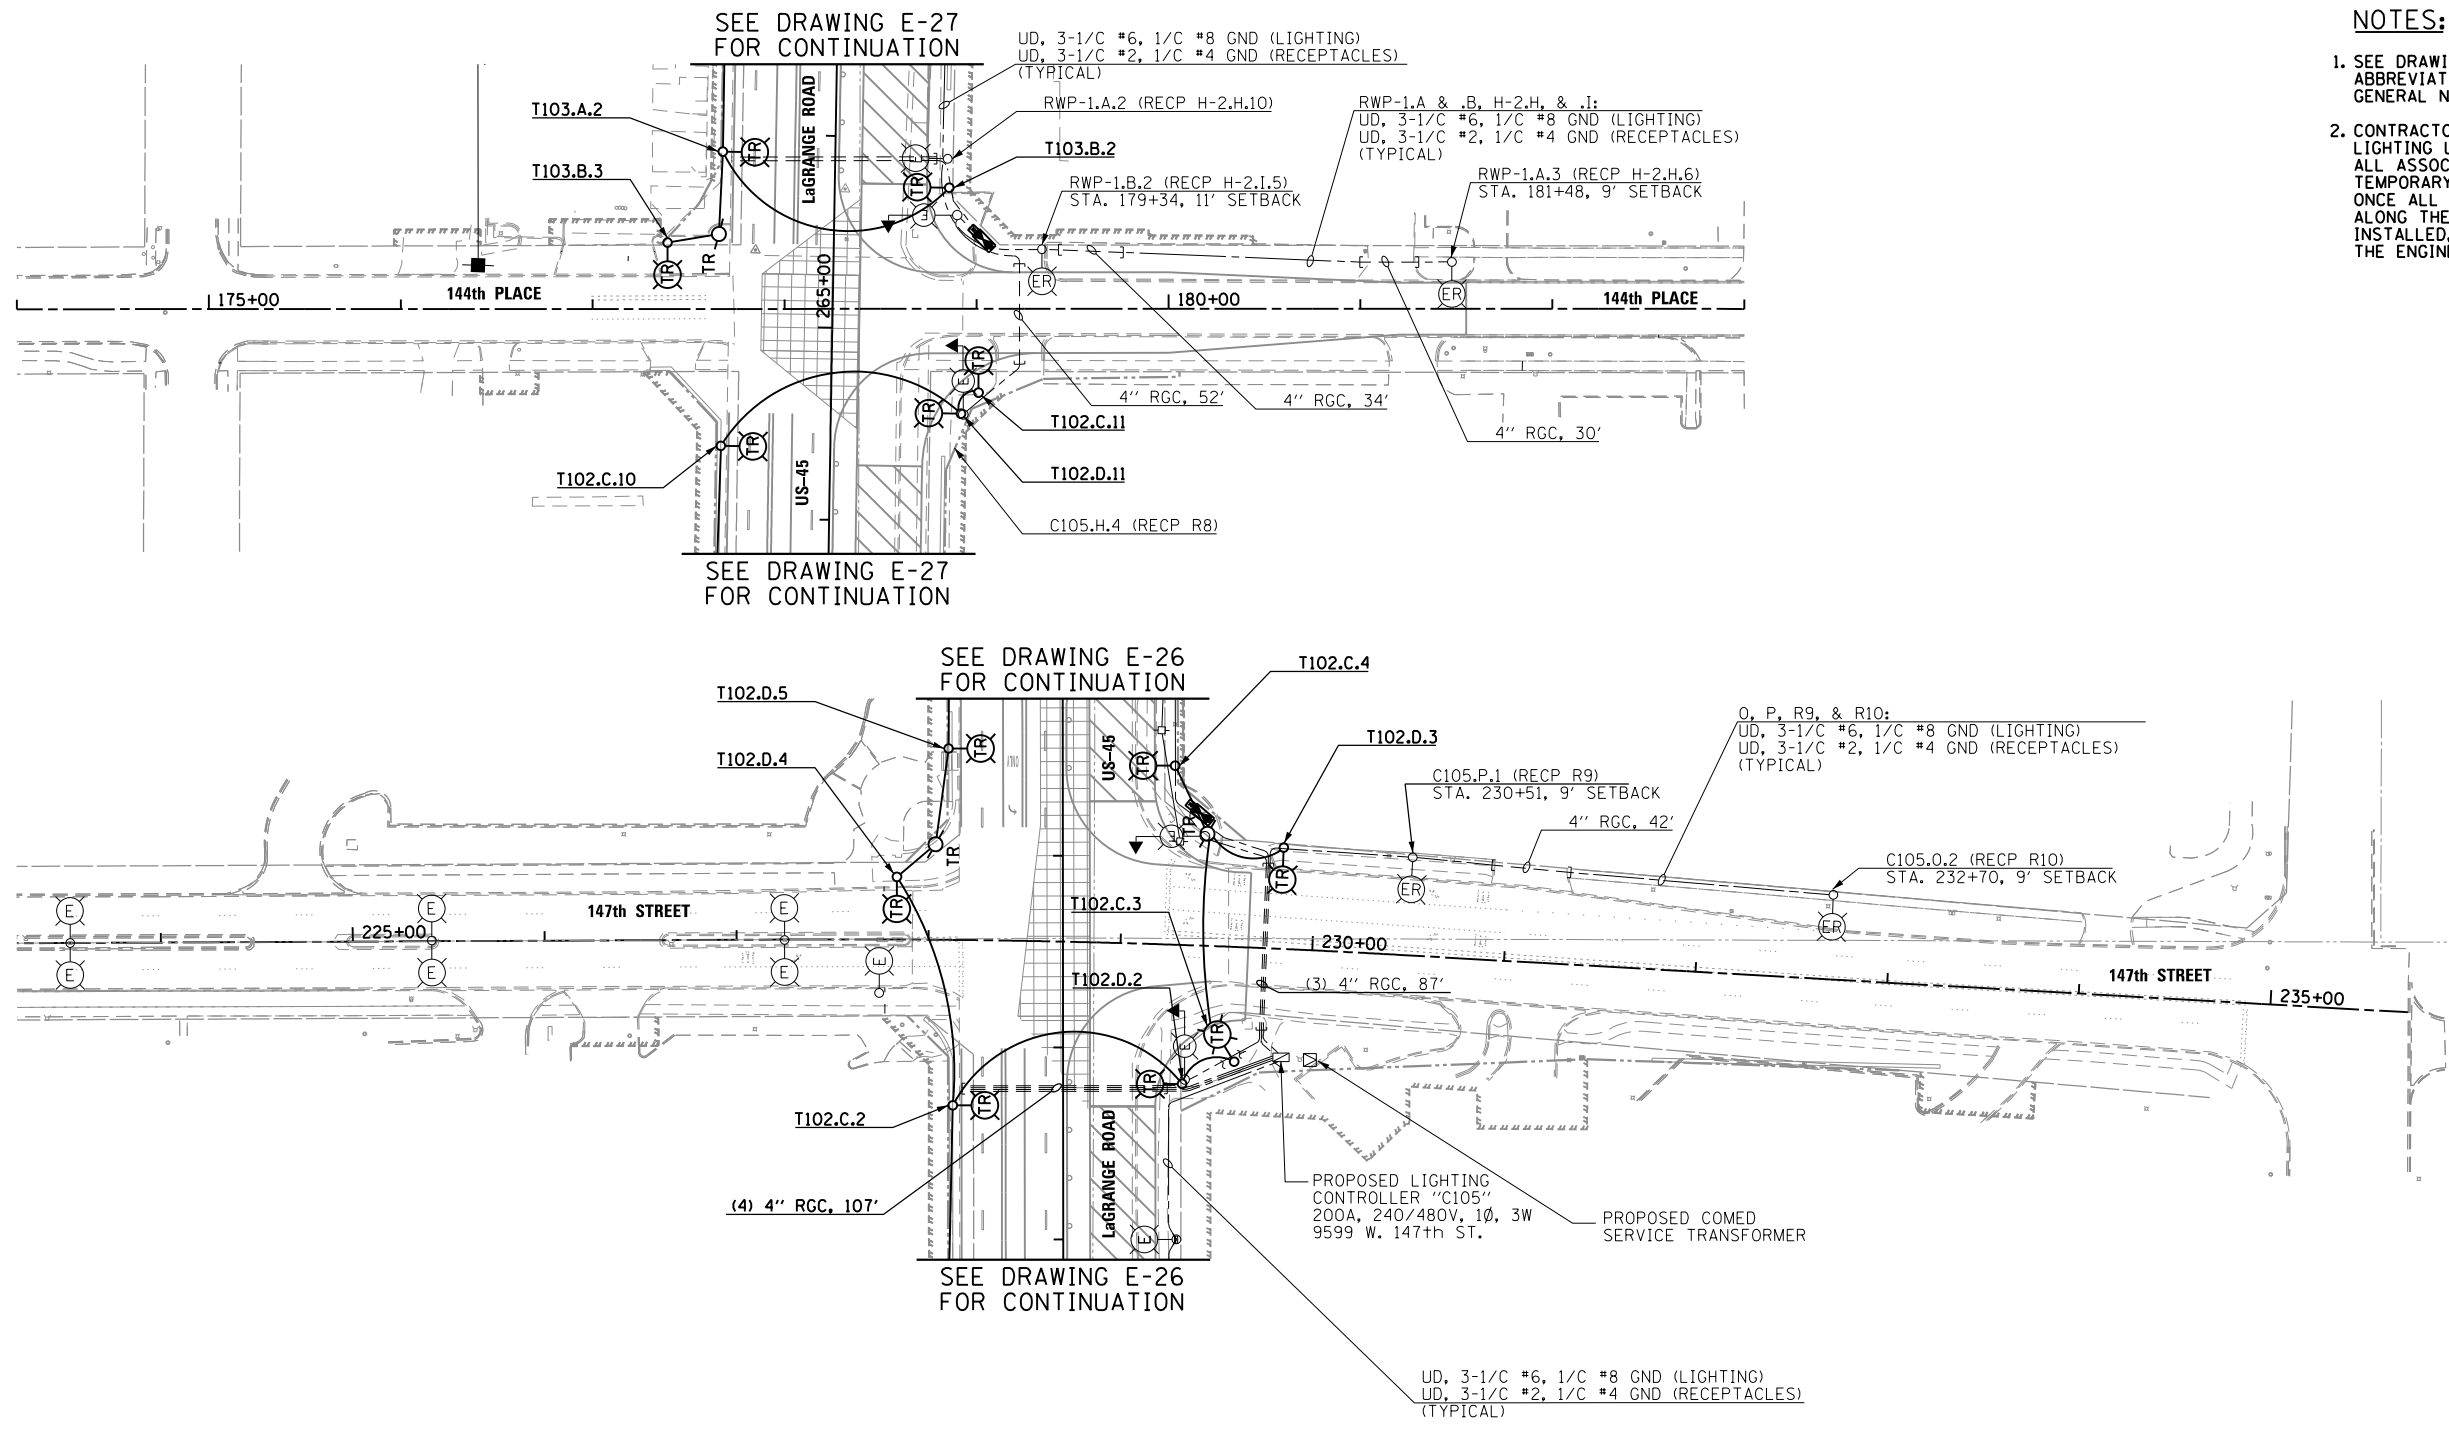

100 S. WACKER DR.
 SUITE 500
 CHICAGO, IL 60606
 TEL (312) 939-1000
 FAX (312) 939-4198
URS

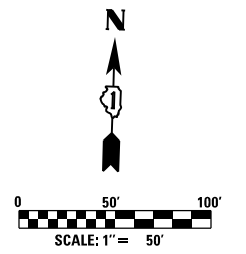

FILE NAME = D160M61-SHT-E30.dgn	USER NAME = michael_bartusiewicz	DESIGNED - MAE	REVISED -	STATE OF ILLINOIS DEPARTMENT OF TRANSPORTATION	147th STREET & 144th PLACE TEMPORARY ROADWAY LIGHTING PLAN - STAGE 1B			F.A.P. RTE. 330	SECTION 103R-4	COUNTY COOK	TOTAL SHEETS 877	SHEET NO. 441
SHT_PLAN	PLOT SCALE = 100.000000' / in.	CHECKED - DAD	REVISED -		SCALE: 1"=50'	SHEET 7 OF 7 SHEETS	STA. VARIES TO STA. VARIES	E-30		CONTRACT NO. 60M61		
	PLOT DATE = 3/15/2013	DATE - 03/13/2013	REVISED -		ILLINOIS FED. AID PROJECT							
DT60M61-SHT-E30.dgn 3/15/2013 2:27:17 PM												