



- NOTES:**
1. SEE DRAWING E-1 FOR ELECTRICAL SYMBOL LIST AND ABBREVIATIONS. SEE DRAWING E-2 FOR ELECTRICAL GENERAL NOTES.
 2. SEE DETAIL DRAWING FOR PROPOSED LIGHTING UNIT DETAILS. SEE IDOT STANDARD DRAWING BE-301 FOR PROPOSED LIGHTING UNIT FOUNDATION DETAILS.

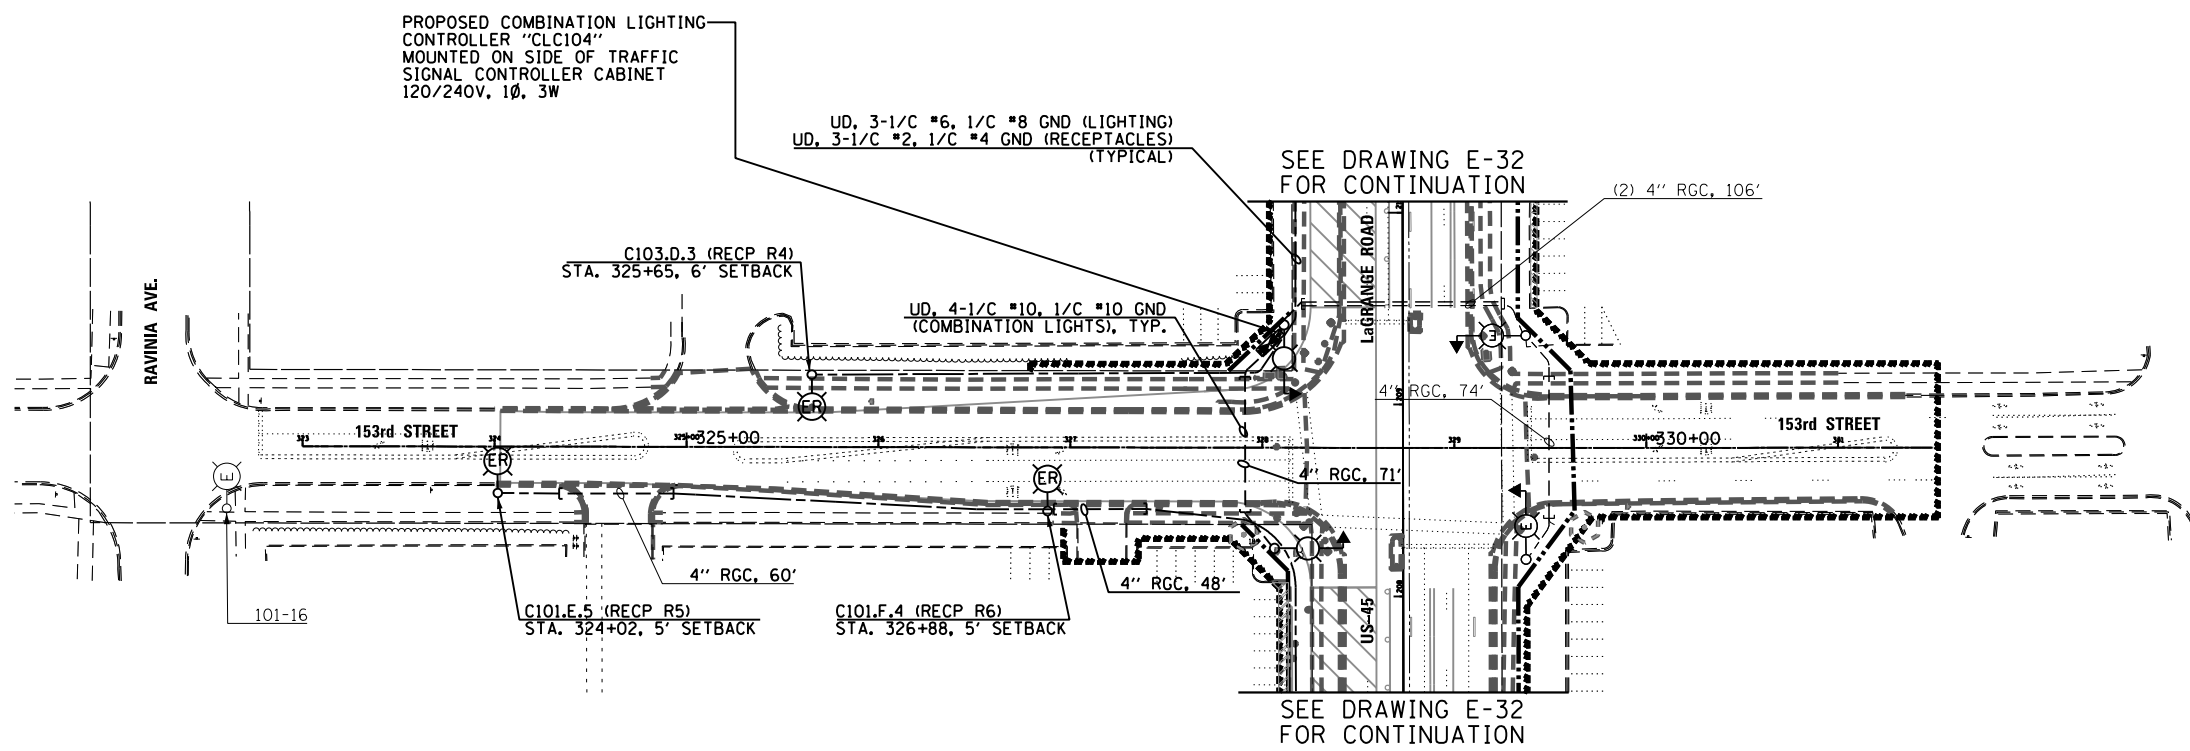

100 S. WACKER DR.
 SUITE 600
 CHICAGO, IL 60606
 TEL (312) 939-1000
 FAX (312) 939-4998
URS

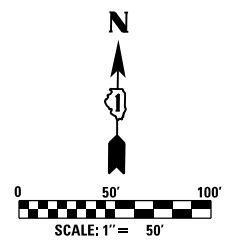

| | | | | | | | | | | | | |
|------------------------------------|----------------------------------|-------------------|-----------|--|--|--|---------------------------|-------------------|------------------|--------------------|--------------------|-----------------|
| FILE NAME = D160M61-SHT-E35.dgn | USER NAME = michael_bartusiewicz | DESIGNED - MAE | REVISED - | STATE OF ILLINOIS DEPARTMENT OF TRANSPORTATION | 153rd STREET & 149th STREET TEMPORARY ROADWAY LIGHTING PLAN - STAGE 3 | | | F.A.P. RTE. = 330 | SECTION = 103R-4 | COUNTY = COOK | TOTAL SHEETS = 877 | SHEET NO. = 446 |
| | PLOT SCALE = 100.000000' / in. | CHECKED - DAD | REVISED - | | | | | E-35 | | CONTRACT NO. 60M61 | | |
| SHT_PLAN | PLOT DATE = 3/15/2013 | DATE = 03/13/2013 | REVISED - | SCALE: 1"=50' SHEET 5 OF 7 SHEETS STA. VARIES TO STA. VARIES | | | ILLINOIS FED. AID PROJECT | | | | | |

D160M61-SHT-E35.dgn 3/15/2013 2:27:22 PM