



**NOTES:**

- SEE DRAWING E-1 FOR ELECTRICAL SYMBOL LIST AND ABBREVIATIONS. SEE DRAWING E-2 FOR ELECTRICAL GENERAL NOTES.

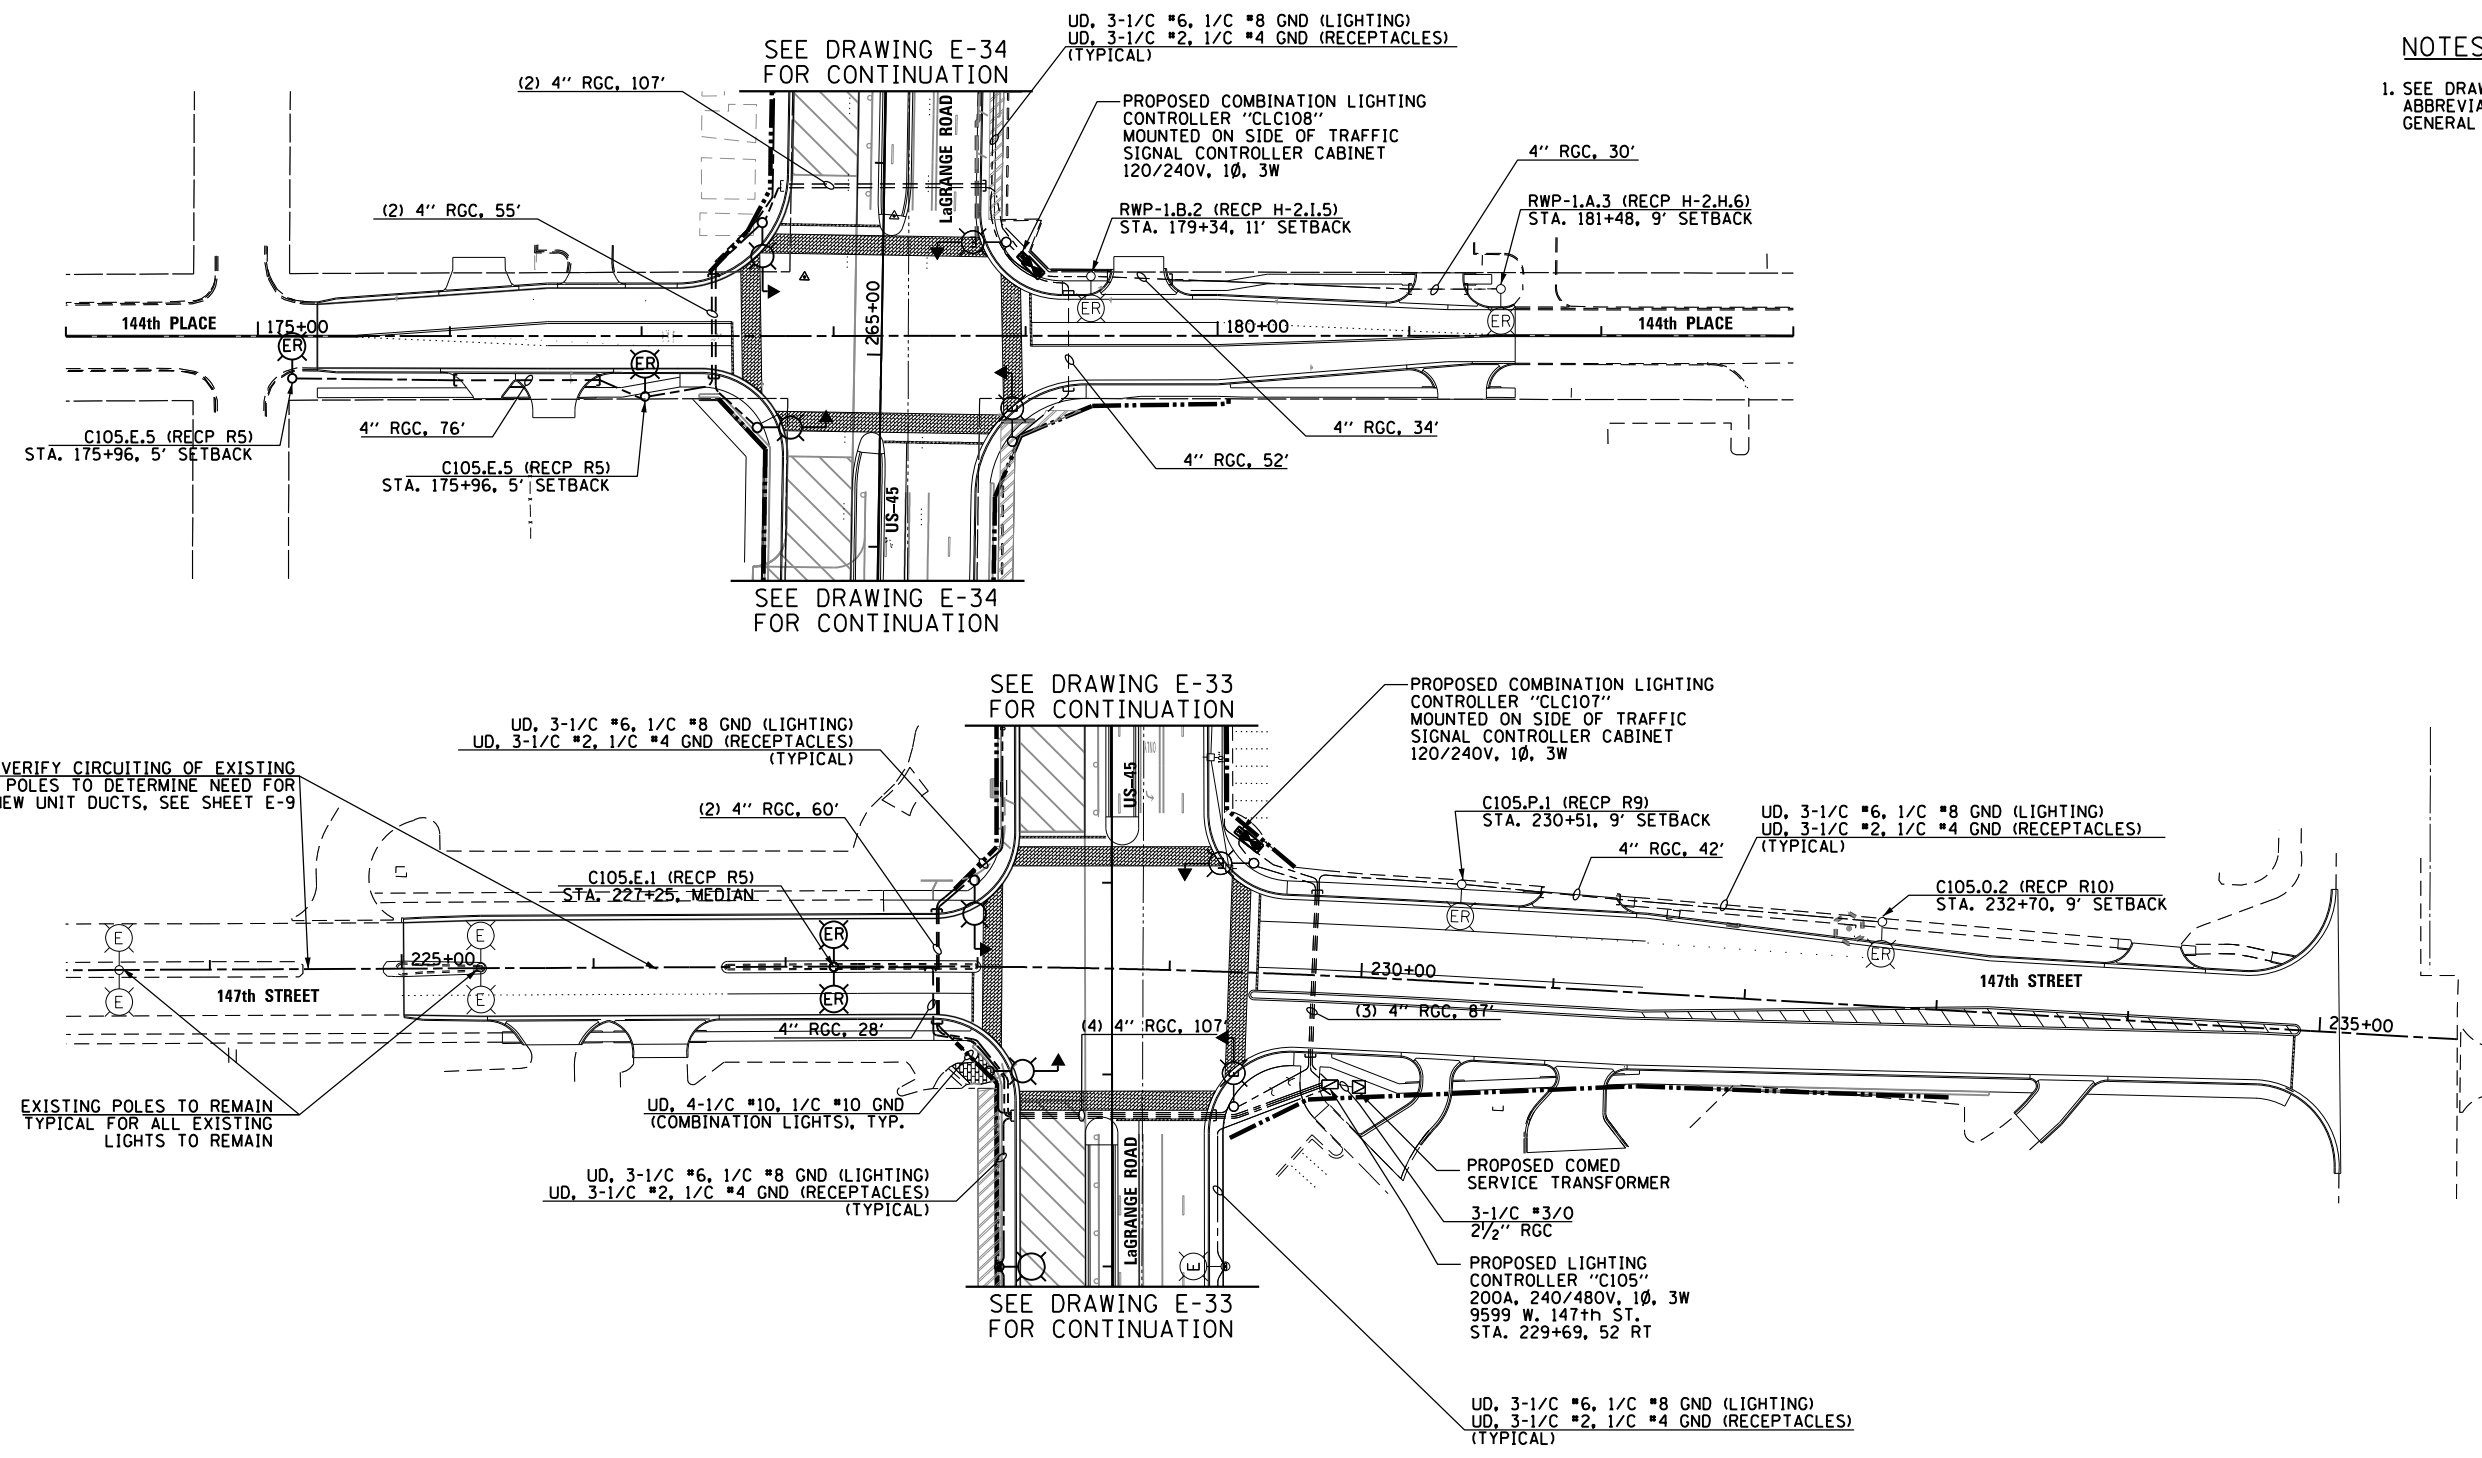

VERIFY CIRCUITING OF EXISTING POLES TO DETERMINE NEED FOR NEW UNIT DUCTS, SEE SHEET E-9

EXISTING POLES TO REMAIN TYPICAL FOR ALL EXISTING LIGHTS TO REMAIN

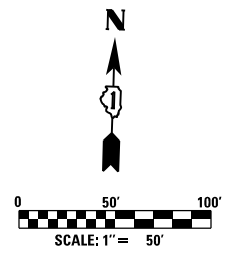

100 S. WACKER DR.  
 SUITE 600  
 CHICAGO, IL 60606  
 TEL (312) 935-1000  
 FAX (312) 935-4998  
**URS**

FILE NAME = D160M61-SHT-E37.dgn	USER NAME = michal_bartusiewicz	DESIGNED - MAE	REVISED -	<b>STATE OF ILLINOIS DEPARTMENT OF TRANSPORTATION</b>	<b>147th STREET &amp; 144th PLACE TEMPORARY ROADWAY LIGHTING PLAN - STAGE 3</b>	F.A.P. RTE.	SECTION	COUNTY	TOTAL SHEETS	SHEET NO.	
SHT.PLAN	PLOT SCALE = 100.000000' / 1" =	DRAWN - MAE	REVISED -			330	103R-4	COOK	877	448	
DT60M61-SHT-E37.dgn 3/15/2013 2:27:23 PM	PLOT DATE = 3/15/2013	CHECKED - DAD	REVISED -			<b>E-37</b>		CONTRACT NO. 60M61		ILLINOIS FED. AID PROJECT	
		DATE - 03/13/2013	REVISED -			SCALE: 1"=50'	SHEET 7 OF 7 SHEETS	STA. VARIES	TO STA. VARIES		