

STORM SEWER REMOVAL 8"
 STA. 292+70.1 TO 292+78.1 - 6' (TBF=0.8 CU YD)
 STA. 292+78.1 TO 293+08.0 - 33' (TBF=7.0 CU YD)

STORM SEWER REMOVAL 42"
 STA. 290+00.0 TO 291+44.7 - 143' (TBF=257.4 CU YD)
 STA. 291+44.7 TO 296+00.0 - 455' (TBF=772.9 CU YD)

STORM SEWER REMOVAL 12"
 STA. 290+00.0 TO 290+39.0 - 100' (TBF=22.7 CU YD)
 STA. 290+00.0 TO 290+41.9 - 41' (TBF=8.2 CU YD)
 STA. 290+00.0 TO 291+46.0 - 145' (TBF=53.8 CU YD)
 STA. 290+39.0 TO 290+59.5 - 27' (TBF=5.5 CU YD)
 STA. 290+41.9 TO 290+59.5 - 26' (TBF=6.5 CU YD)
 STA. 290+50.8 TO 290+39.0 - 38' (TBF=6.1 CU YD)
 STA. 290+59.5 TO 293+08.0 - 245' (TBF=89.4 CU YD)
 STA. 291+44.1 TO 291+44.7 - 13' (TBF=1.3 CU YD)
 STA. 291+46.0 TO 291+44.1 - 28' (TBF=9.8 CU YD)
 STA. 291+92.0 TO 291+44.1 - 46'
 STA. 292+91.2 TO 292+96.0 - 3'
 STA. 292+96.0 TO 293+08.0 - 25' (TBF=8.4 CU YD)
 STA. 293+08.0 TO 294+58.3 - 147' (TBF=123.3 CU YD)
 STA. 293+87.6 TO 293+87.6 - 14' (TBF=4.2 CU YD)
 STA. 294+49.4 TO 294+54.1 - 3' (TBF=0.5 CU YD)
 STA. 294+54.1 TO 294+54.1 - 1' (TBF=0.4 CU YD)
 STA. 294+58.3 TO 294+65.8 - 4' (TBF=3.6 CU YD)
 STA. 294+65.8 TO 294+65.8 - 26' (TBF=22.4 CU YD)
 STA. 295+13.0 TO 295+25.2 - 9' (TBF=1.5 CU YD)
 STA. 295+25.2 TO 295+25.0 - 45' (TBF=19.8 CU YD)

REMOVING MANHOLES

291+44.7, 15.8 RT
 291+46.0, 47.3 RT
 294+58.3, 42.4 LT
 294+65.8, 44.4 LT


REMOVING INLETS

290+41.9, 2.1 RT
 291+44.1, 0.1 RT
 291+92.0, 1.6 LT
 292+70.1, 50.2 LT
 292+78.1, 50.3 LT
 293+08.0, 31.3 LT
 292+96.0, 6.2 LT
 293+87.6, 53.6 LT
 294+49.4, 08.8 LT
 294+54.1, 10.4 LT
 295+13.0, 57.3 LT

REMOVING CATCH BASINS


290+50.8, 82.9 LT
 290+59.5, 21.2 LT
 293+08.0, 31.3 LT
 295+25.2, 57.8 LT

291+92.0, 1.6 LT
 292+70.1, 50.2 LT
 292+78.1, 50.3 LT
 293+08.0, 31.3 LT
 292+96.0, 6.2 LT
 293+87.6, 53.6 LT
 294+49.4, 08.8 LT
 294+54.1, 10.4 LT
 295+13.0, 57.3 LT

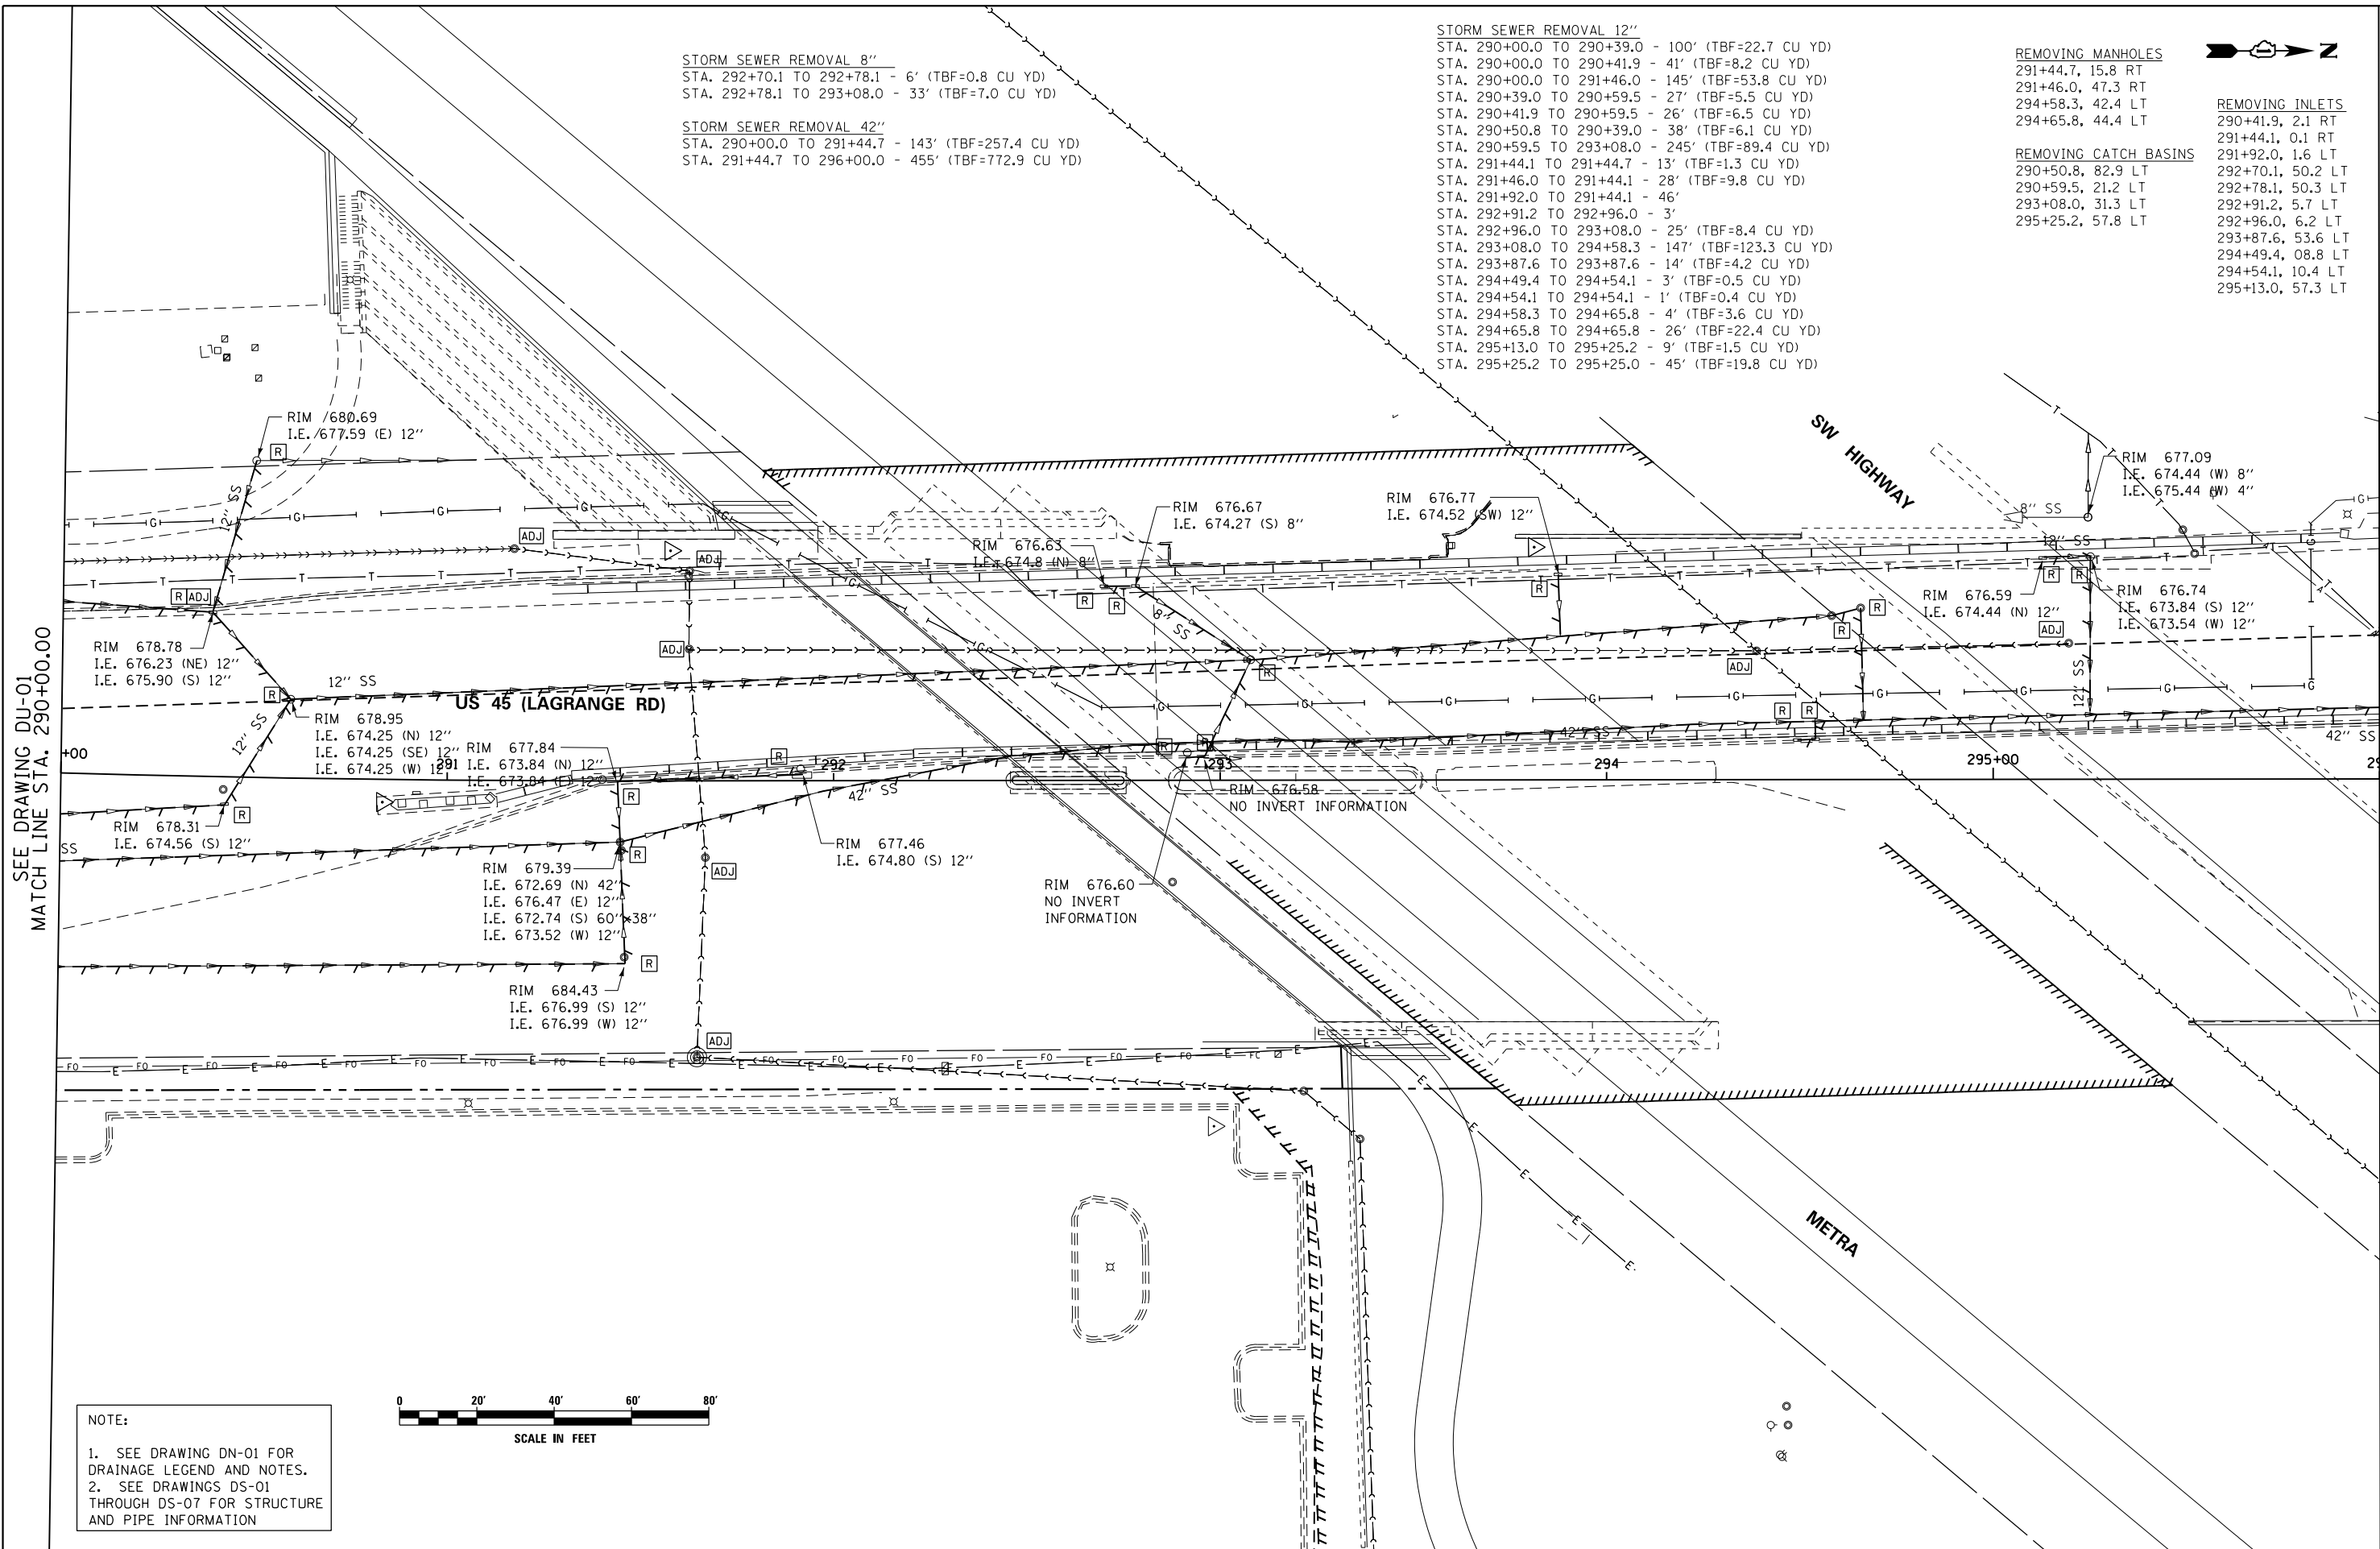

SEE DRAWING DU-01
 MATCH LINE STA. 290+00.00

 MATCH LINE STA. 296+00.00
 SEE DRAWING DU-03



NOTE:
 1. SEE DRAWING DN-01 FOR DRAINAGE LEGEND AND NOTES.
 2. SEE DRAWINGS DS-01 THROUGH DS-07 FOR STRUCTURE AND PIPE INFORMATION

100 S. WACKER DR.
 100 S. WACKER DR.
 CHICAGO, IL 60606
 TEL (312) 939-1000
 FAX (312) 939-4998



FILE NAME = D160M62-SHT-DRAINE.X02.dgn	USER NAME = Anthony.Plutz	DESIGNED - EJD	REVISED -	STATE OF ILLINOIS DEPARTMENT OF TRANSPORTATION	EXISTING DRAINAGE PLAN - US 45 (LAGRANGE ROAD)			F.A.P. RTE. 330	SECTION 103R-5	COUNTY COOK	TOTAL SHEETS 778	SHEET NO. 157
SHT.PLAN	PLOT SCALE = 48.000000' / in.	CHECKED - JWM	REVISED -		SCALE: 1"=20'	SHEET 2 OF 17 SHEETS	STA. 290+00.00 TO STA. 296+00.00	DU-02		CONTRACT NO. 60M62		
	PLOT DATE = 3/13/2013	DATE - 03/13/13	REVISED -		ILLINOIS FED. AID PROJECT							