

STORM SEWER REMOVAL - 12"
 STA. 376+13.2 TO 376+13.4 - 7' (TBF=4.9 CU YD)
 STA. 377+00.3 TO 377+01.5 - 71' (TBF=18.9 CU YD)
 STA. 375+60.7 TO 376+08.1 - 47' (TBF=7.5 CU YD)


STORM SEWER REMOVAL - 15"
 STA. 374+00.0 TO 377+01.5 - 300'

STORM SEWER REMOVAL - 18"
 STA. 377+01.5 TO 378+82.3 - 180'

END SECTIONS TO BE REMOVED
 STA. 375+60.7, 57.6 RT
 STA. 376+08.1, 56.8 RT


REMOVING INLETS
 376+13.2, 33.0 LT
 377+00.3, 33.1 RT

REMOVING MANHOLES
 377+01.5, 40.9 LT

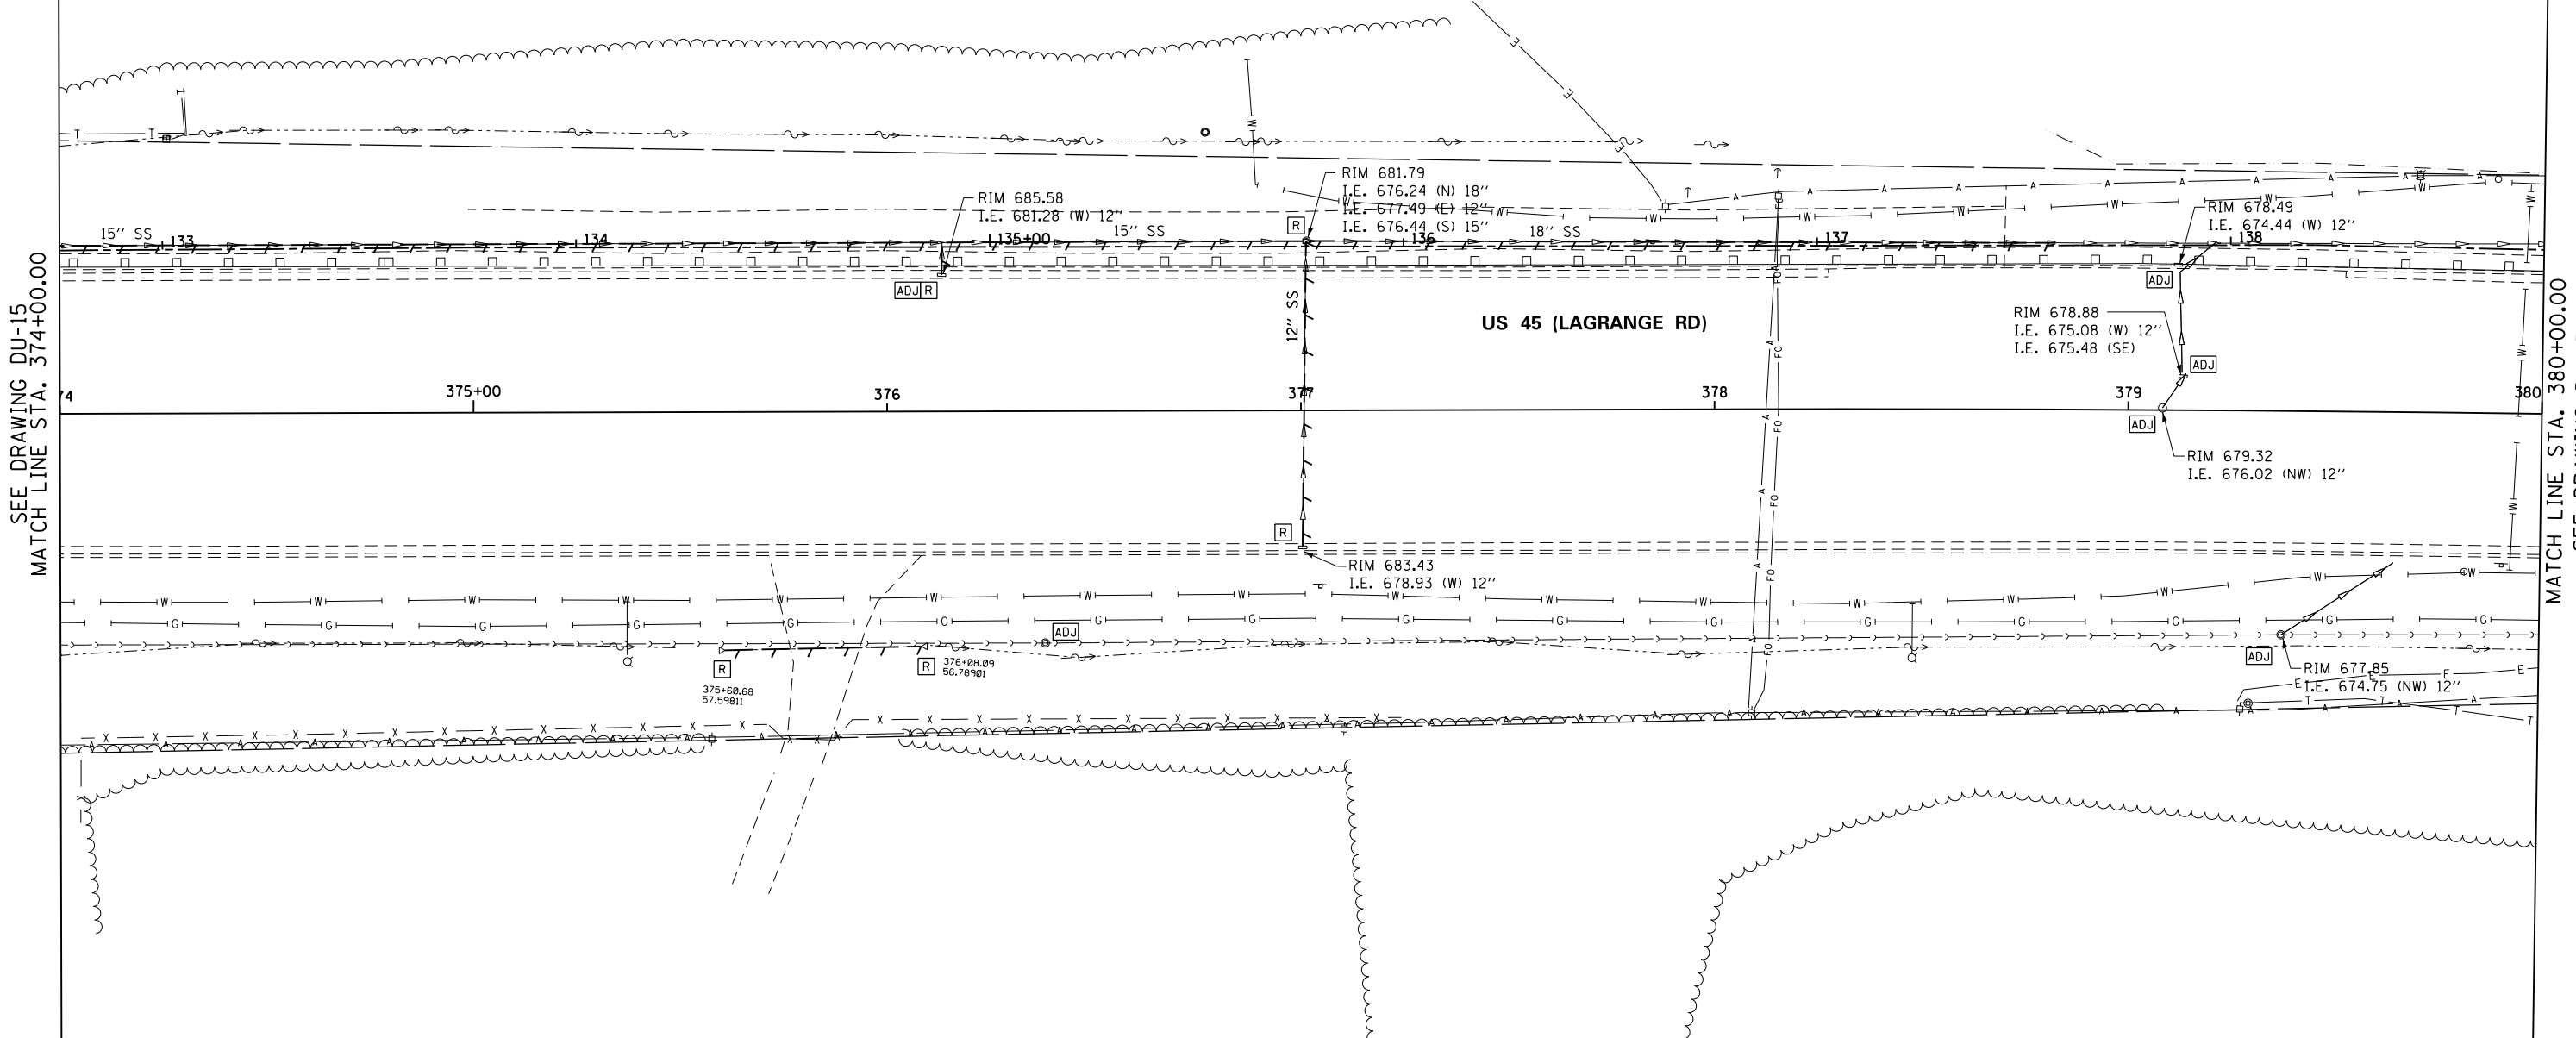

SEE DRAWING DU-15
 MATCH LINE STA. 374+00.00

 MATCH LINE STA. 380+00.00
 SEE DRAWING DU-17



NOTE:
 1. SEE DRAWING DN-01 FOR DRAINAGE LEGEND AND NOTES.
 2. SEE DRAWINGS DS-01 THROUGH DS-07 FOR STRUCTURE AND PIPE INFORMATION

100 S. WACKER DR.
 SUITE 600
 CHICAGO, IL 60606
 TEL (312) 939-1000
 FAX (312) 939-4998



FILE NAME = D:\160M62-SHT-DRAINE\X16.dgn
 SHT_PLAN

USER NAME = Anthony.Plutz	DESIGNED - EJD	REVISED -
PLOT SCALE = 40.000000' / in.	DRAWN - EJD	REVISED -
PLOT DATE = 3/13/2013	CHECKED - JWM	REVISED -
	DATE - 03/13/13	REVISED -

STATE OF ILLINOIS
 DEPARTMENT OF TRANSPORTATION

EXISTING DRAINAGE PLAN - US 45 (LAGRANGE ROAD)

SCALE: 1"=20' SHEET 16 OF 17 SHEETS STA. 374+00.00 TO STA. 380+00.00

F.A.P. RTE.	SECTION	COUNTY	TOTAL SHEETS	SHEET NO.
330	103R-5	COOK	778	171
DU-16			CONTRACT NO. 60M62	
ILLINOIS FED. AID PROJECT				