


STORM SEWER REMOVAL - 18"
 STA. 654+01.0 TO 655+66.0 - 165' (TBF=0.0 CU YD)
 STA. 655+70.0 TO 656+04.0 - 34' (TBF=0.0 CU YD)

REMOVING CATCH BASINS
 655+68.0, 24.8' RT

 
REMOVING FLARED END SECTION
 656+05.3, 24.0' RT

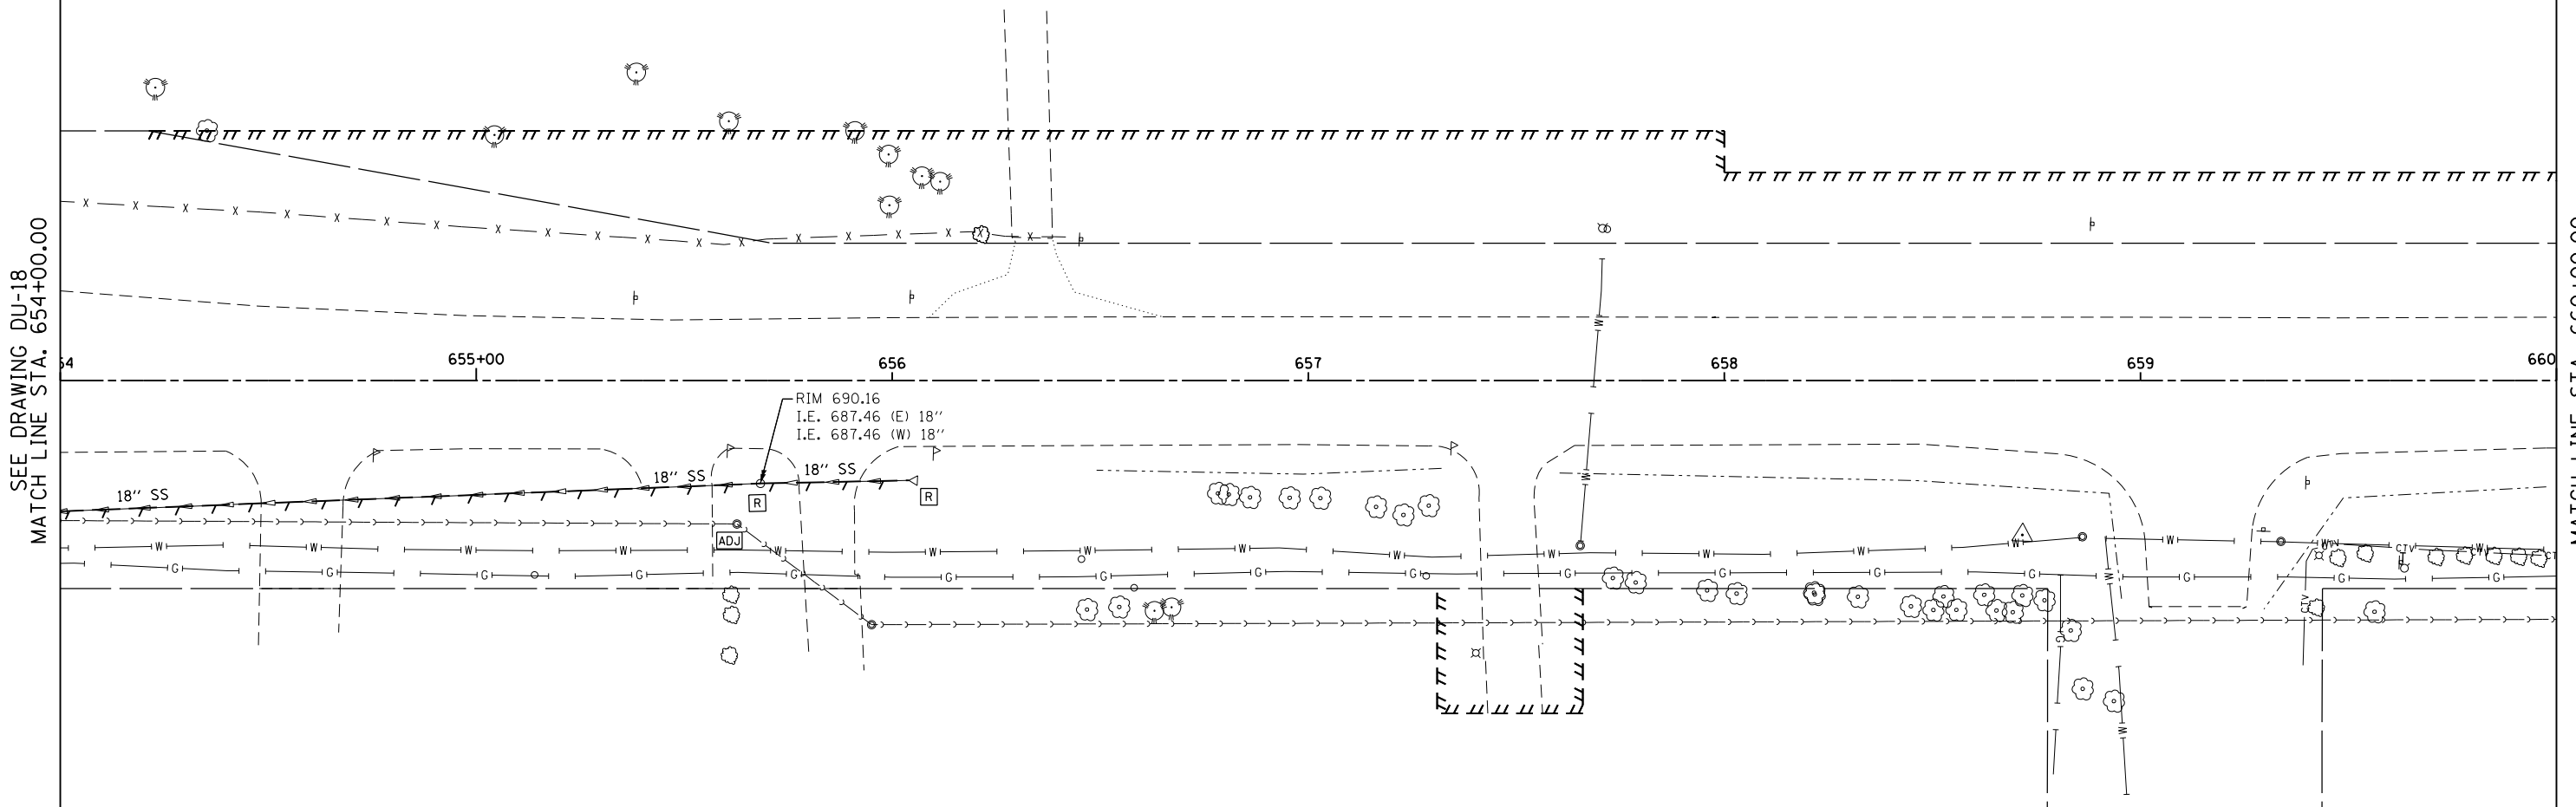

SEE DRAWING DU-18
 MATCH LINE STA. 654+00.00

MATCH LINE STA. 660+00.00
 SEE DRAWING DU-20

NOTE:
 1. SEE DRAWING DN-01 FOR DRAINAGE LEGEND AND NOTES.
 2. SEE DRAWINGS DS-01 THROUGH DS-07 FOR STRUCTURE AND PIPE INFORMATION



100 S. WACKER DR.
 SUITE 600
 CHICAGO, IL 60606
 TEL (312) 939-1000
 FAX (312) 939-4198



FILE NAME = D160M62-SHT-DRAINE19.dgn	USER NAME = Anthony.Plutz	DESIGNED - EJD	REVISED -
SHT_PLAN	PLOT SCALE = 48.000000' / in.	DRAWN - EJD	REVISED -
	PLOT DATE = 3/13/2013	CHECKED - JWM	REVISED -
		DATE - 03/13/13	REVISED -

STATE OF ILLINOIS
 DEPARTMENT OF TRANSPORTATION

EXISTING DRAINAGE PLAN - 135TH STREET

SCALE: 1"=20' SHEET 2 OF 3 SHEETS STA. 654+00.00 TO STA. 660+00.00

F.A.P. RTE.	SECTION	COUNTY	TOTAL SHEETS	SHEET NO.
330	103R-5	COOK	778	174
DU-19			CONTRACT NO. 60M62	
ILLINOIS FED. AID PROJECT				