 



SEE DRAWING DU-19
 MATCH LINE STA. 660+00.00

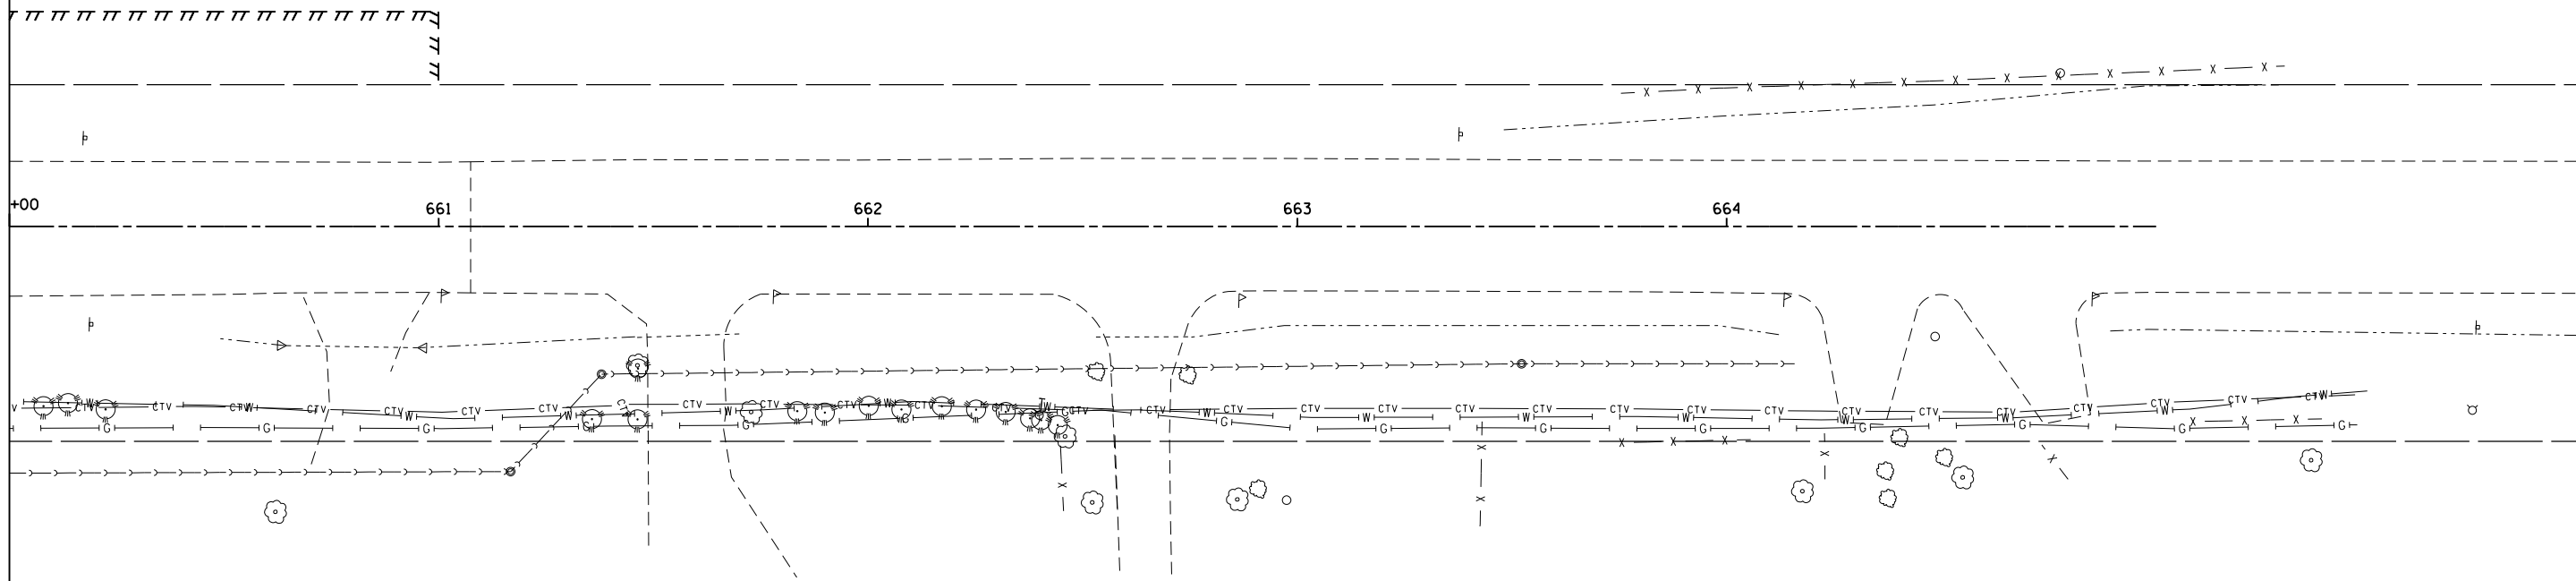

NOTE:
 1. SEE DRAWING DN-01 FOR DRAINAGE LEGEND AND NOTES.
 2. SEE DRAWINGS DS-01 THROUGH DS-07 FOR STRUCTURE AND PIPE INFORMATION

FILE NAME =	USER NAME = Anthony.Plutz
D160M62-SHT-DRAINE.X20.dgn	
SHT.PLAN	

DESIGNED - EJD	REVISD -
DRAWN - EJD	REVISD -
CHECKED - JWM	REVISD -
DATE - 03/13/13	REVISD -

PLOT SCALE = 40.000000' / in.	
PLOT DATE = 3/13/2013	

**STATE OF ILLINOIS
 DEPARTMENT OF TRANSPORTATION**

EXISTING DRAINAGE PLAN - 135TH STREET

SCALE: 1"=20' SHEET 3 OF 3 SHEETS STA. 660+00.00 TO STA. END

F.A.P. RTE.	SECTION	COUNTY	TOTAL SHEETS	SHEET NO.
330	103R-5	COOK	778	175
DU-20			CONTRACT NO. 60M62	
ILLINOIS FED. AID PROJECT				