 



MANHOLES TO BE ADJUSTED  
 STA 23+40.8, 43.5' RT  
 STA 26+50.3, 26.8' RT



SEE DRAWING DU-22  
 MATCH LINE STA. 22+00.00

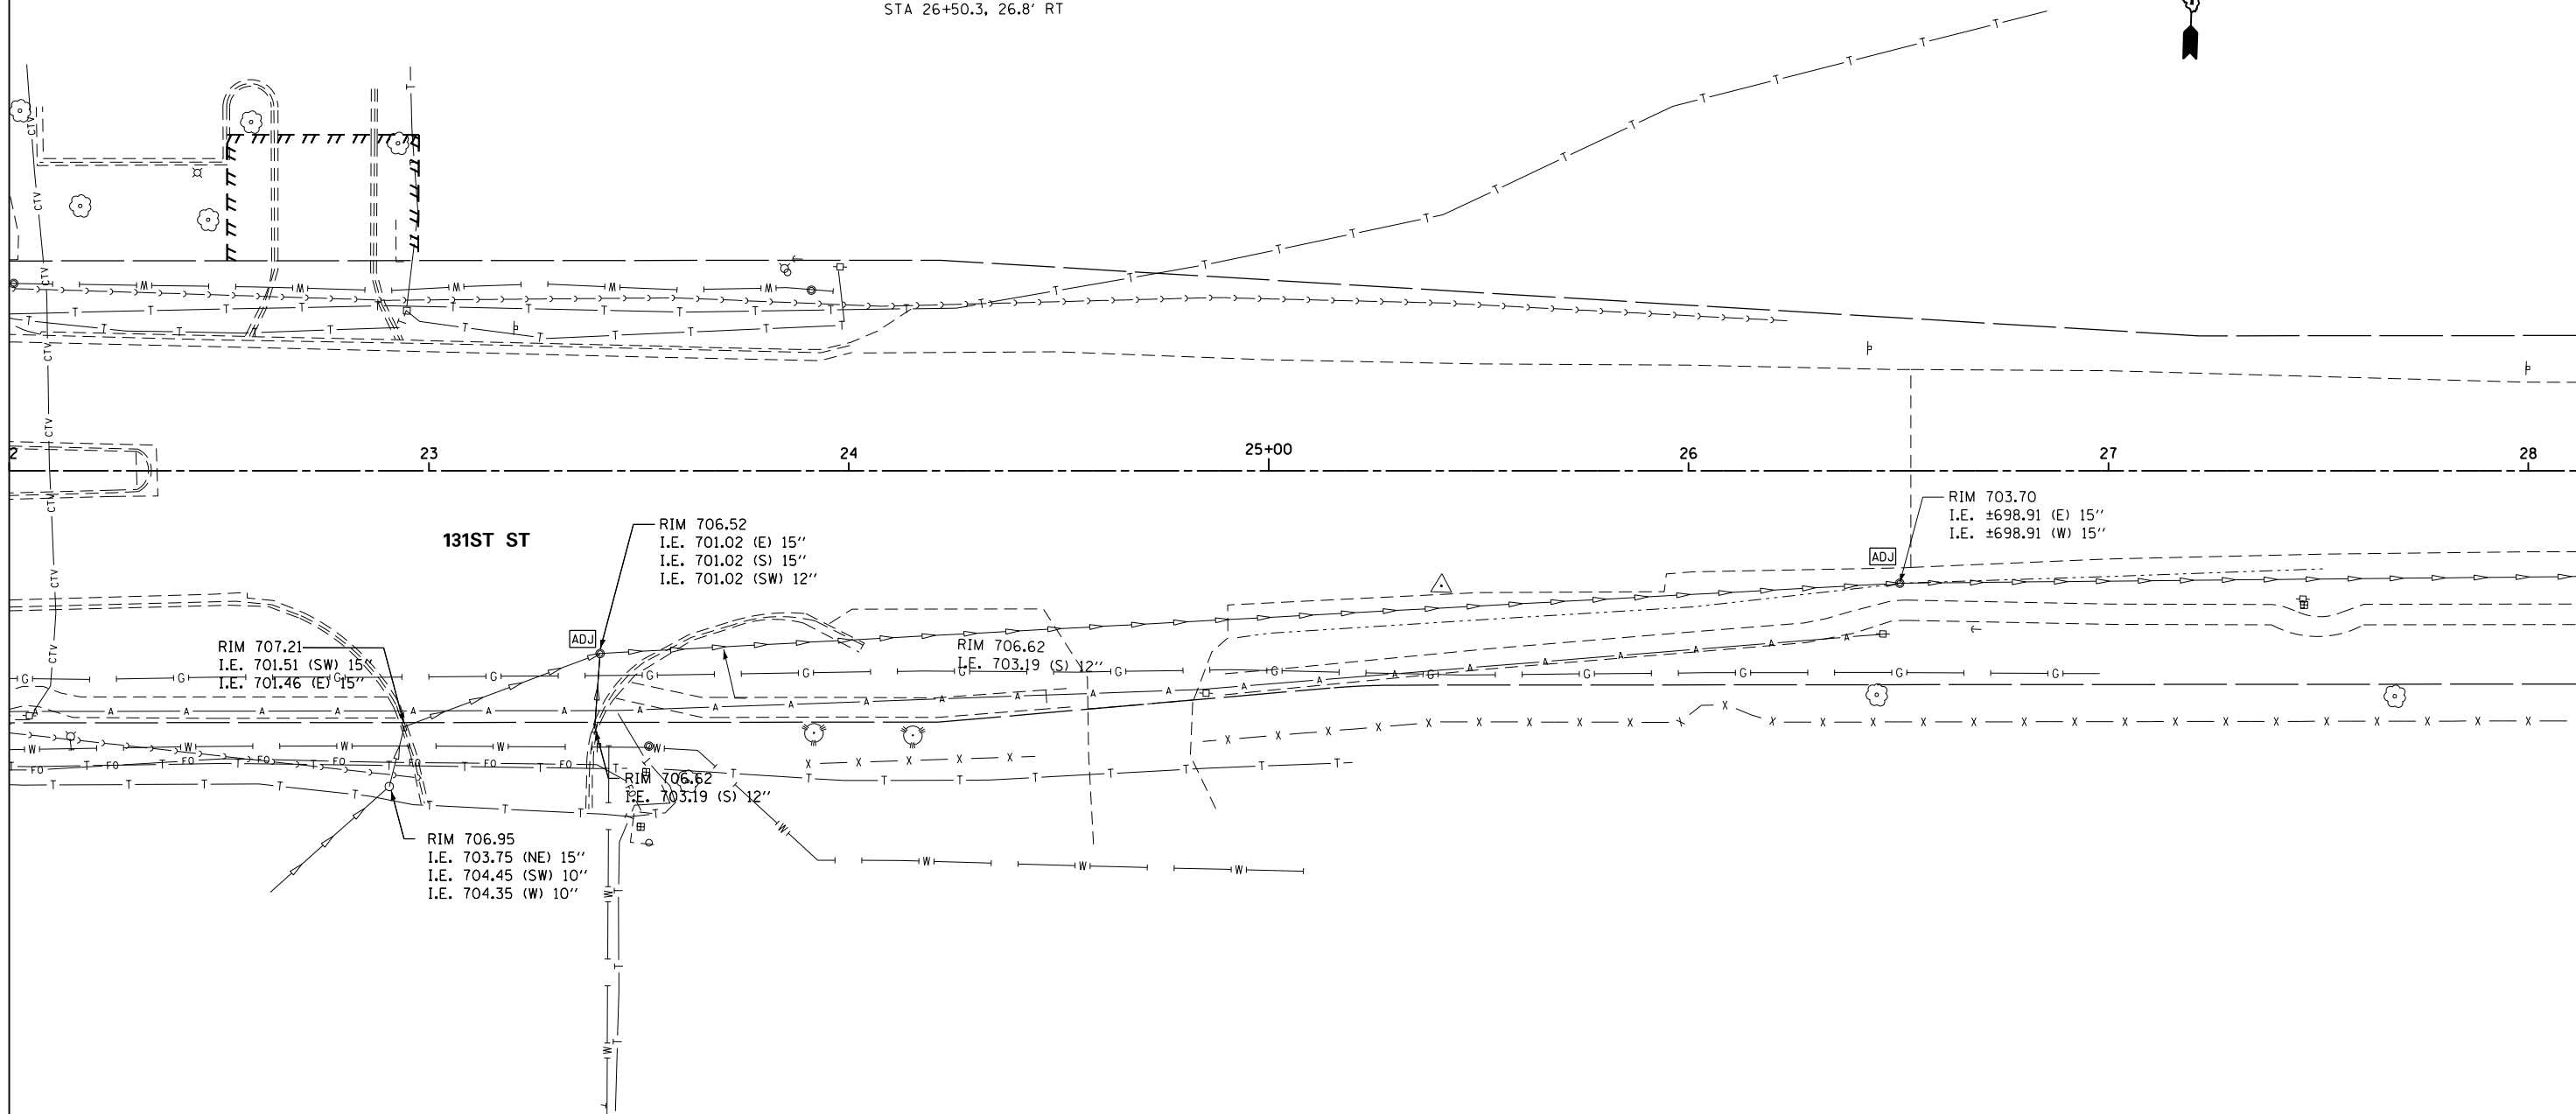

NOTE:  
 1. SEE DRAWING DN-01 FOR DRAINAGE LEGEND AND NOTES.  
 2. SEE DRAWINGS DS-01 THROUGH DS-07 FOR STRUCTURE AND PIPE INFORMATION

URS  
 100 S. WACKER DR.  
 SUITE 600  
 CHICAGO, IL 60606  
 TEL (312) 939-1000  
 FAX (312) 939-4998

FILE NAME = D:\6062-SHT-DRAINE\X23.dgn	USER NAME = Anthony.Plutz	DESIGNED - EJD	REVISED -
SHT_PLAN	PLOT SCALE = 48.000000' / in.	DRAWN - EJD	REVISED -
	PLOT DATE = 3/13/2013	CHECKED - JWM	REVISED -
		DATE - 03/13/13	REVISED -

STATE OF ILLINOIS  
 DEPARTMENT OF TRANSPORTATION

EXISTING DRAINAGE PLAN - 131ST STREET

SCALE: 1"=20' SHEET 3 OF 3 SHEETS STA. 22+00.00 TO STA. END

F.A.P. RTE.	SECTION	COUNTY	TOTAL SHEETS	SHEET NO.
330	103R-5	COOK	778	178
DU-23			CONTRACT NO. 60M62	
ILLINOIS FED. AID PROJECT				