




MANHOLES TO BE ADJUSTED  
 STA 657+65.3, 39.7' RT  
 STA 658+86.1, 37.5' RT  
 STA 659+33.8, 38.7 RT

CATCH BASINS TO BE ADJUSTED  
 STA 655+68.31, 24.8' RT

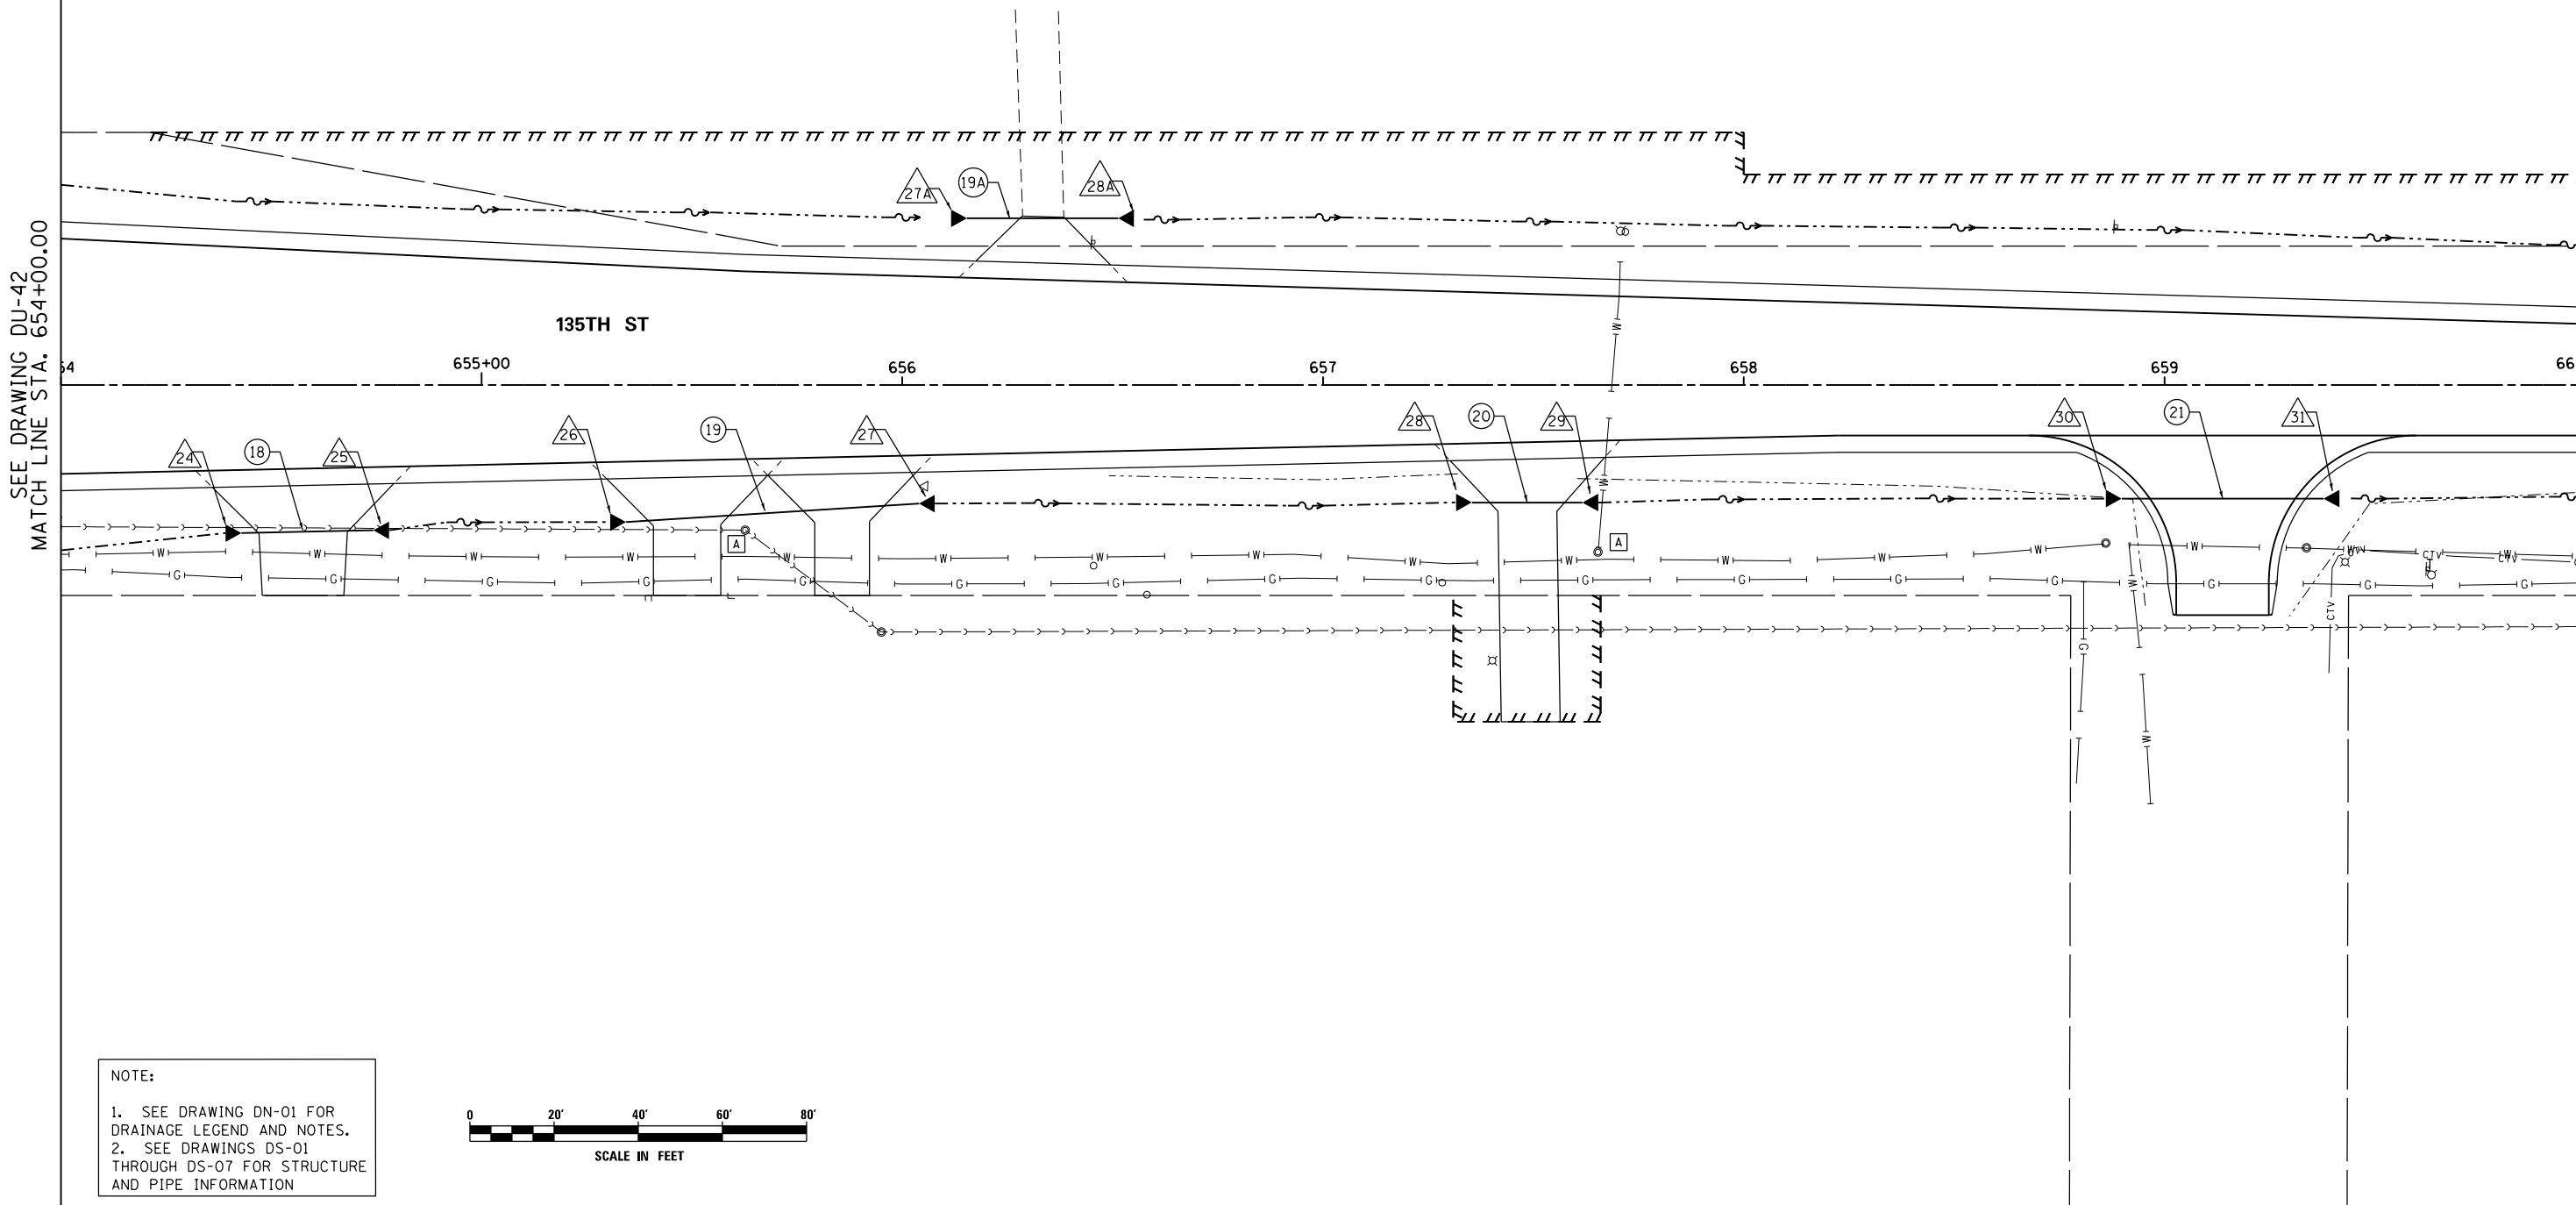

SEE DRAWING DU-42  
 MATCH LINE STA. 654+00.00

MATCH LINE STA. 660+00.00  
 SEE DRAWING DU-44

135TH ST

655+00

656

 
657

658

659

660

NOTE:  
 1. SEE DRAWING DN-01 FOR DRAINAGE LEGEND AND NOTES.  
 2. SEE DRAWINGS DS-01 THROUGH DS-07 FOR STRUCTURE AND PIPE INFORMATION



100 S. WACKER DR.  
 SUITE 600  
 CHICAGO, IL 60606  
 TEL (312) 939-1000  
 FAX (312) 939-4198



FILE NAME = D:\160M62-SHT-DRAINPR19.dgn  
 SHT\_PLAN

USER NAME = Anthony.Plutz  
 PLOT SCALE = 48.000000' / in.  
 PLOT DATE = 3/13/2013

DESIGNED - EJD  
 DRAWN - EJD  
 CHECKED - JWM  
 DATE - 03/13/13

REVISED -  
 REVISED -  
 REVISED -  
 REVISED -

STATE OF ILLINOIS  
 DEPARTMENT OF TRANSPORTATION

PROPOSED DRAINAGE PLAN - 135TH STREET

SCALE: 1"=20' SHEET 2 OF 3 SHEETS STA. 654+00.00 TO STA. 660+00.00

| F.A.P. RTE.               | SECTION | COUNTY | TOTAL SHEETS       | SHEET NO. |
|---------------------------|---------|--------|--------------------|-----------|
| 330                       | 103R-5  | COOK   | 778                | 198       |
| DU-43                     |         |        | CONTRACT NO. 60M62 |           |
| ILLINOIS FED. AID PROJECT |         |        |                    |           |