



PLAN	SURVEYED	DATE
	PLOTTED	
	NOTE BOOK	
	NO.	
	CHECKED	
	FILE NAME	

PROFILE	SURVEYED	DATE
	PLOTTED	
	NOTE BOOK	
	NO.	
	CHECKED	
	FILE NAME	

100 S. WACKER DR.  
SUITE 500  
CHICAGO, IL 60606  
TEL (312) 339-4000  
FAX (312) 339-4098



SEE SHEET WT-02 FOR NOTES (6) TO (11)

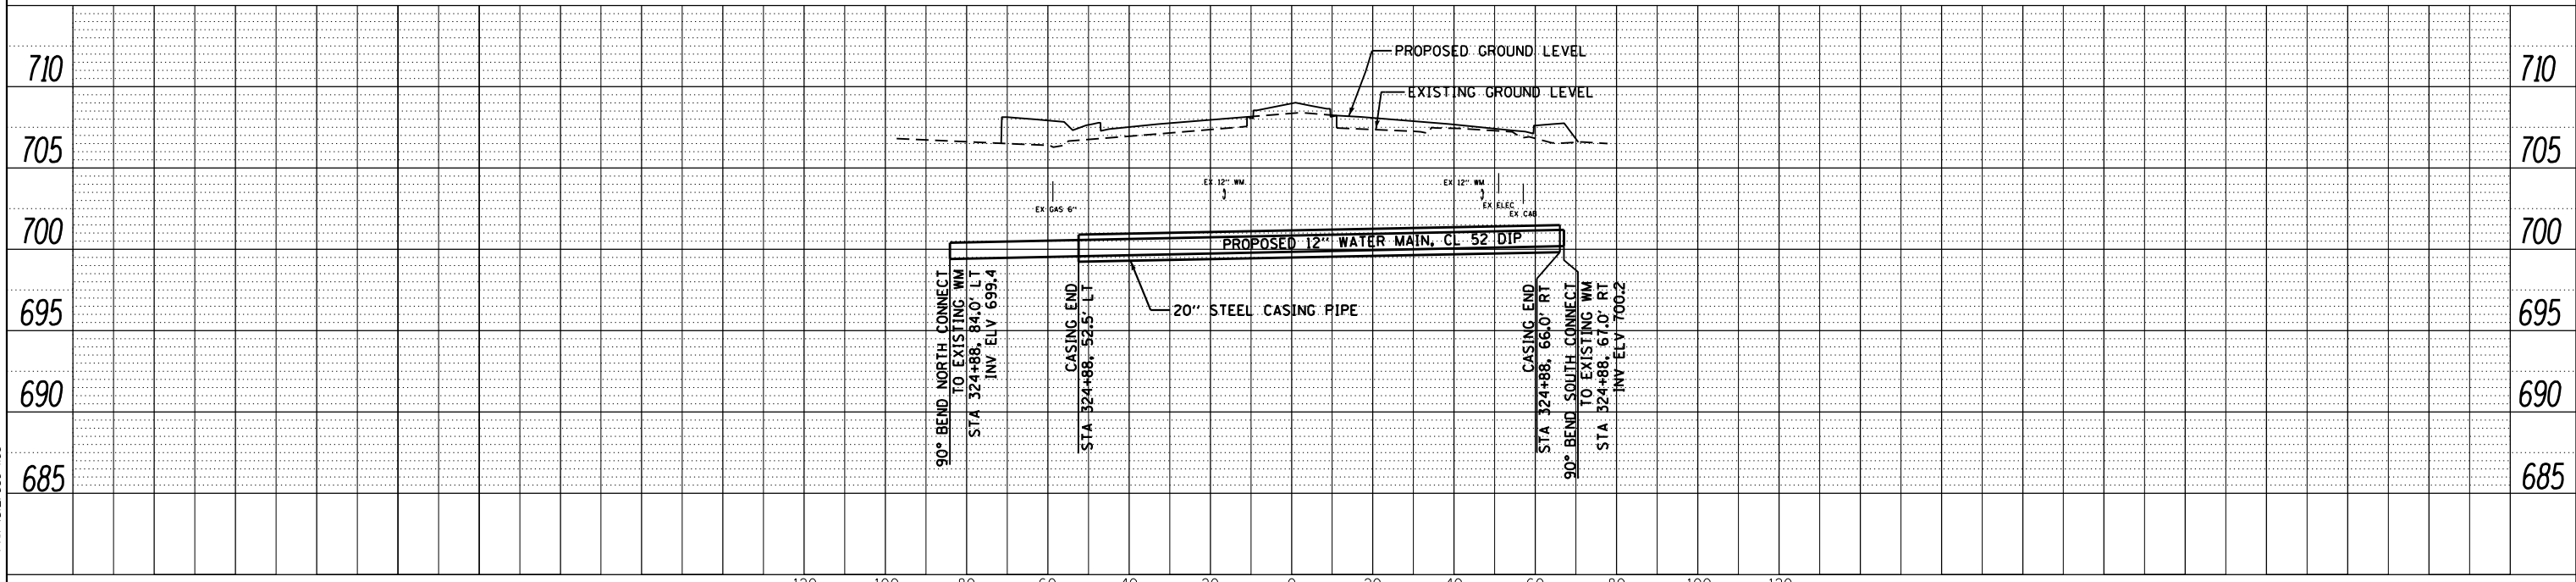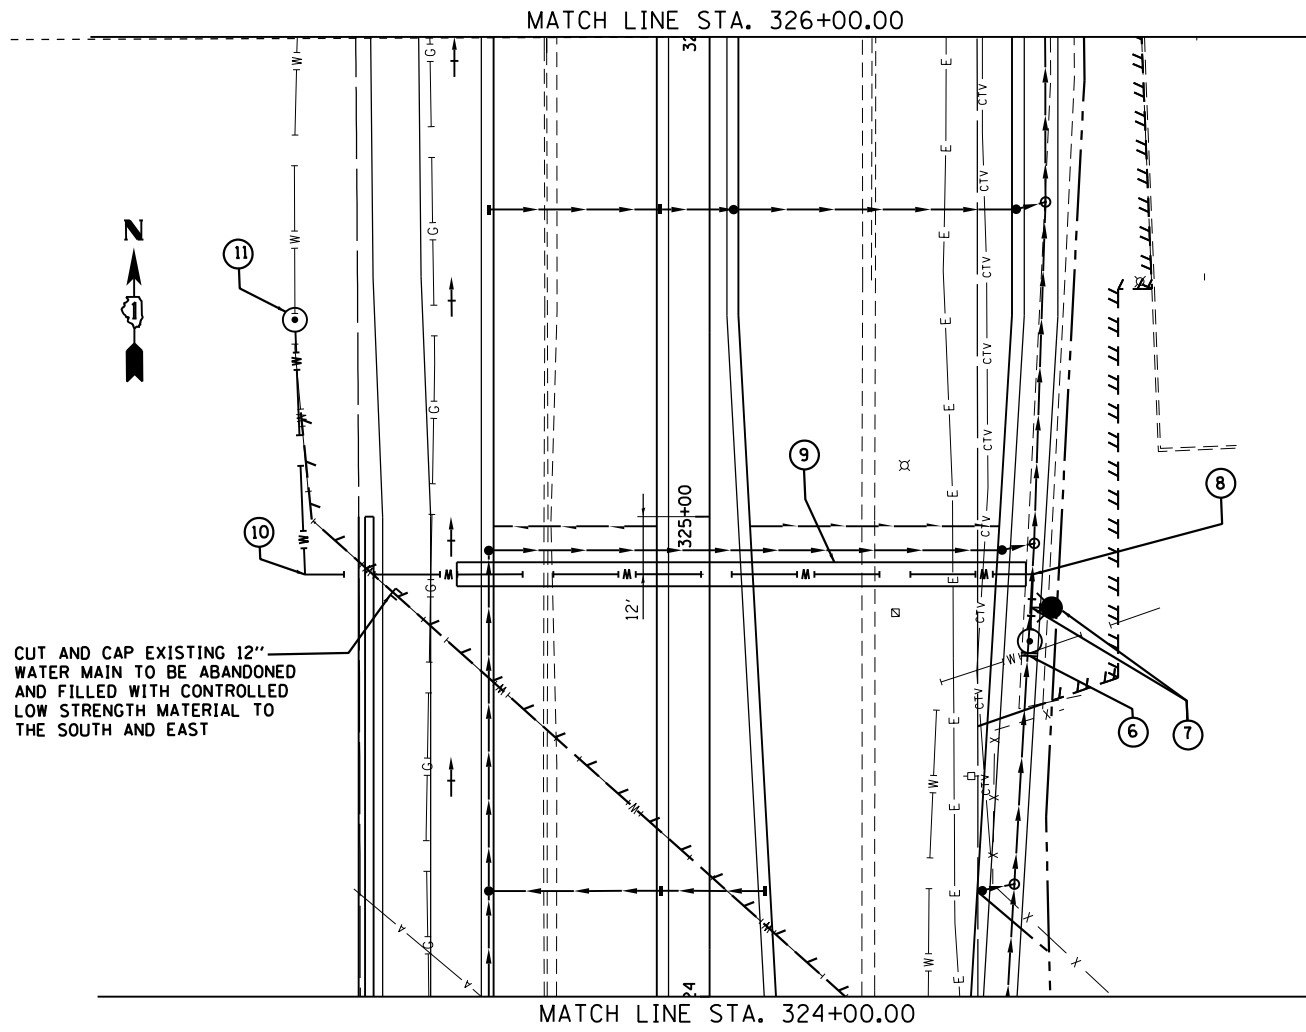

FILE NAME =	USER NAME = Frank.Stallone	DESIGNED - MDB	REVISIED -	<b>STATE OF ILLINOIS</b> <b>DEPARTMENT OF TRANSPORTATION</b>	<b>WATER MAIN - PROPOSED PLAN AND PROFILE</b> <b>US 45 (LAGRANGE ROAD)</b>	F.A.P. RTE.	SECTION	COUNTY	TOTAL SHEETS	SHEET NO.
D160M62-SHT-WATER03.dgn		DRAWN - MDB	REVISIED -			330	103R-5	COOK	778	232
PLOT SCALE = 40.000000' / in.		CHECKED - TDW	REVISIED -			WT-03		CONTRACT NO. 60M62		
PLOT DATE = 3/15/2013		DATE - 03/13/13	REVISIED -			SCALES: 1"=40'H; 1"=5'V		SHEET 3 OF 8 SHEETS		STA. 324+00.00 TO STA. 326+00.00

ILLINOIS FED. AID PROJECT