



- NOTES:**
- SEE DRAWING E-1 FOR ELECTRICAL SYMBOL LIST AND ABBREVIATIONS. SEE DRAWING E-2 FOR ELECTRICAL GENERAL NOTES.
  - SEE DRAWING E-49 FOR PROPOSED PIER/ABUTMENT UNDERPASS LIGHTING UNIT INSTALLATION DETAILS. FURNISH AND INSTALL 6"x6"x4" JUNCTION BOXES AS SHOWN ABOVE UNDERPASS LIGHTING FIXTURES ON TOP OF ABUTMENT WALL OR PIER.
  - FURNISH AND INSTALL 12"x10"x6" JUNCTION BOXES ON TOP OF ABUTMENT WALL OR PIER AT STATIONS GIVEN. ALIGN JUNCTION BOX WITH FACE OF ABUTMENT WALL OR PIER.
  - FURNISH AND INSTALL 24"x24"x8" JUNCTION BOXES ON FACE OF ABUTMENT WALL AT STATION GIVEN. MOUNT JUNCTION BOX 1'-0" BELOW TOP OF WALL.
  - FURNISH AND INSTALL REQUIRED STAINLESS STEEL MOUNTING HARDWARE FOR UNDERPASS LIGHTING FIXTURES AND JUNCTION BOXES PER IDOT STANDARD SPECIFICATIONS.

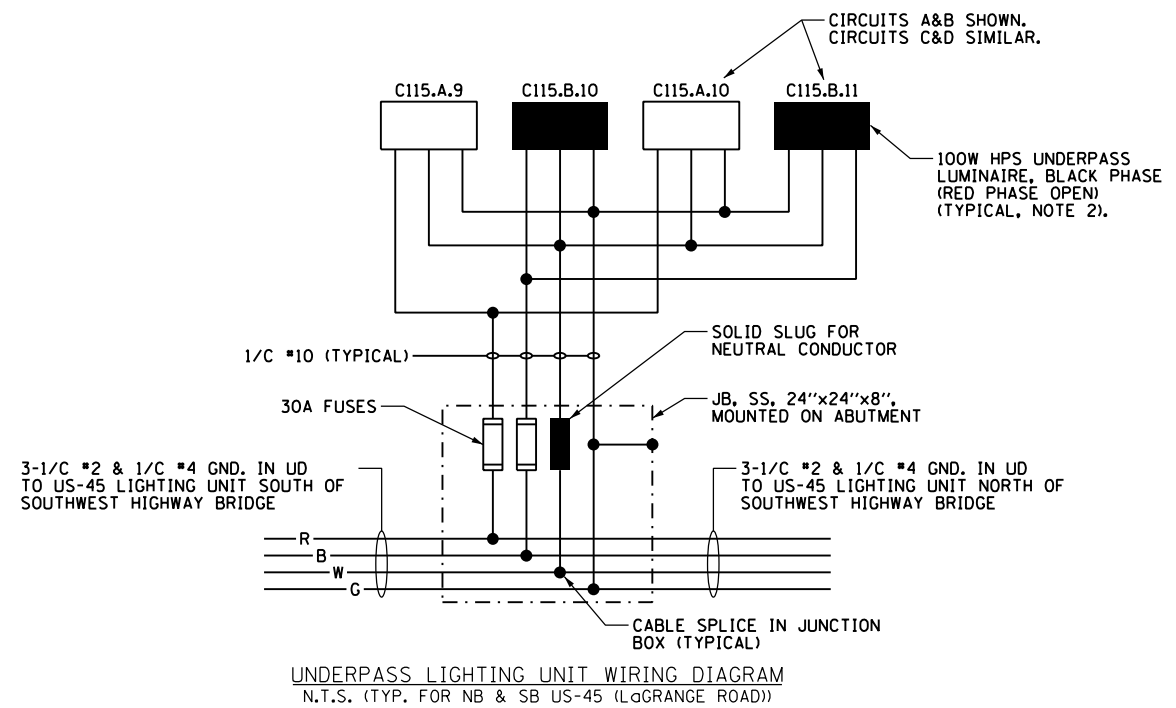

UNDERPASS FIXTURE NUMBER	UNDERPASS FIXTURE LOCATION (NOTE 2)	
	STATION	CL OFFSET
C115.C.10	294+69	62.5 LT
C115.D.8	294+99	62.5 LT
C115.D.9	295+41	1.6 LT
C115.A.10	295+45	1.5 RT
C115.C.9	295+72	1.5 LT
C115.B.10	295+75	1.6 RT
C115.B.11	296+17	62.5 RT
C115.A.9	296+44	62.5 RT

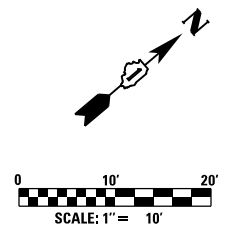

100 S. WACKER DR.  
 100 S/WITE CND  
 CHICAGO, IL 60606  
 TEL (312) 939-1000  
 FAX (312) 939-4998

**URS**

FILE NAME = D160M62-SHT-E10.dgn	USER NAME = Anthony.Plutz	DESIGNED - MAE	REVISED -
		DRAWN - WM	REVISED -
		CHECKED - DAD	REVISED -
SHT.PLAN	PLOT DATE = 3/13/2013	DATE - 03/13/13	REVISED -

**STATE OF ILLINOIS  
DEPARTMENT OF TRANSPORTATION**

**UNDERPASS LIGHTING PLAN  
SOUTHWEST HIGHWAY BRIDGE**

SCALE: 1" = 10' SHEET 1 OF 1 SHEETS STA. 164+23 TO STA. 167+50

F.A.P. RTE.	SECTION	COUNTY	TOTAL SHEETS	SHEET NO.
330	103R-5	COOK	778	334
<b>E-10</b>			CONTRACT NO. 60M62	
ILLINOIS FED. AID PROJECT				