


**NOTE:**  
 THE GENERAL CONTRACTOR IS REQUIRED TO HIRE AN ENVIRONMENTAL FIRM WITH AT LEAST FIVE (5) DOCUMENTED LEAKING UNDERGROUND STORAGE TANK CLEANUPS OR THAT IS PRE-QUALIFIED IN HAZARDOUS WASTE BY THE DEPARTMENT TO REMEDIATE THE SOIL CONTAMINATION AND MONITOR FOR WORKER PROTECTION.

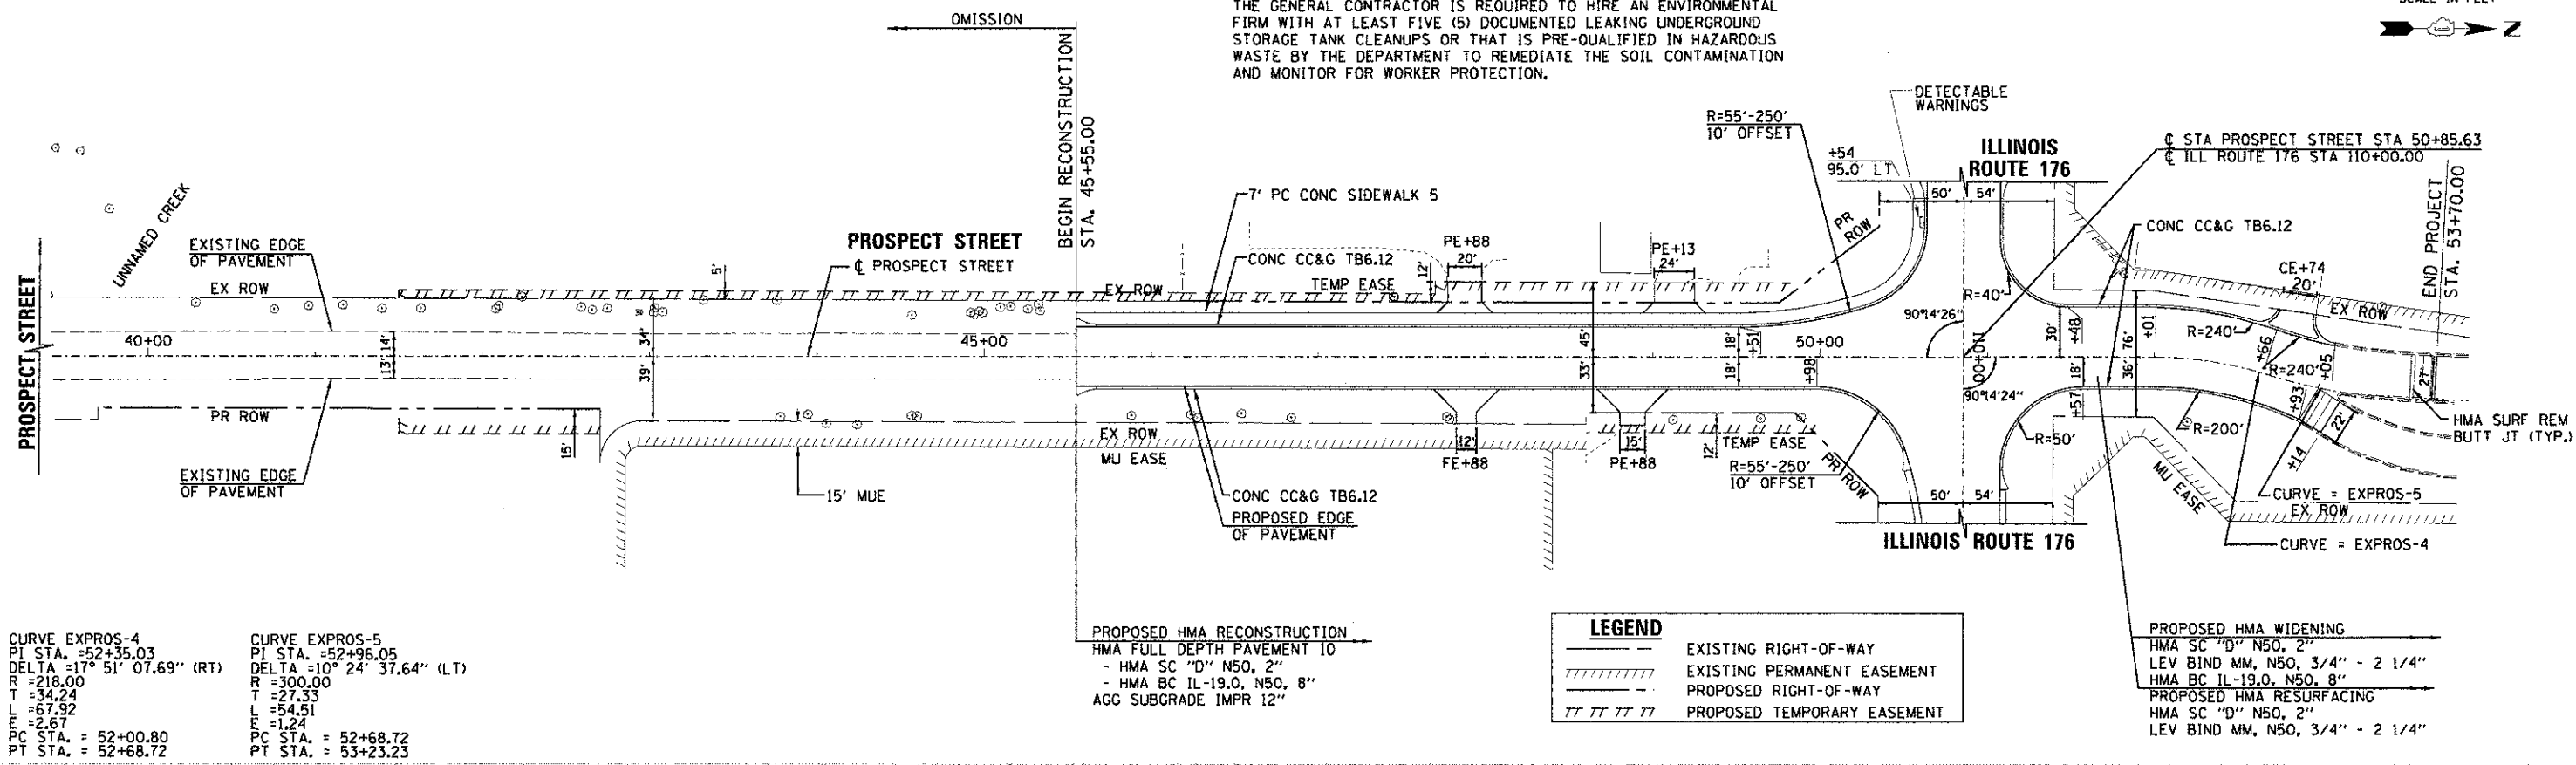

**CURVE EXPROS-4**  
 PI STA. = 52+35.03  
 DELTA = 17° 51' 07.69" (RT)  
 R = 218.00  
 T = 34.24  
 L = 67.92  
 E = 2.67  
 PC STA. = 52+00.80  
 PT STA. = 52+68.72


**CURVE EXPROS-5**  
 PI STA. = 52+96.05  
 DELTA = 10° 24' 37.64" (LT)  
 R = 300.00  
 T = 27.33  
 L = 54.51  
 E = 1.24  
 PC STA. = 52+68.72  
 PT STA. = 53+23.23

**PROPOSED HMA RECONSTRUCTION**  
 HMA FULL DEPTH PAVEMENT 10"  
 - HMA SC "D" N50, 2"  
 - HMA BC IL-19.0, N50, 8"  
 AGG SUBGRADE IMPR 12"

**LEGEND**

- EXISTING RIGHT-OF-WAY
- EXISTING PERMANENT EASEMENT
- - - PROPOSED RIGHT-OF-WAY
- /// PROPOSED TEMPORARY EASEMENT

**PROPOSED HMA WIDENING**  
 HMA SC "D" N50, 2"  
 LEV BIND MM, N50, 3/4" - 2 1/4"  
 HMA BC IL-19.0, N50, 8"  
 PROPOSED HMA RESURFACING  
 HMA SC "D" N50, 2"  
 LEV BIND MM, N50, 3/4" - 2 1/4"

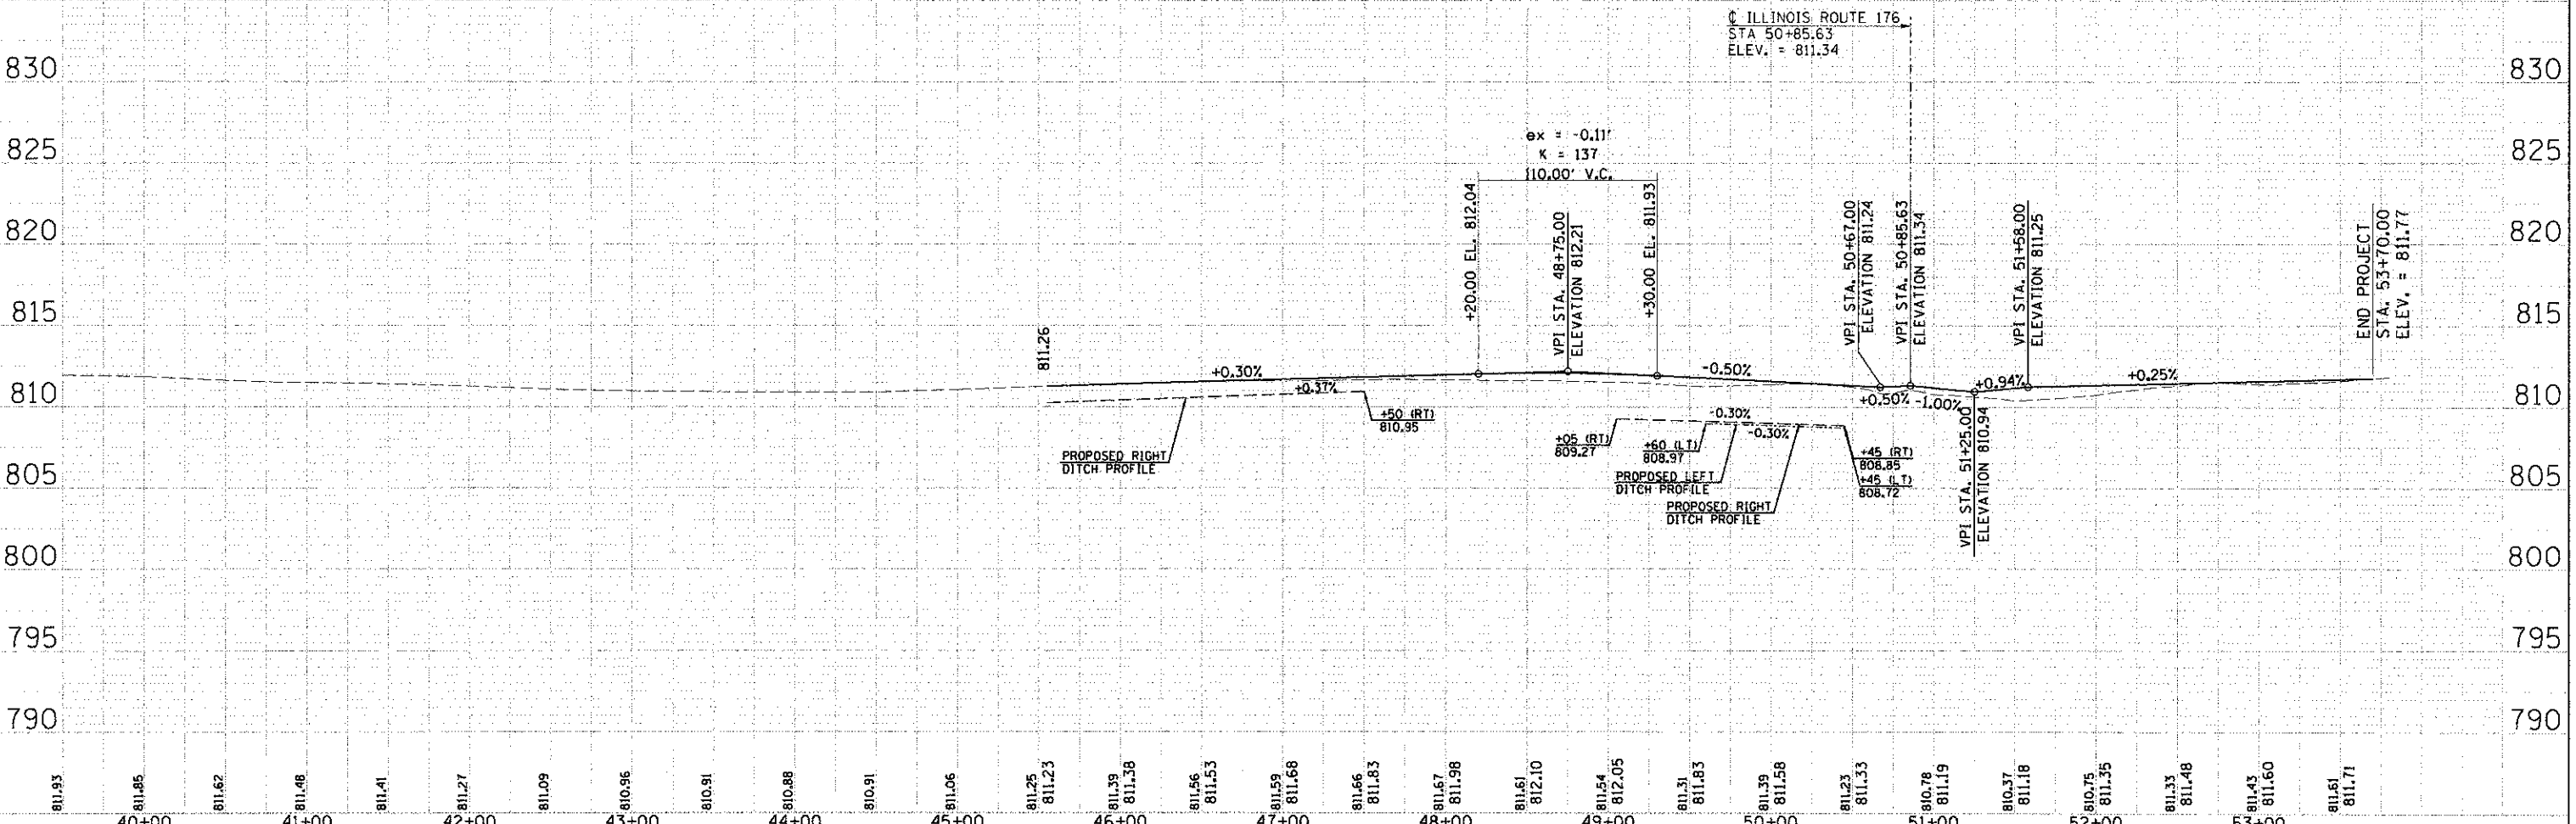

DATE	
BY	
PLAN	
NO. _____	
NO. _____	
NO. _____	
NO. _____	

DATE	
BY	
PROFILE	
NO. _____	
NO. _____	
NO. _____	
NO. _____	

COMPANY NAME: HRGreen.com  
 PROJECT CONTACT: [Name]  
 CLIENT: [Name]  
 DATE PLOTTED: 3/22/2013 10:23:44 AM  
 FILE NAME: 635\_0004\_Prospect.dwg  
 PLOT DRIVER: pldrvr  
 PEN TABLE: pens\_standard-trans - Copy.rtl

HRGreen.com Illinois Professional Design Firm # 184-001222	USER NAME = sparnal DESIGNED DCJ DRAWN SMP CHECKED - TEH DATE - 2/5/13	REVISED - REVISED - REVISED - REVISED -	<b>STATE OF ILLINOIS</b> <b>DEPARTMENT OF TRANSPORTATION</b>	<b>ROADWAY PLAN AND PROFILE</b> <b>PROSPECT STREET</b>	F.A.J.I. RTE. 40B7 SECTION 98-0024-00-WR COUNTY MCHENRY TOTAL SHEETS 115 SHEETS NO. 29 CONTRACT NO. 63532	SCALE: 1" = 50' SHEET NO. 4 OF 6 SHEETS STA. 41+60.00 TO STA. 53+70.00	FED. ROAD DIST. NO. ILLINOIS FED. AID PROJECT
--	--	--	---	---	--	--	---