
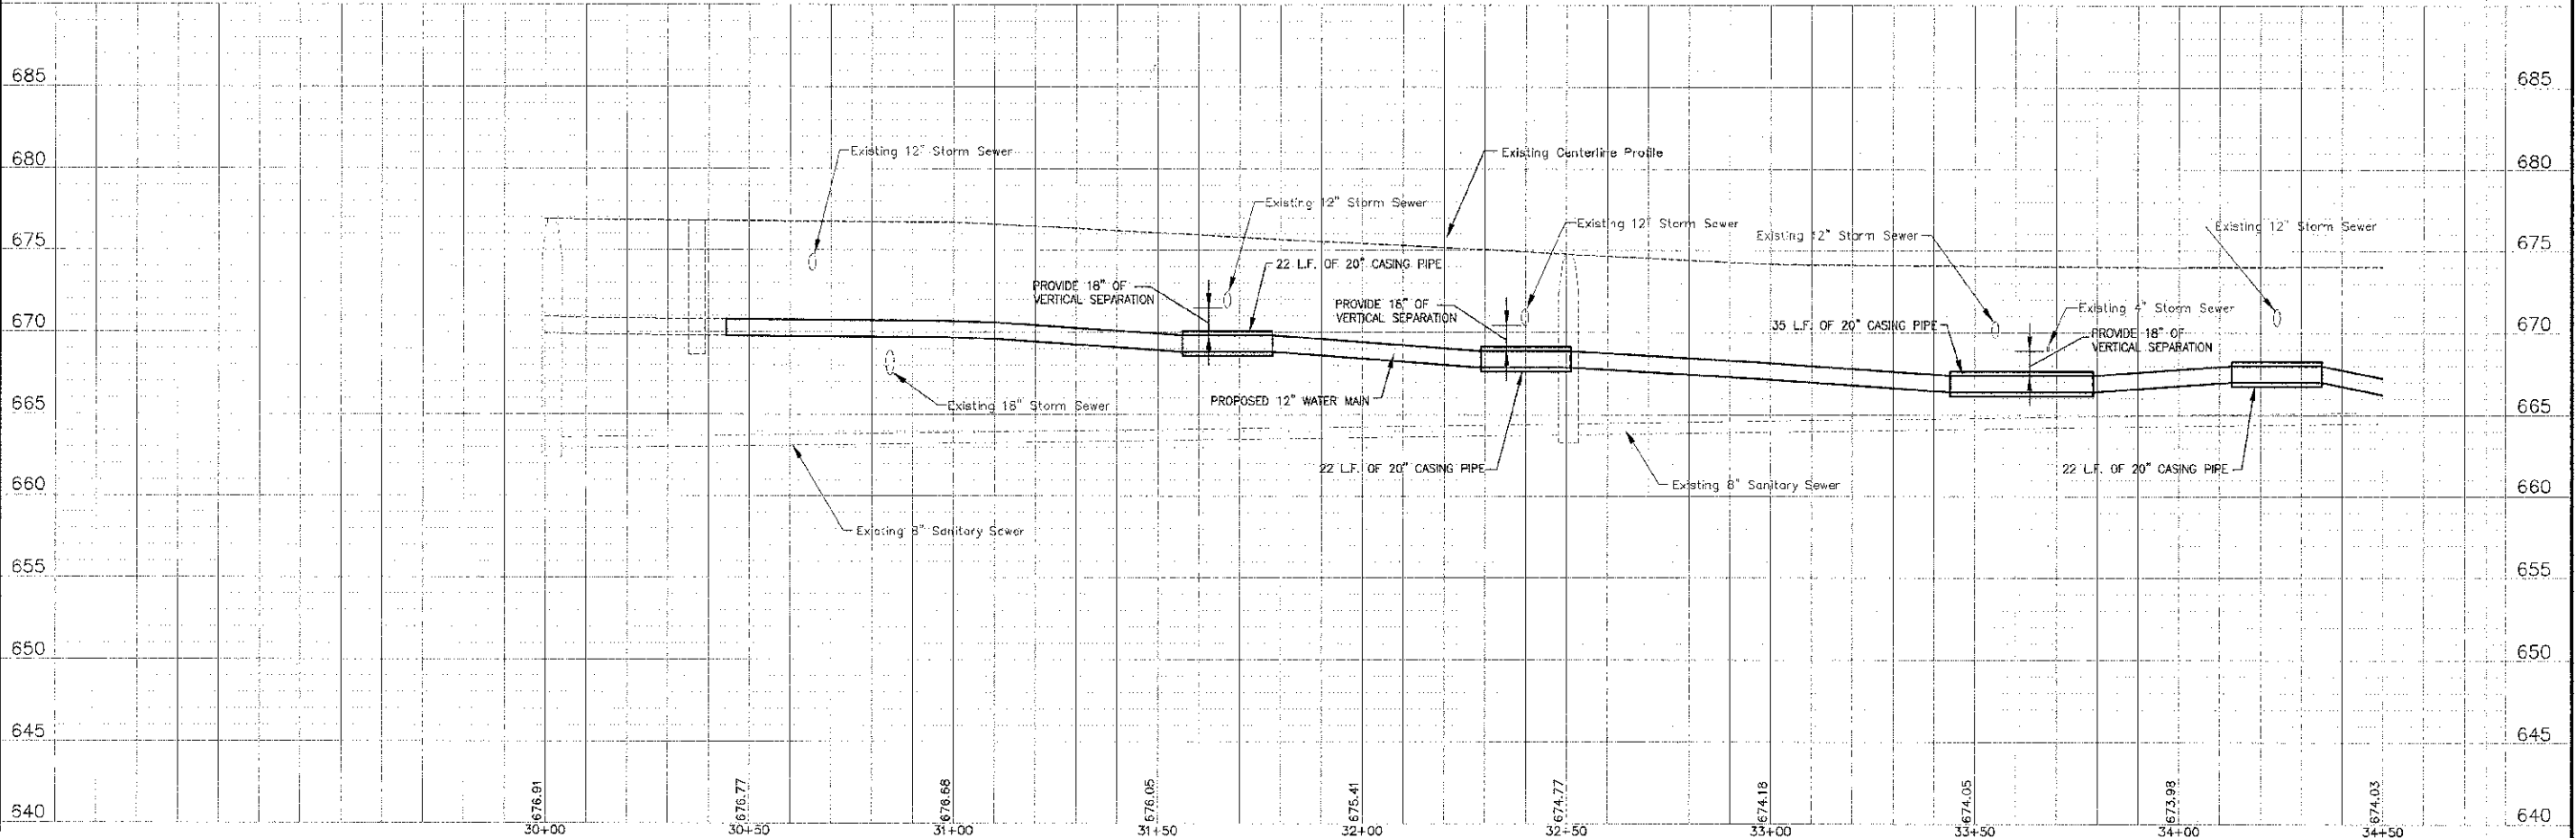


WATER MAIN FIRE HYDRANTS		
NO.	STATION	DESCRIPTION
WM-FH2	32+56	HYDRANT W/AUXILIARY VALVE W/6 LF OF ADDITIONAL LEADER PIPE (RJT)

WATER MAIN FITTINGS		
NO.	STATION	DESCRIPTION
WM-F22	30+77	12" D.I. 45° BEND
WM-F23	31+12	12" D.I. 45° BEND
WM-F24	32+56	12" X 5" TEE
WM-F25	33+94	12" X 8" TEE
WM-F26	33+94	6" D.I. 60° BEND
WM-F27	33+84	6" D.I. 50° BEND (NON-PRESSURE CONNECTION)

WATER MAIN PIPES		
NO.	LENGTH	DESCRIPTION
WM-P6	406 LF	12" D.I. RJT
WM-P7	19 LF	6" D.I. RJT

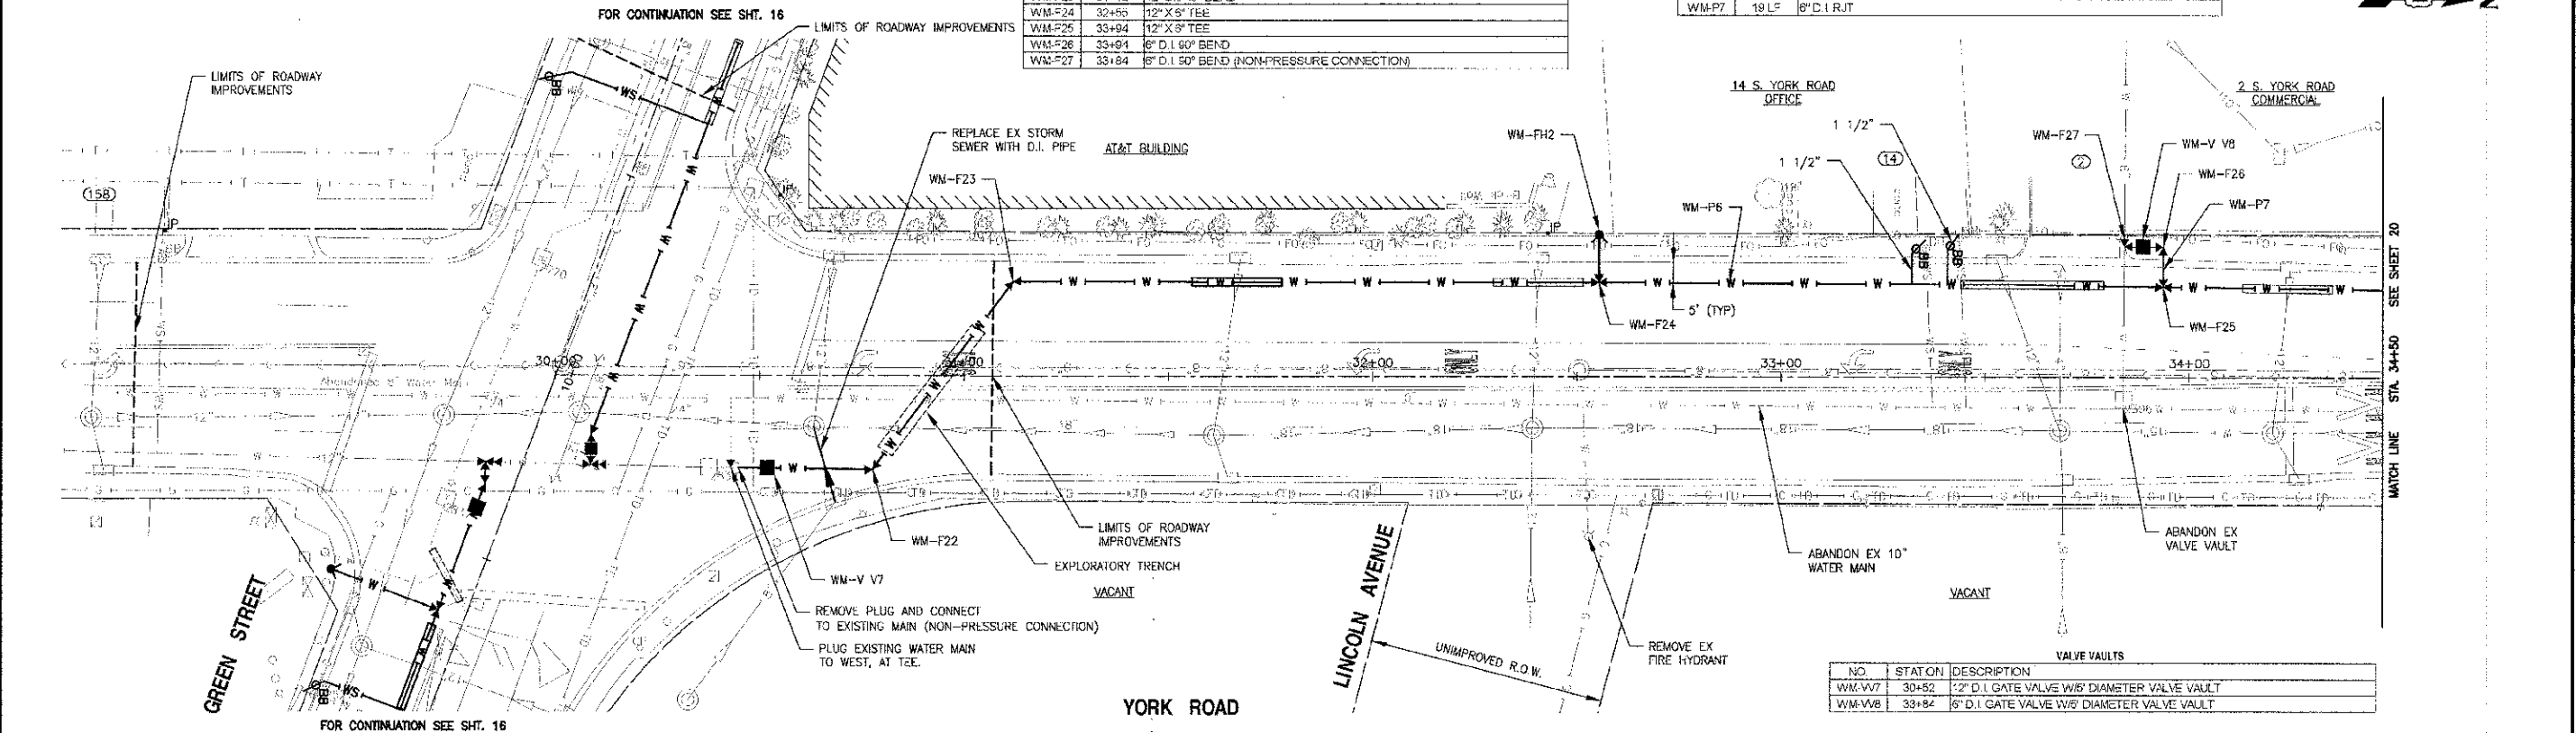

PROJECT: ILLINOIS STATE DEPARTMENT OF TRANSPORTATION, PROJECT NO. 1000561, STA. 30+00 TO STA. 34+50  
 DRAWN: MSB, CHECKED: LDH, DATE: 06-18-12  
 SCALE: 1" = 40' VERT.

	DESIGNED - ALP DRAWN - MSB CHECKED - LDH DATE - 06-18-12	REVISED - DC1 REVIEW 12-17-12 REVISED - REVISED - REVISED -	<b>STATE OF ILLINOIS</b> <b>DEPARTMENT OF TRANSPORTATION</b>	<b>WATER MAIN REPLACEMENT PLAN AND PROFILE</b> <b>YORK ROAD</b>	F.A.U. NO. 3553 SECTION 16-0067-00 RB COUNTY DUWAGE TOTAL SHEET NO. 37 OF 75 CONTRACT NO. 63759
--	---	--	---	--	---

SCALE: 1" = 40' VERT. PROJECT NO: 1000561 STA. 30+00 TO STA. 34+50